


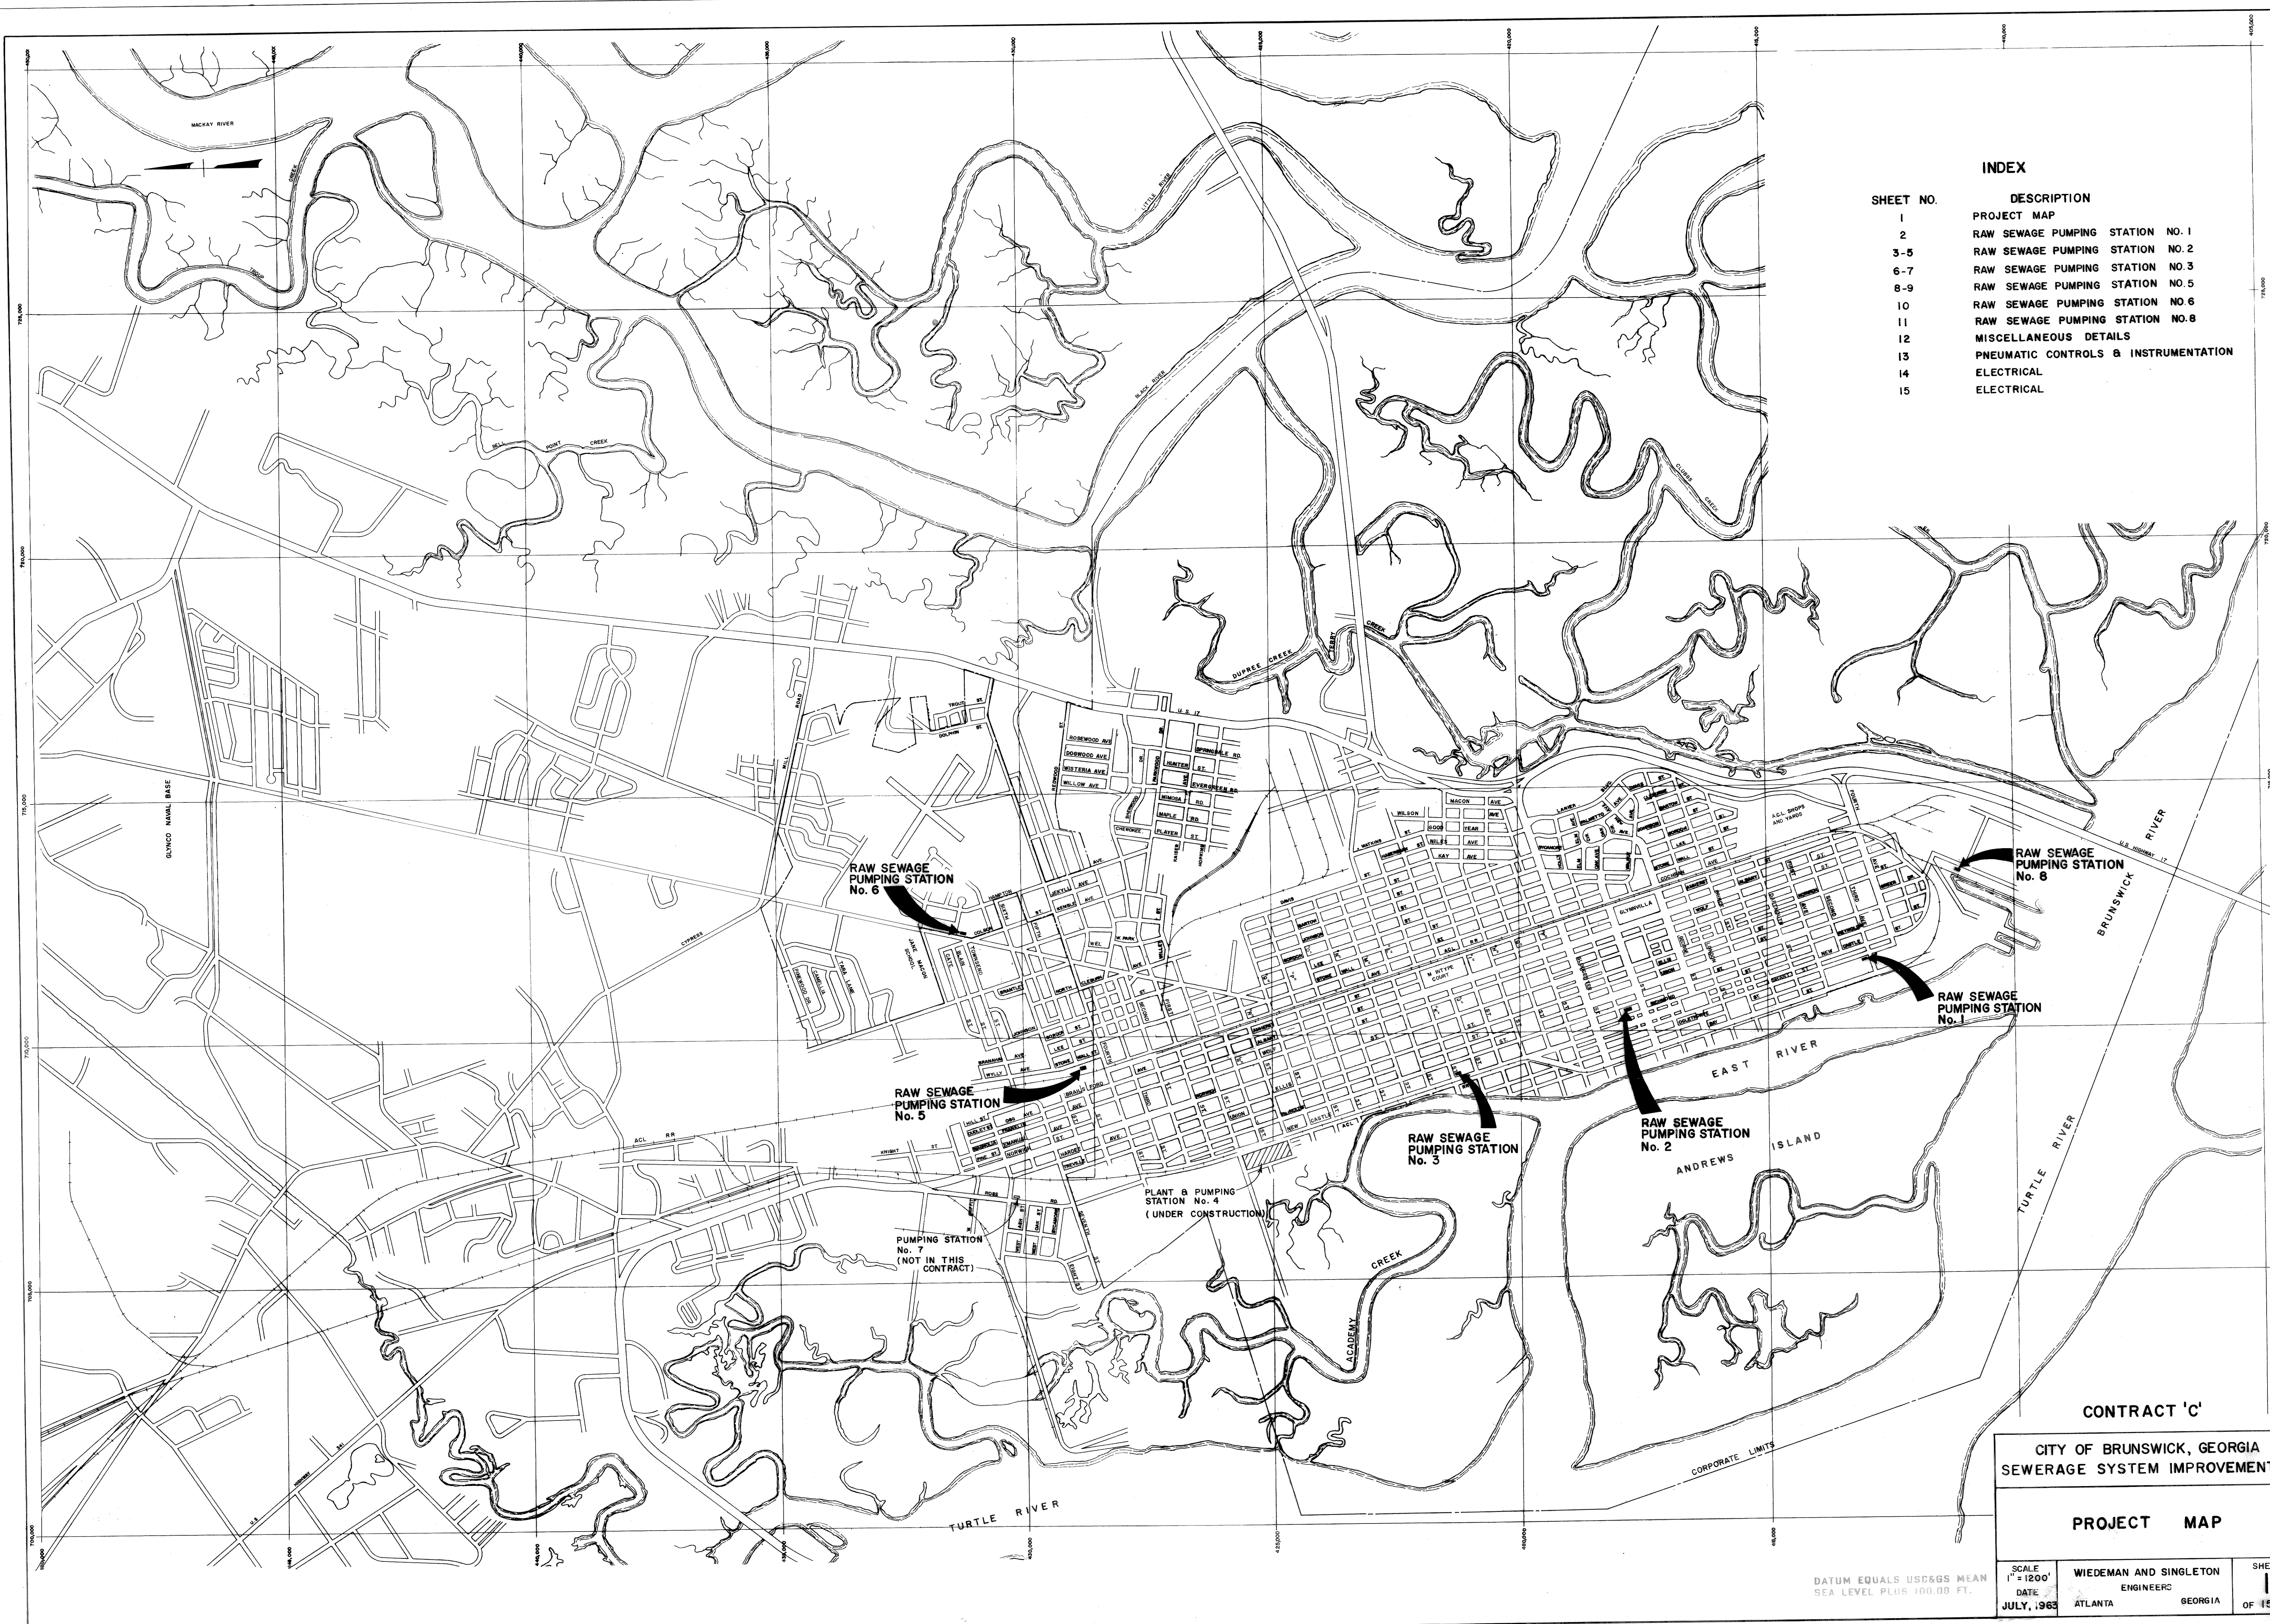

INDEX

SHEET NO.	DESCRIPTION
1	PROJECT MAP
2	RAW SEWAGE PUMPING STATION NO. 1
3-5	RAW SEWAGE PUMPING STATION NO. 2
6-7	RAW SEWAGE PUMPING STATION NO. 3
8-9	RAW SEWAGE PUMPING STATION NO. 5
10	RAW SEWAGE PUMPING STATION NO. 6
11	RAW SEWAGE PUMPING STATION NO. 8
12	MISCELLANEOUS DETAILS
13	PNEUMATIC CONTROLS & INSTRUMENTATION
14	ELECTRICAL
15	ELECTRICAL









CONTRACT 'C'

CITY OF BRUNSWICK, GEORGIA
SEWERAGE SYSTEM IMPROVEMENTS


PROJECT MAP

SCALE 1" = 1200'	WIEDEMAN AND SINGLETON ENGINEERS	SHEET 1
DATE JULY, 1965	ATLANTA GEORGIA	OF 15





DATUM EQUALS USCGS MEAN
SEA LEVEL PLUS 100.00 FT.

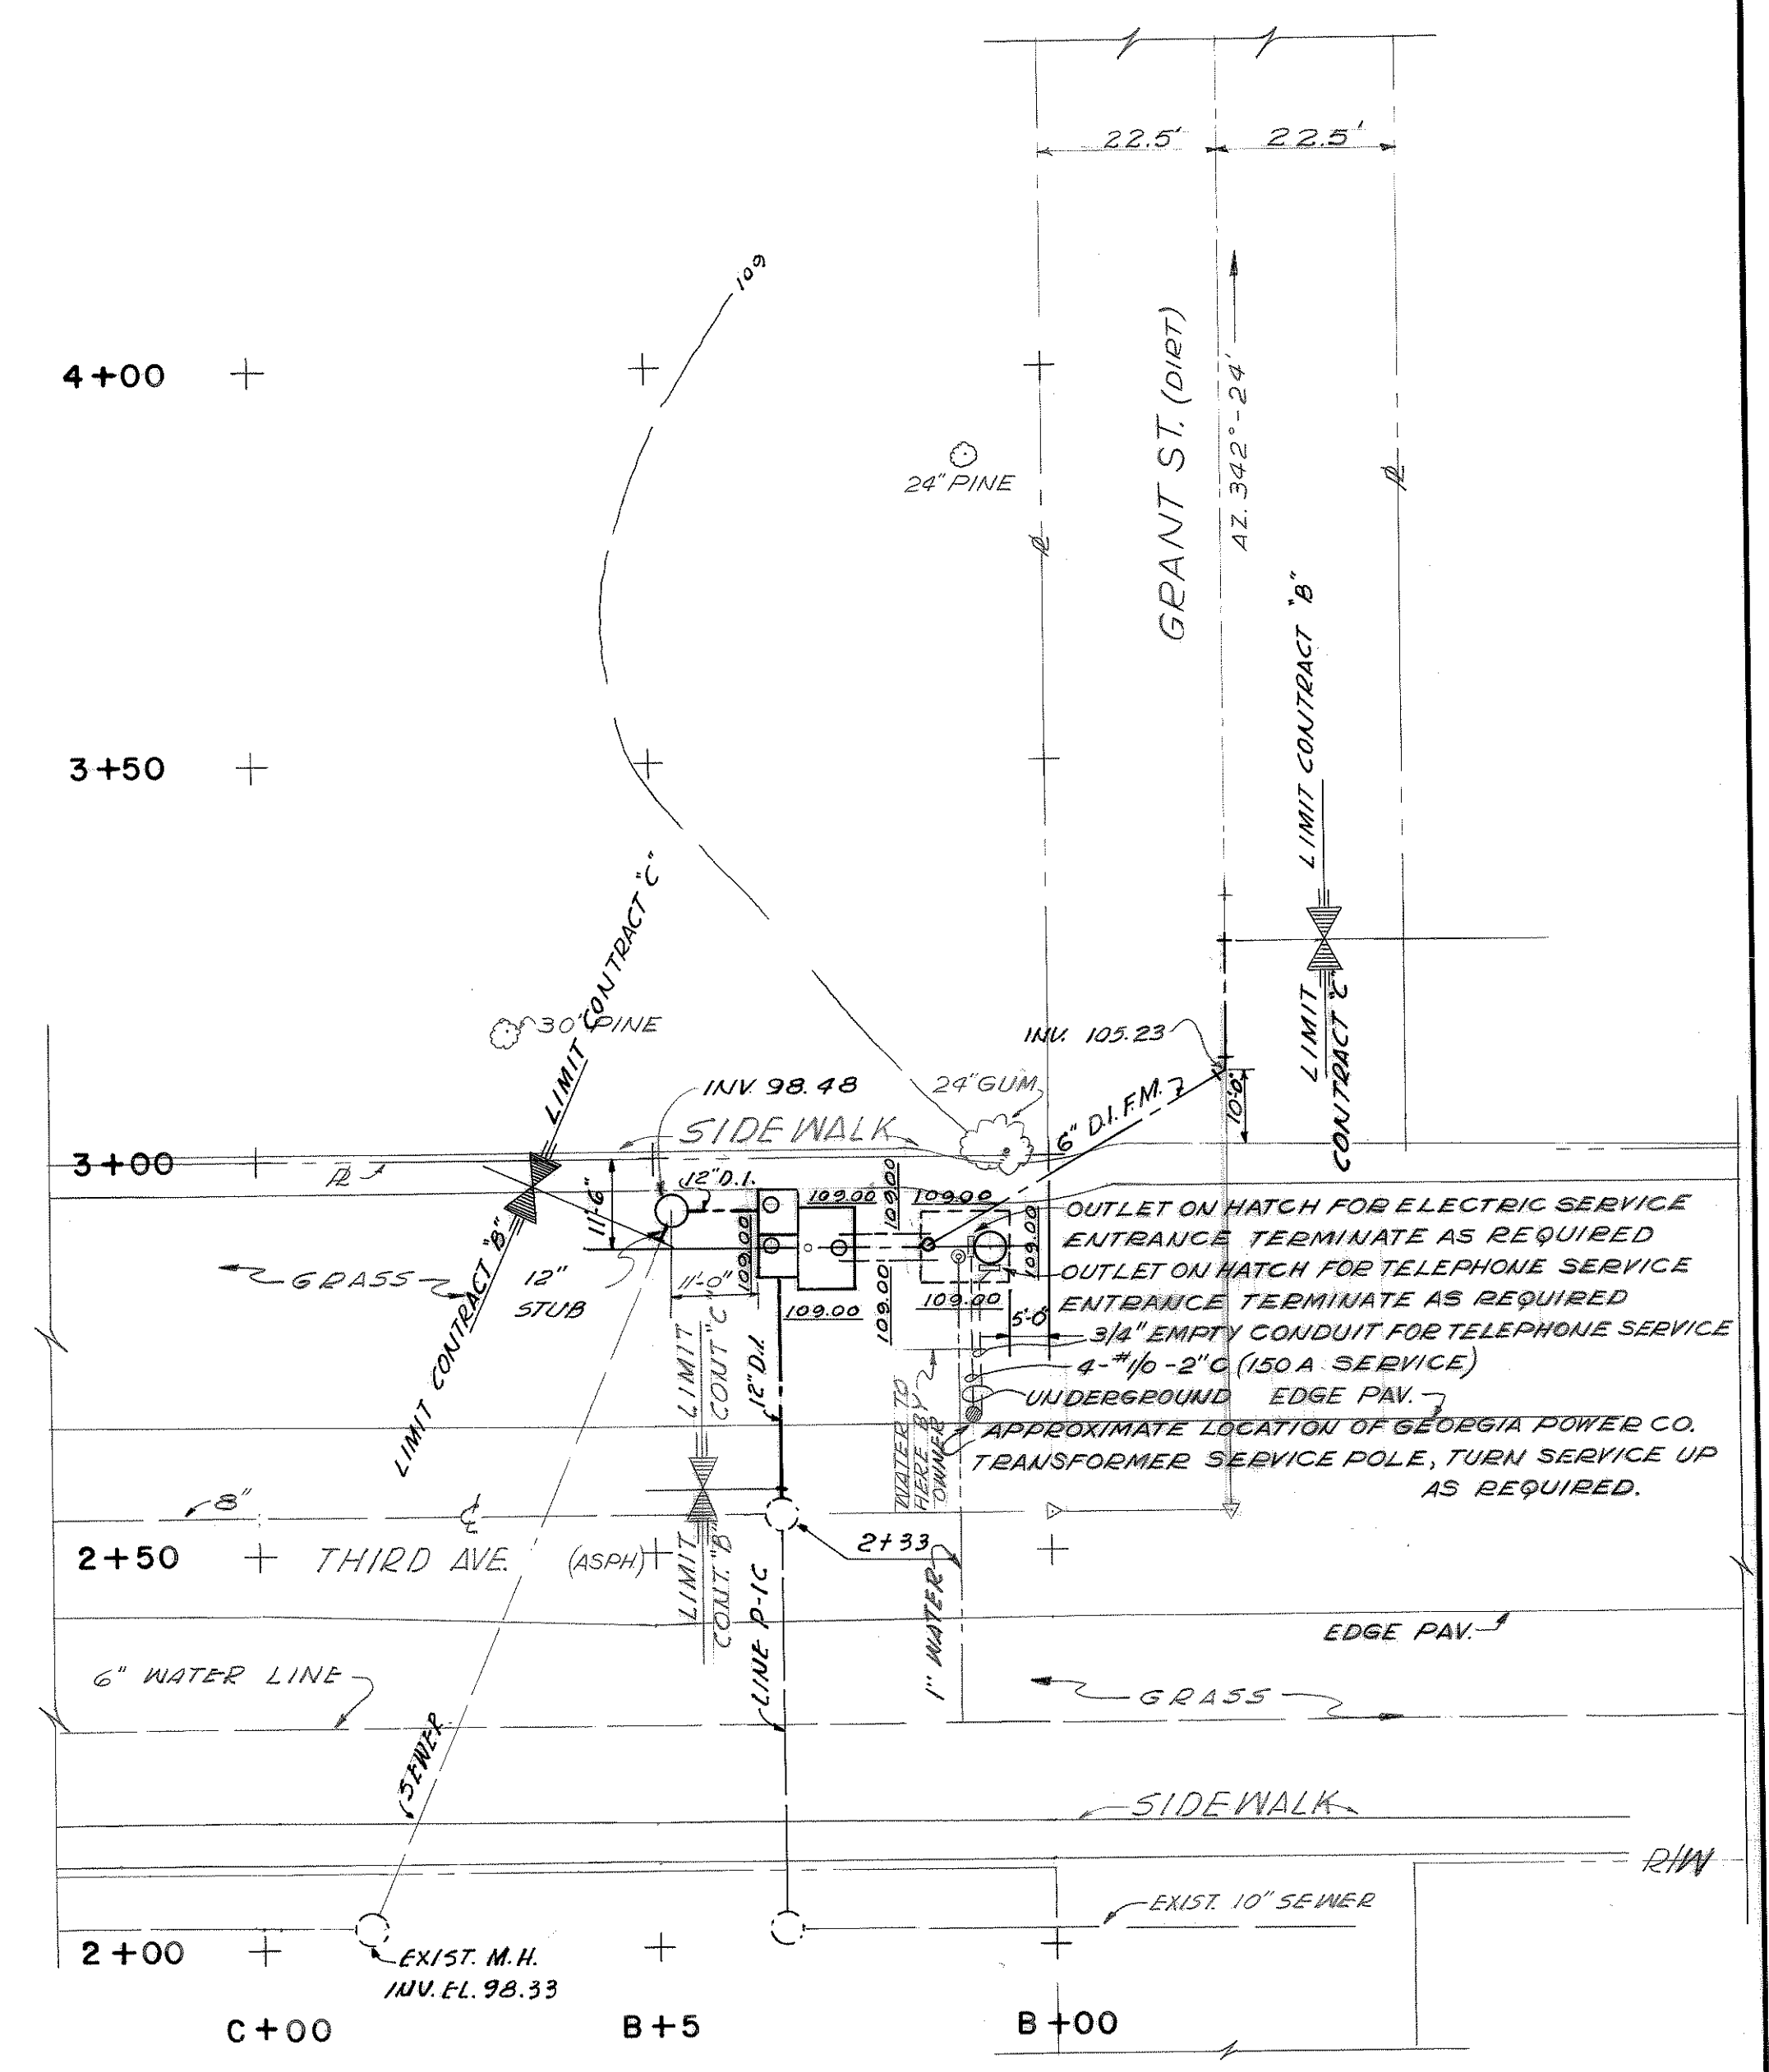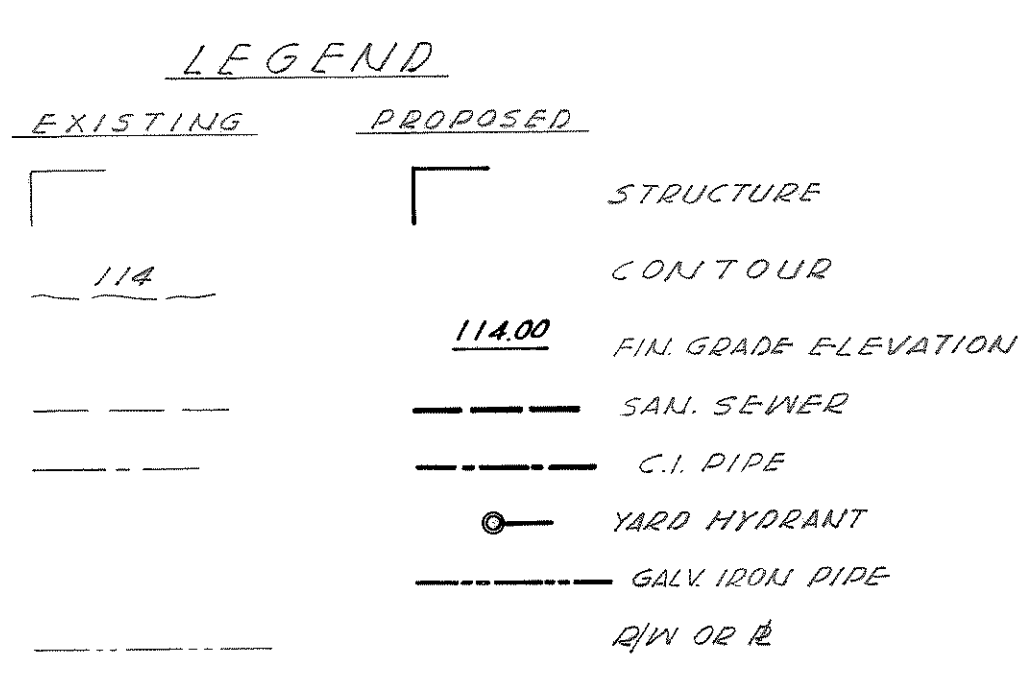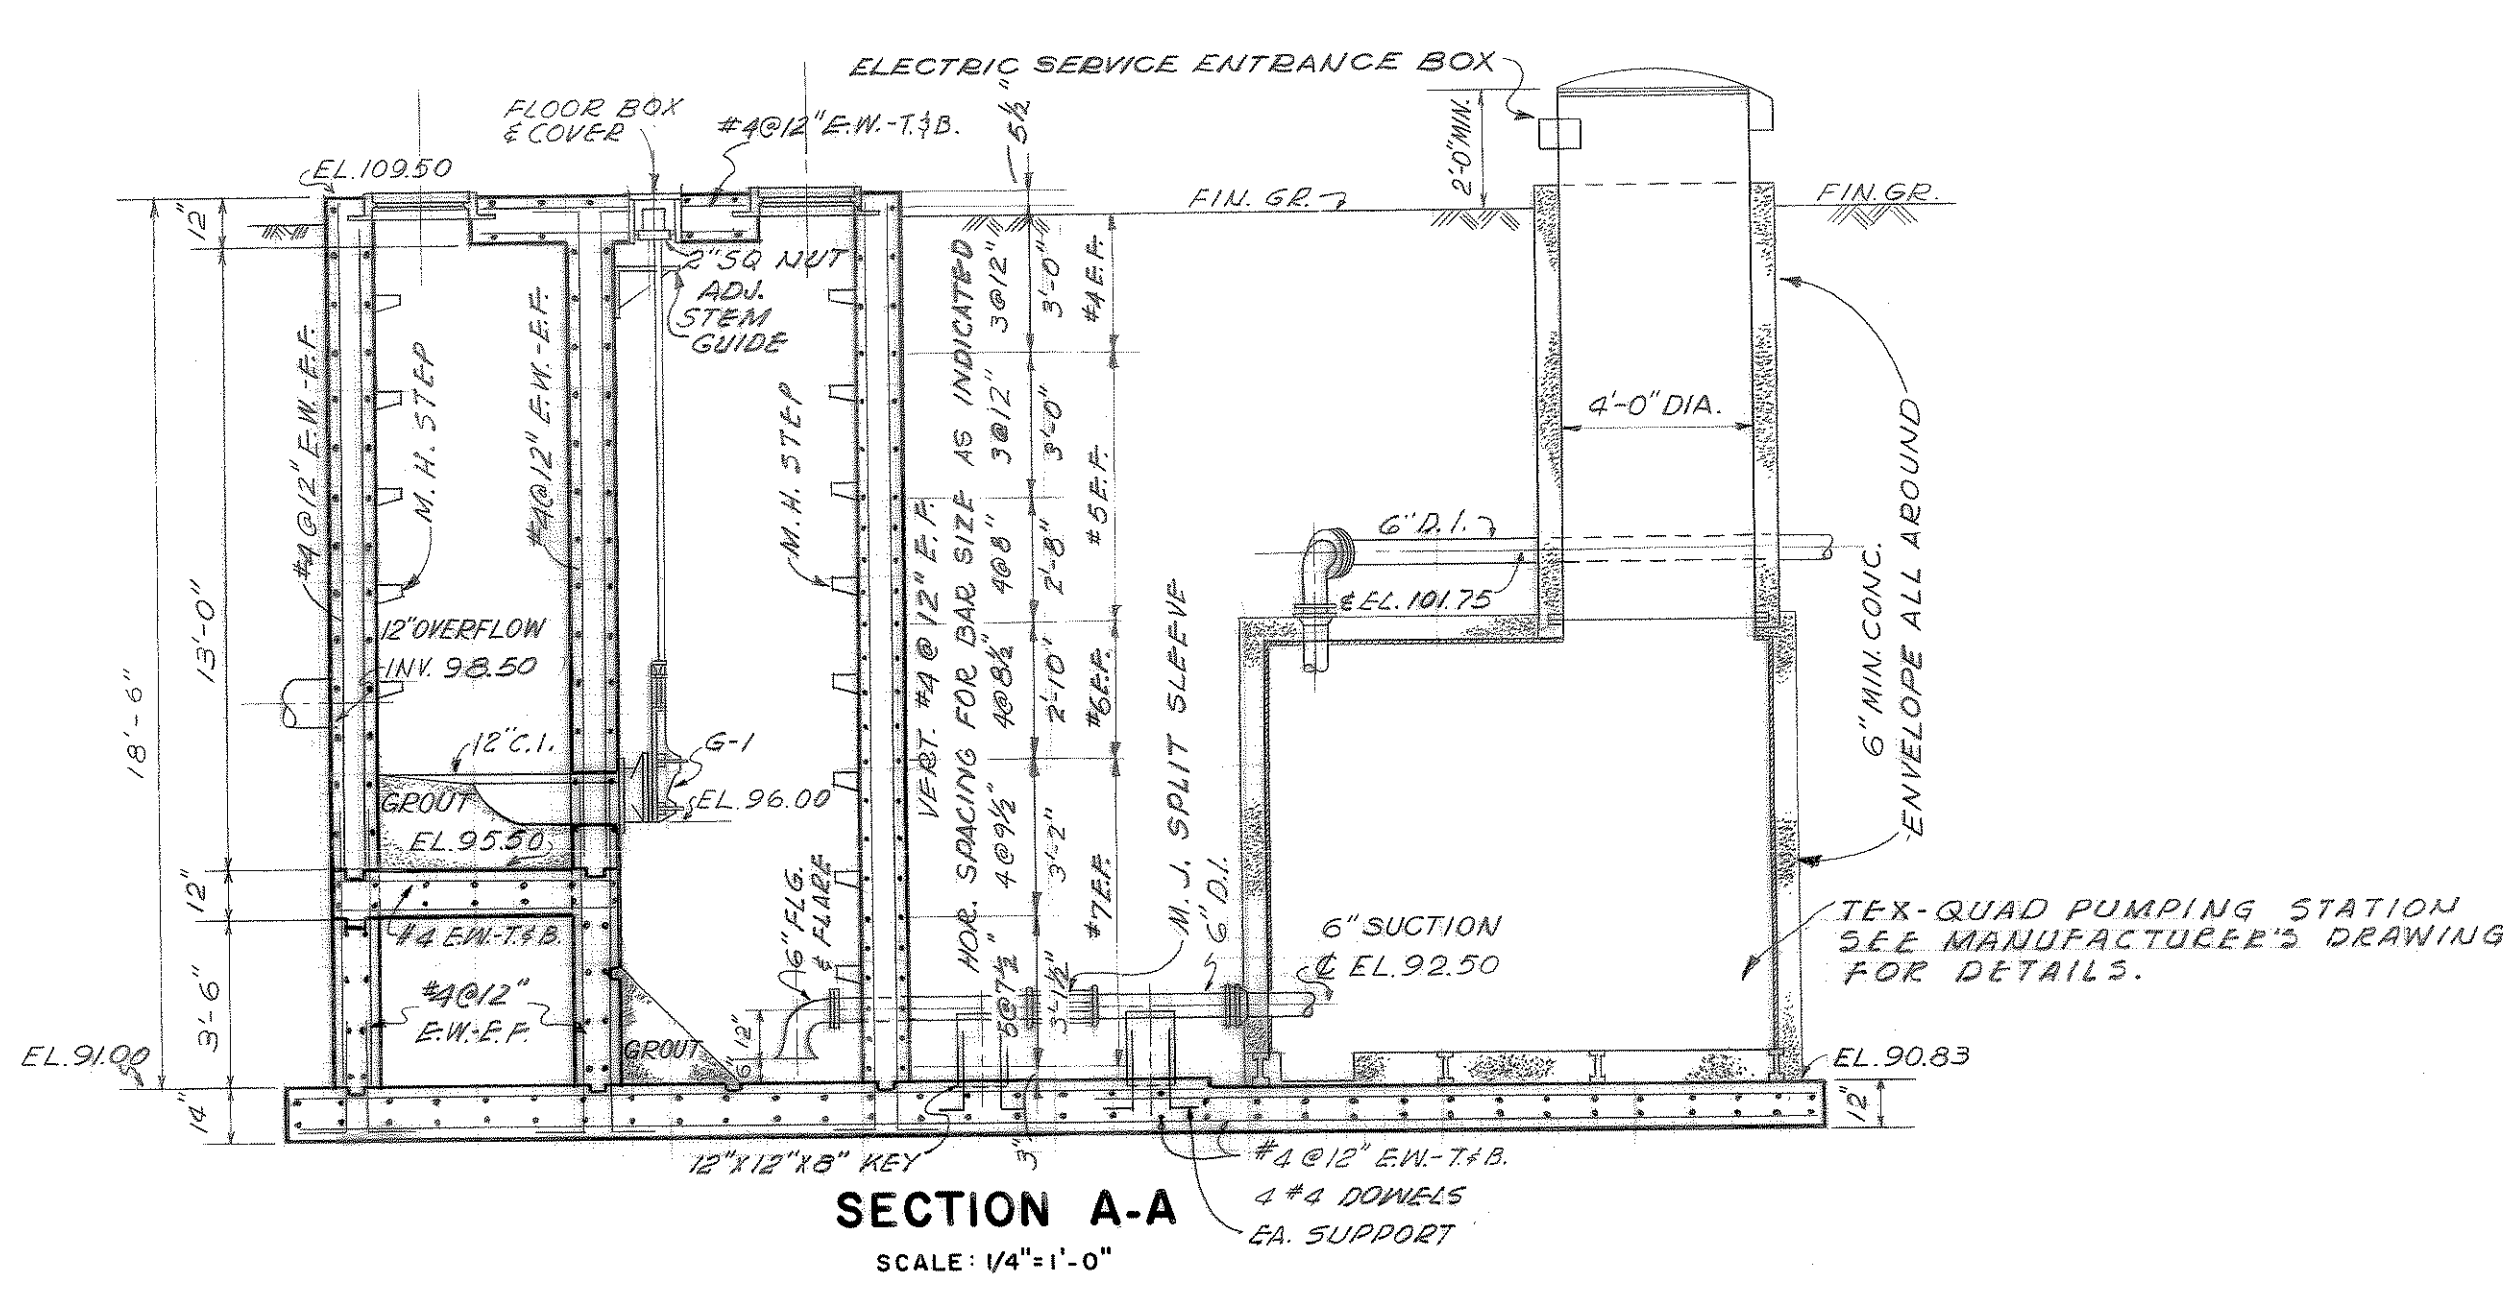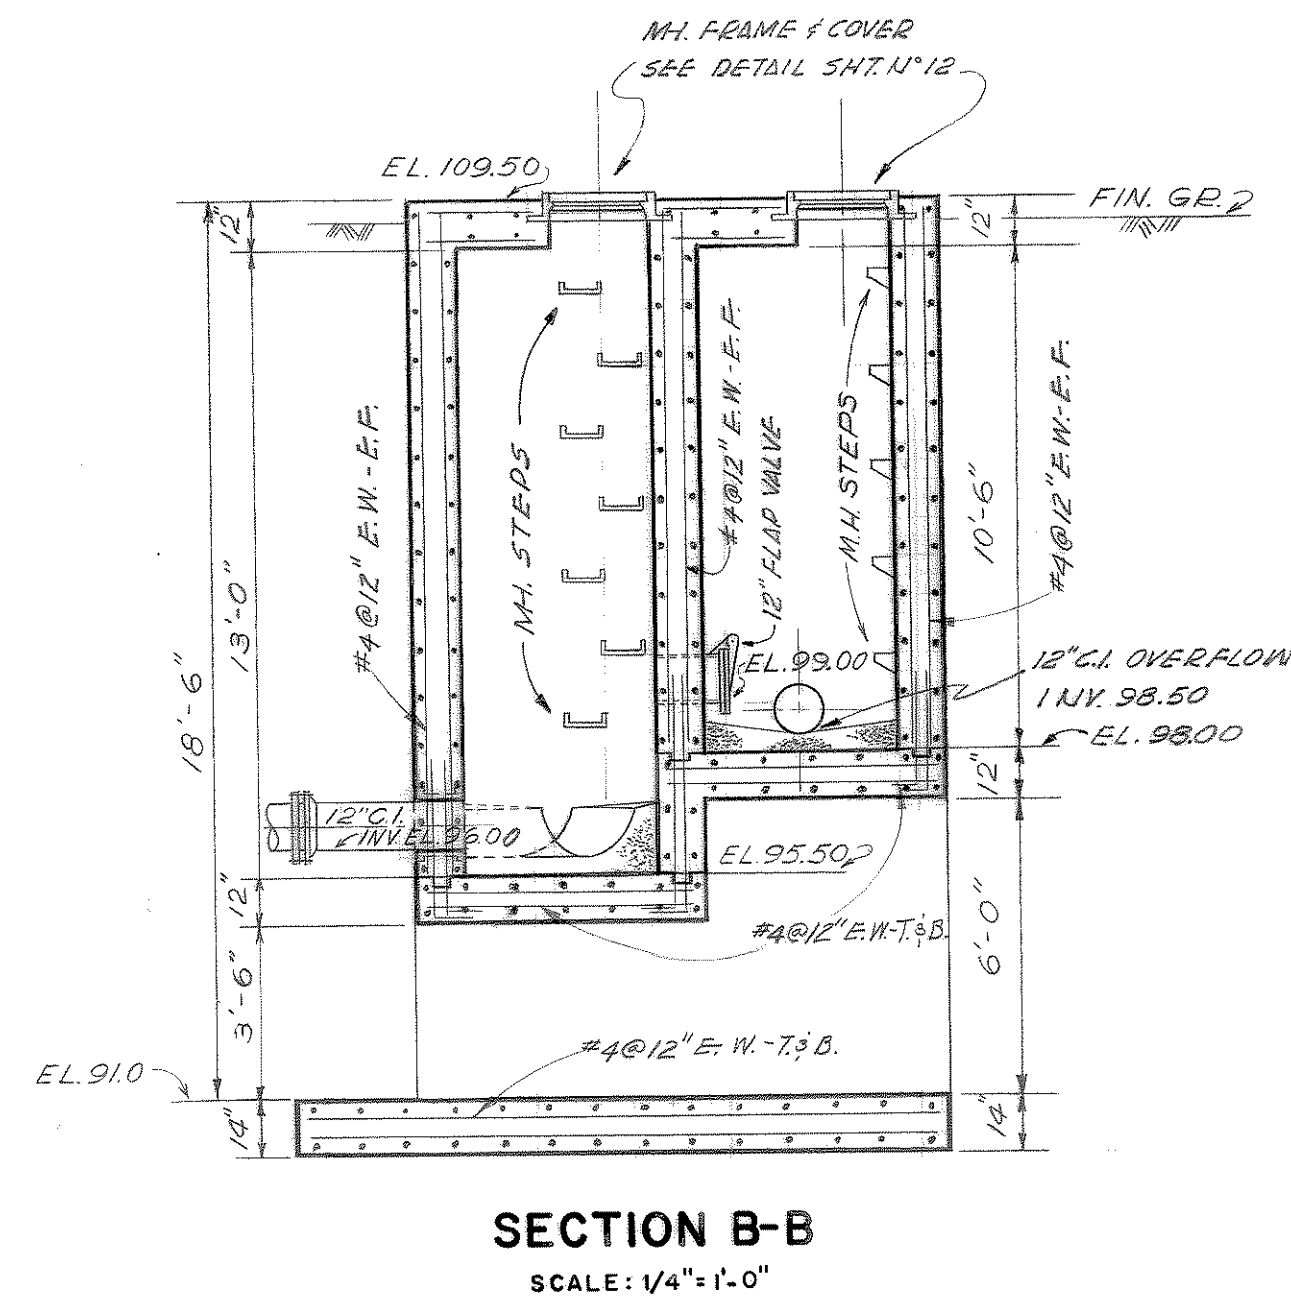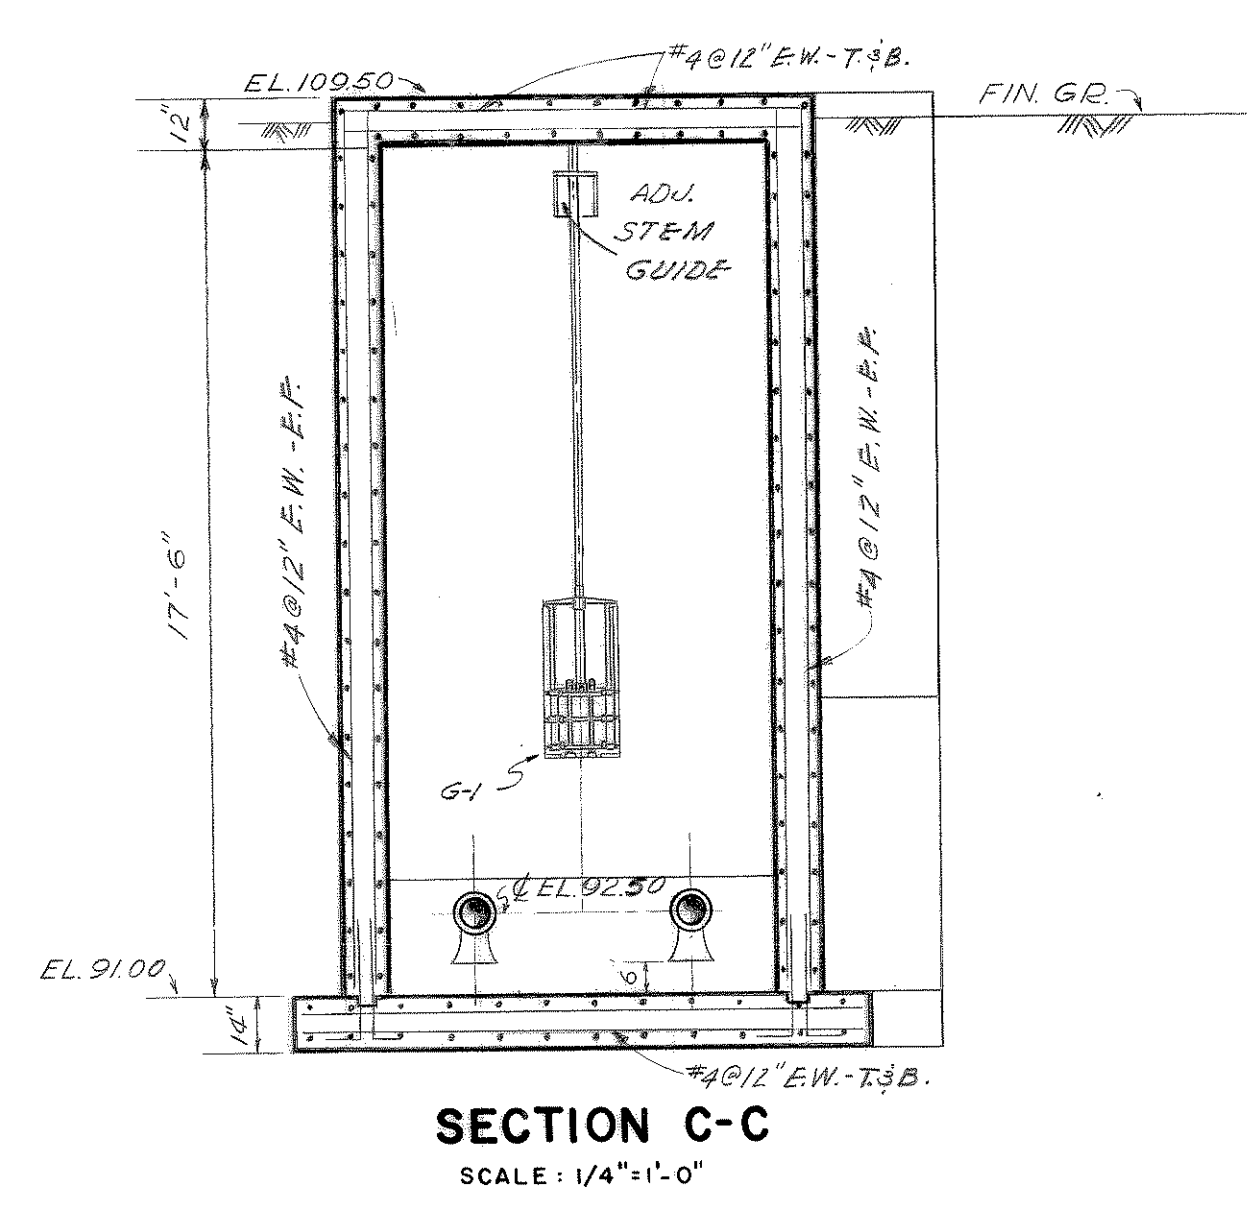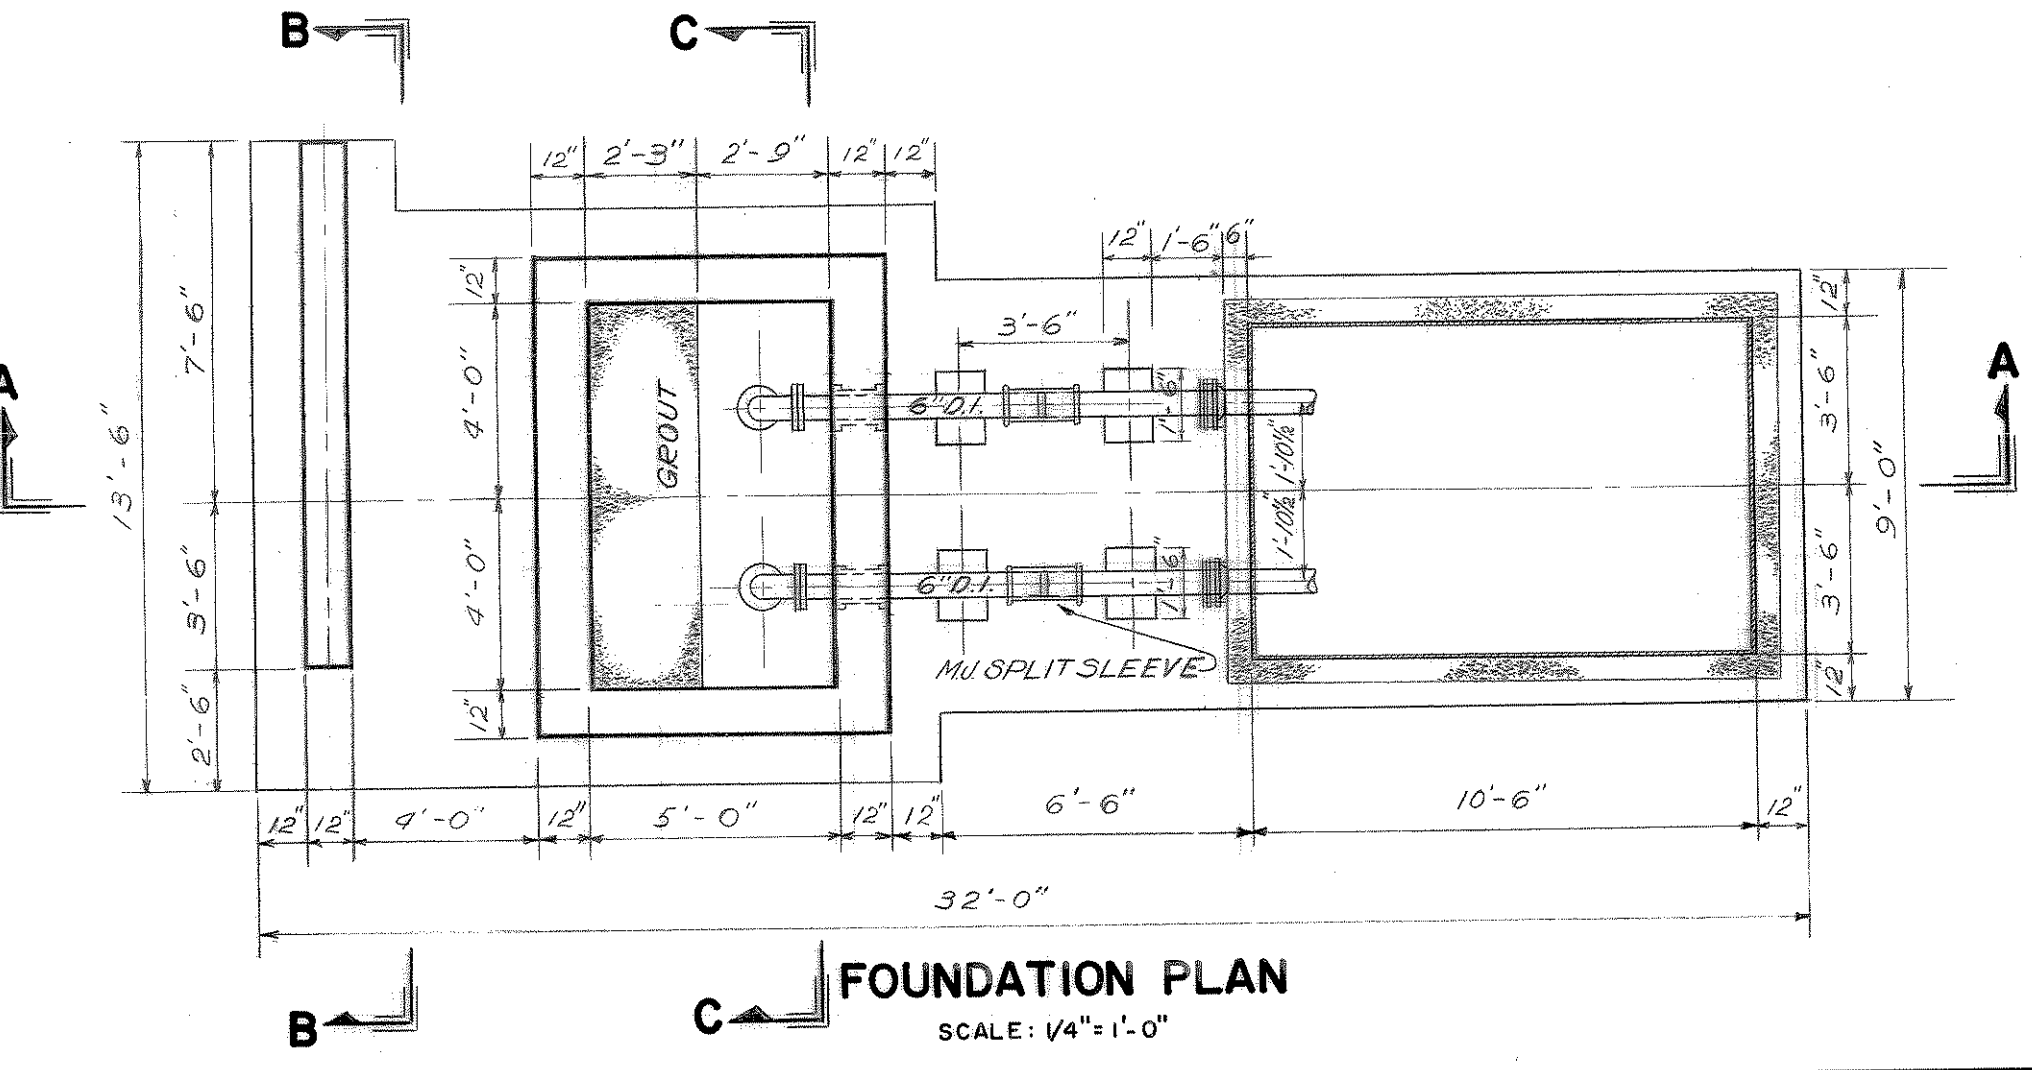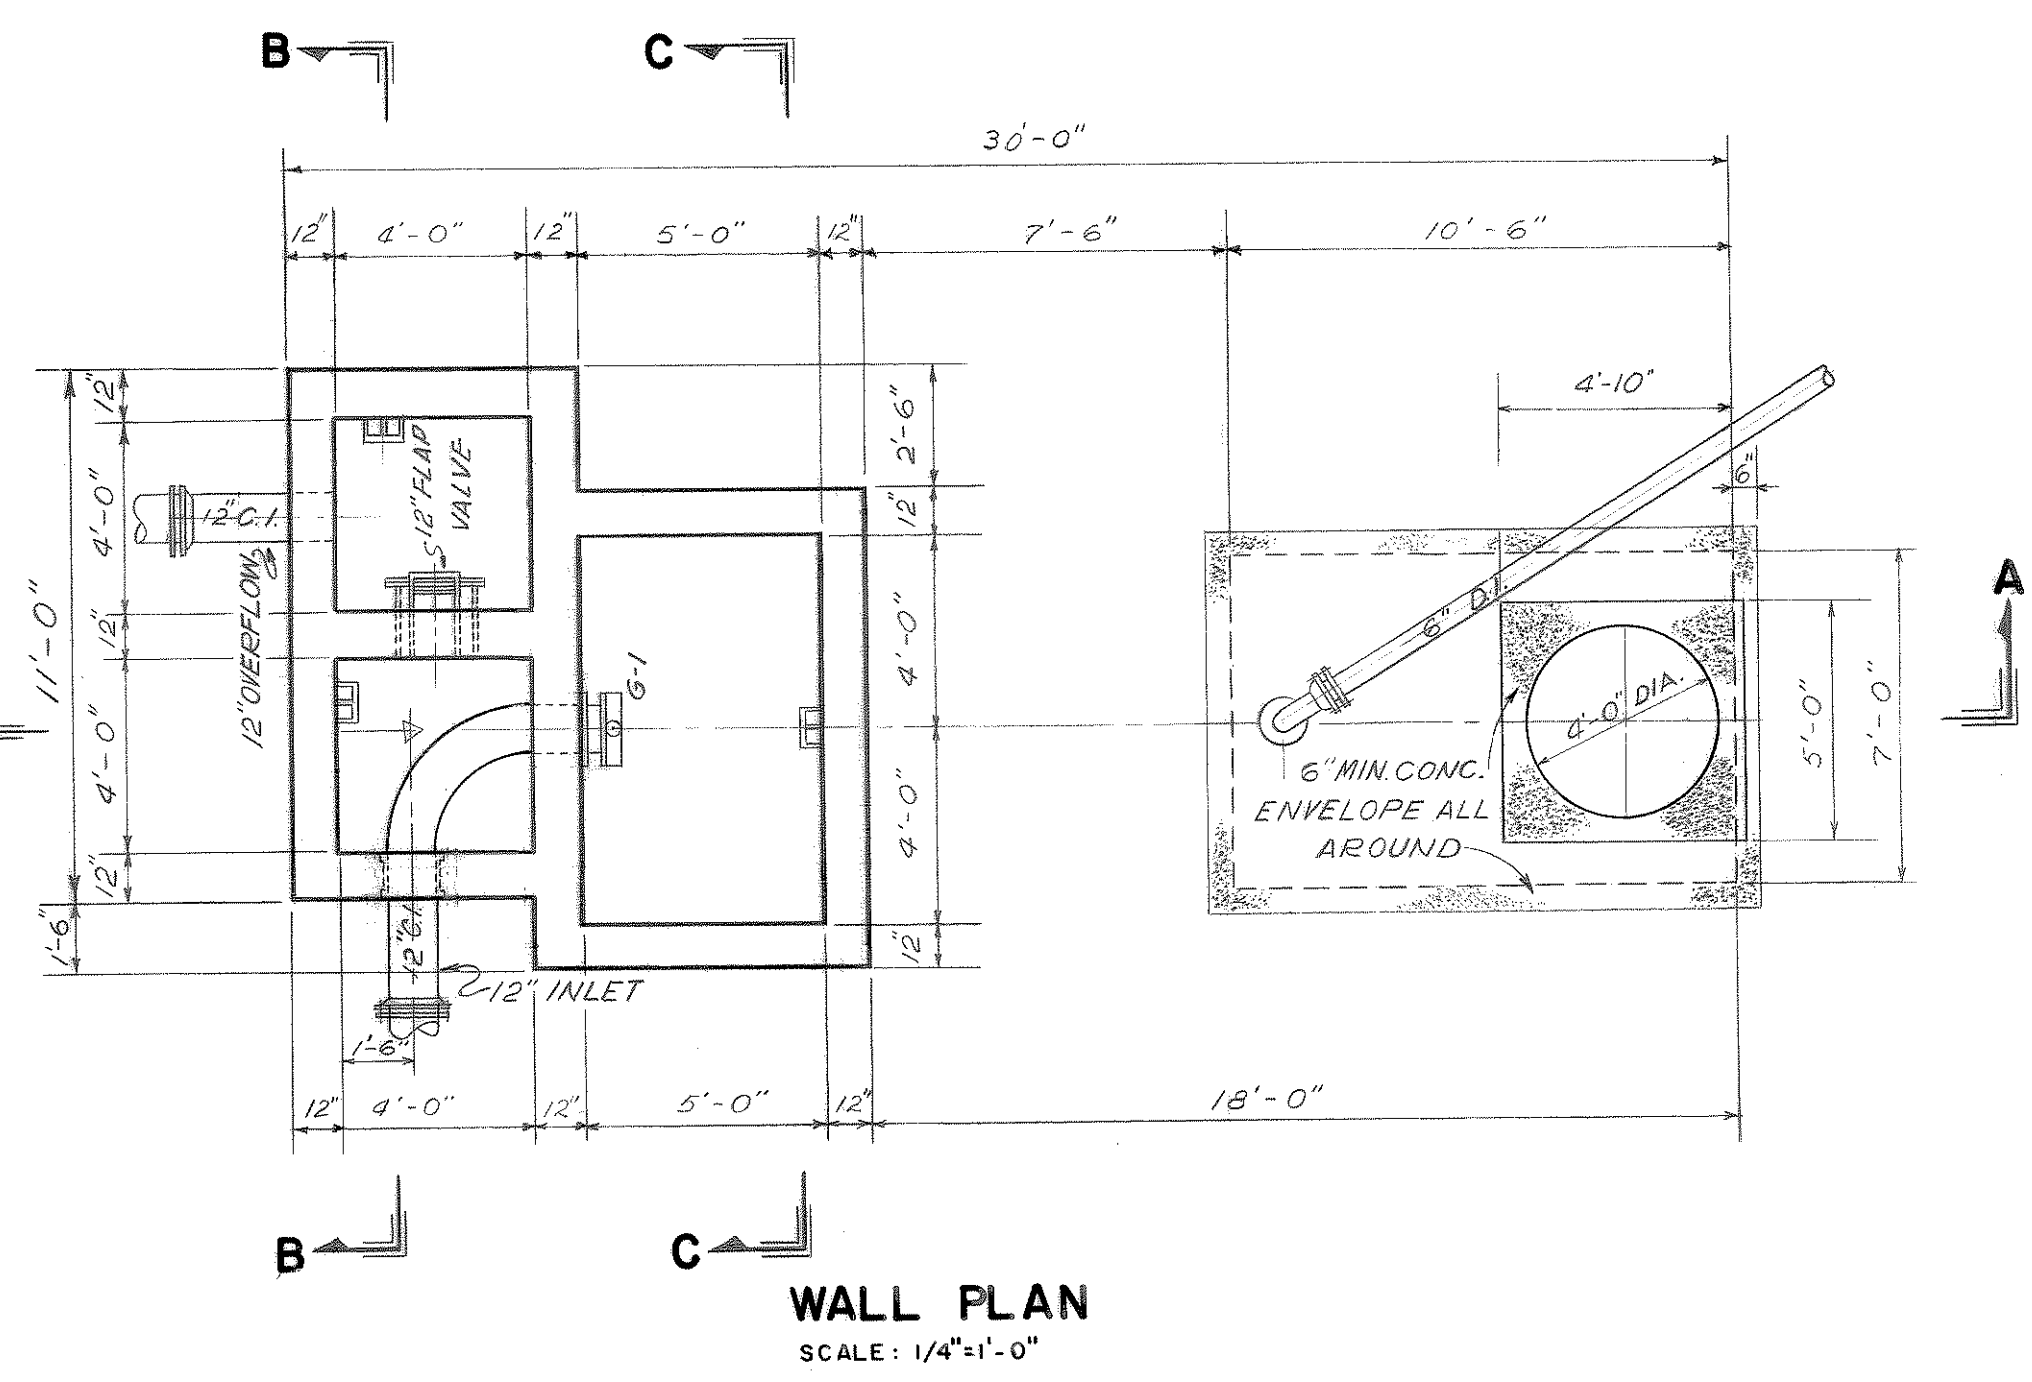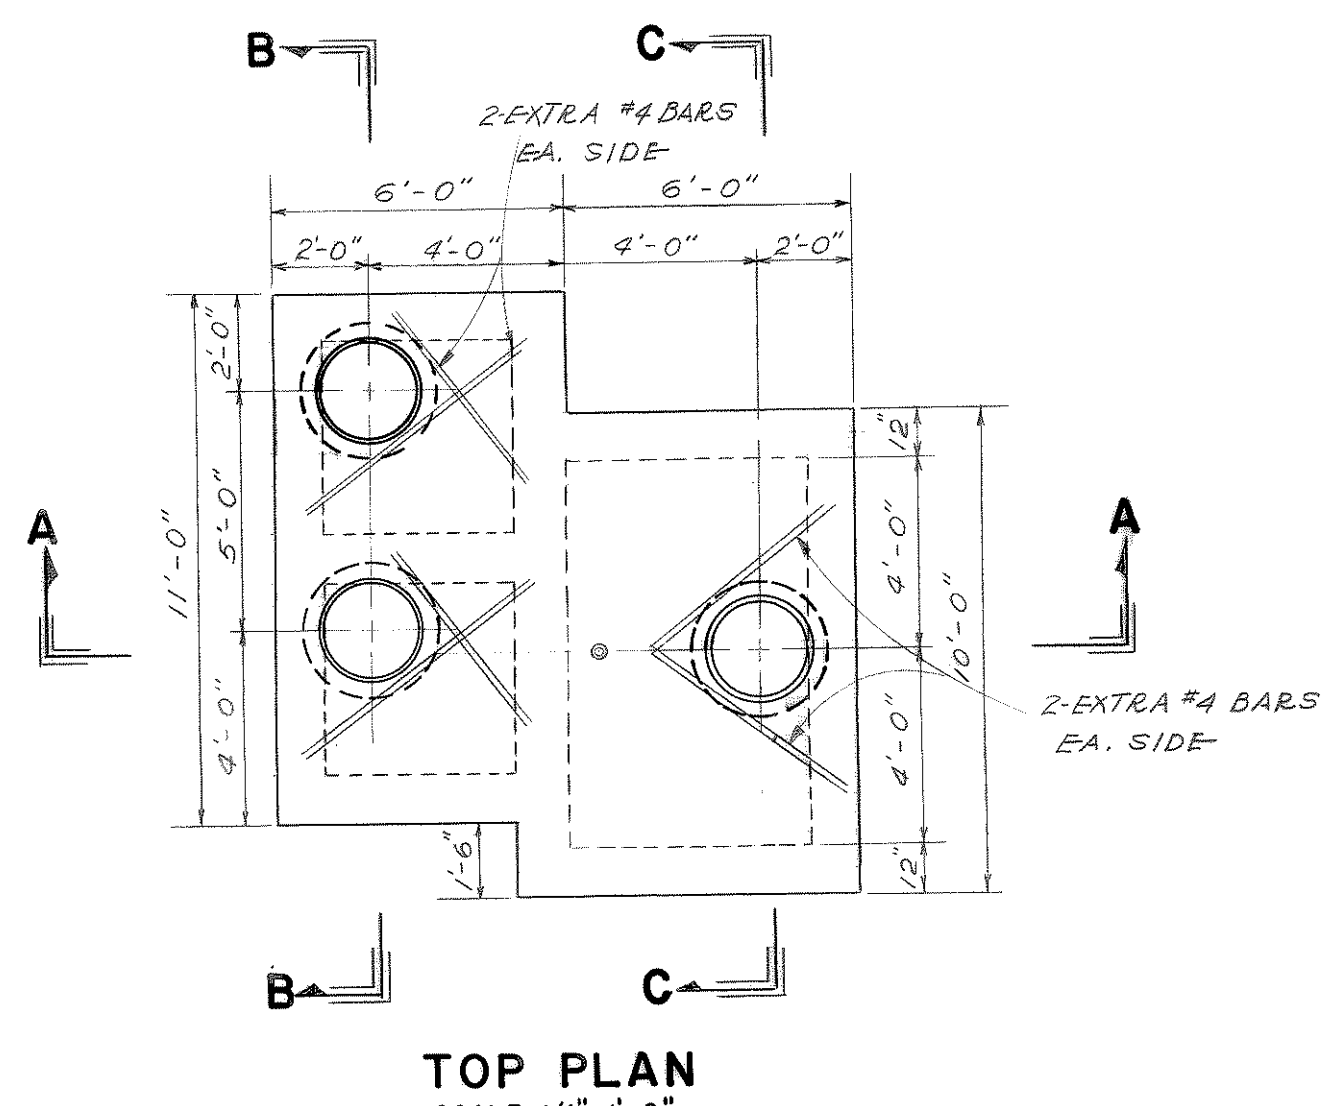

CONTRACT "C"			
CITY OF BRUNSWICK , GEORGIA SEWERAGE SYSTEM IMPROVEMENTS			
RAW SEWAGE PUMPING STATION NO.1			
SCALE AS SHOWN DATE JULY, 1963	WIEDEMAN AND SINGLETON ENGINEERS		SHEET 2 OF 15

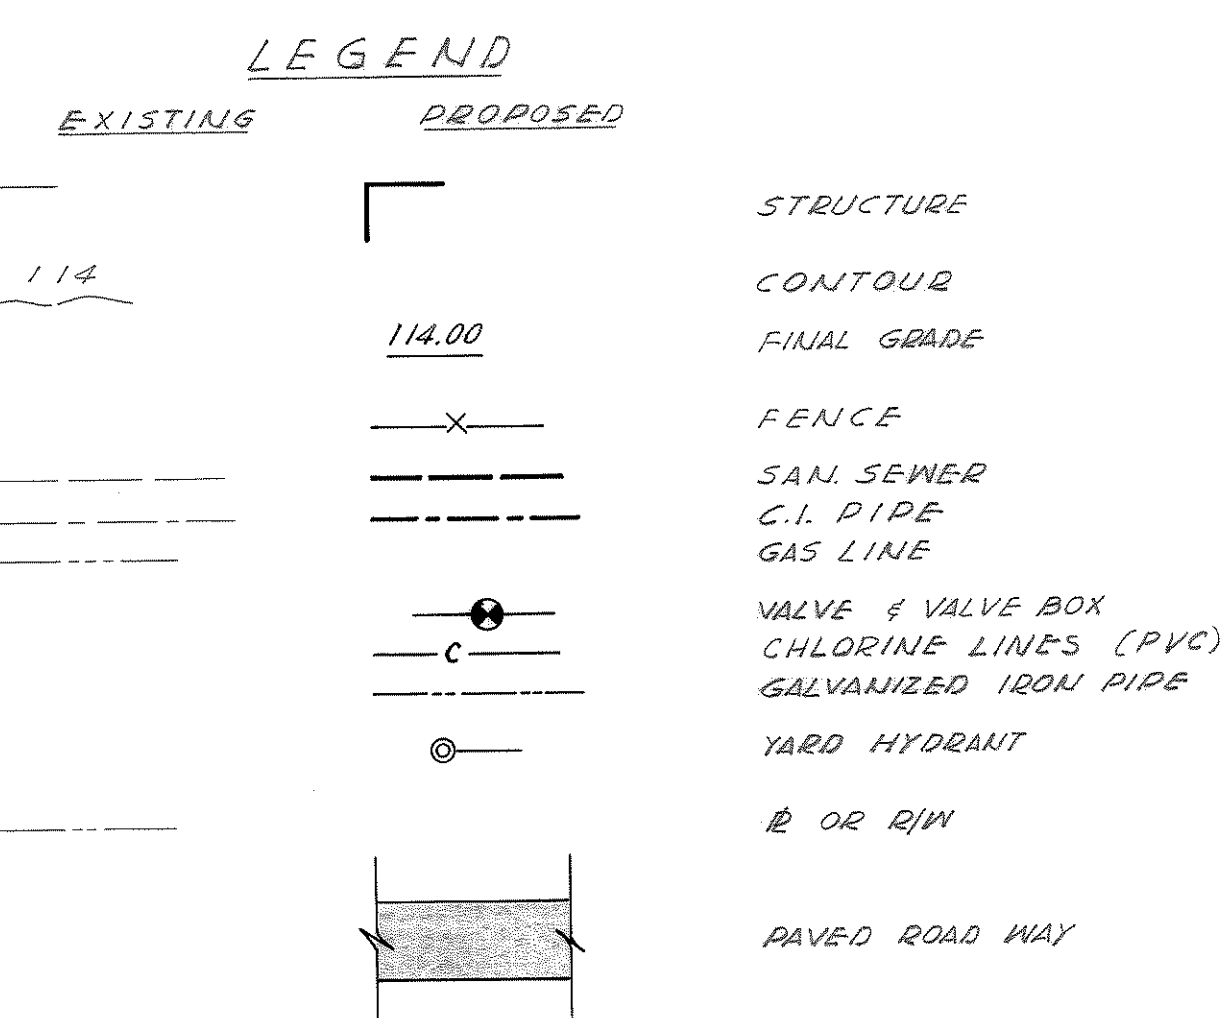

DATUM EQUALS USC&GS MEAN
SEA LEVEL PLUS 100.00 FT.

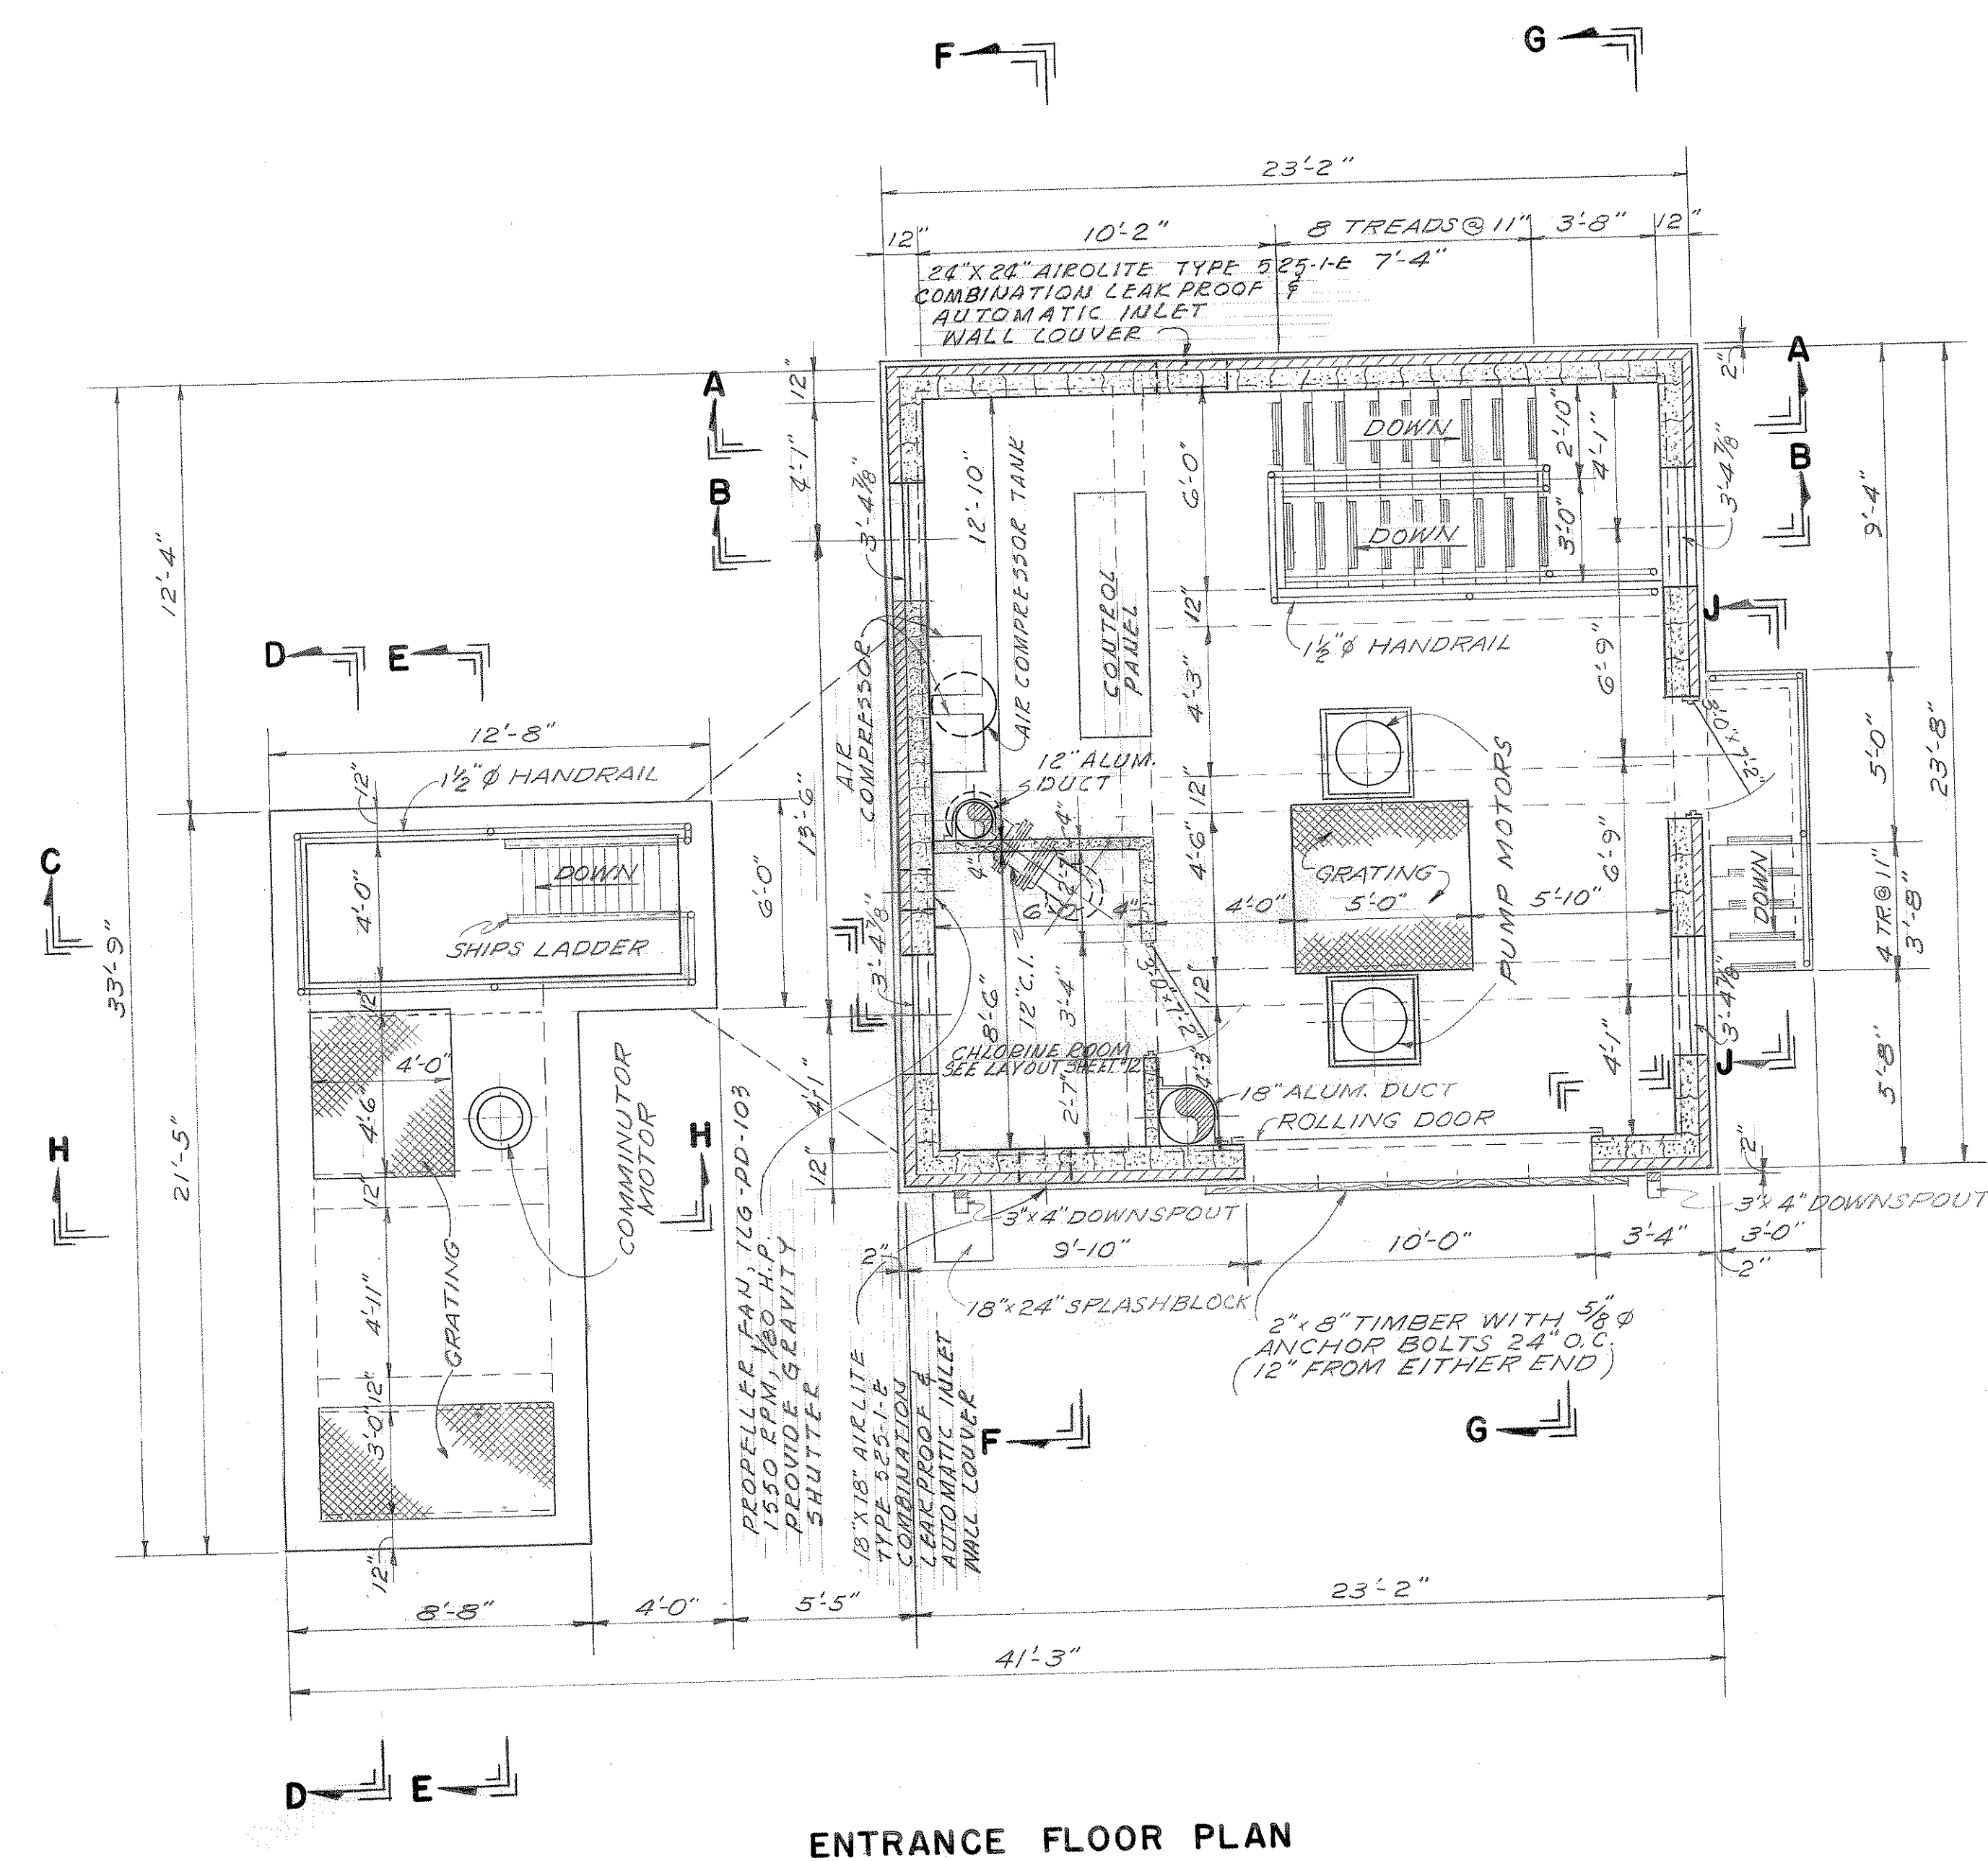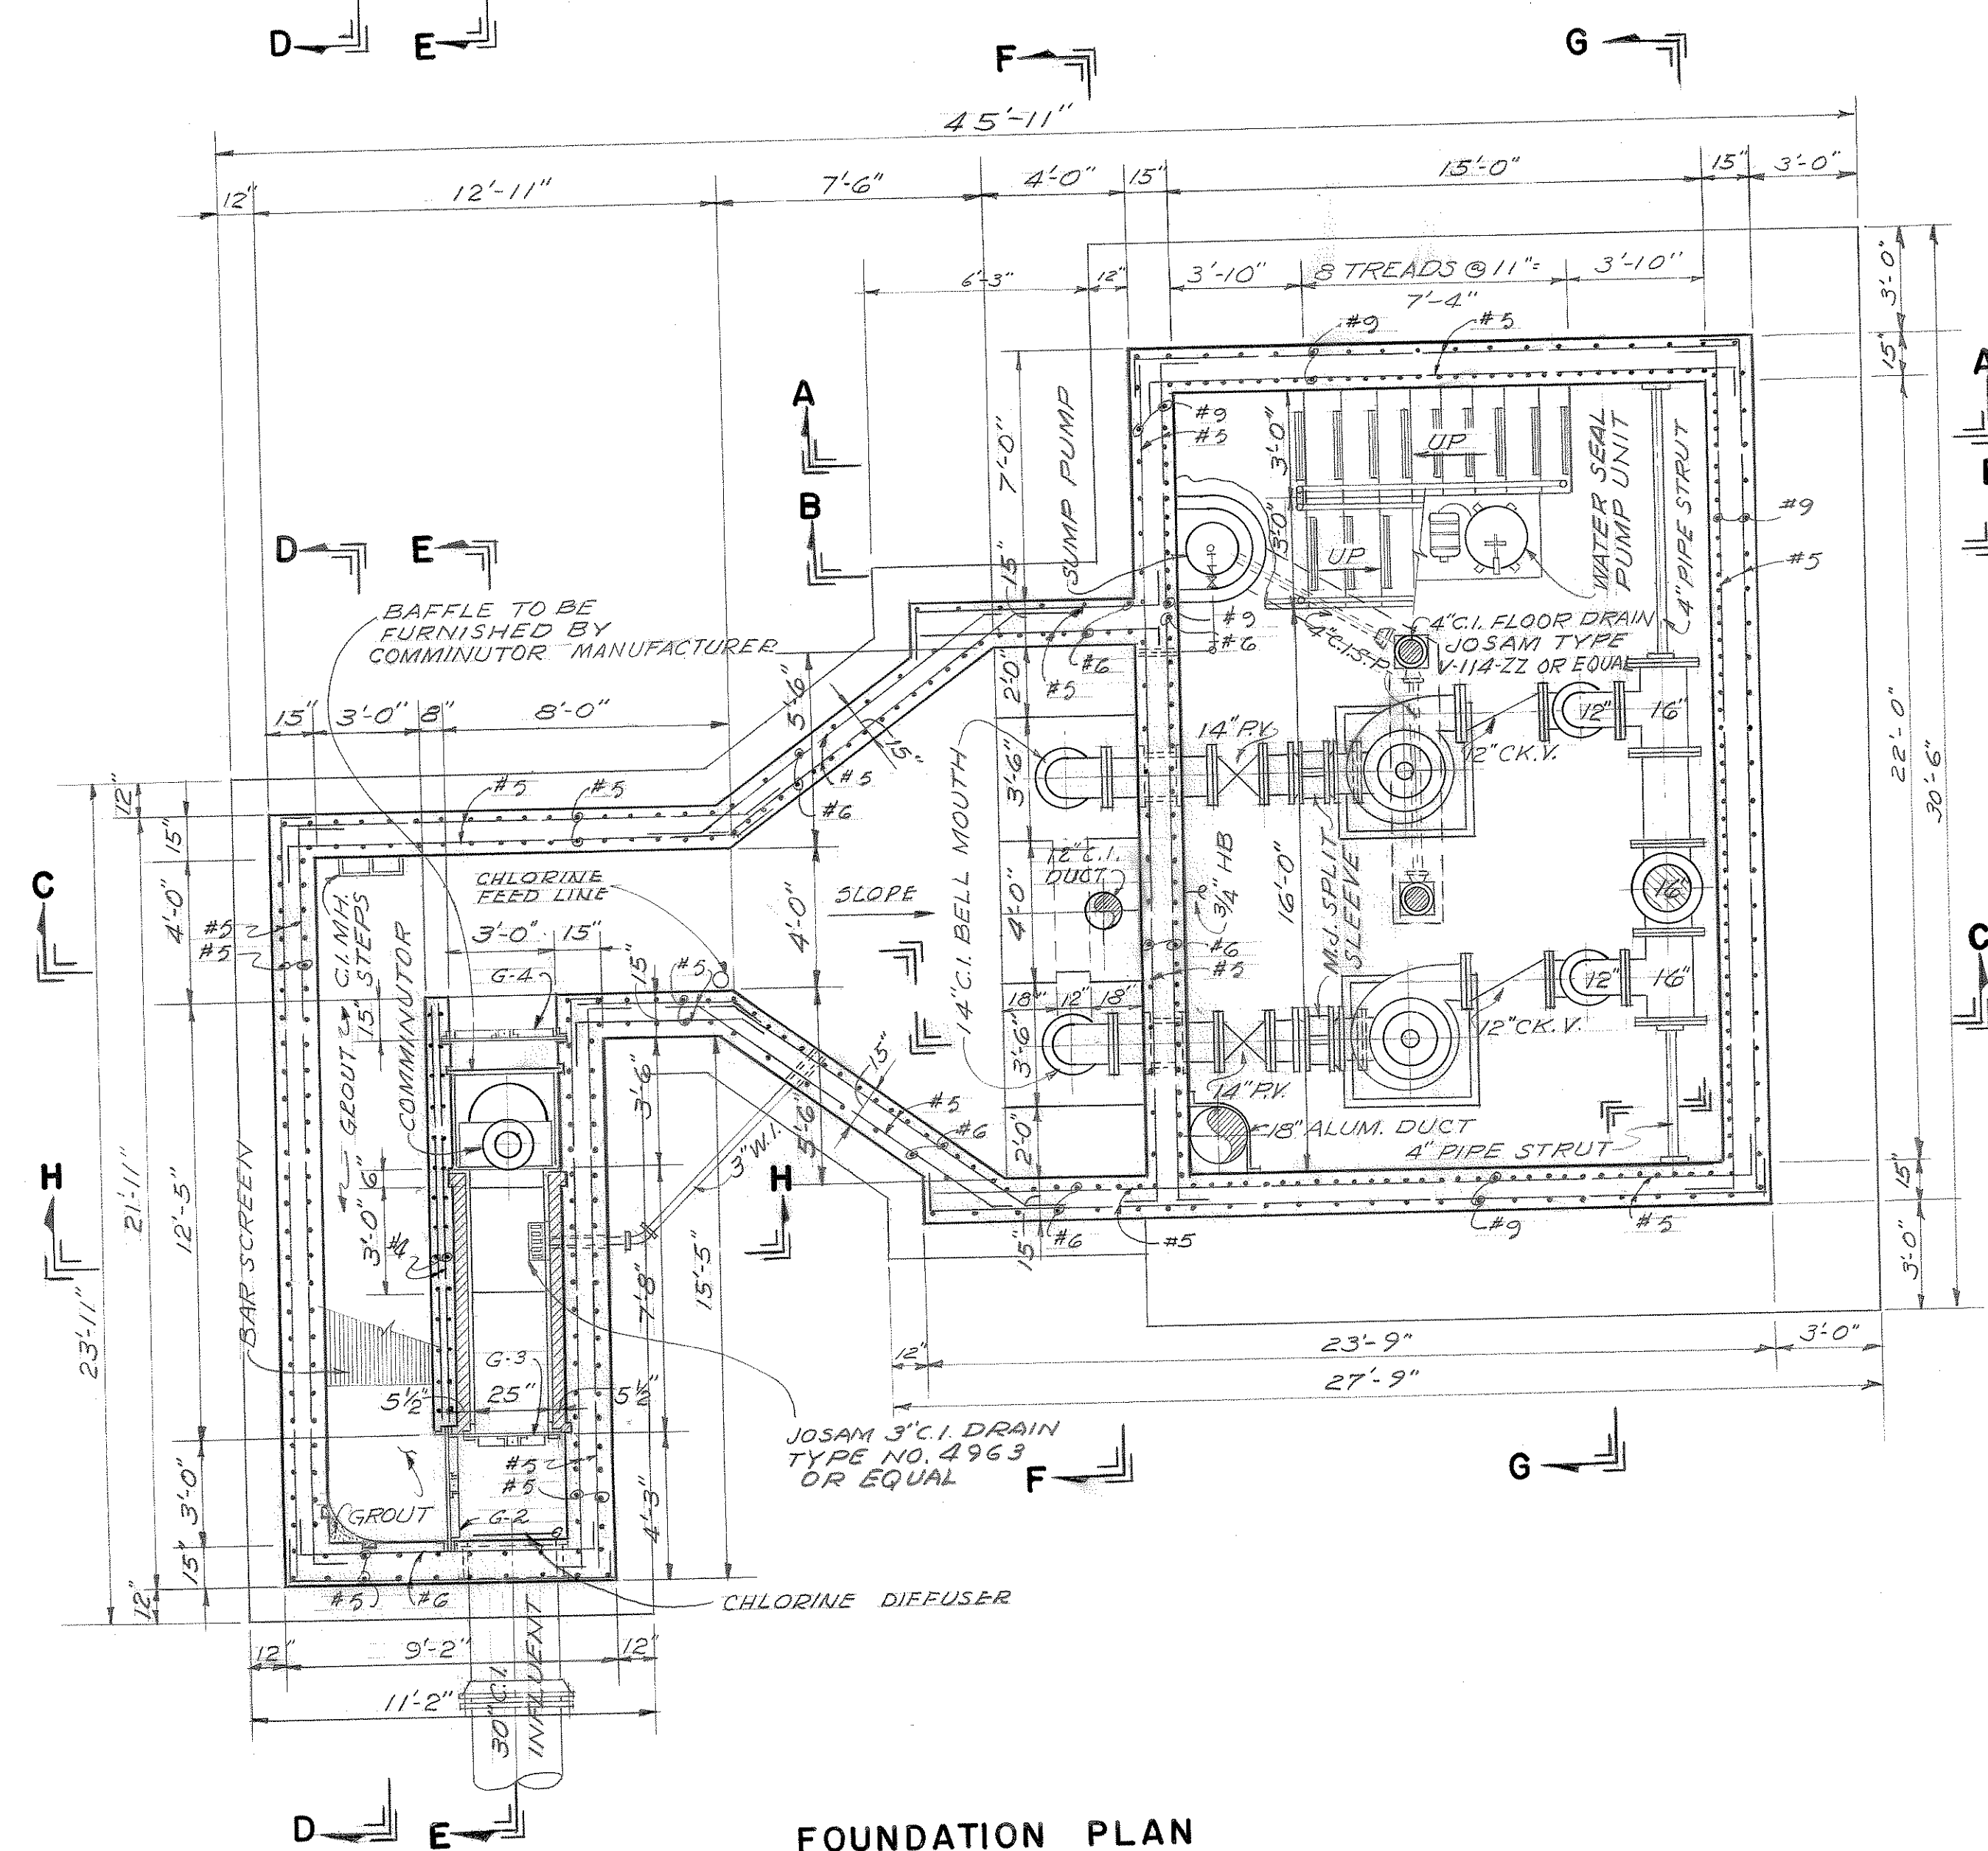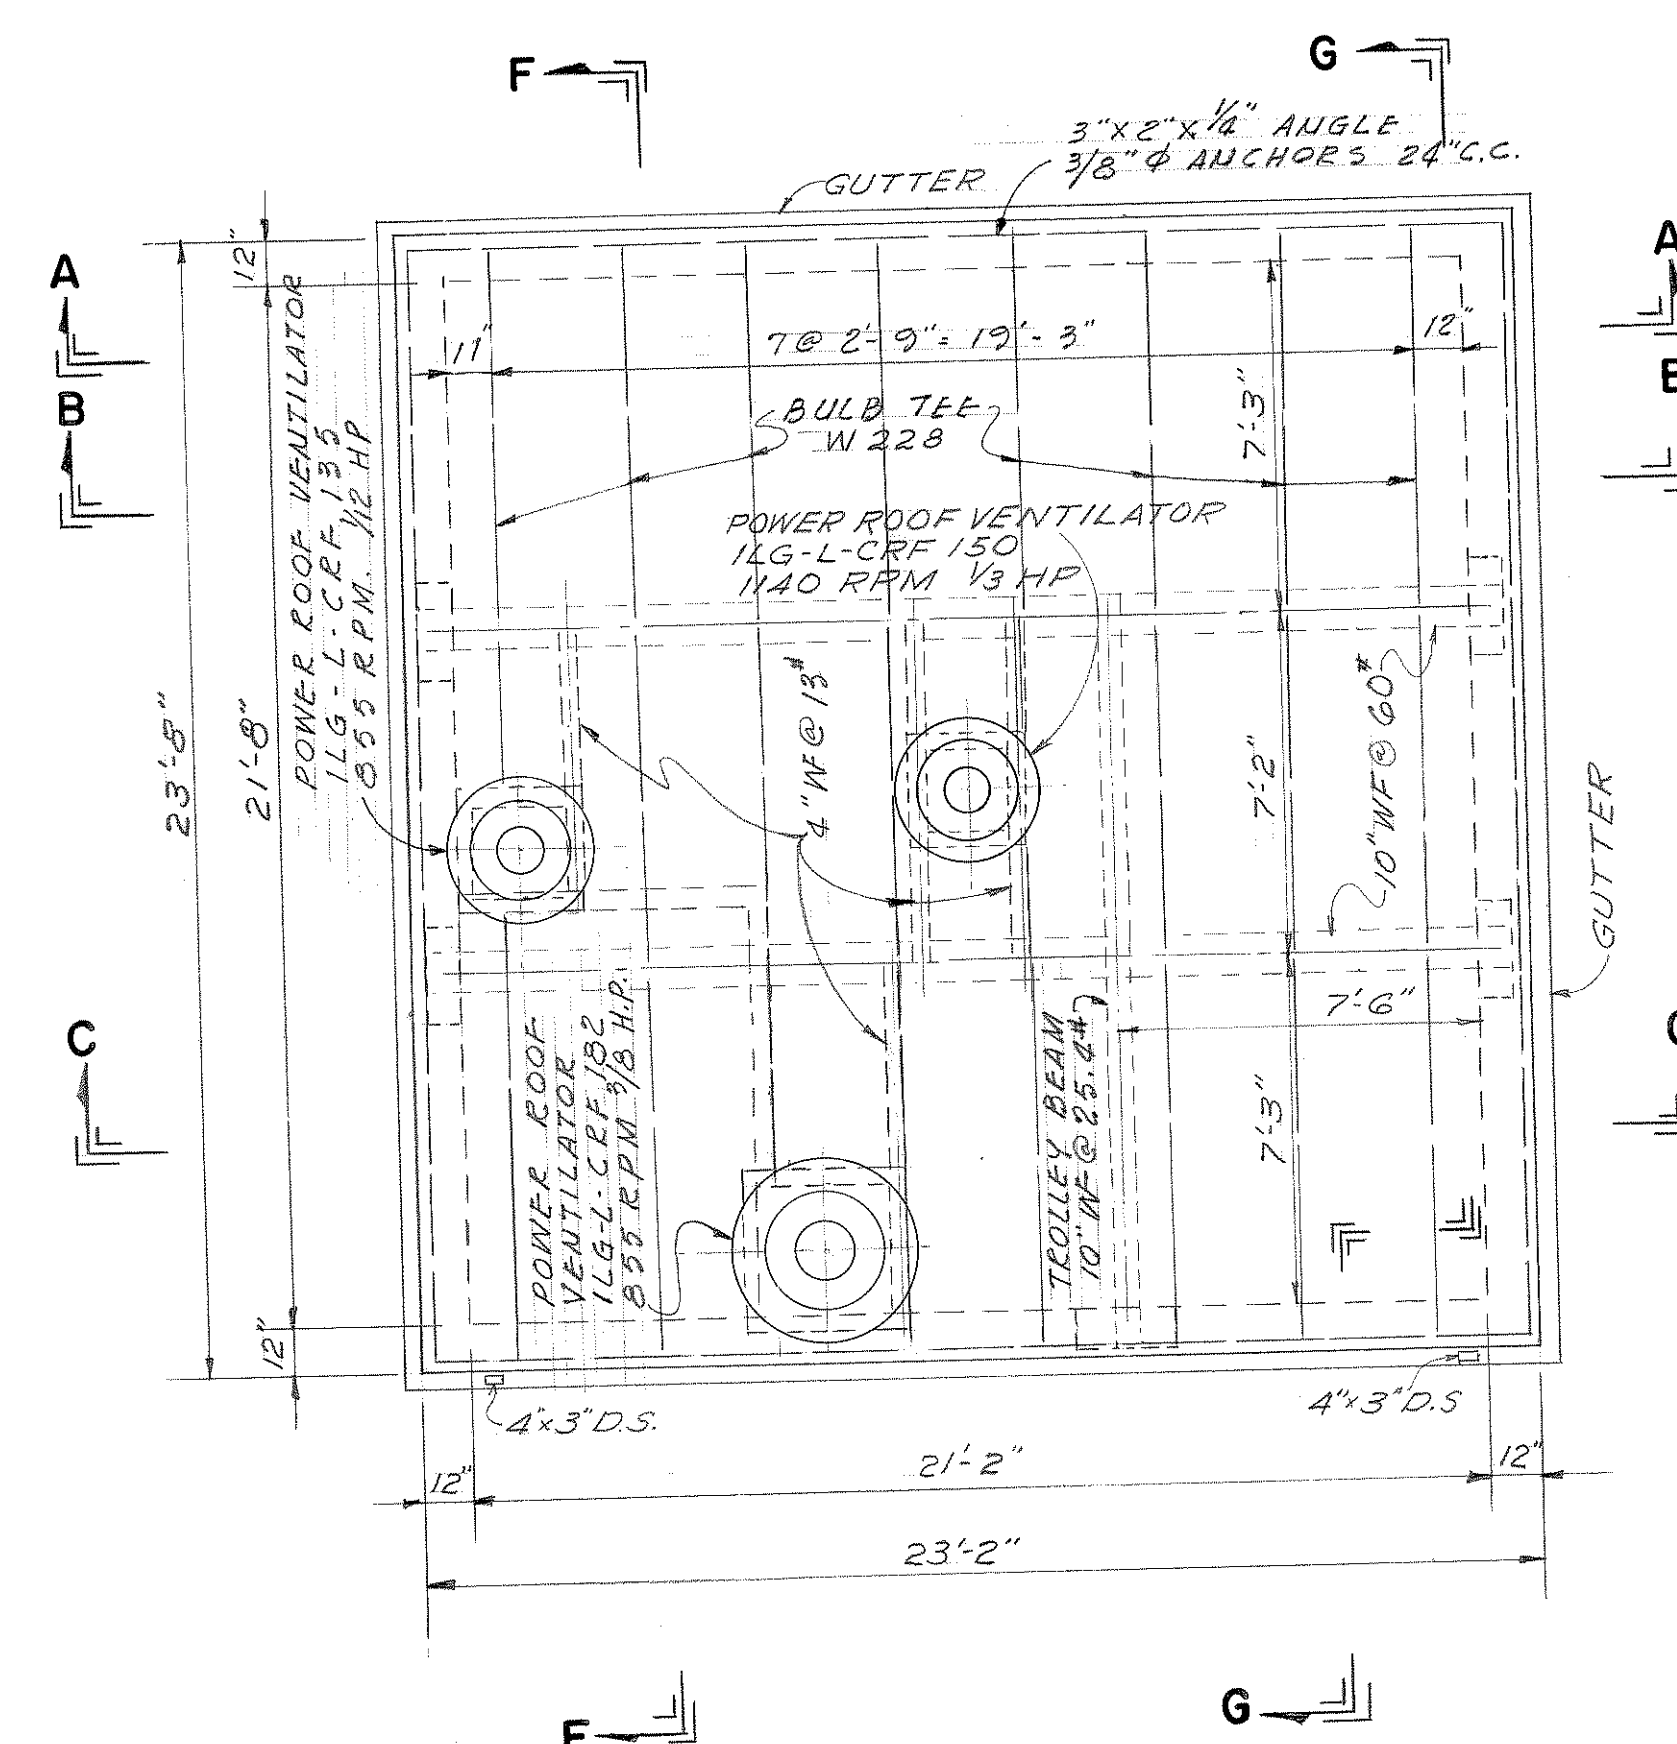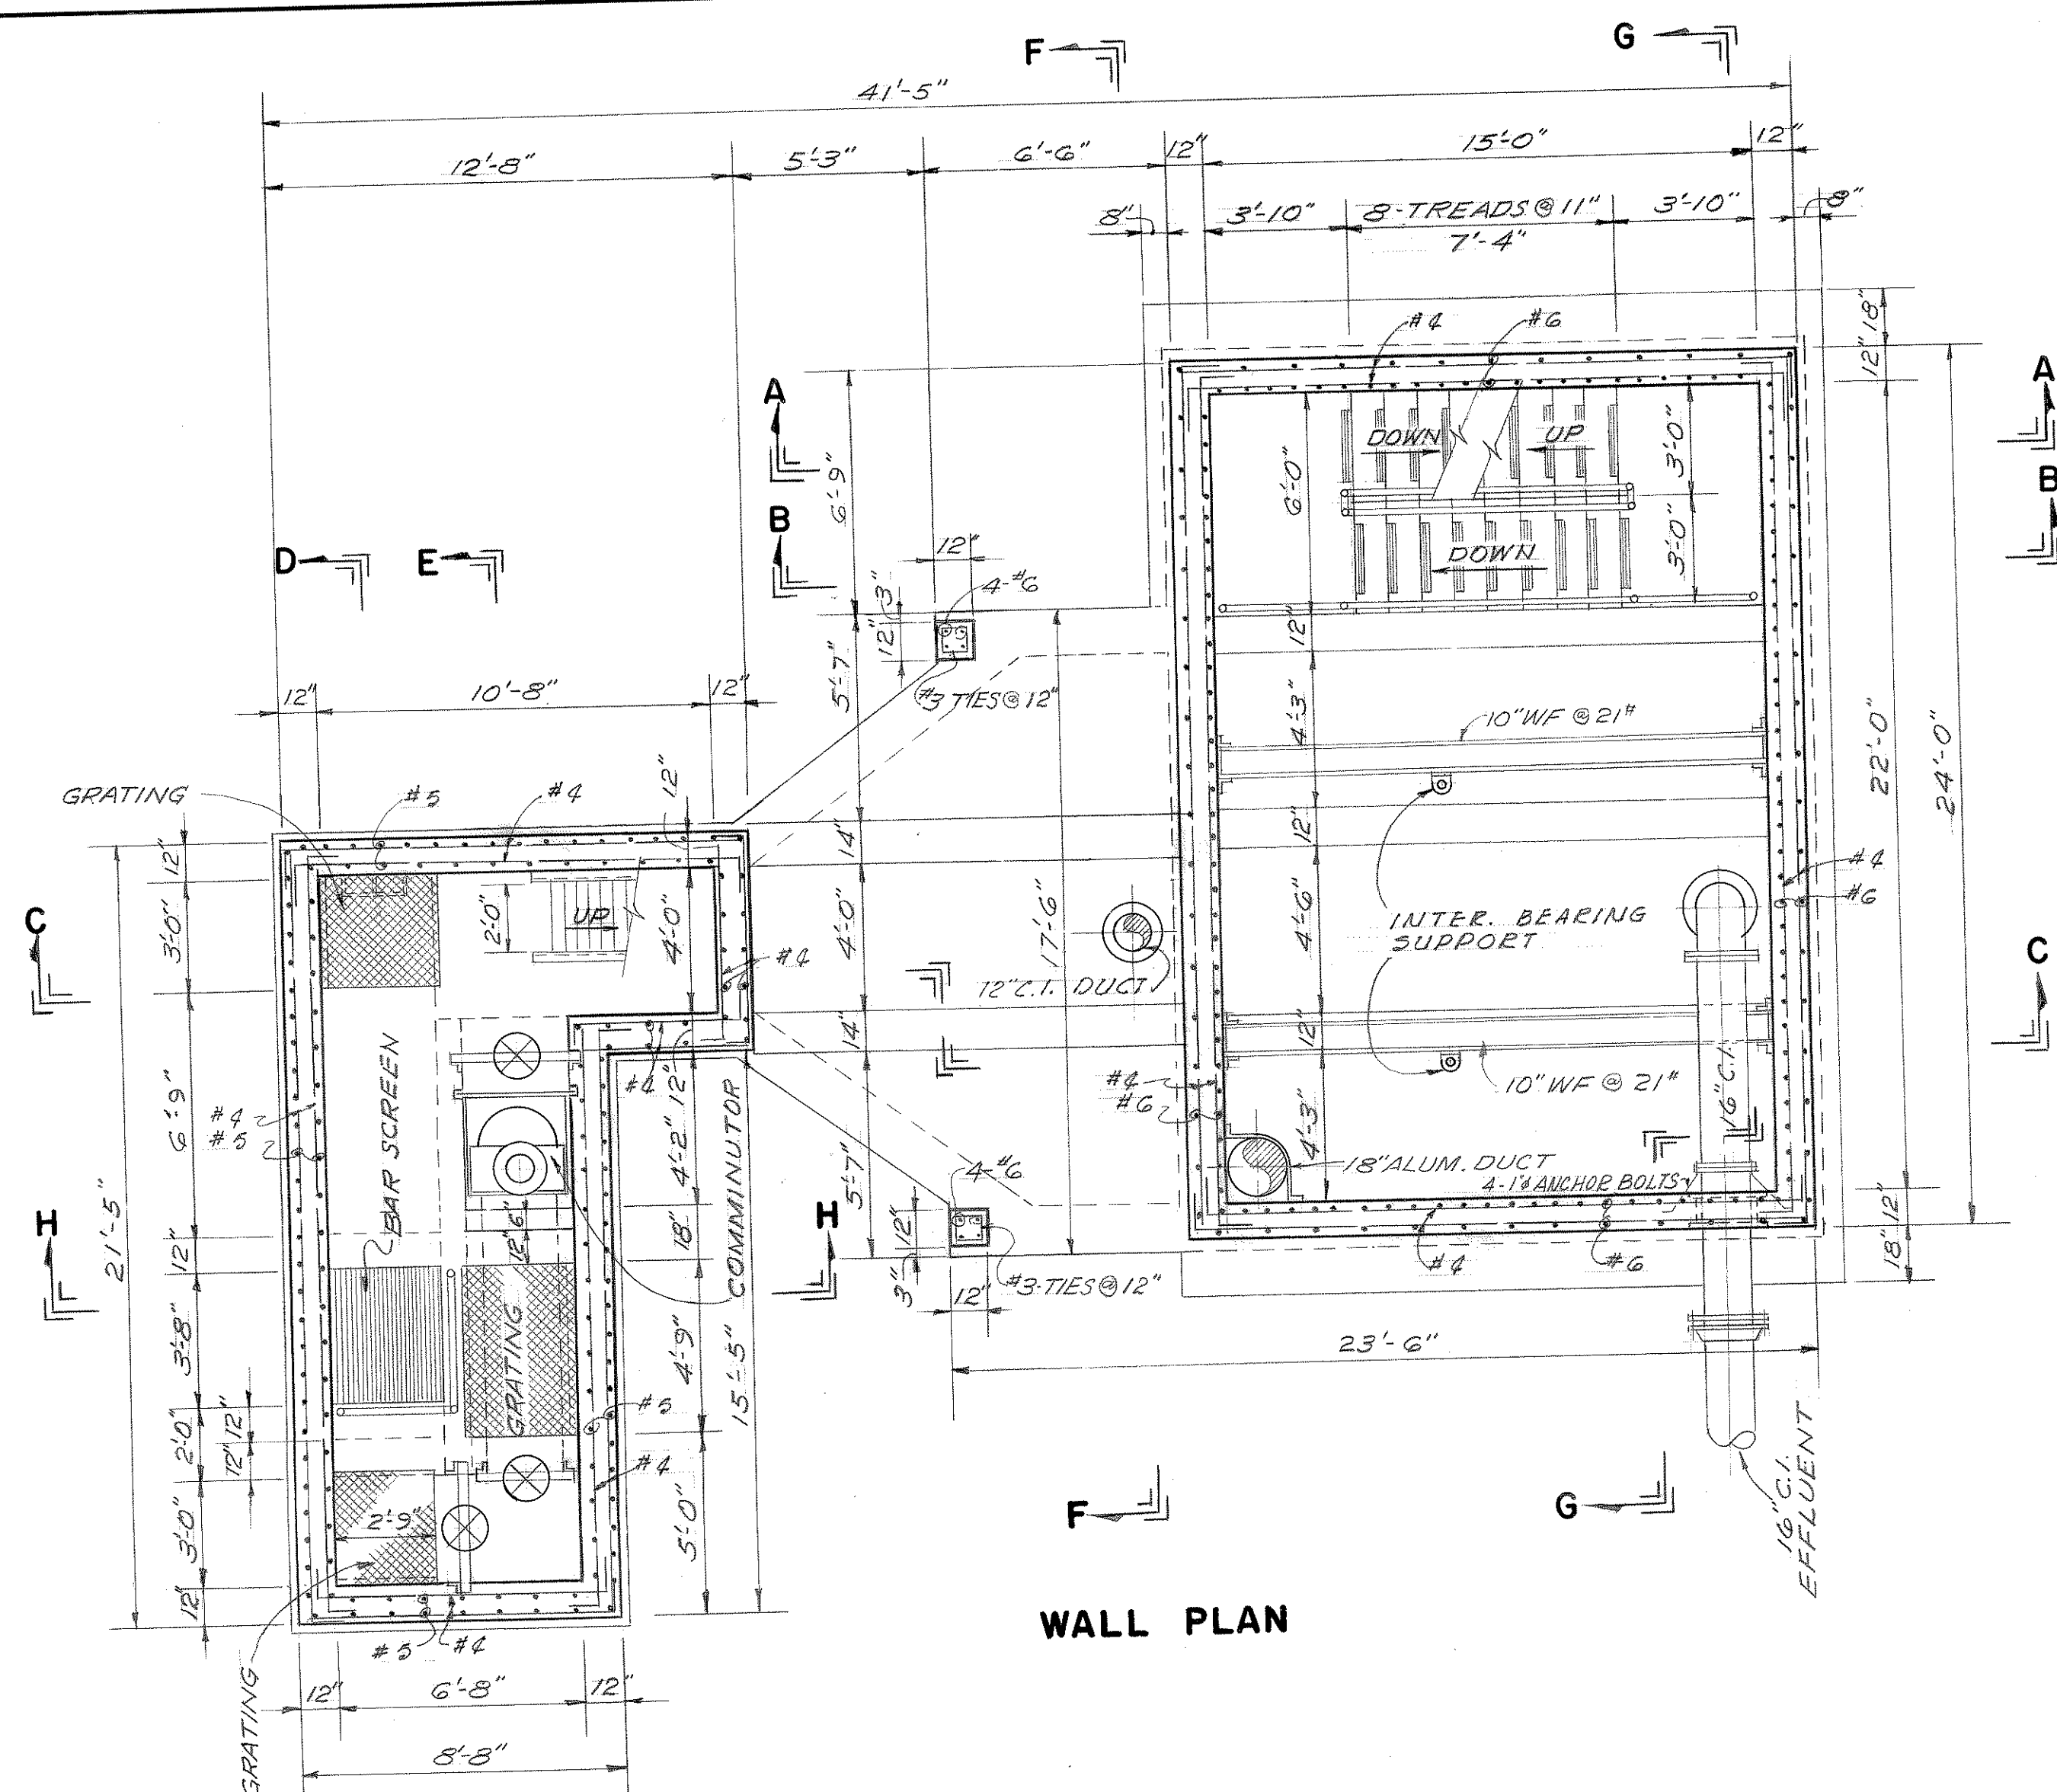

CONTRACT 'C'


CITY OF BRUNSWICK , GEORGIA
SEWERAGE SYSTEM IMPROVEMENTS

RAW SEWAGE
PUMPING STATION NO. 2


DATUM EQUALS USC&GS MEAN
SEA LEVEL PLUS 100.00 FT.

SCALE 1/4" = 1'-0"	WIEDEMAN AND SINGLETON ENGINEERS	SHEET 4
DATE JULY, 1963	ATLANTA	OF 15


REVISED DEC 1963

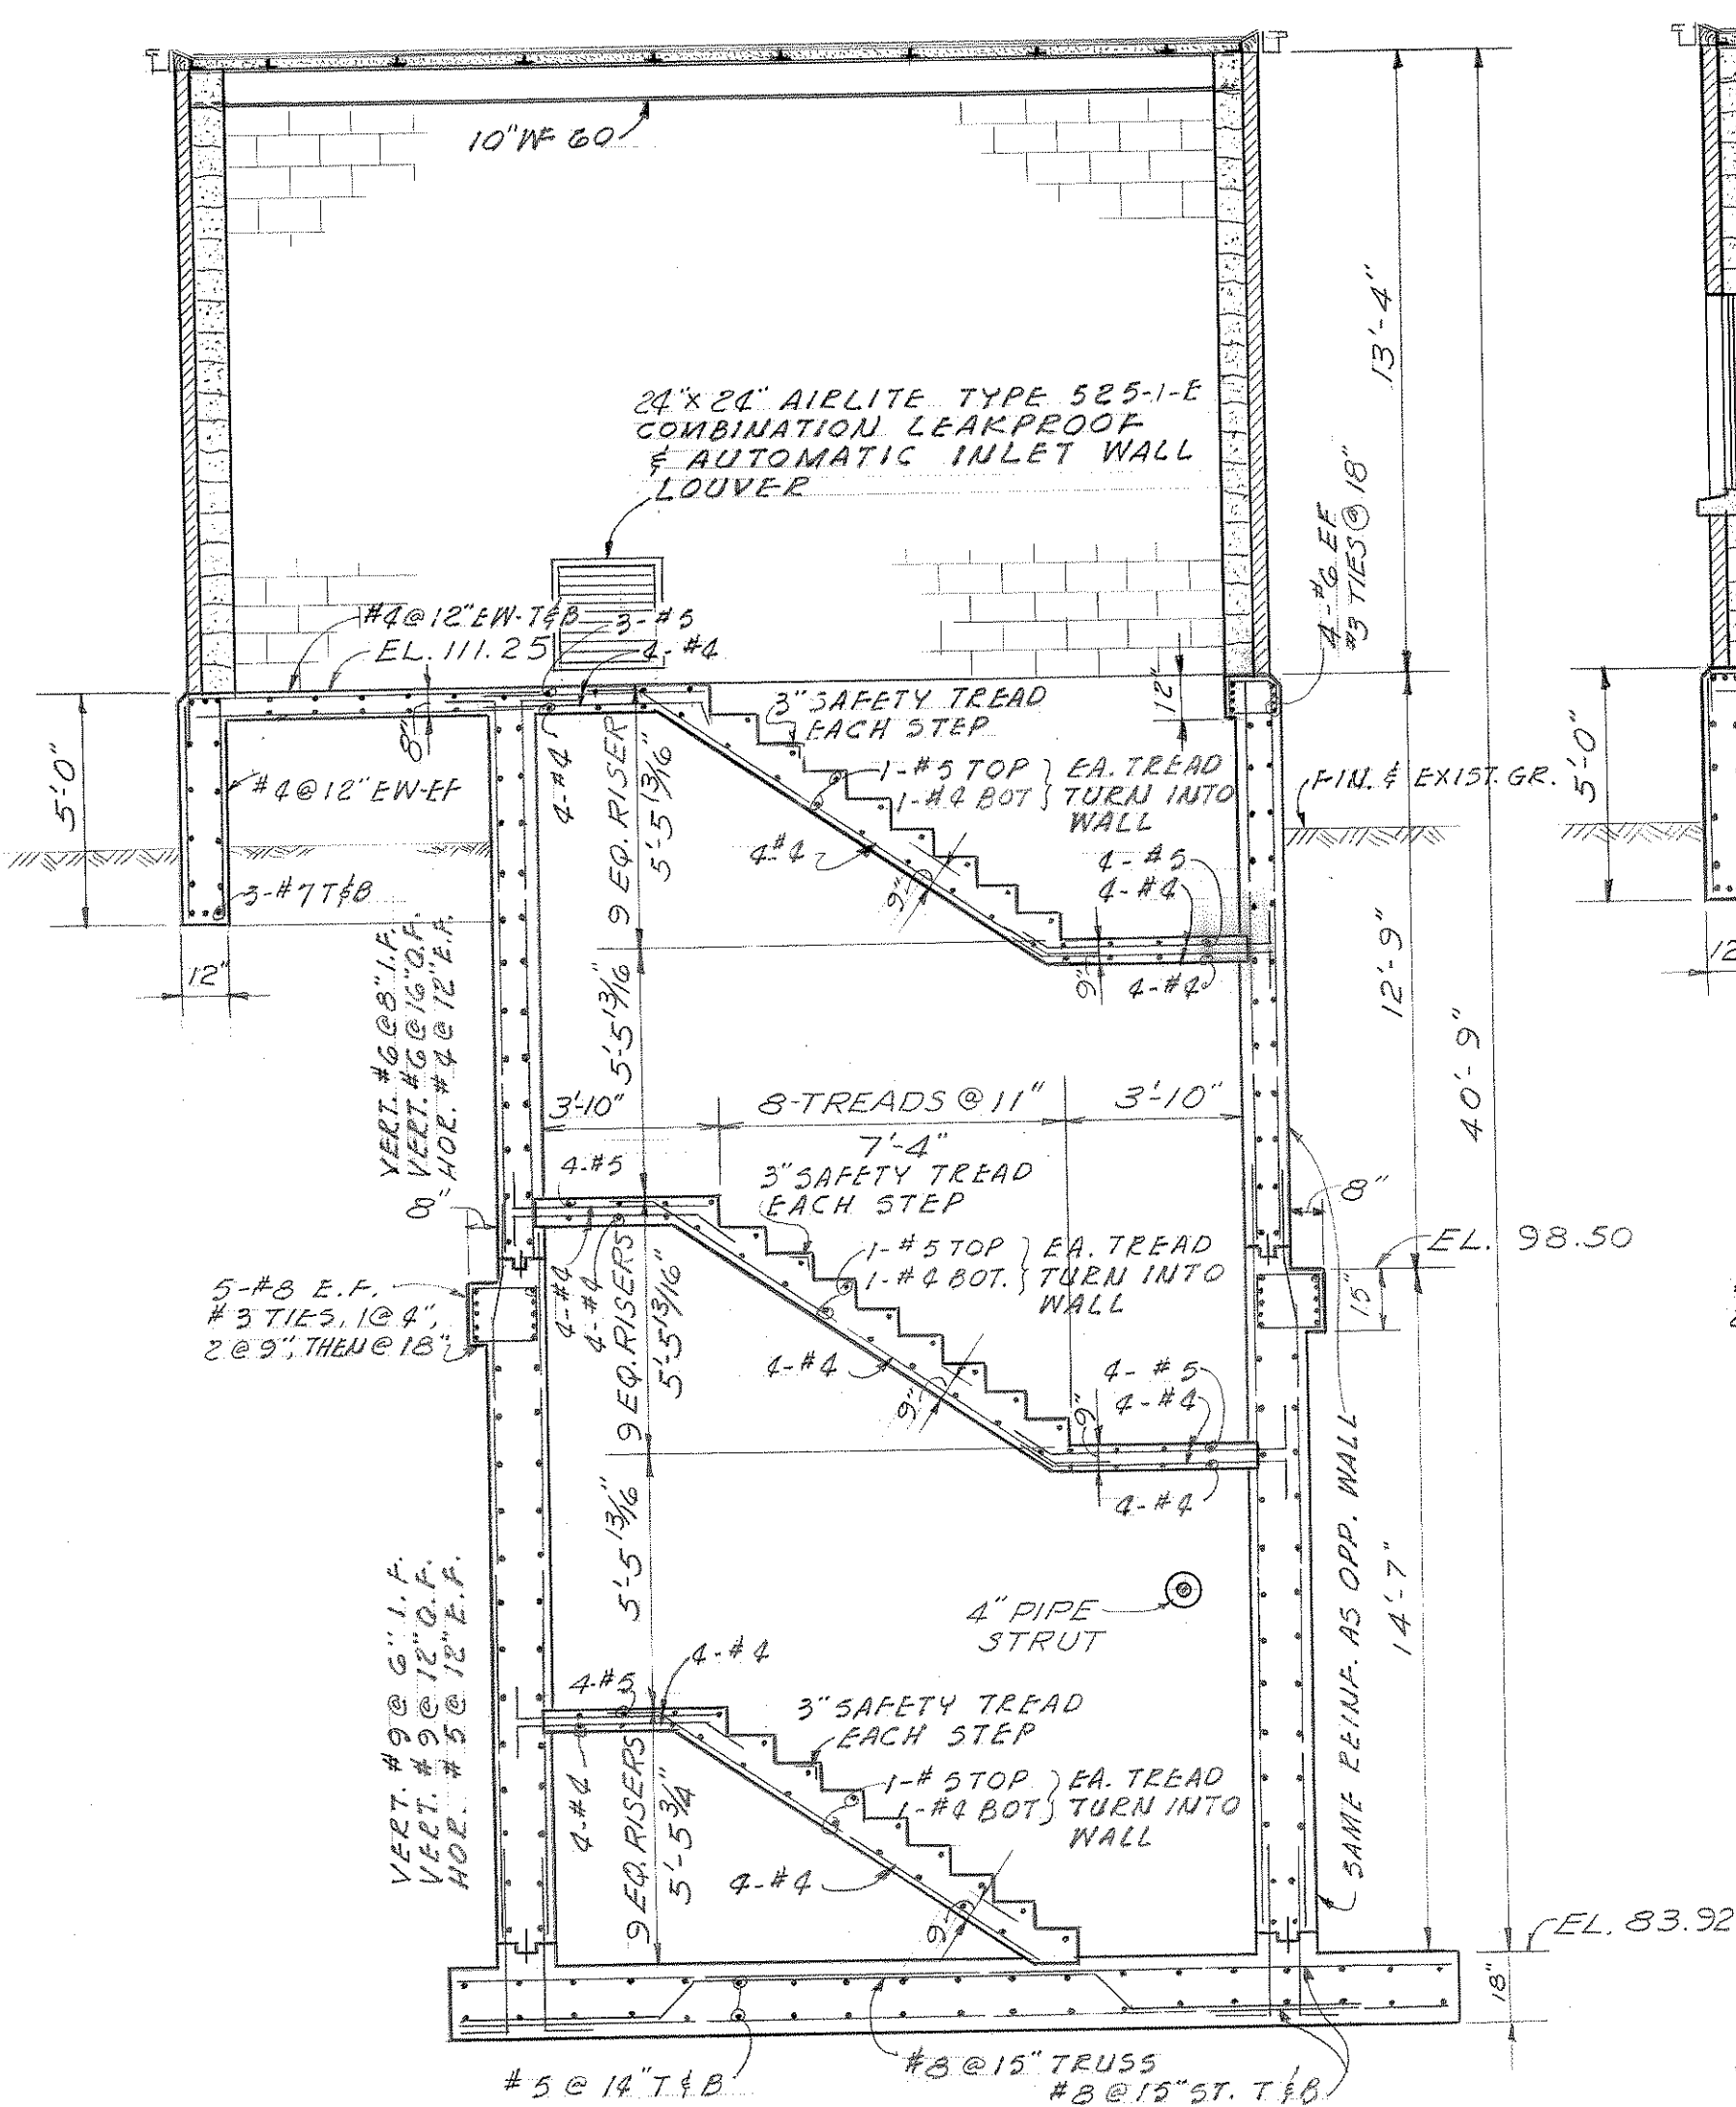


SECTION A-A

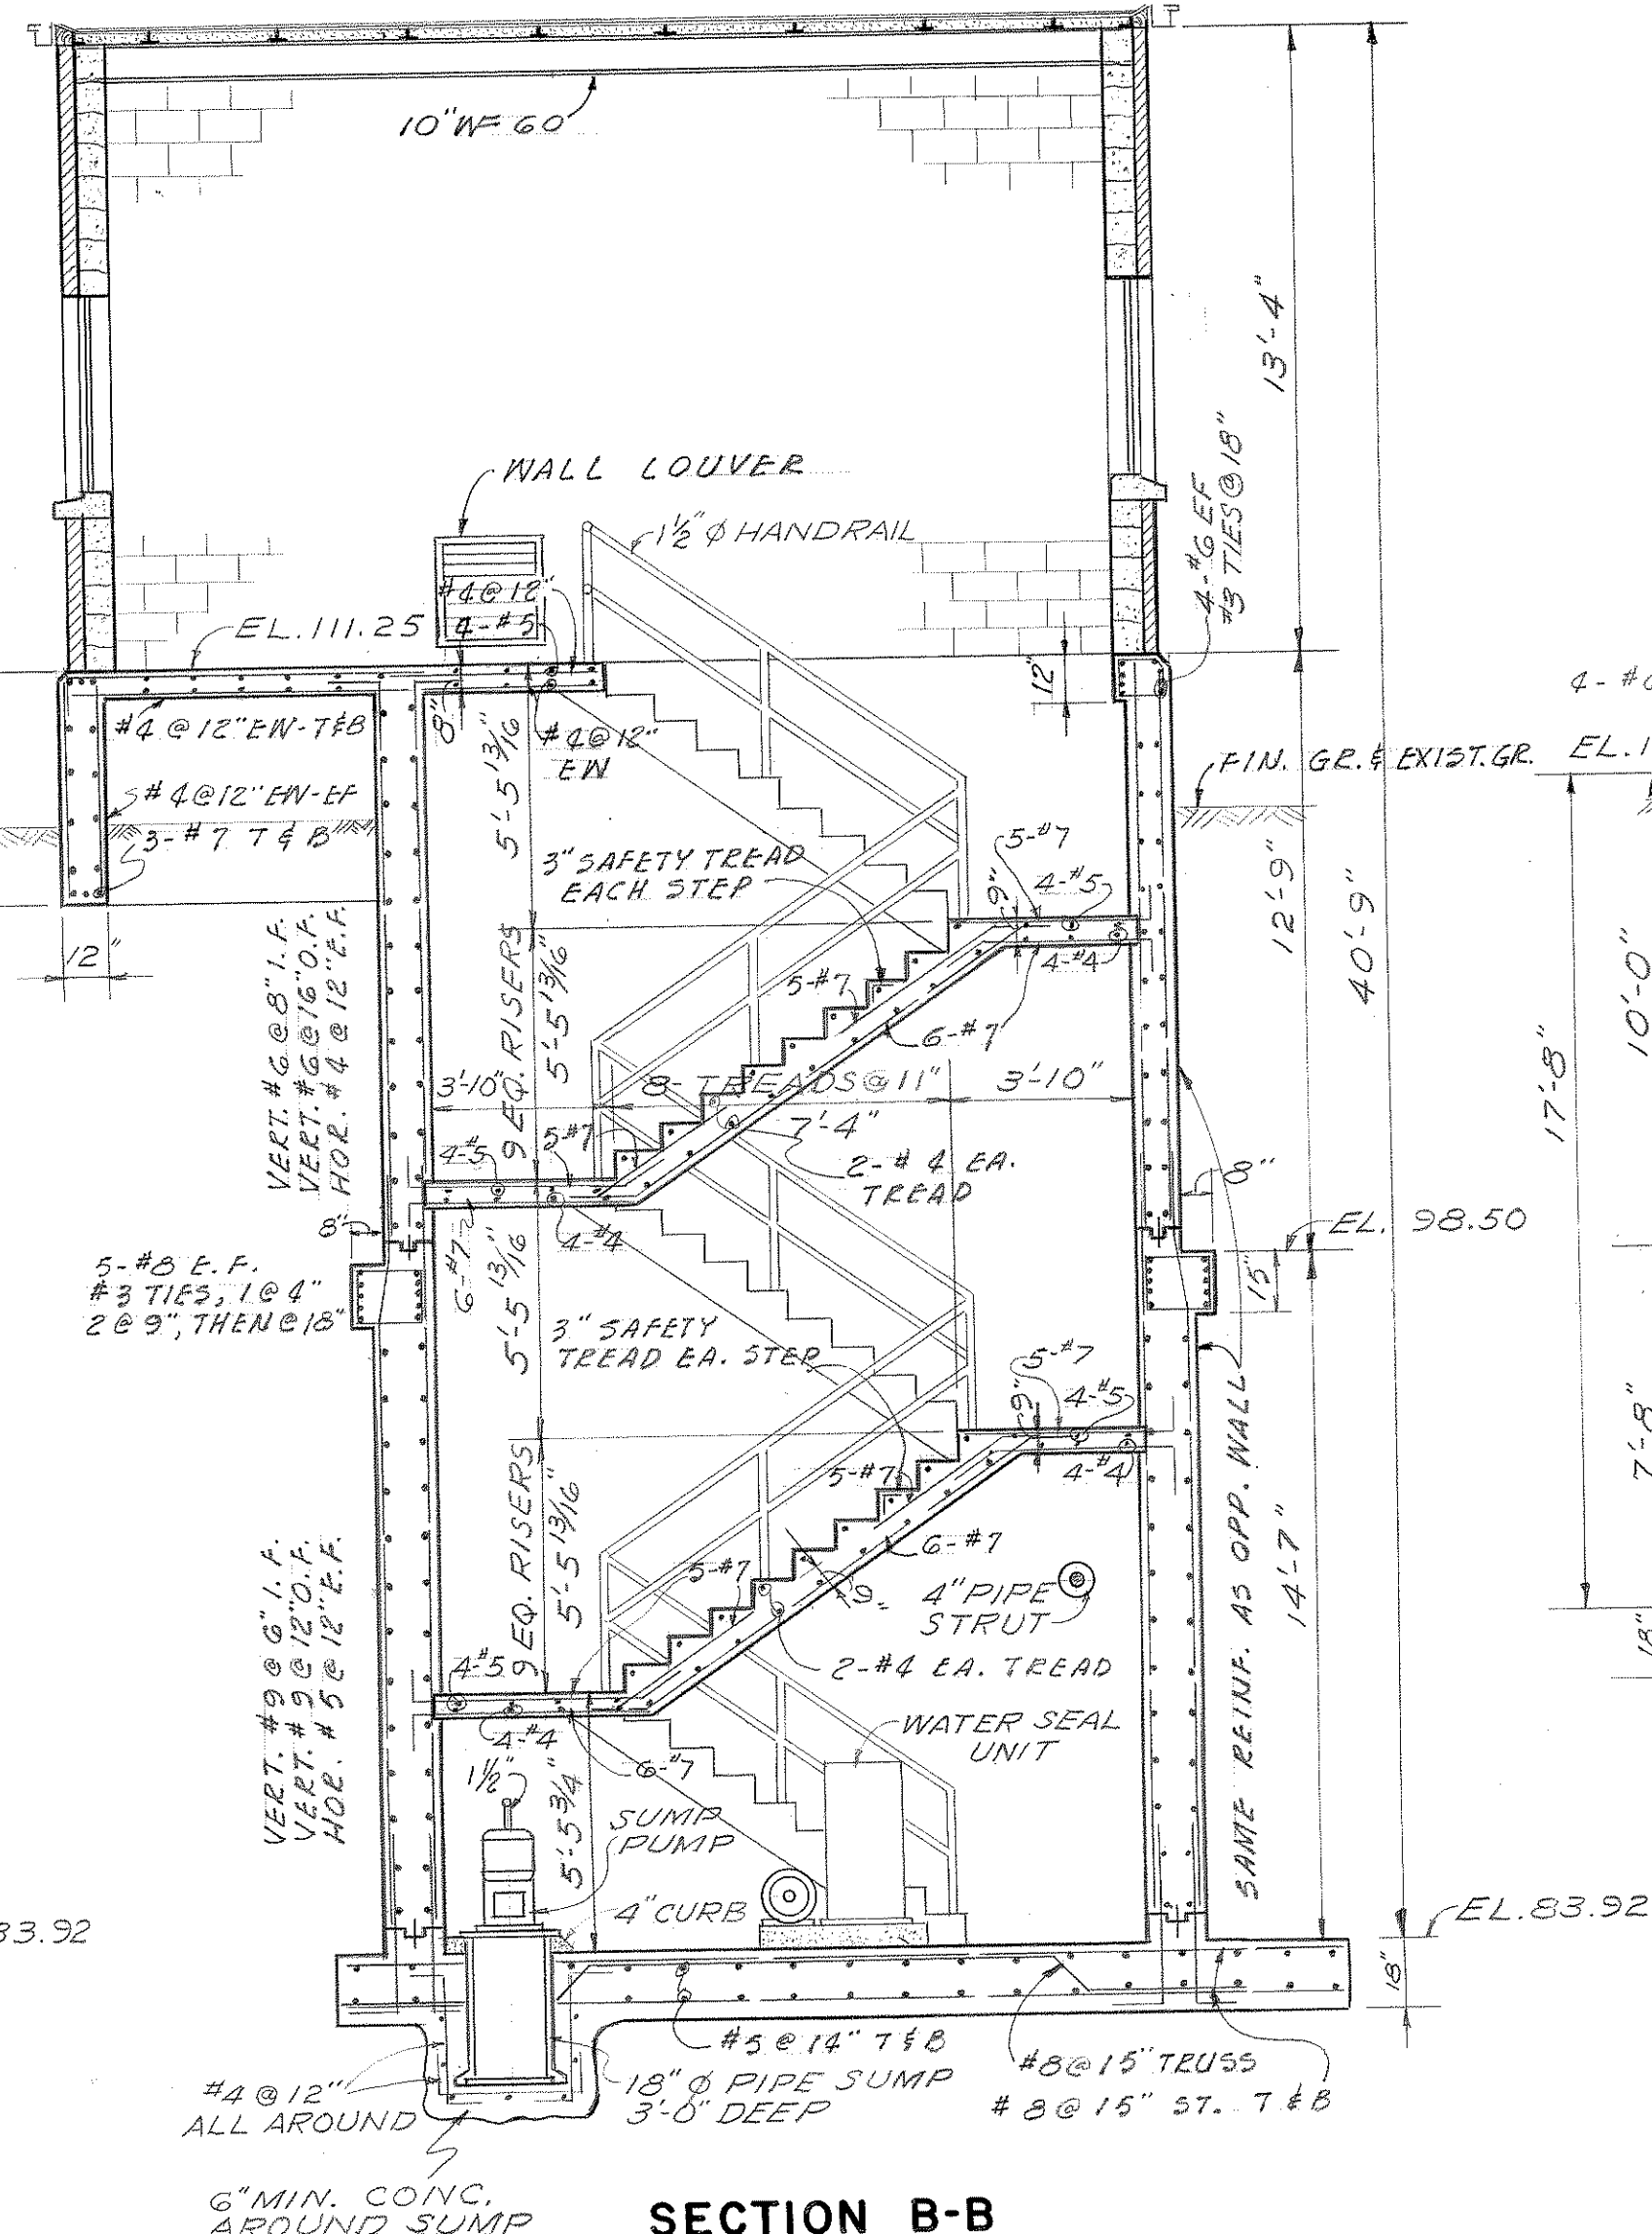


SECTION B-B

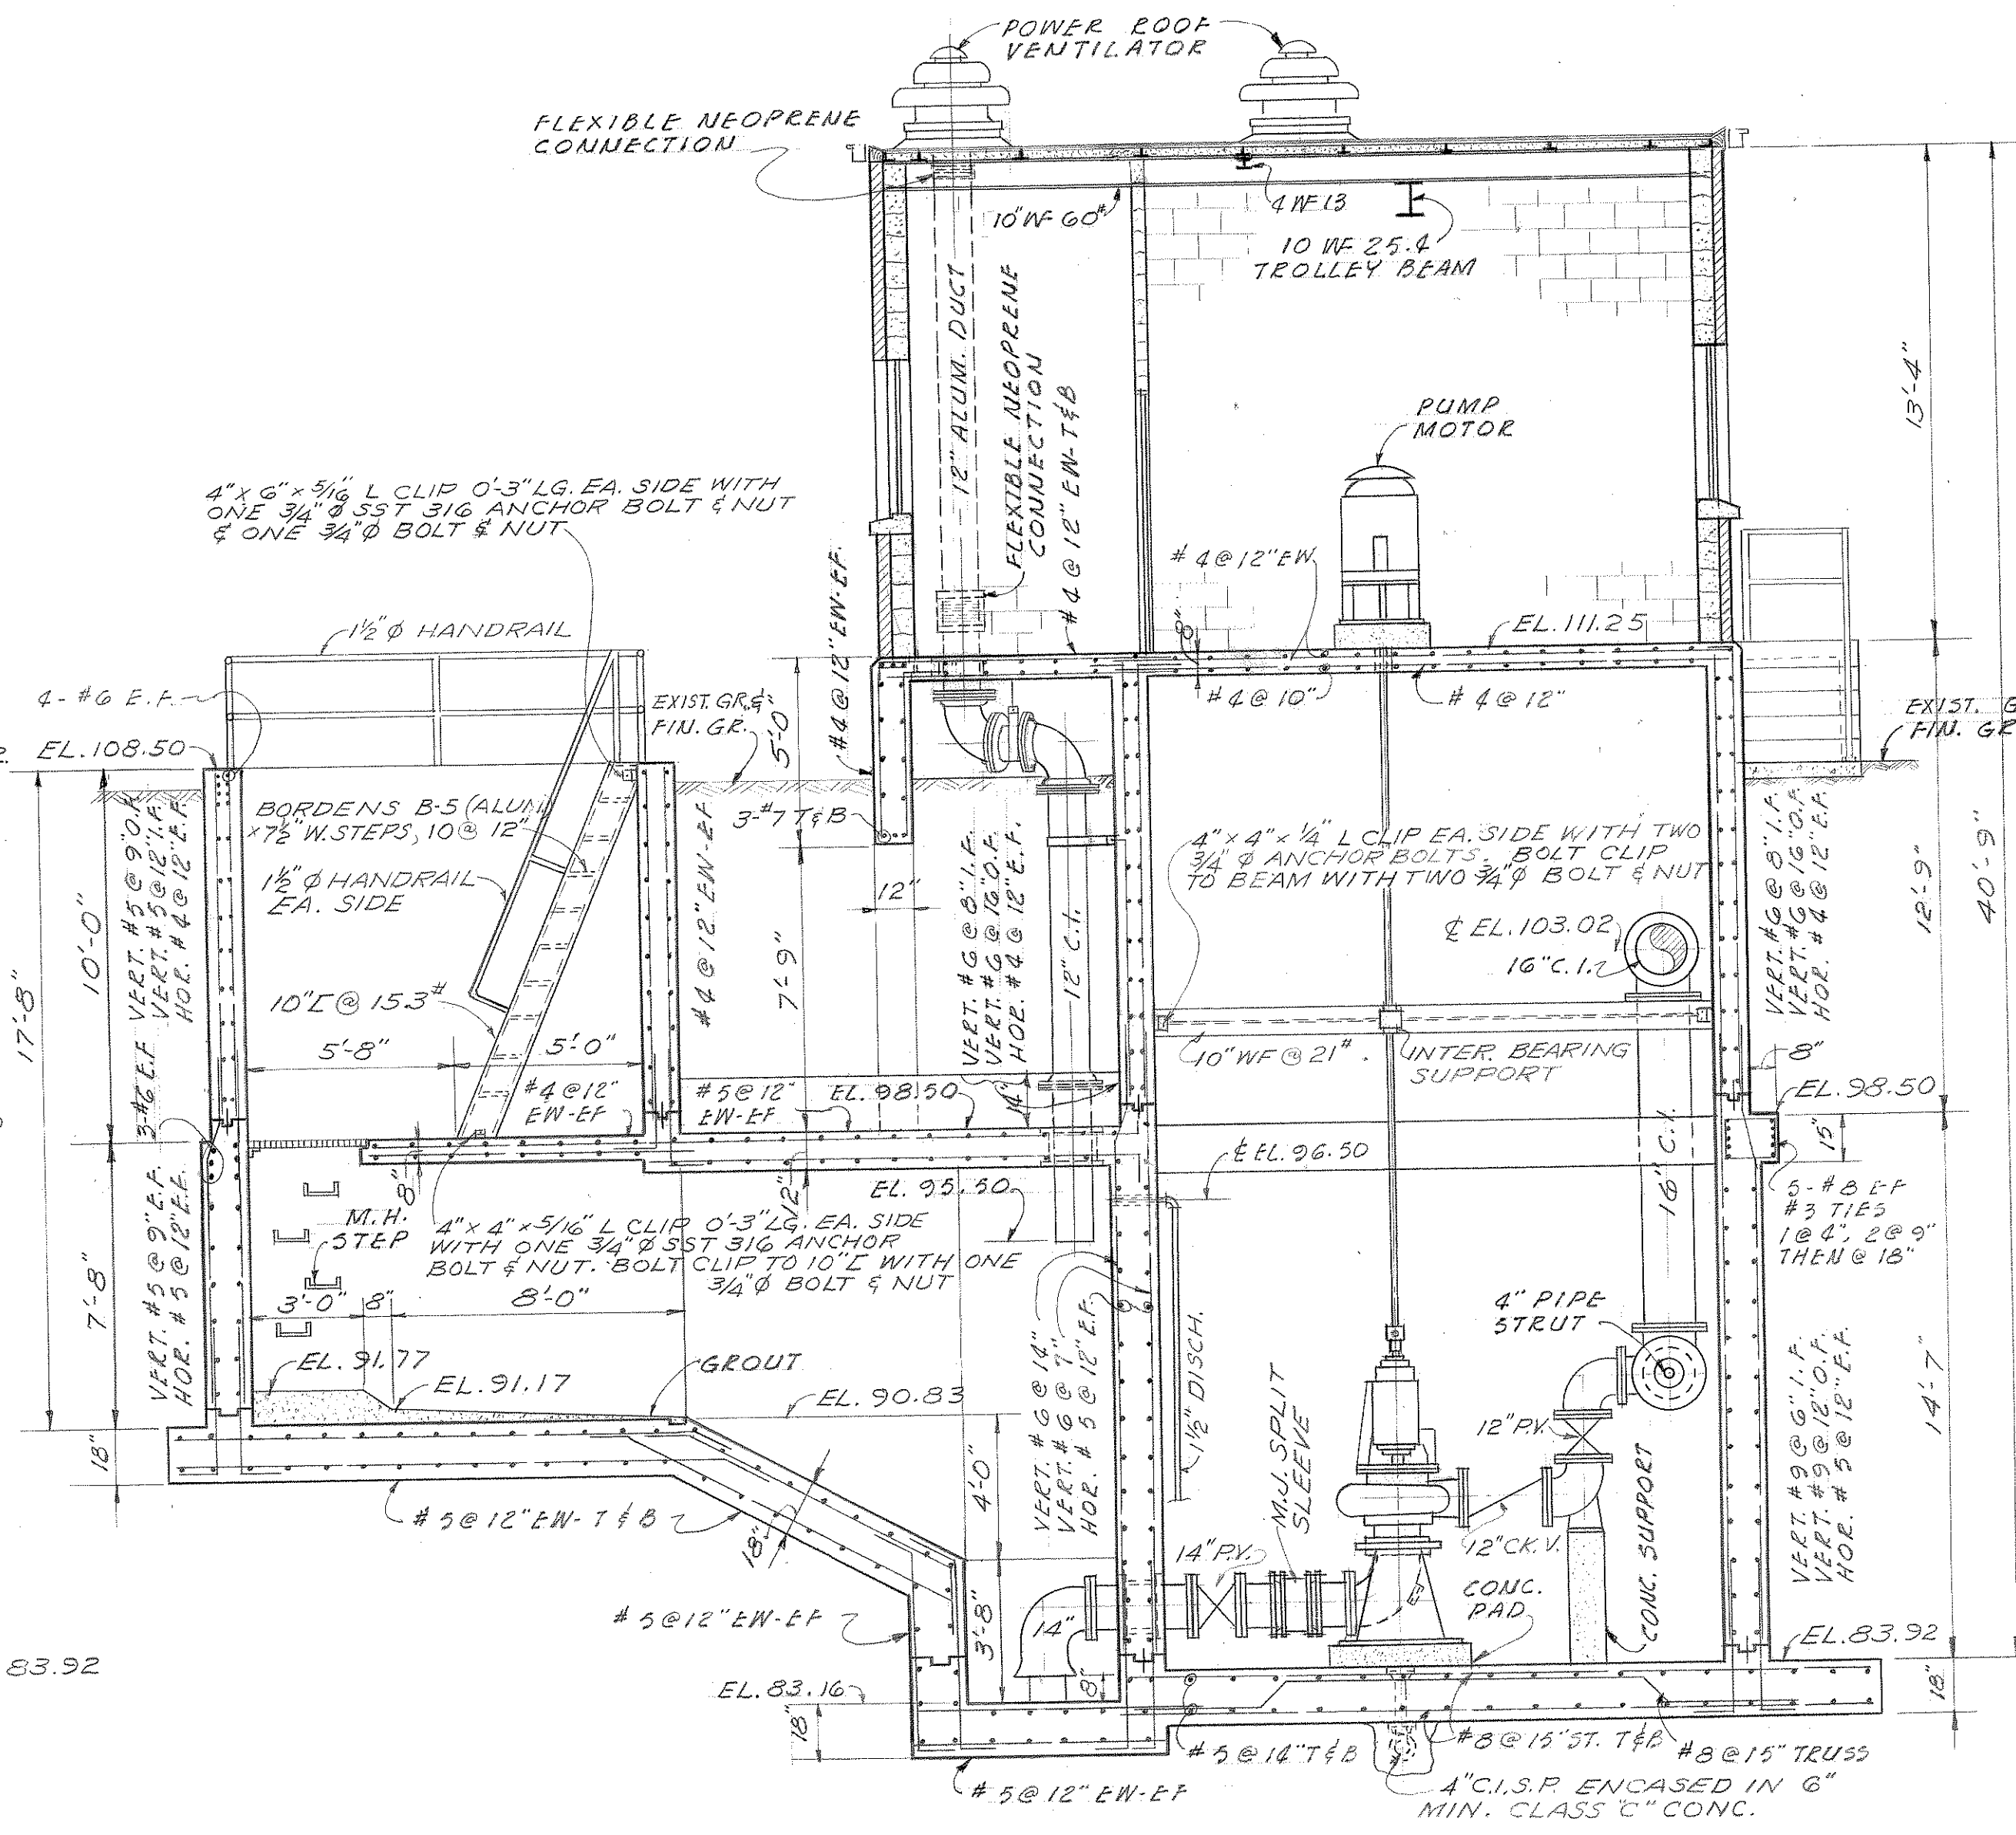


SECTION C-C

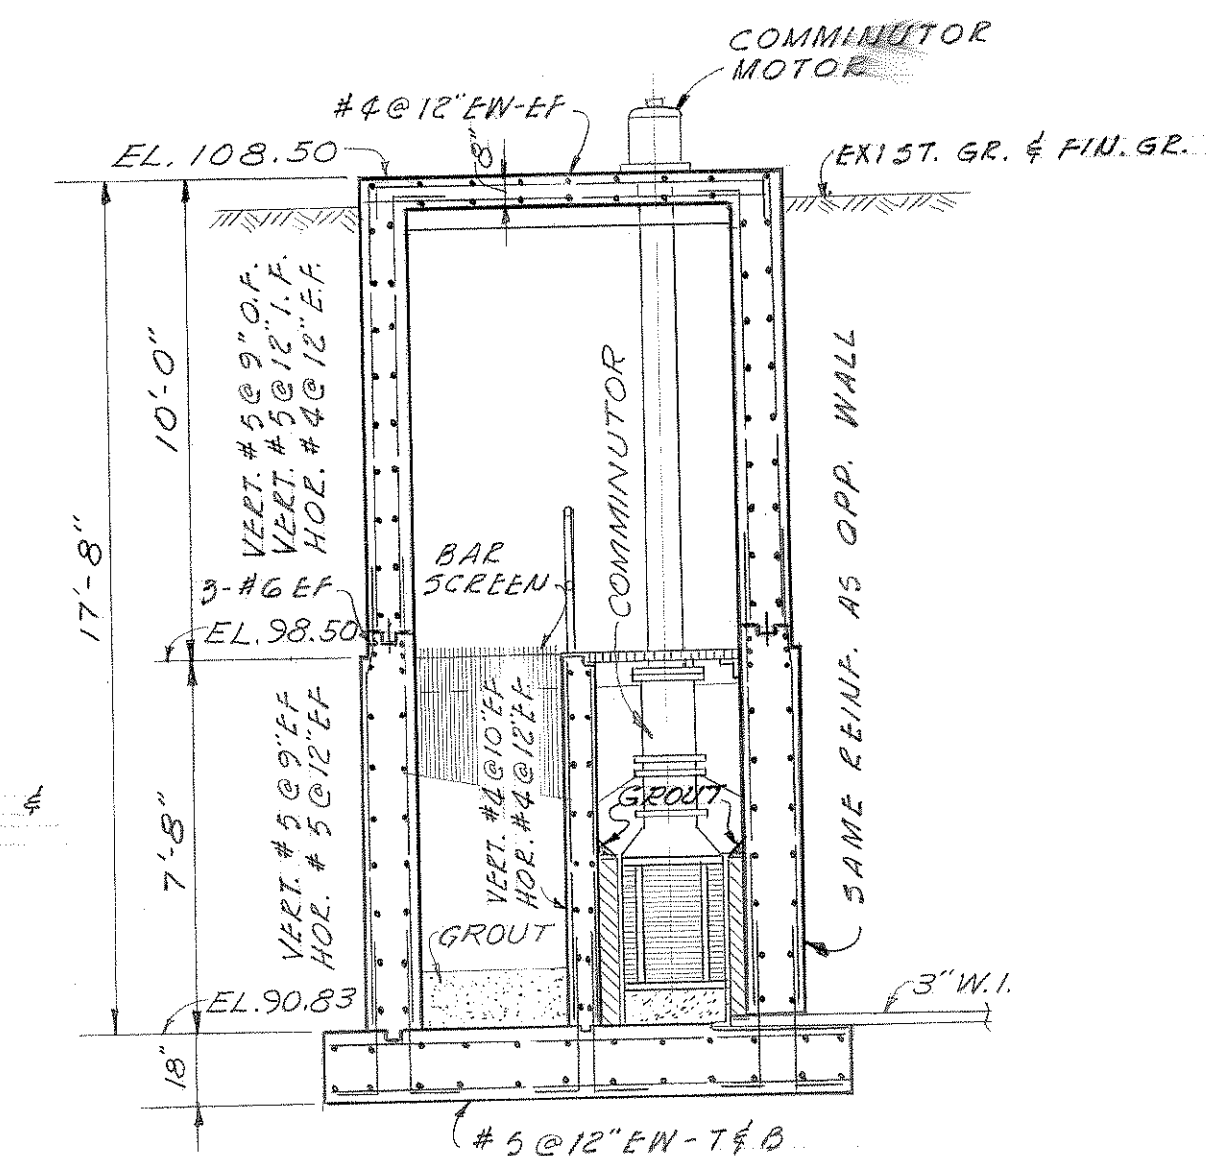


SECTION H-H

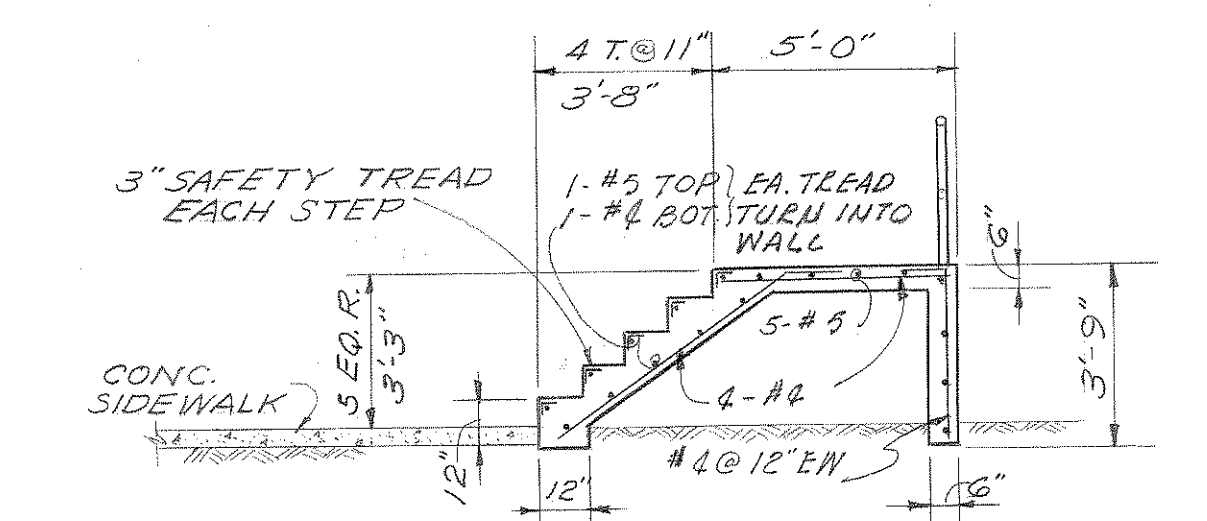


SECTION J-J

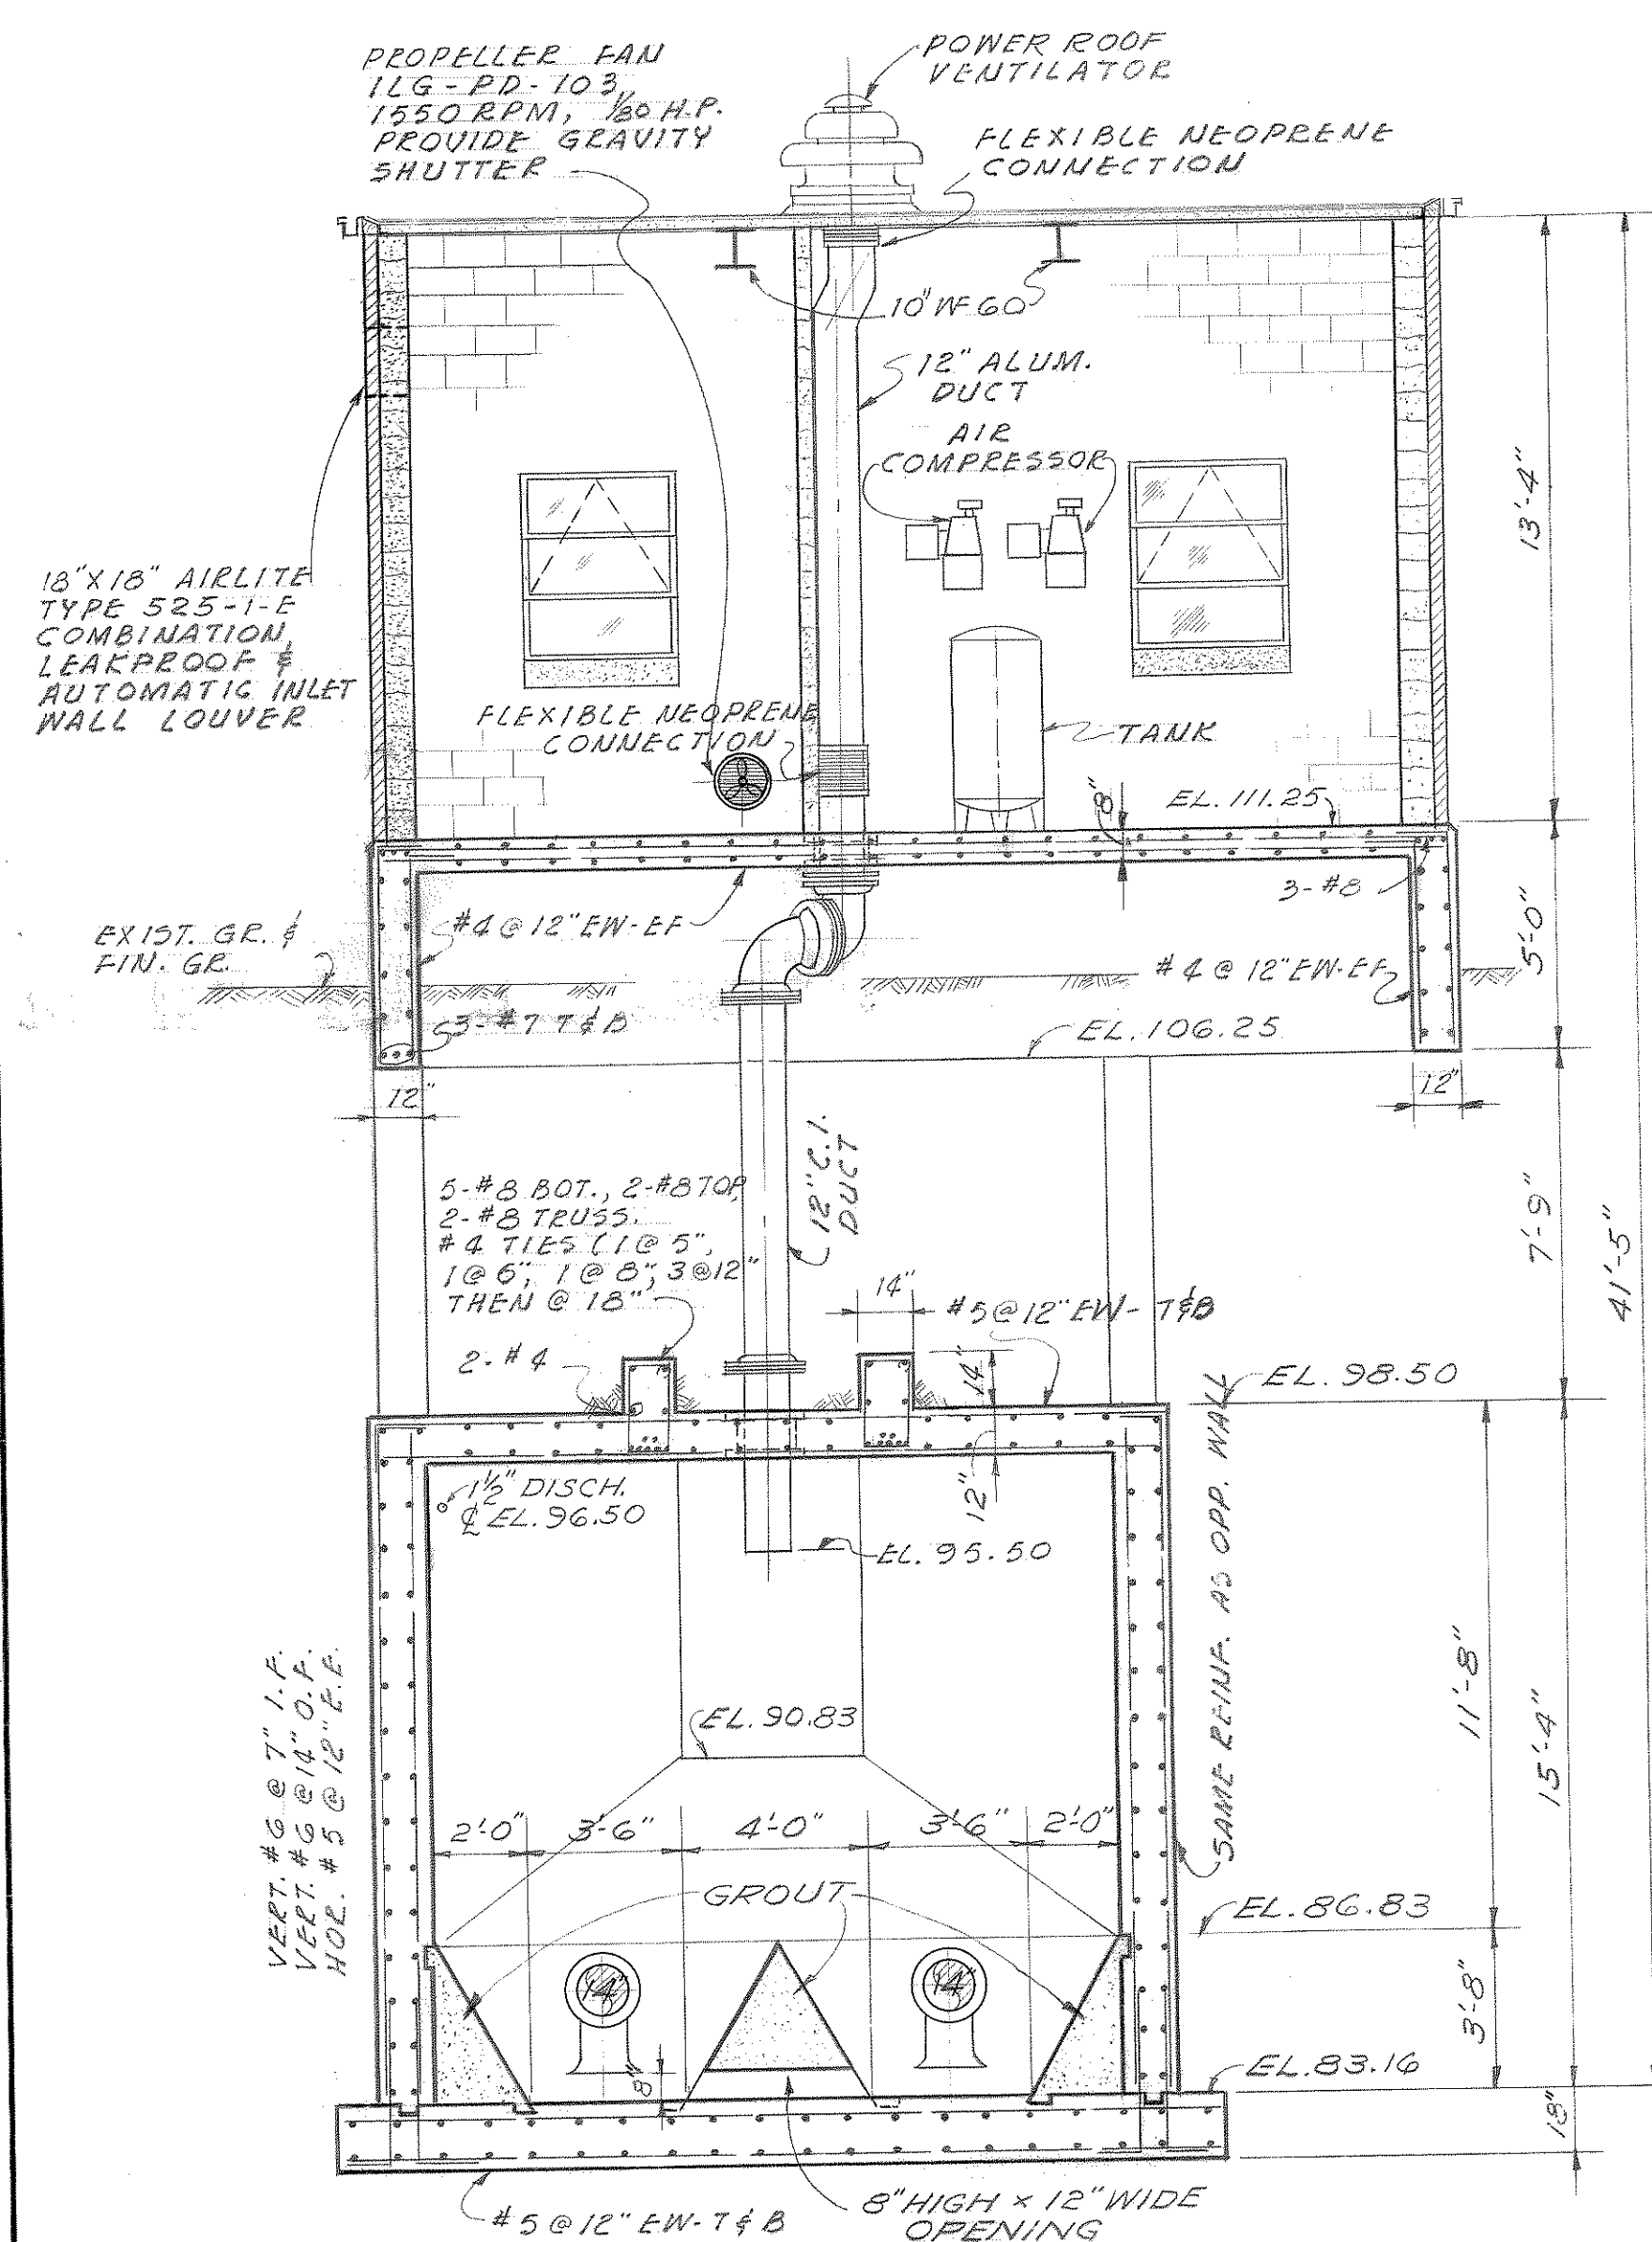


SECTION F-F

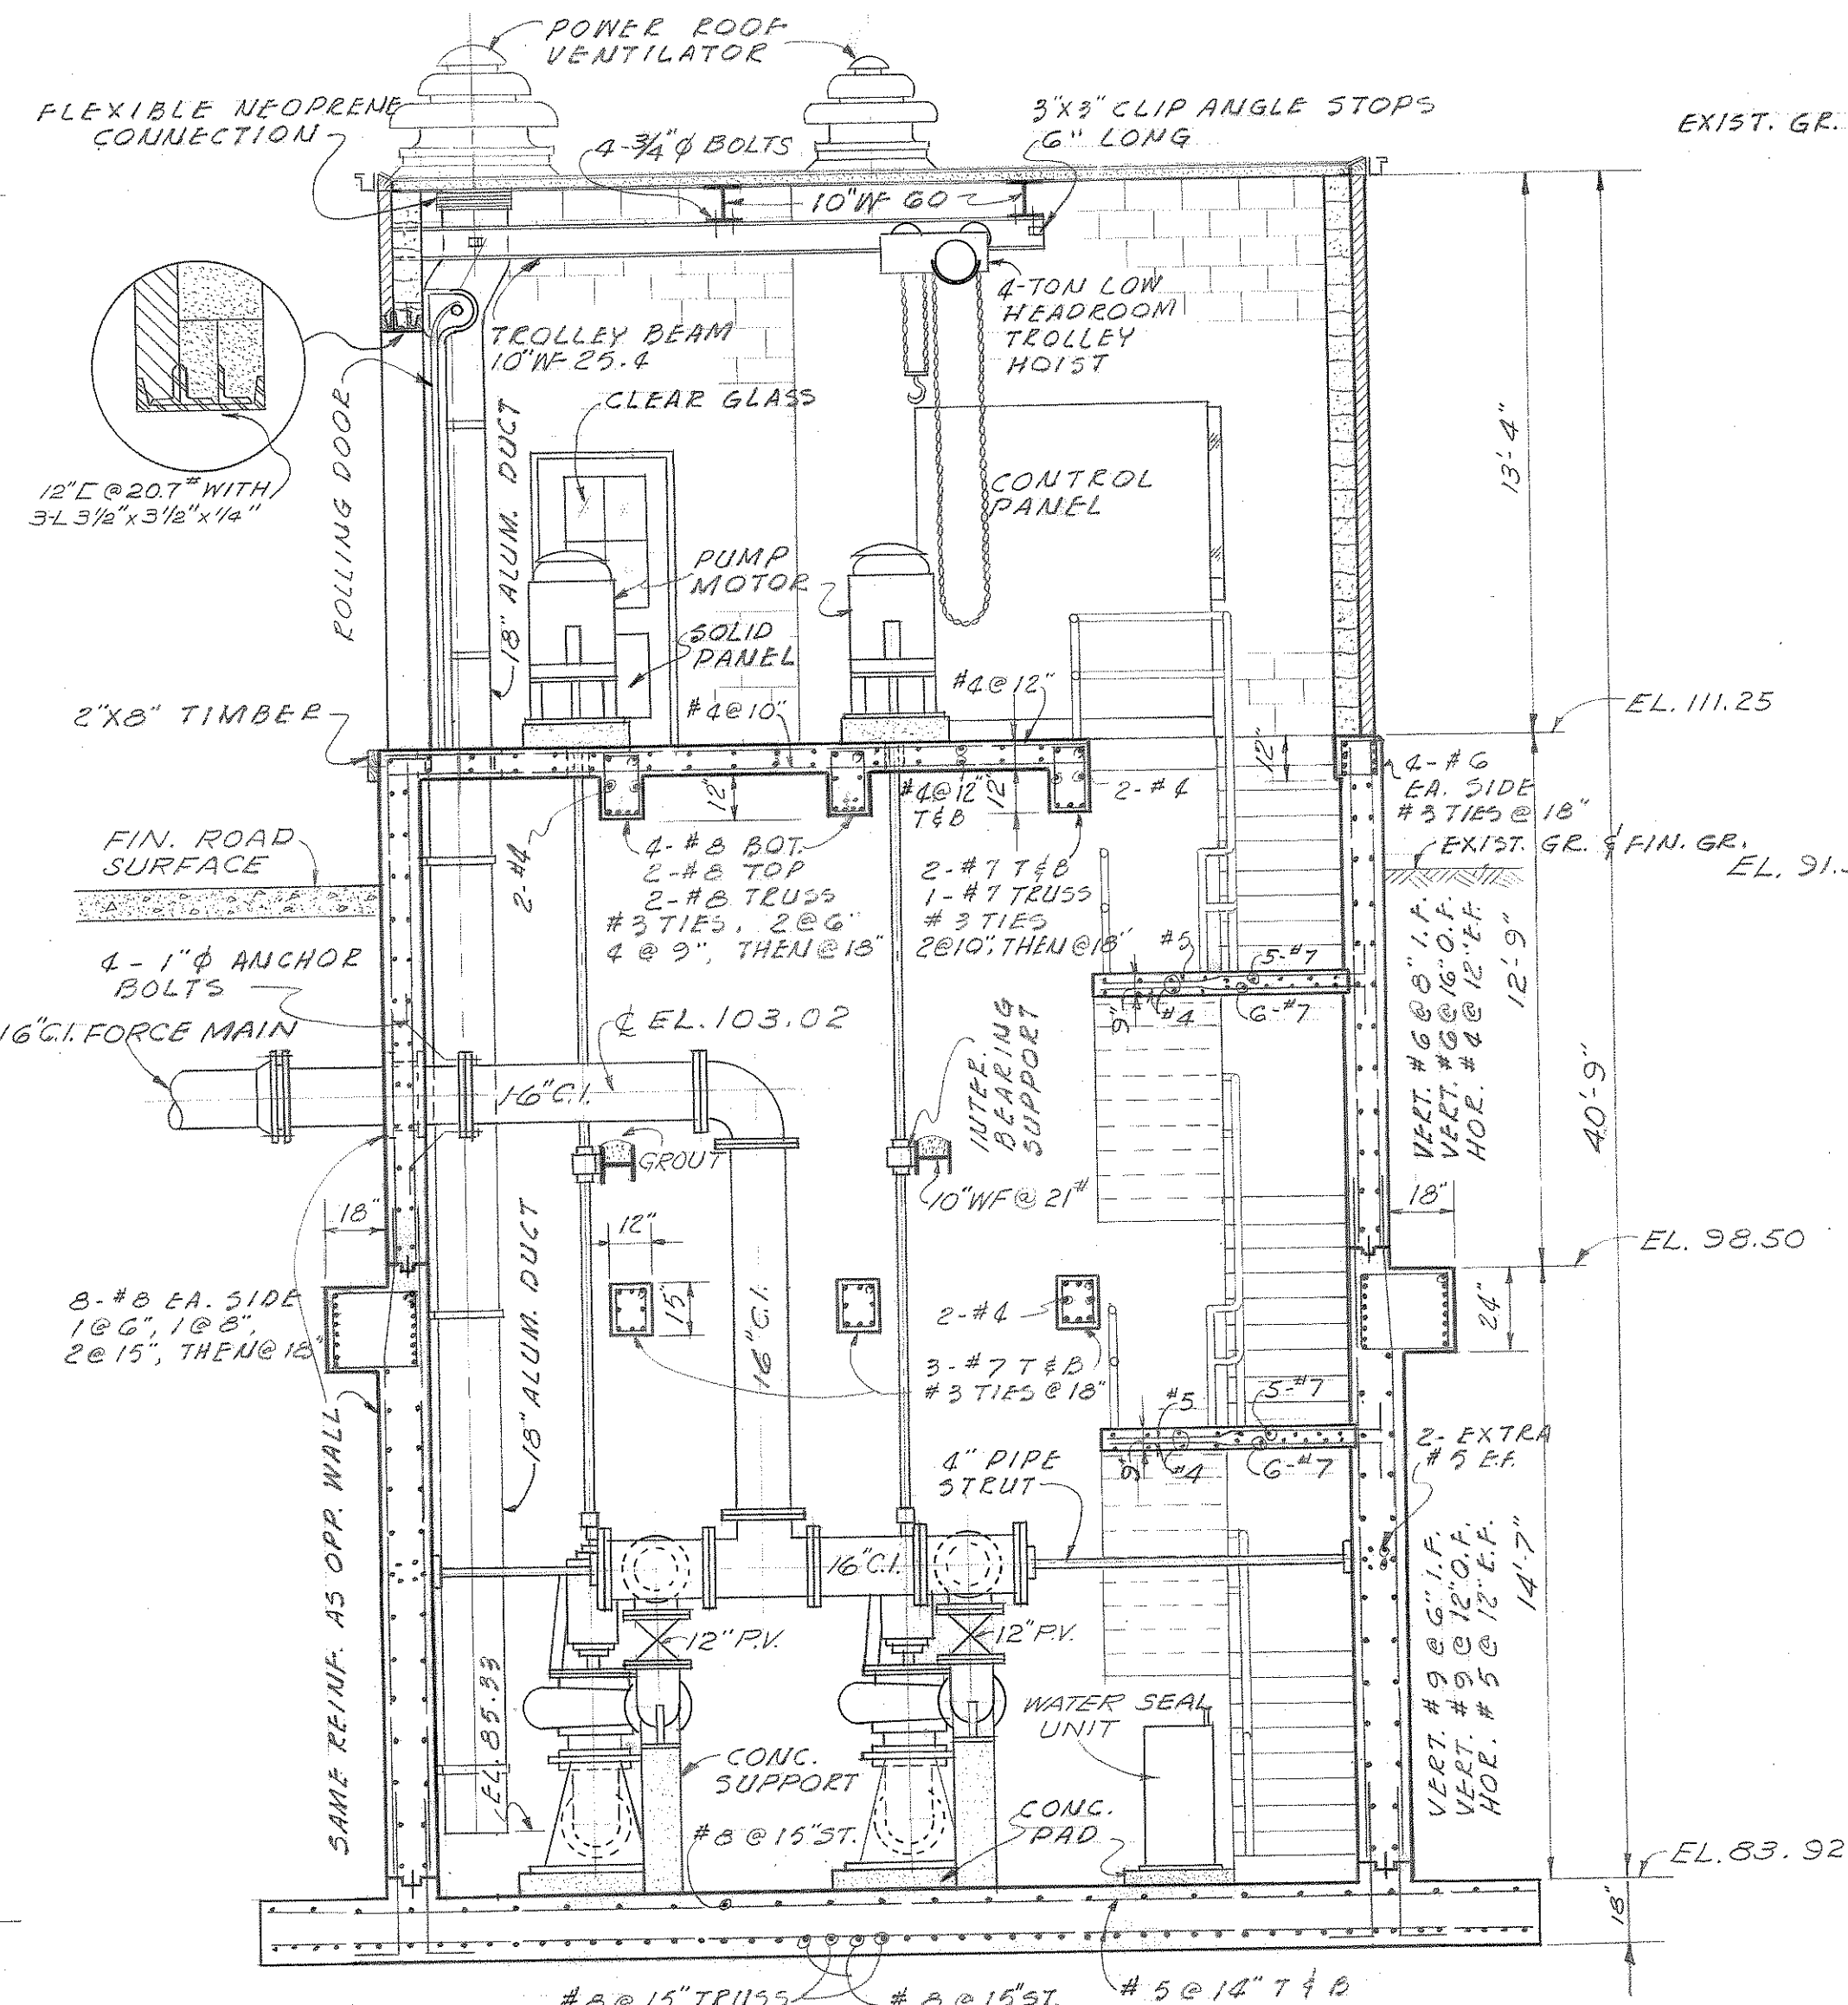

SECTION G-G

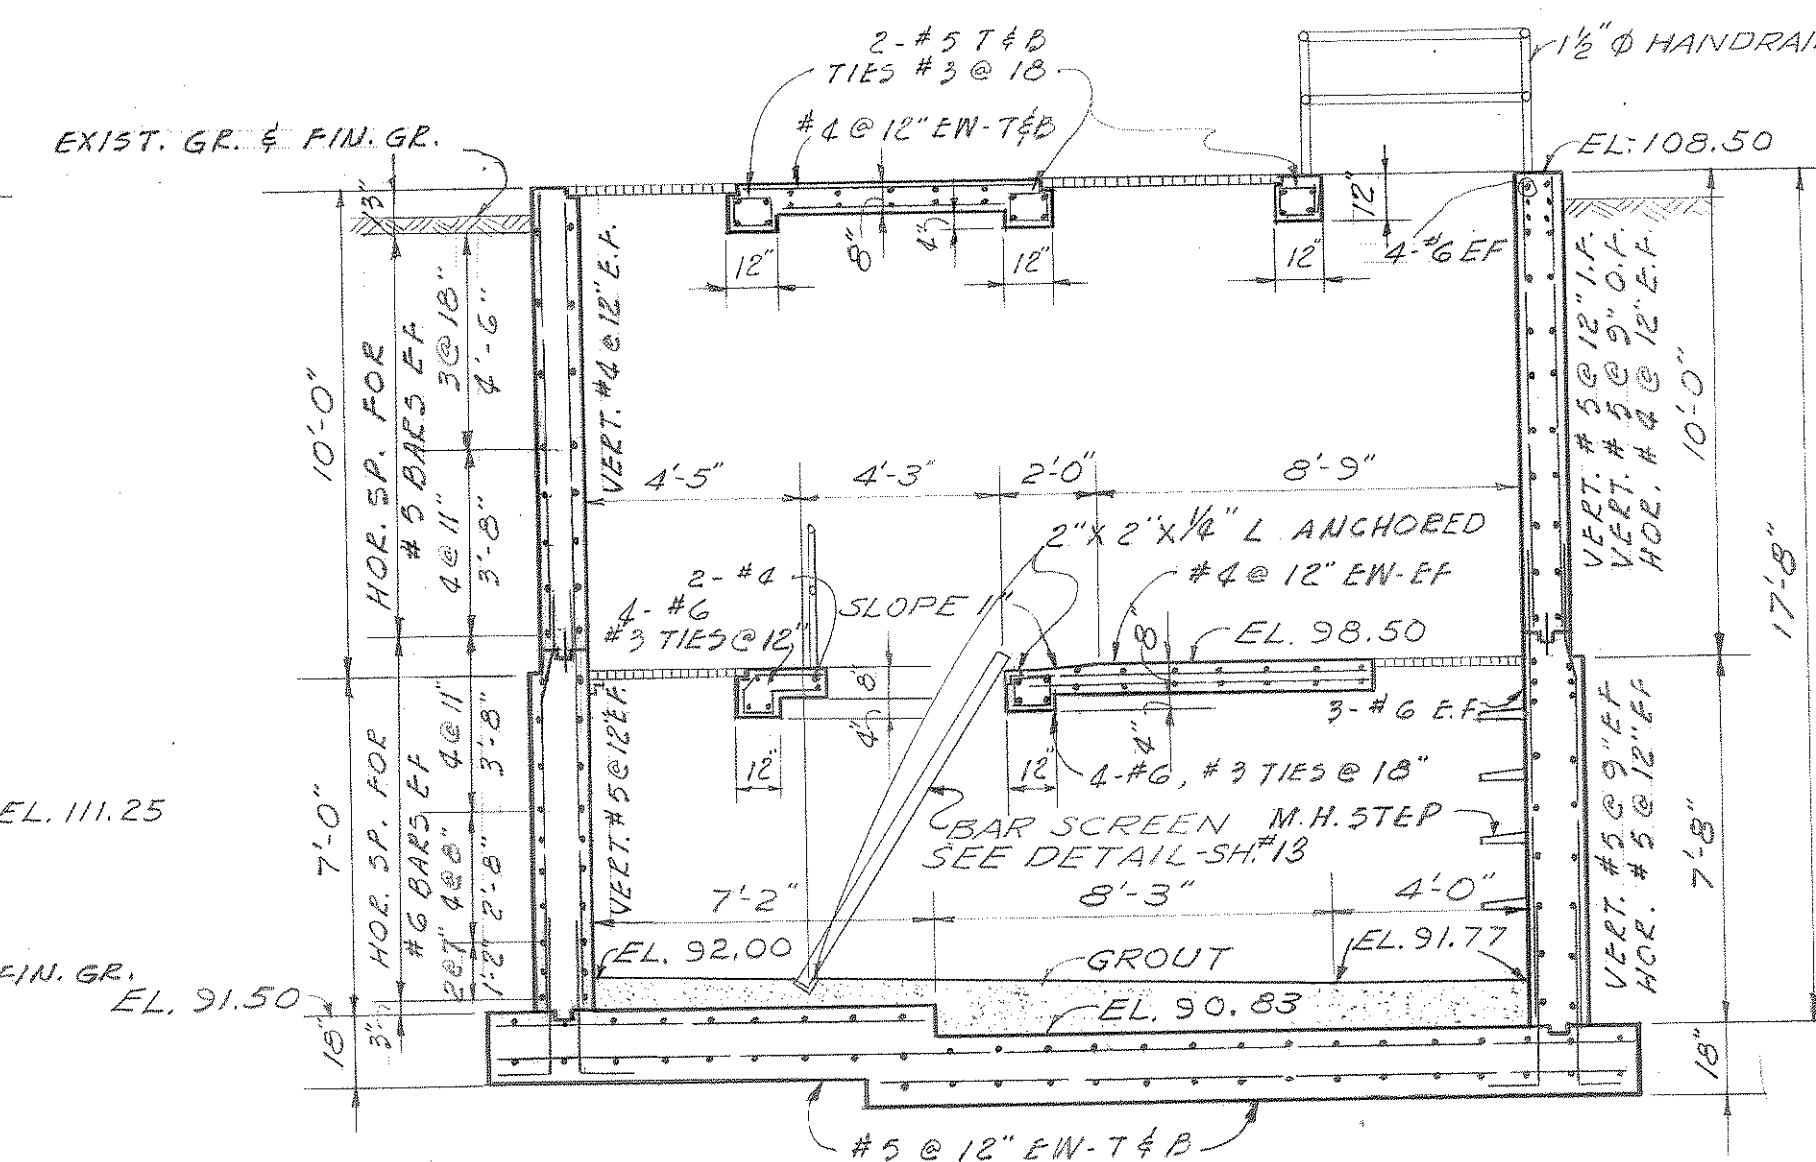

SECTION D-D

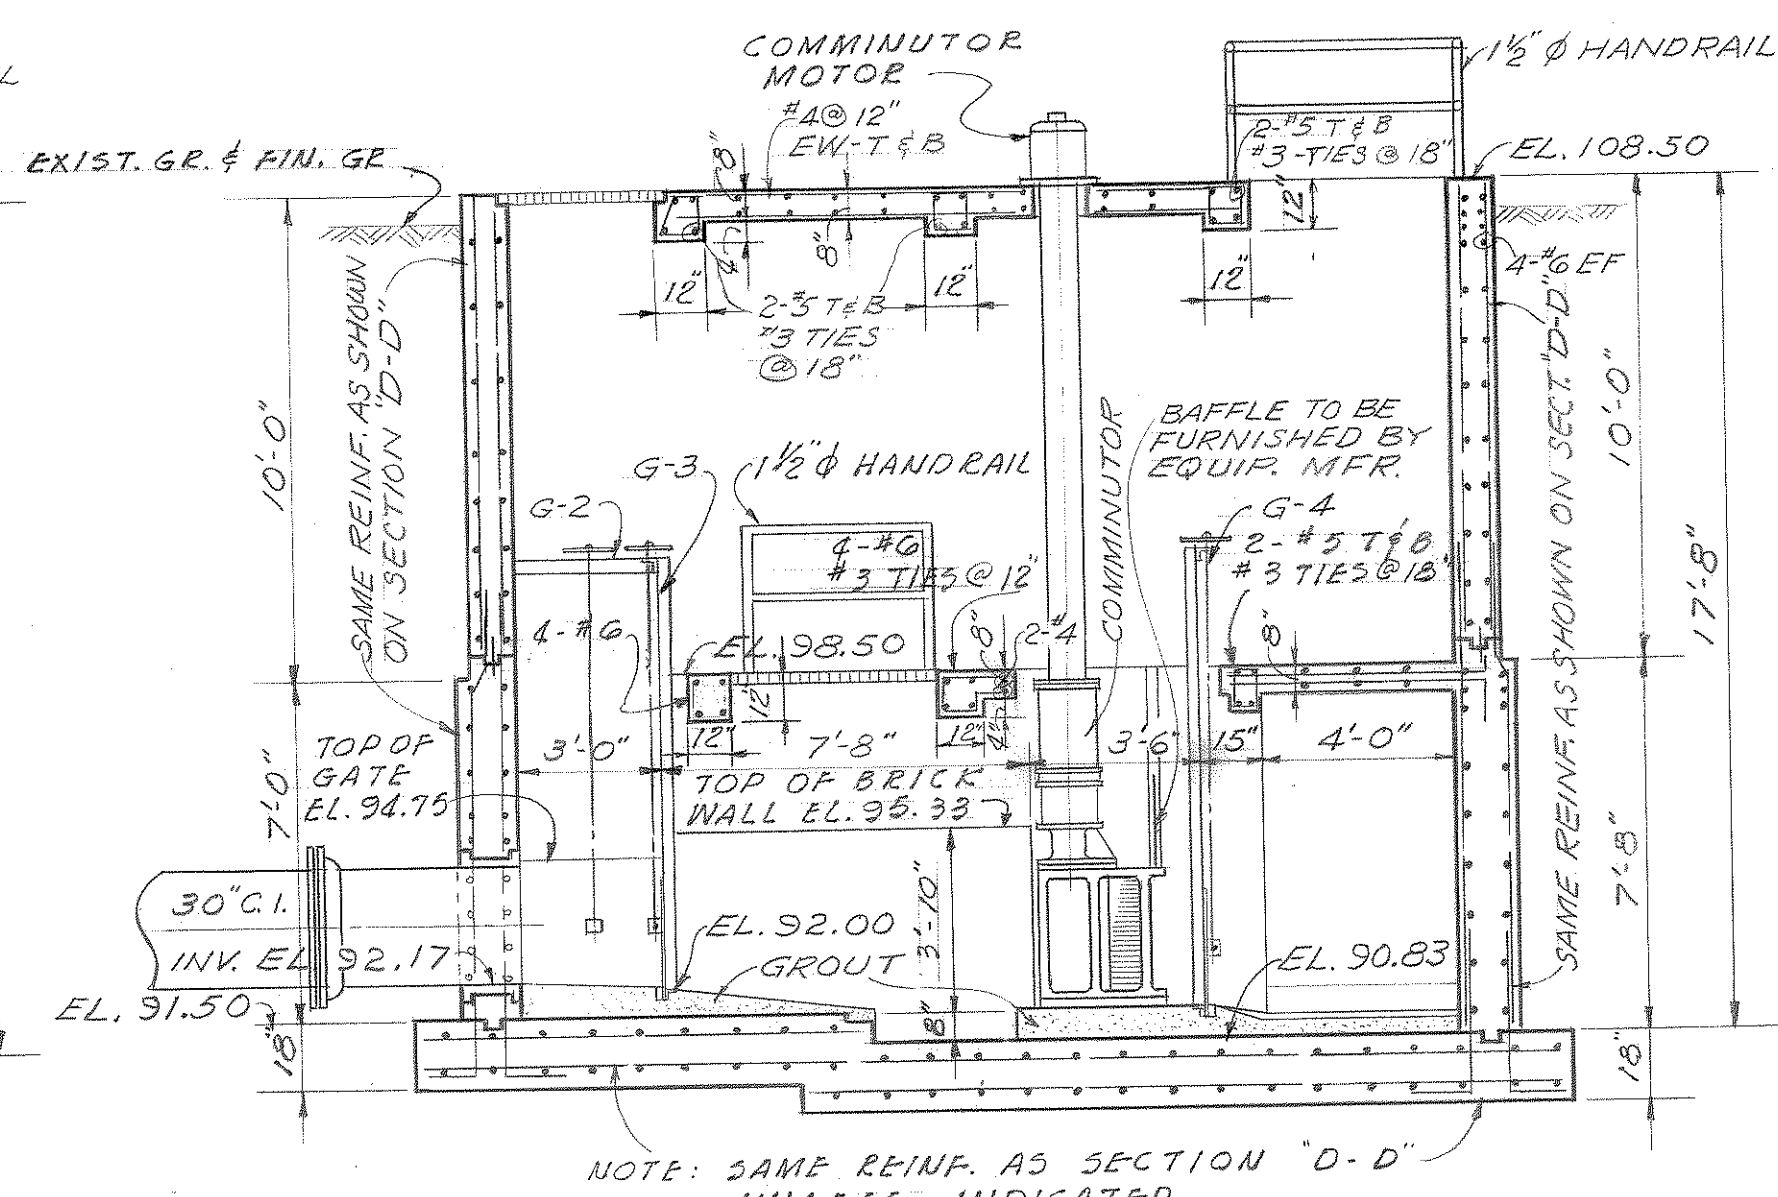

SECTION E-E

- NOTE:**
1. PROVIDE #4@12" FOR CONCRETE PIERES OR FOUNDATIONS FOR ALL PUMPS, BASE ELLS AND PIPING. EXTEND PIERS UNDER PIPING UP TO MIDPOINT OF PIPE.
 2. FOR TYPICAL WALL SECTION SEE SHEET N-7

CONTRACT 'C'

**CITY OF BRUNSWICK, GEORGIA
SEWERAGE SYSTEM IMPROVEMENTS**

**RAW SEWAGE
PUMPING STATION NO. 2**






DATUM EQUALS U.S.P.F.S. MEAN
SEA LEVEL PLUS 100.00 FT.

SCALE
1/4" = 1'-0"
DATE
JULY, 1963

WIEDEMAN AND SINGLETON
ENGINEERS
ATLANTA

GEORGIA
SHEET
5
OF 15

REVISED DEC 1963

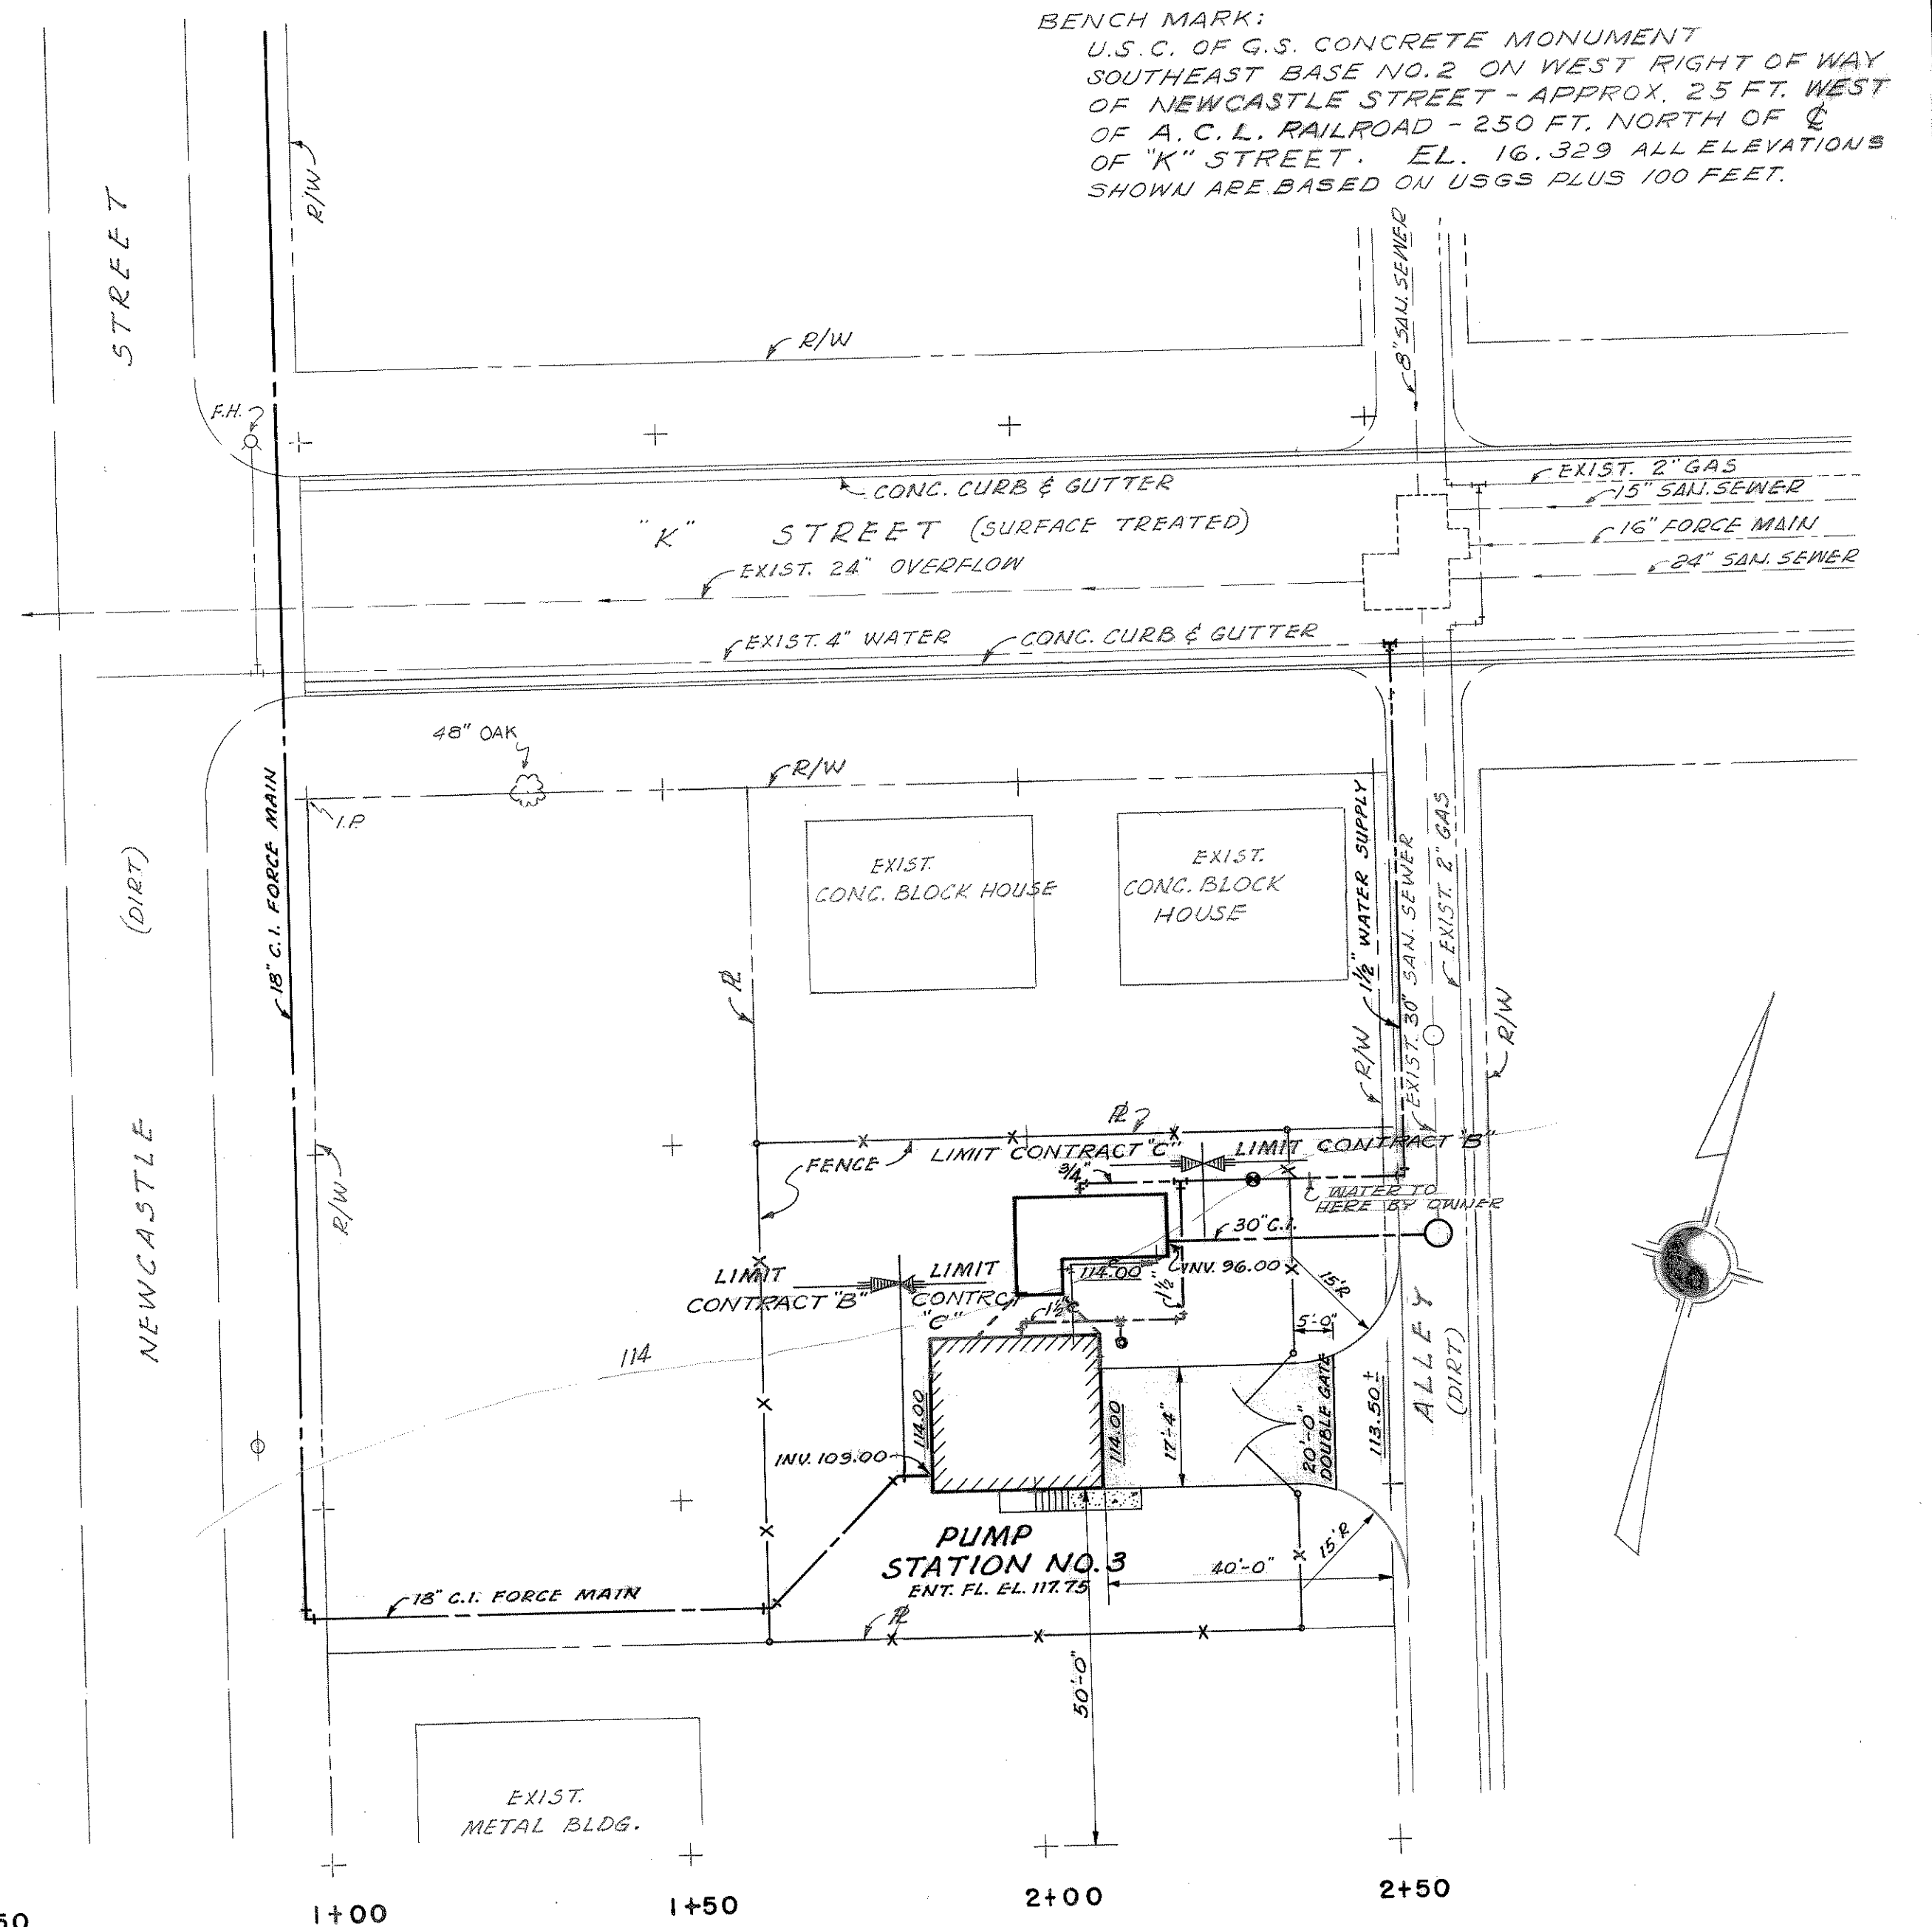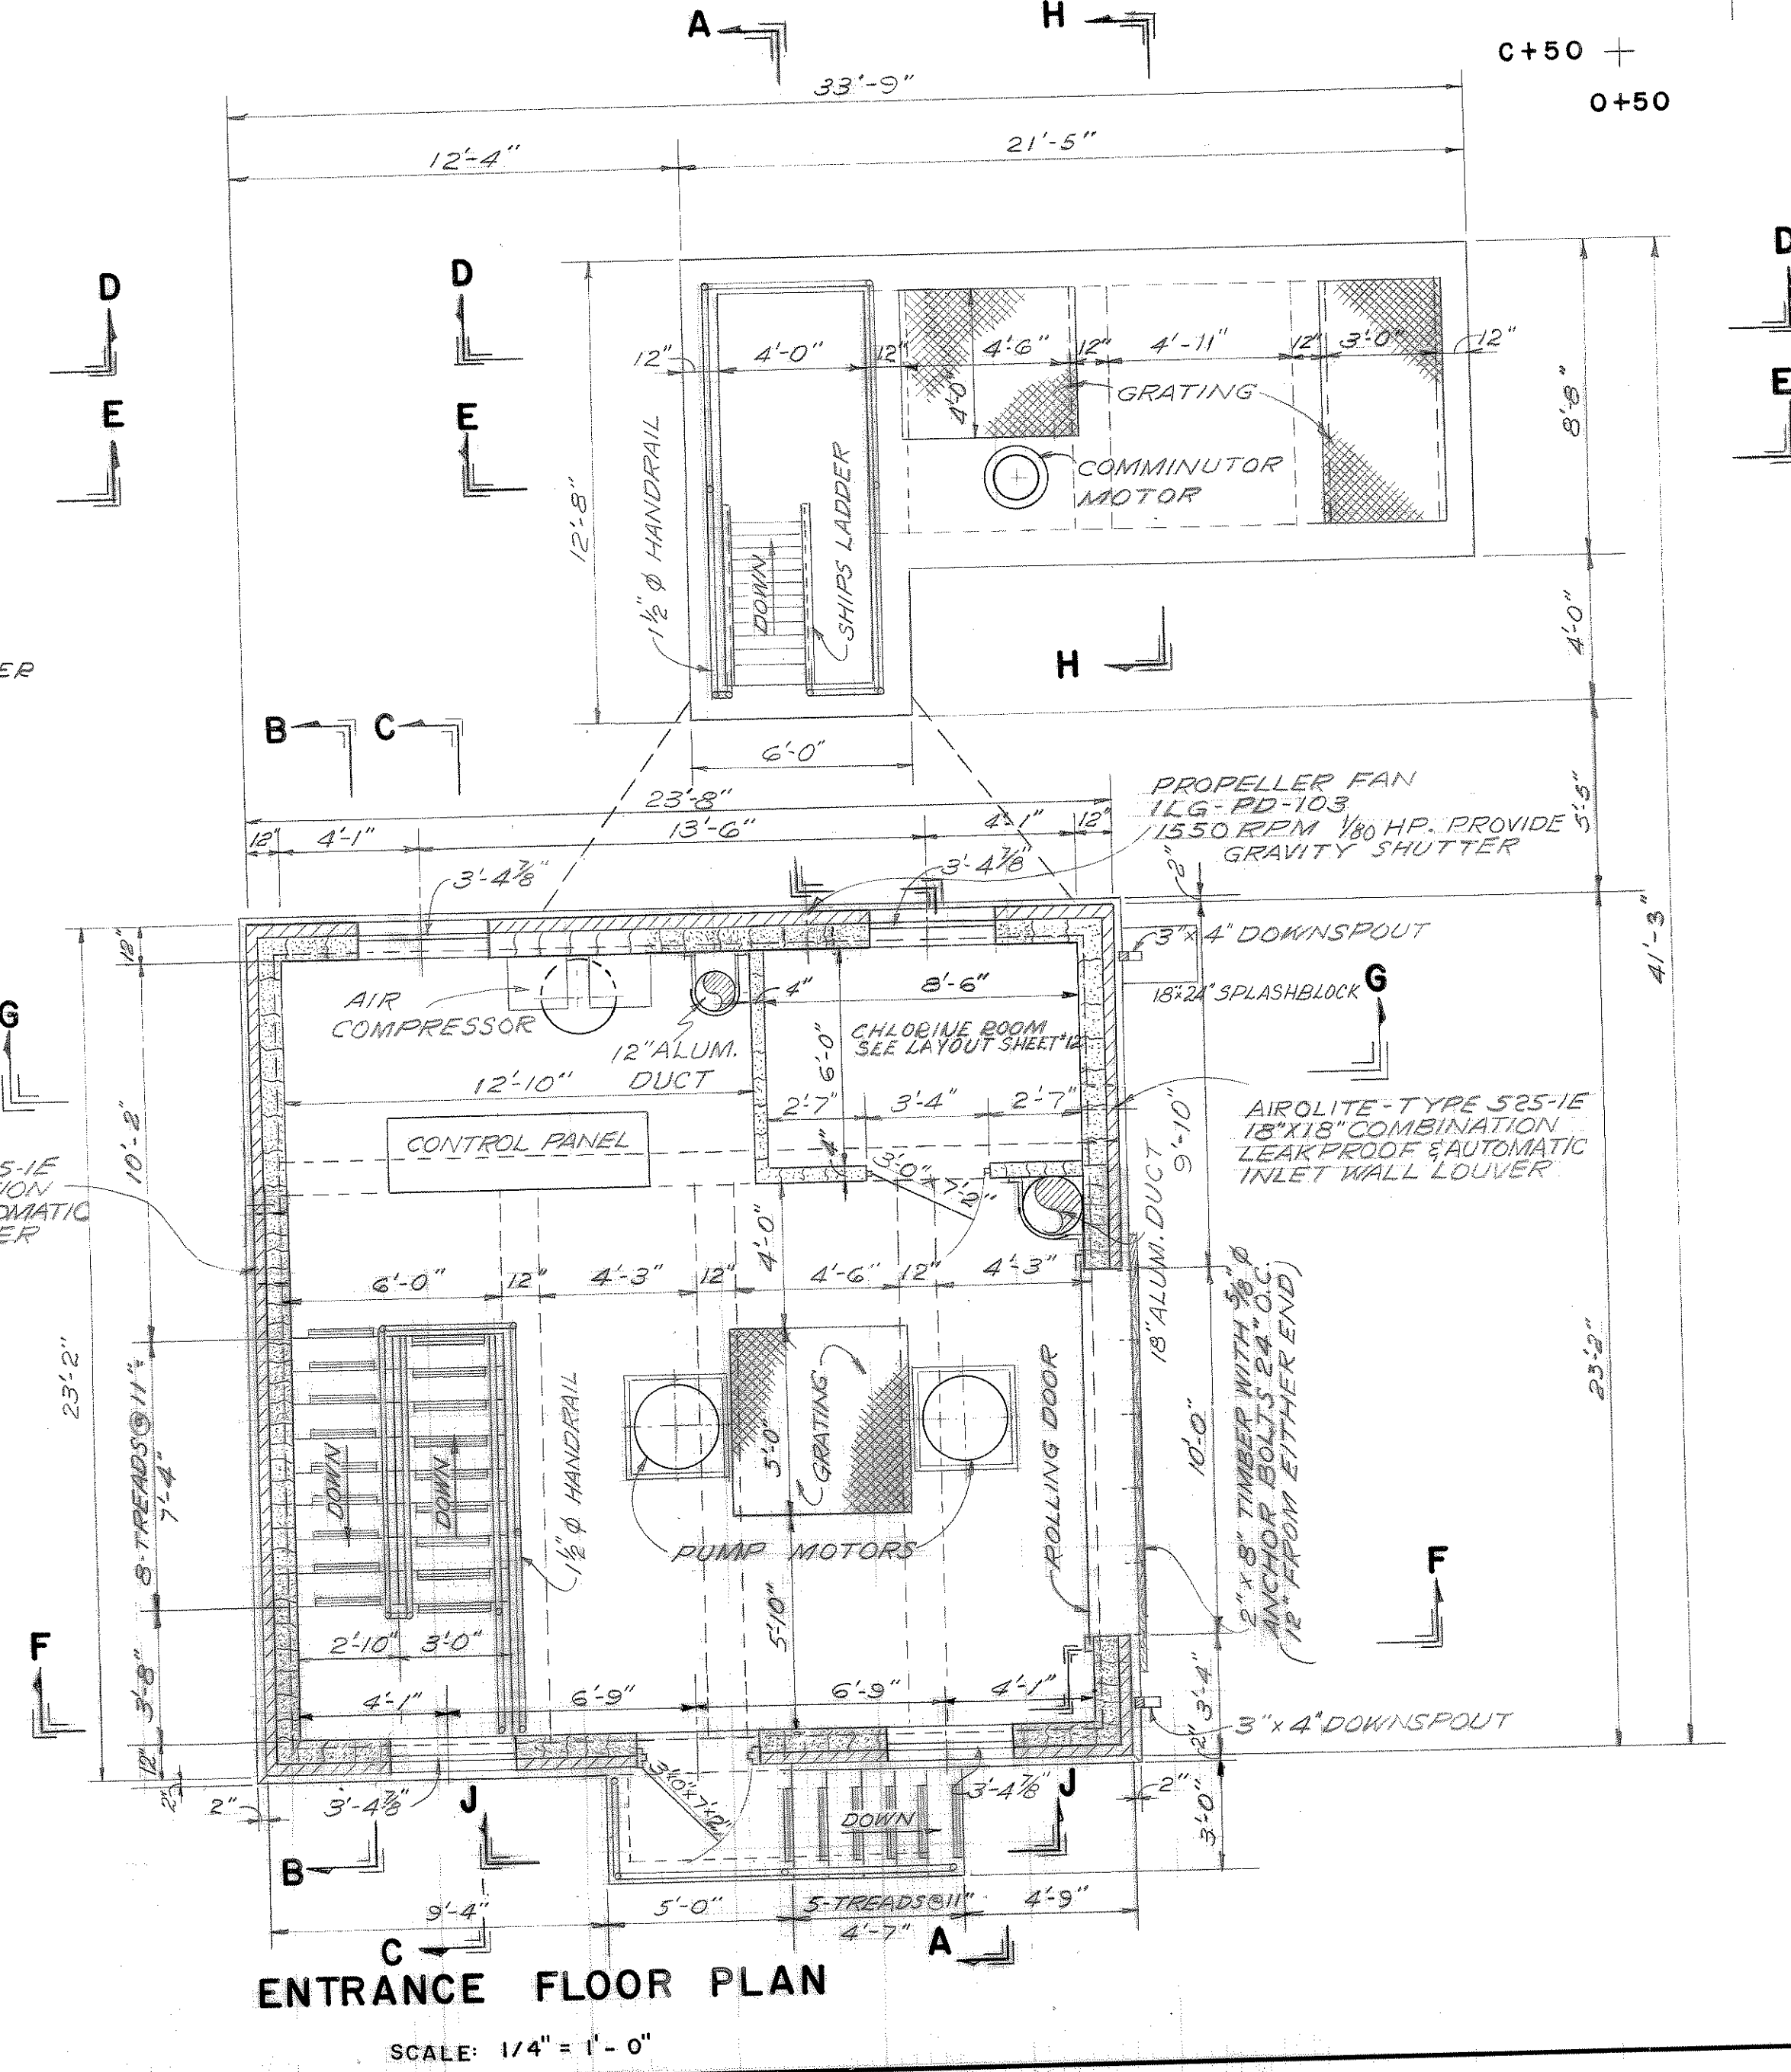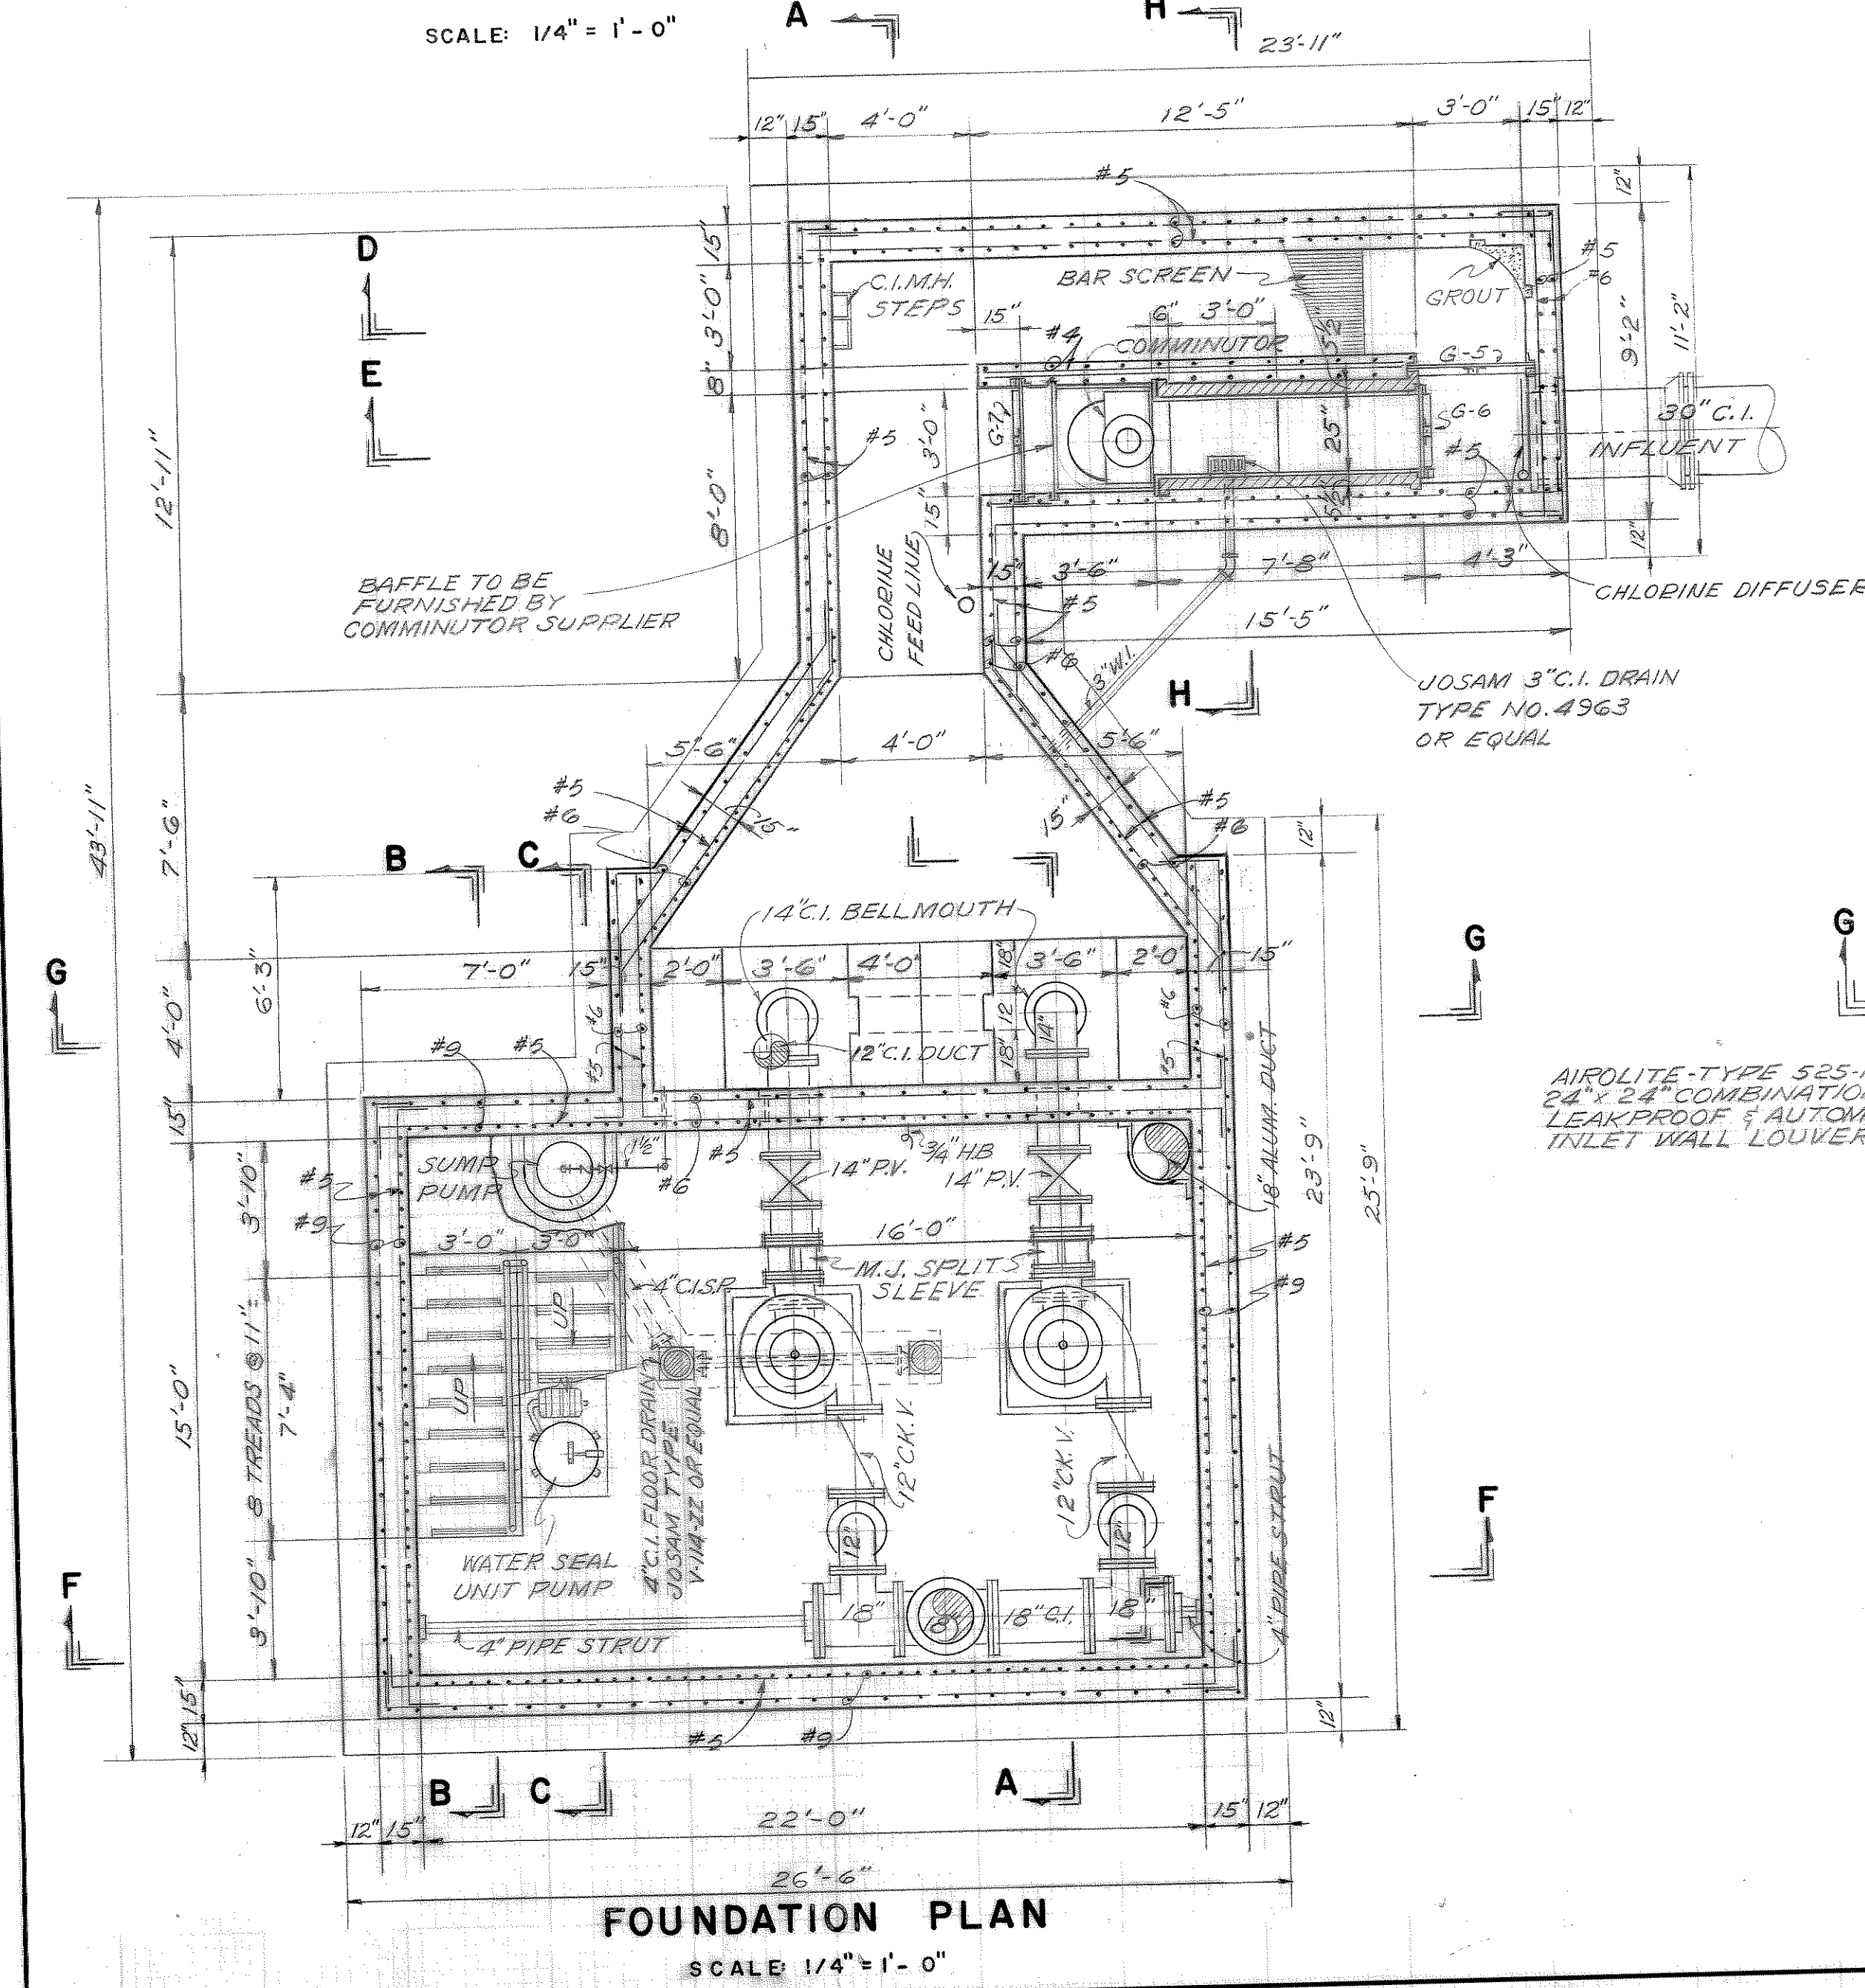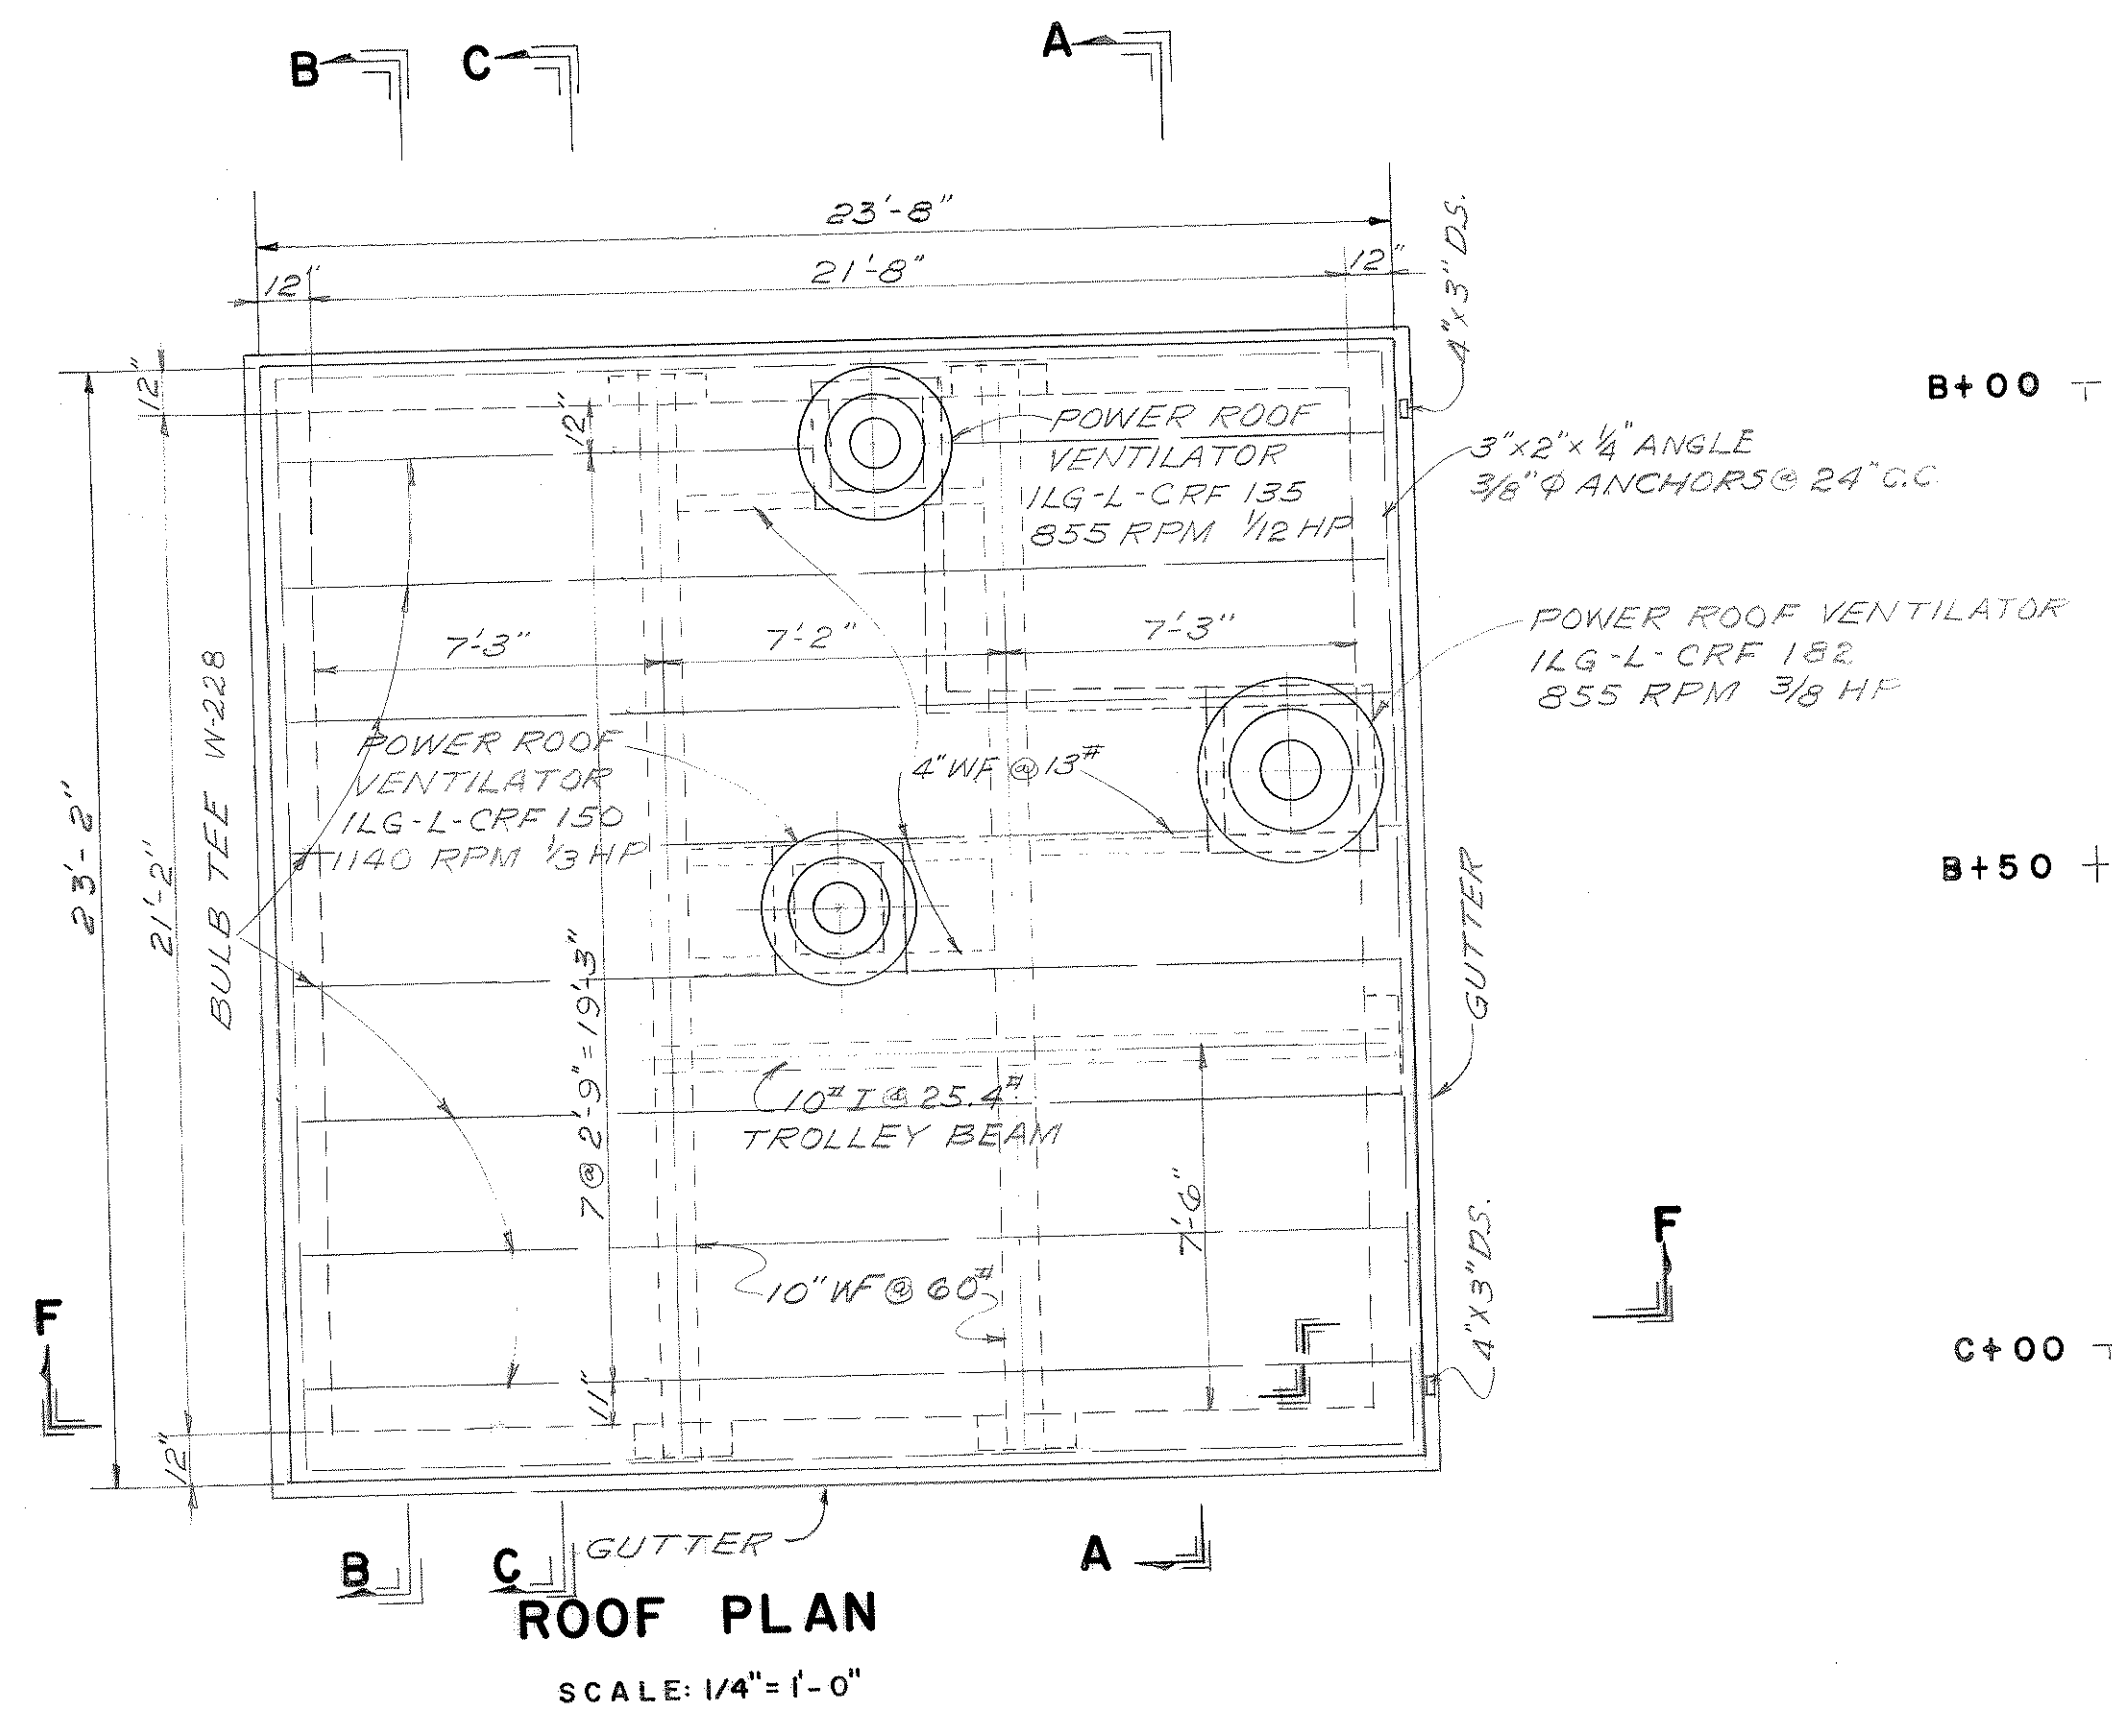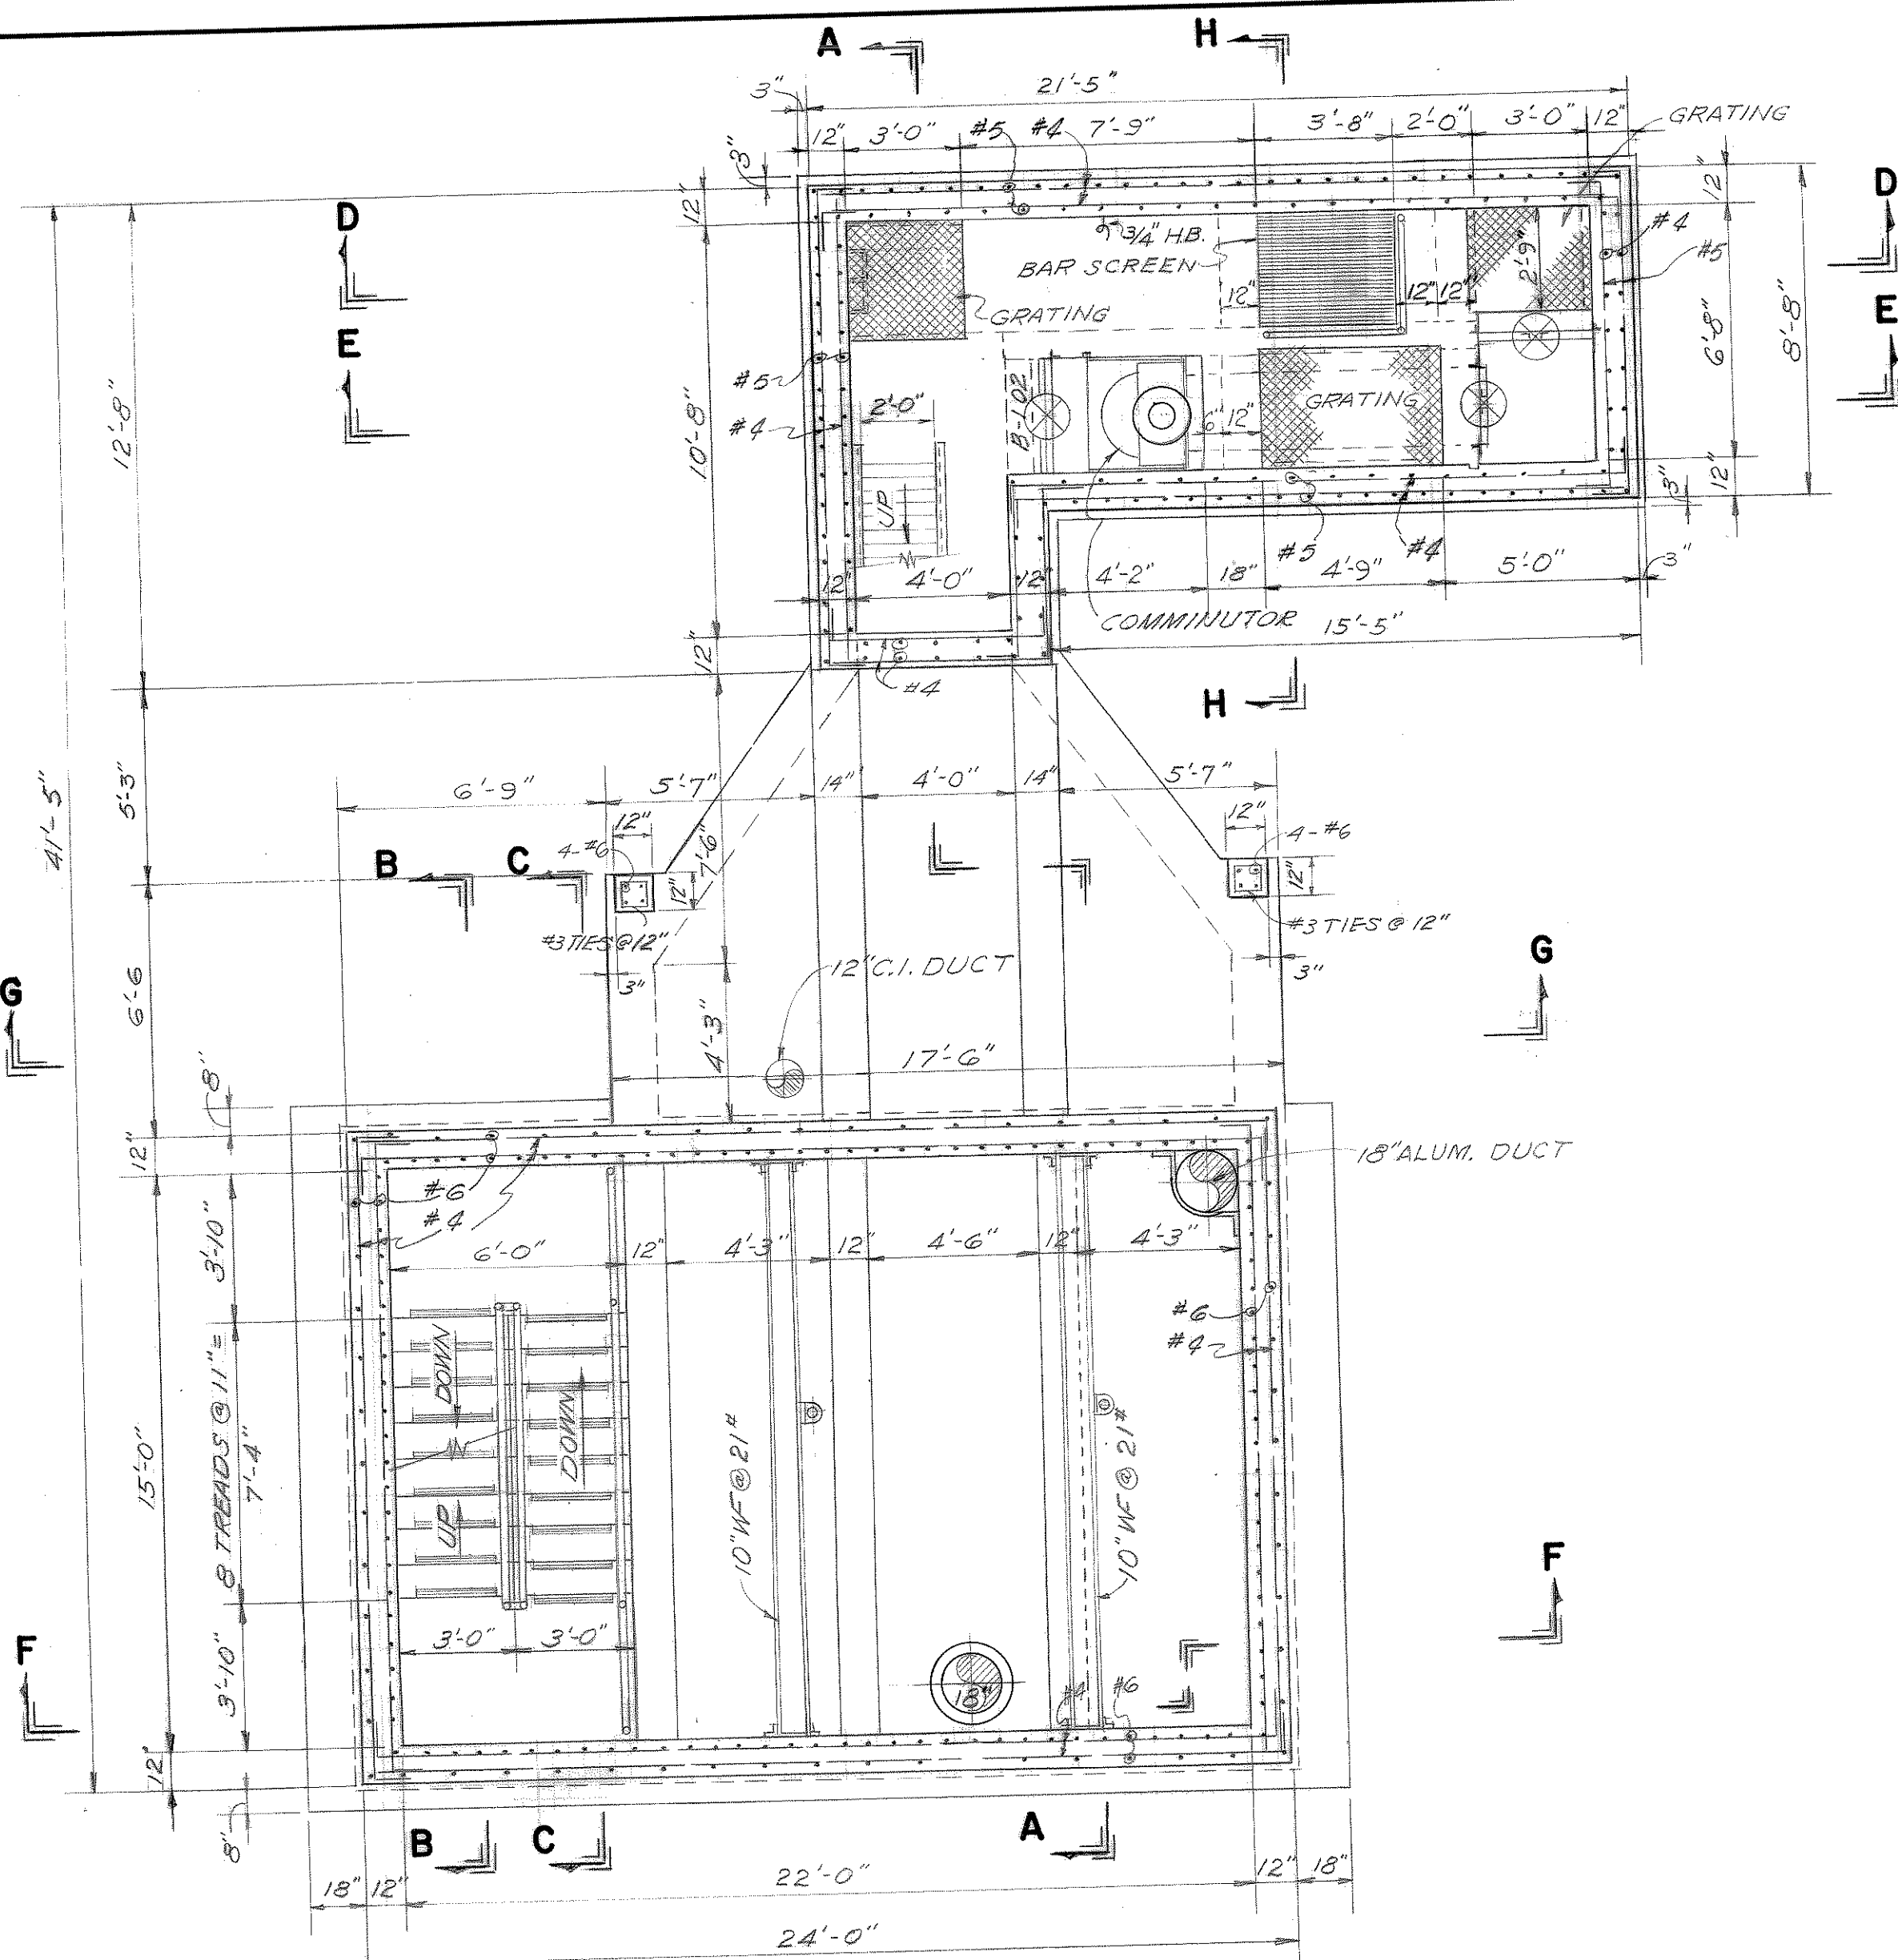

LEGEND		STRUCTURE
EXISTING	PROPOSED	
114.00		CONTOUR
X		FIN. GRADE ELEVATION
- - -		FENCE
- - -		SAN. SEWER
- - -		G.I. PIPE
- - -		GAS LINE
- - -		VALVE & VALVE BOX
- - -		GALV. IRON PIPE
- - -		YARD HYDRANT
- - -		R/W OR B
- - -		PAVED ROADWAY
- - -		CHLORINE LINE (PVC)

CONTRACT 'C'

CITY OF BRUNSWICK, GEORGIA
SEWERAGE SYSTEM IMPROVEMENTS


RAW SEWAGE
PUMPING STATION NO. 3

SCALE AS SHOWN DATE JULY, 1963

WIEDEMAN AND SINGLETON
ENGINEERS
ATLANTA GEORGIA


SHEET 6 OF 15

DATUM EQUALS USCGS MEAN
SEA LEVEL PLUS 100.00 FT.

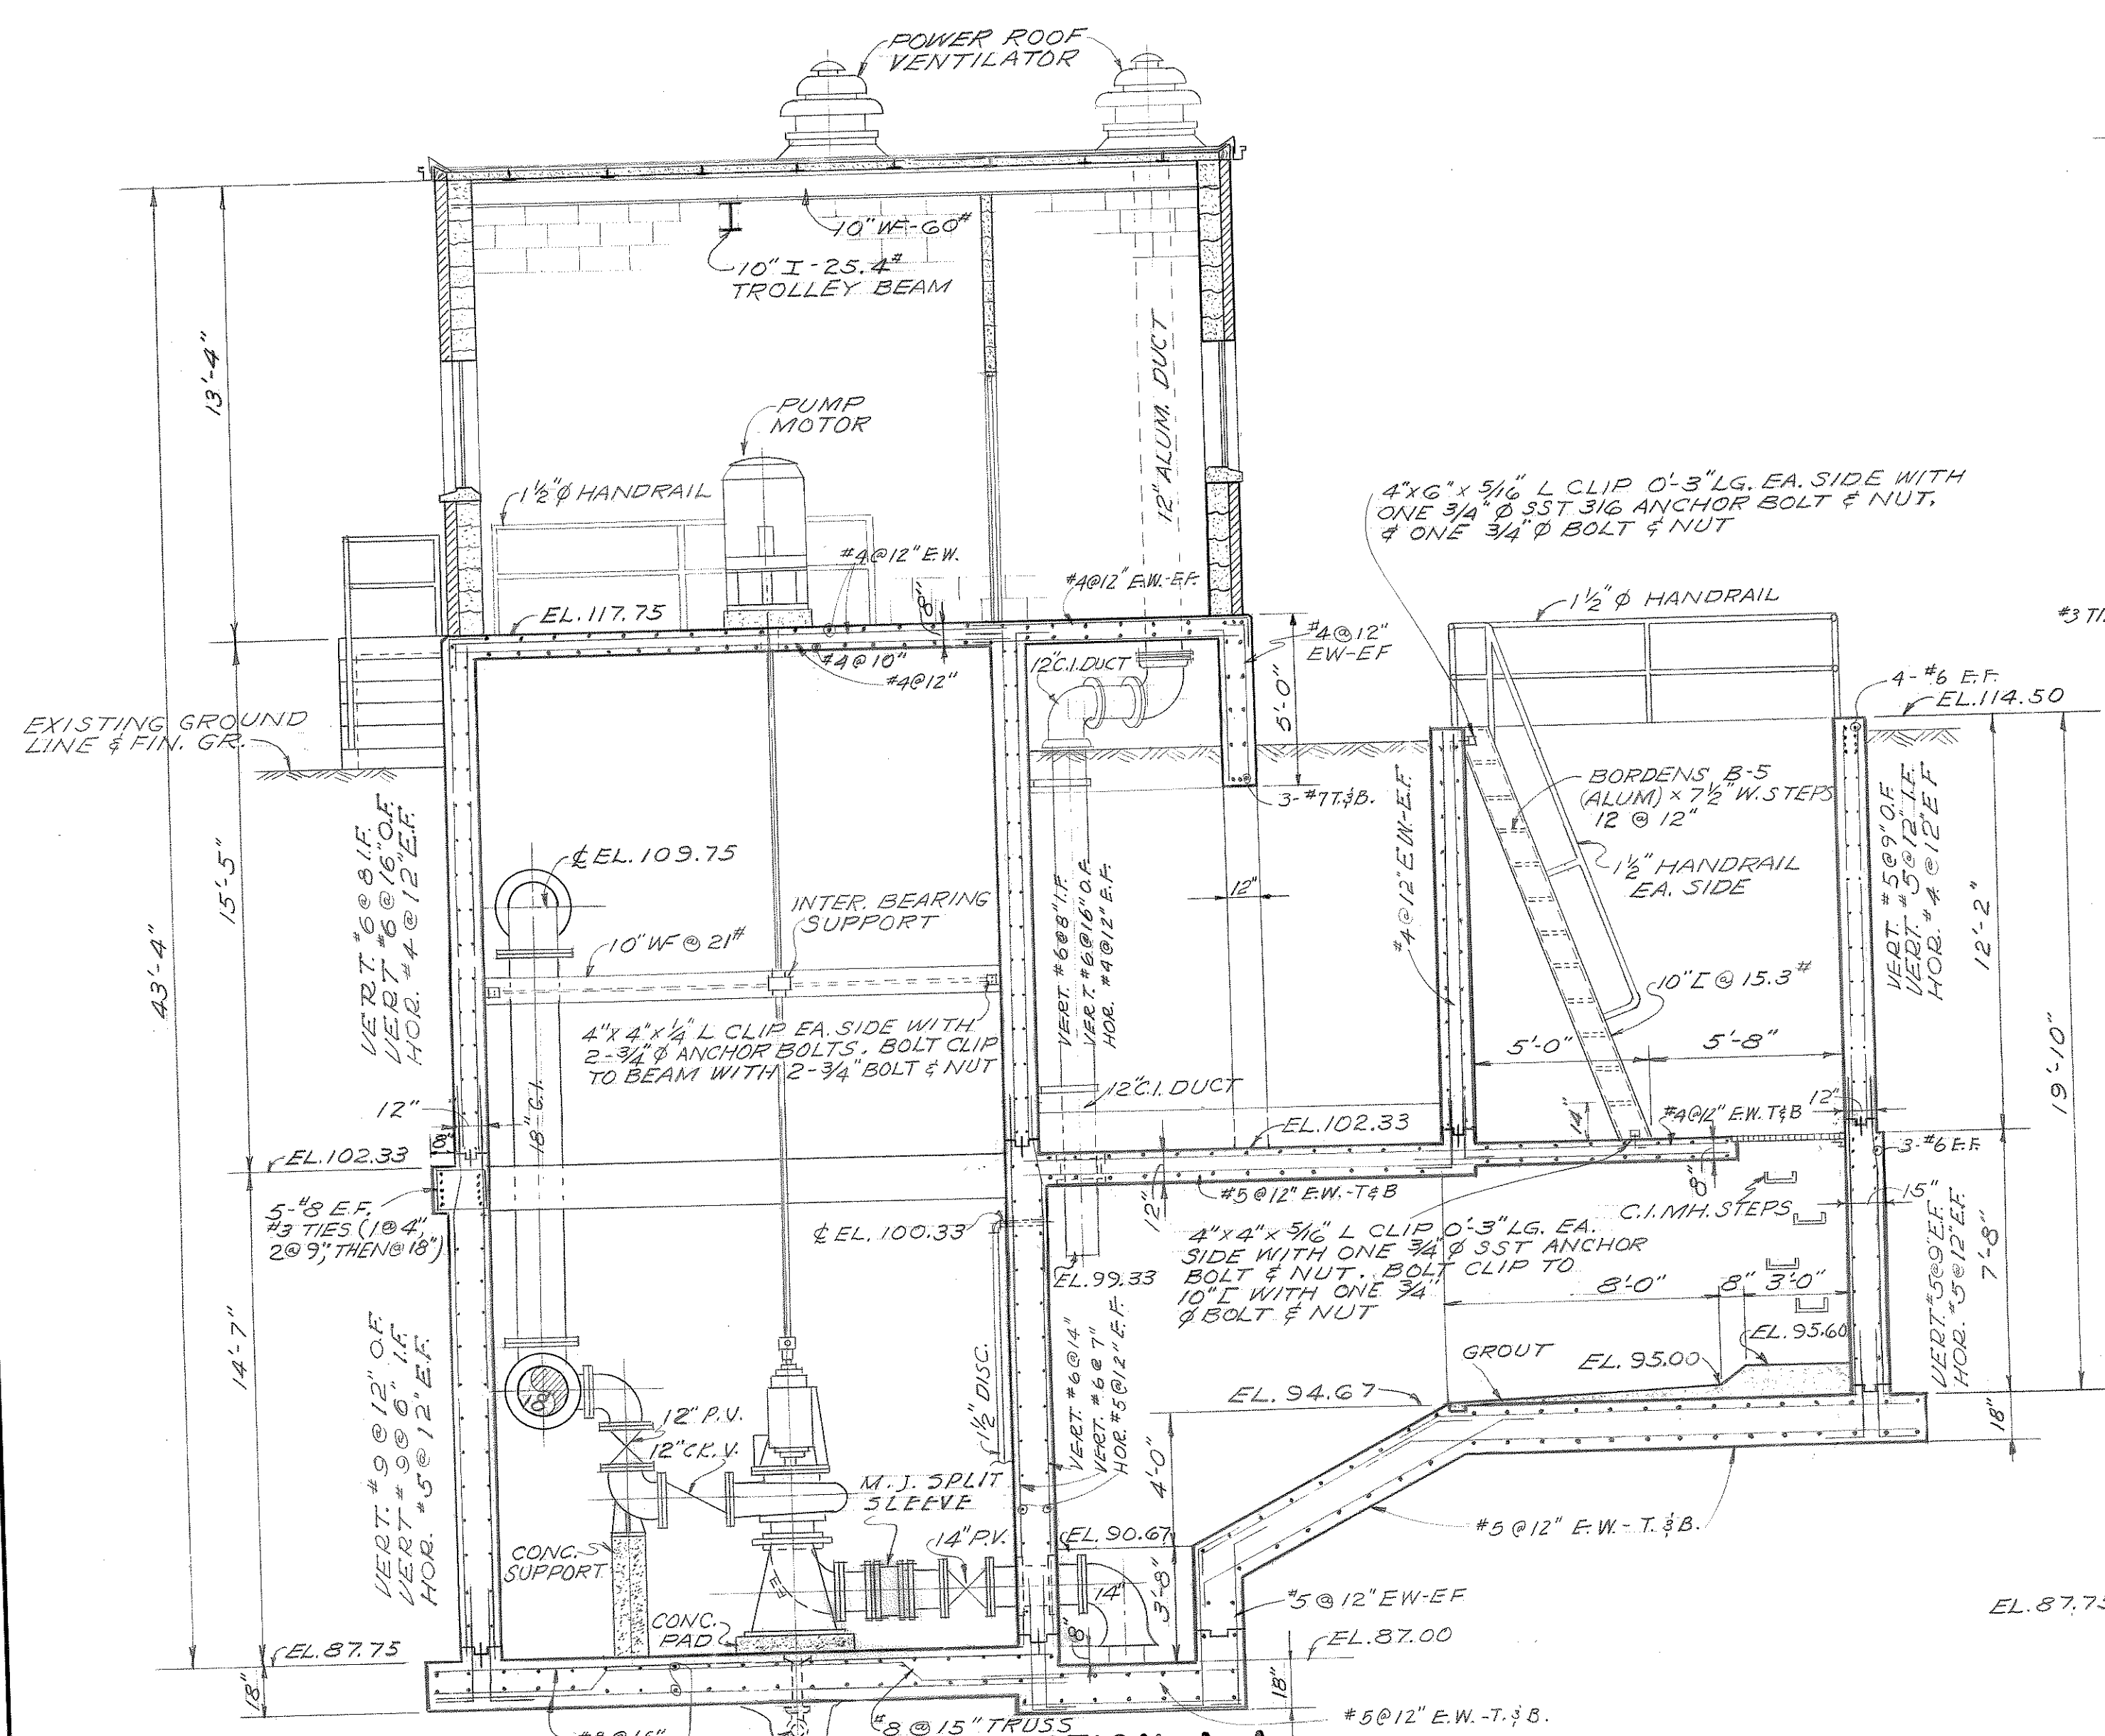


SECTION A-A

SCALE: 1/4" = 1'-0"

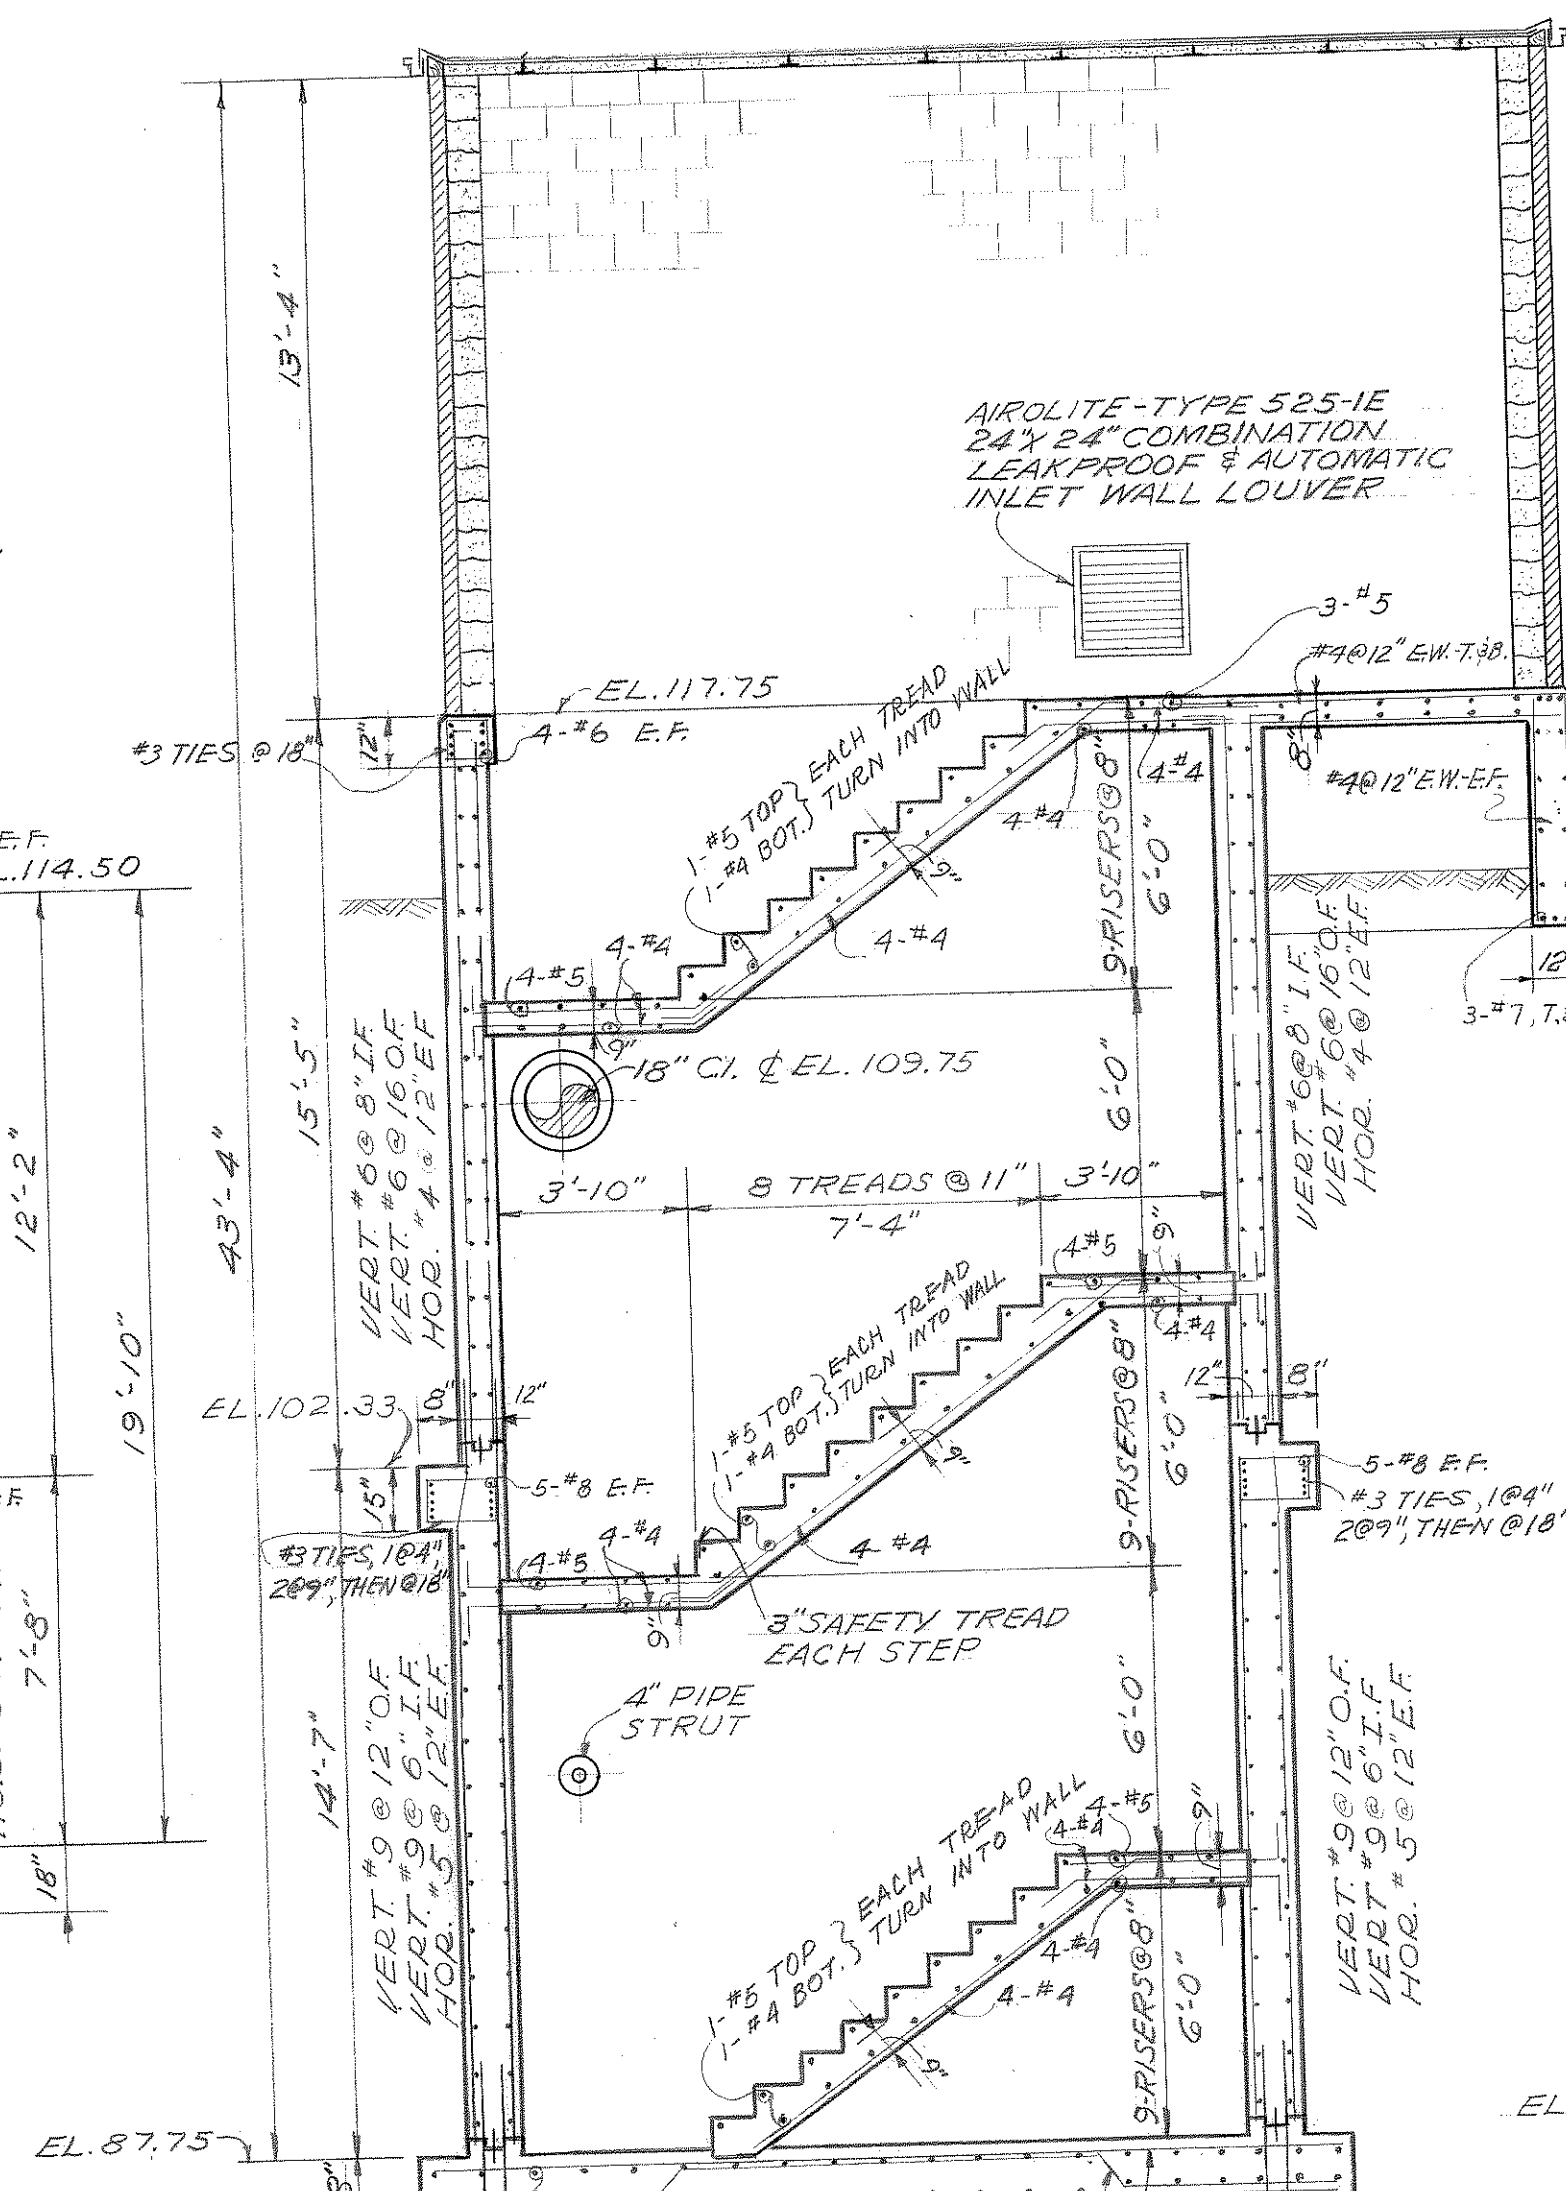


SECTION B-B

SCALE: 1/4" = 1'-0"

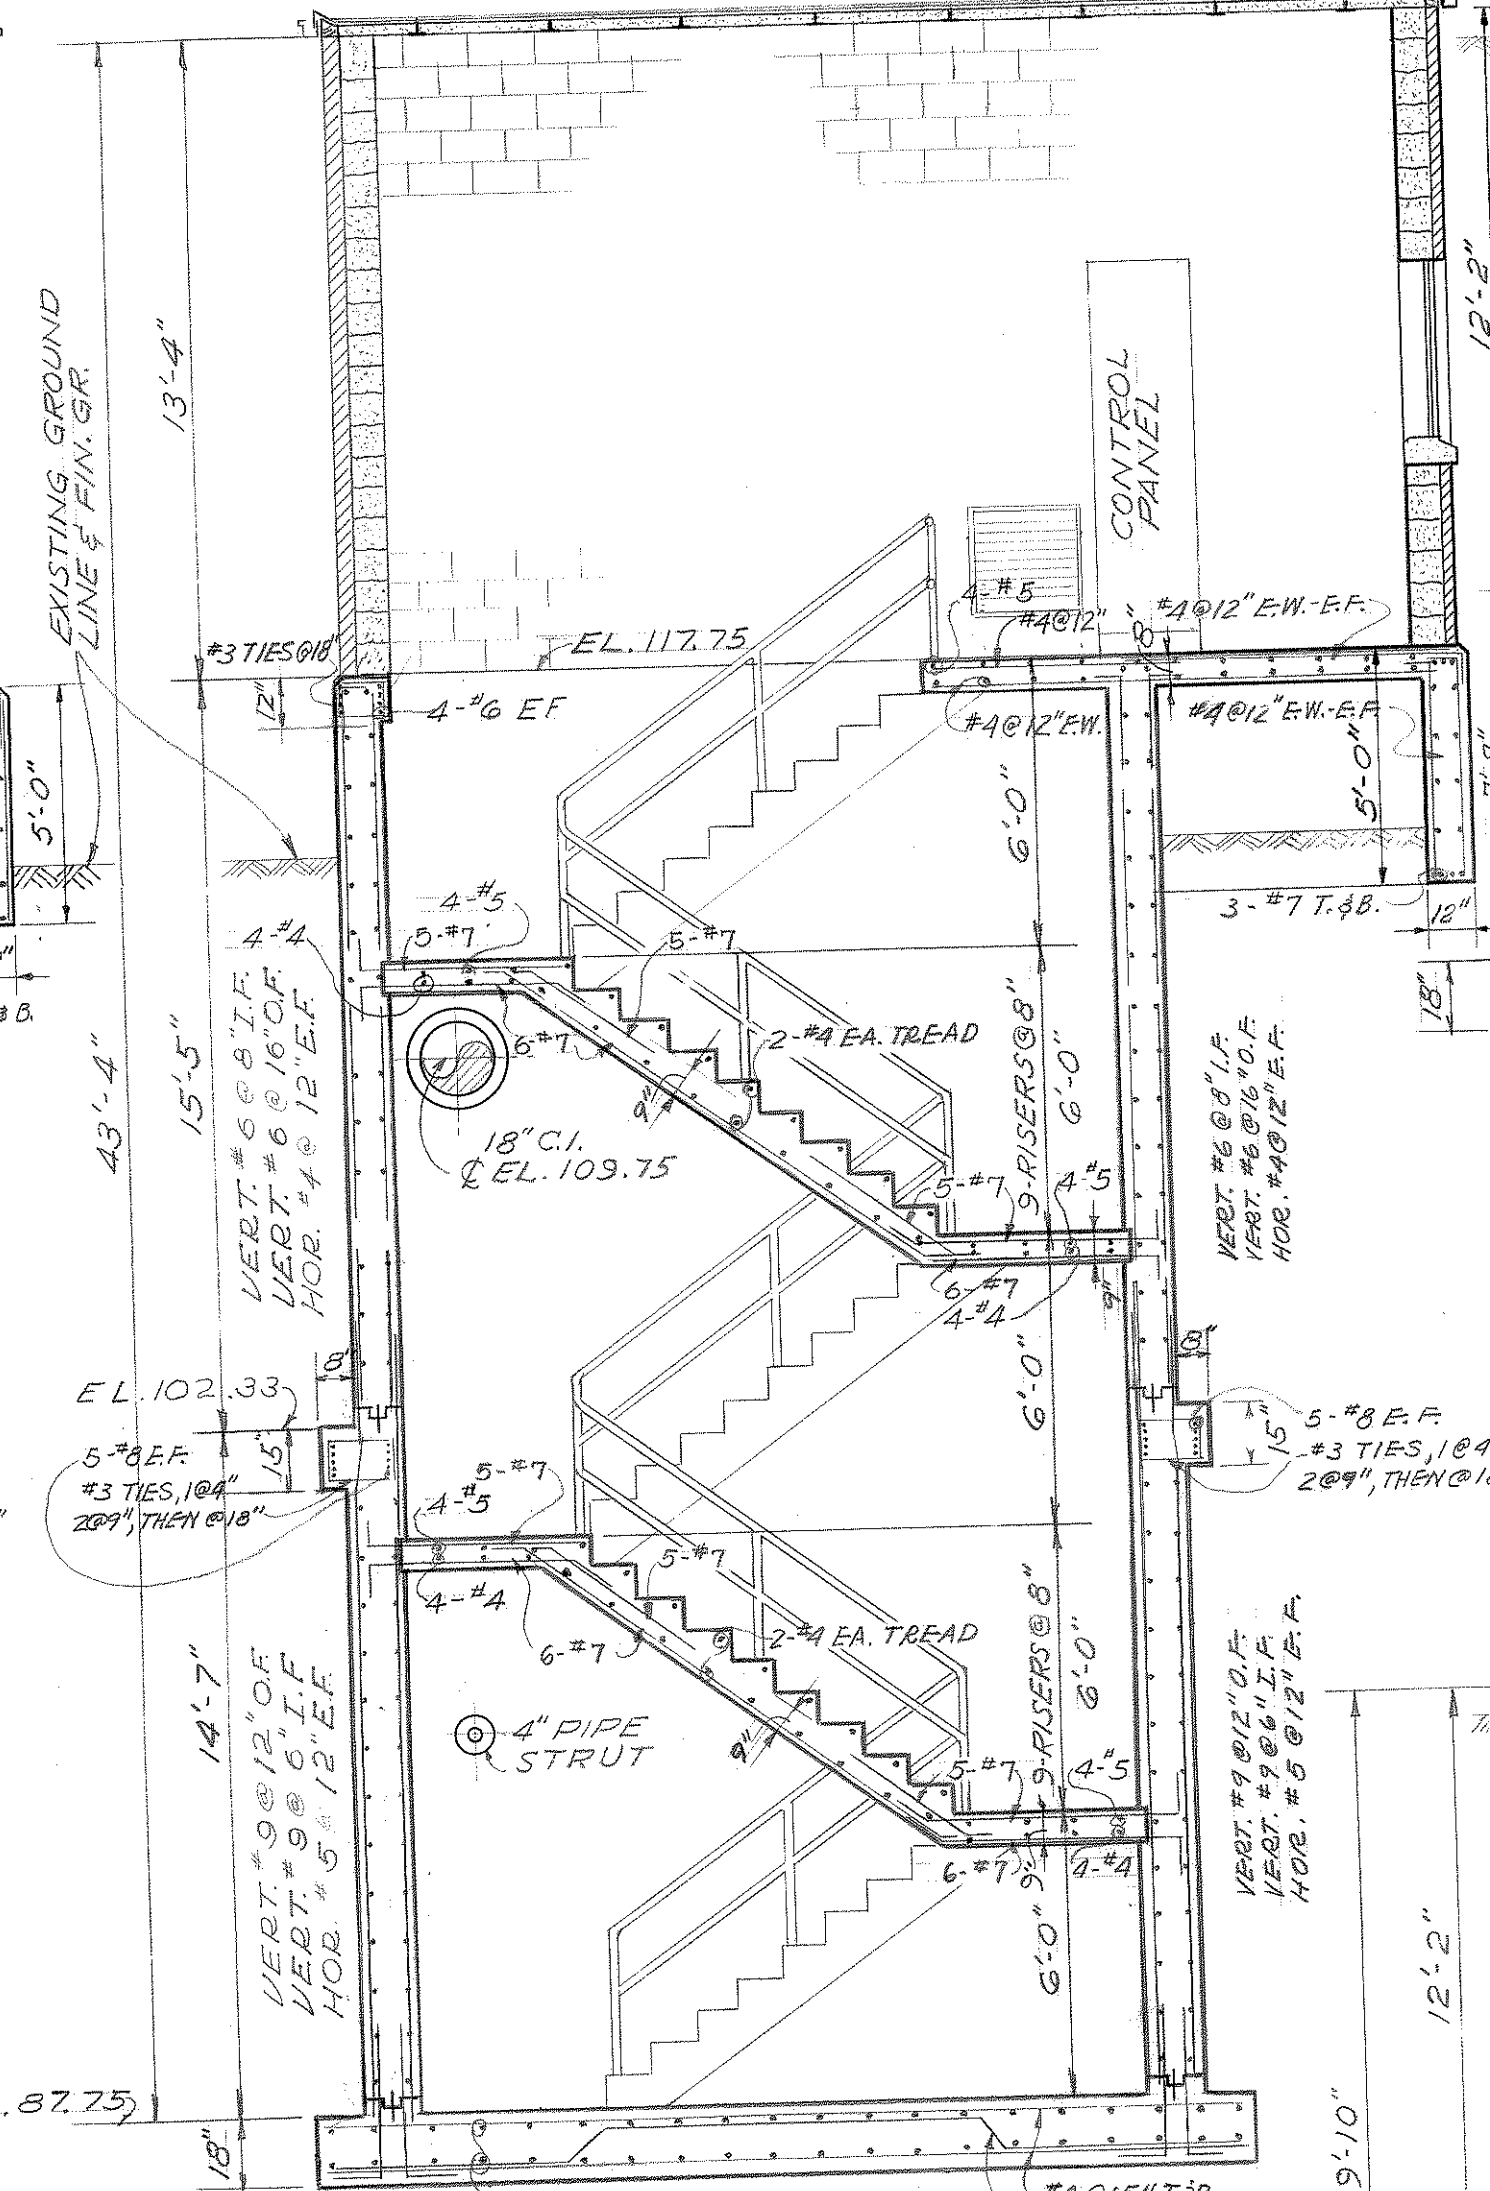


SECTION C-C

SCALE: 1/4" = 1'-0"

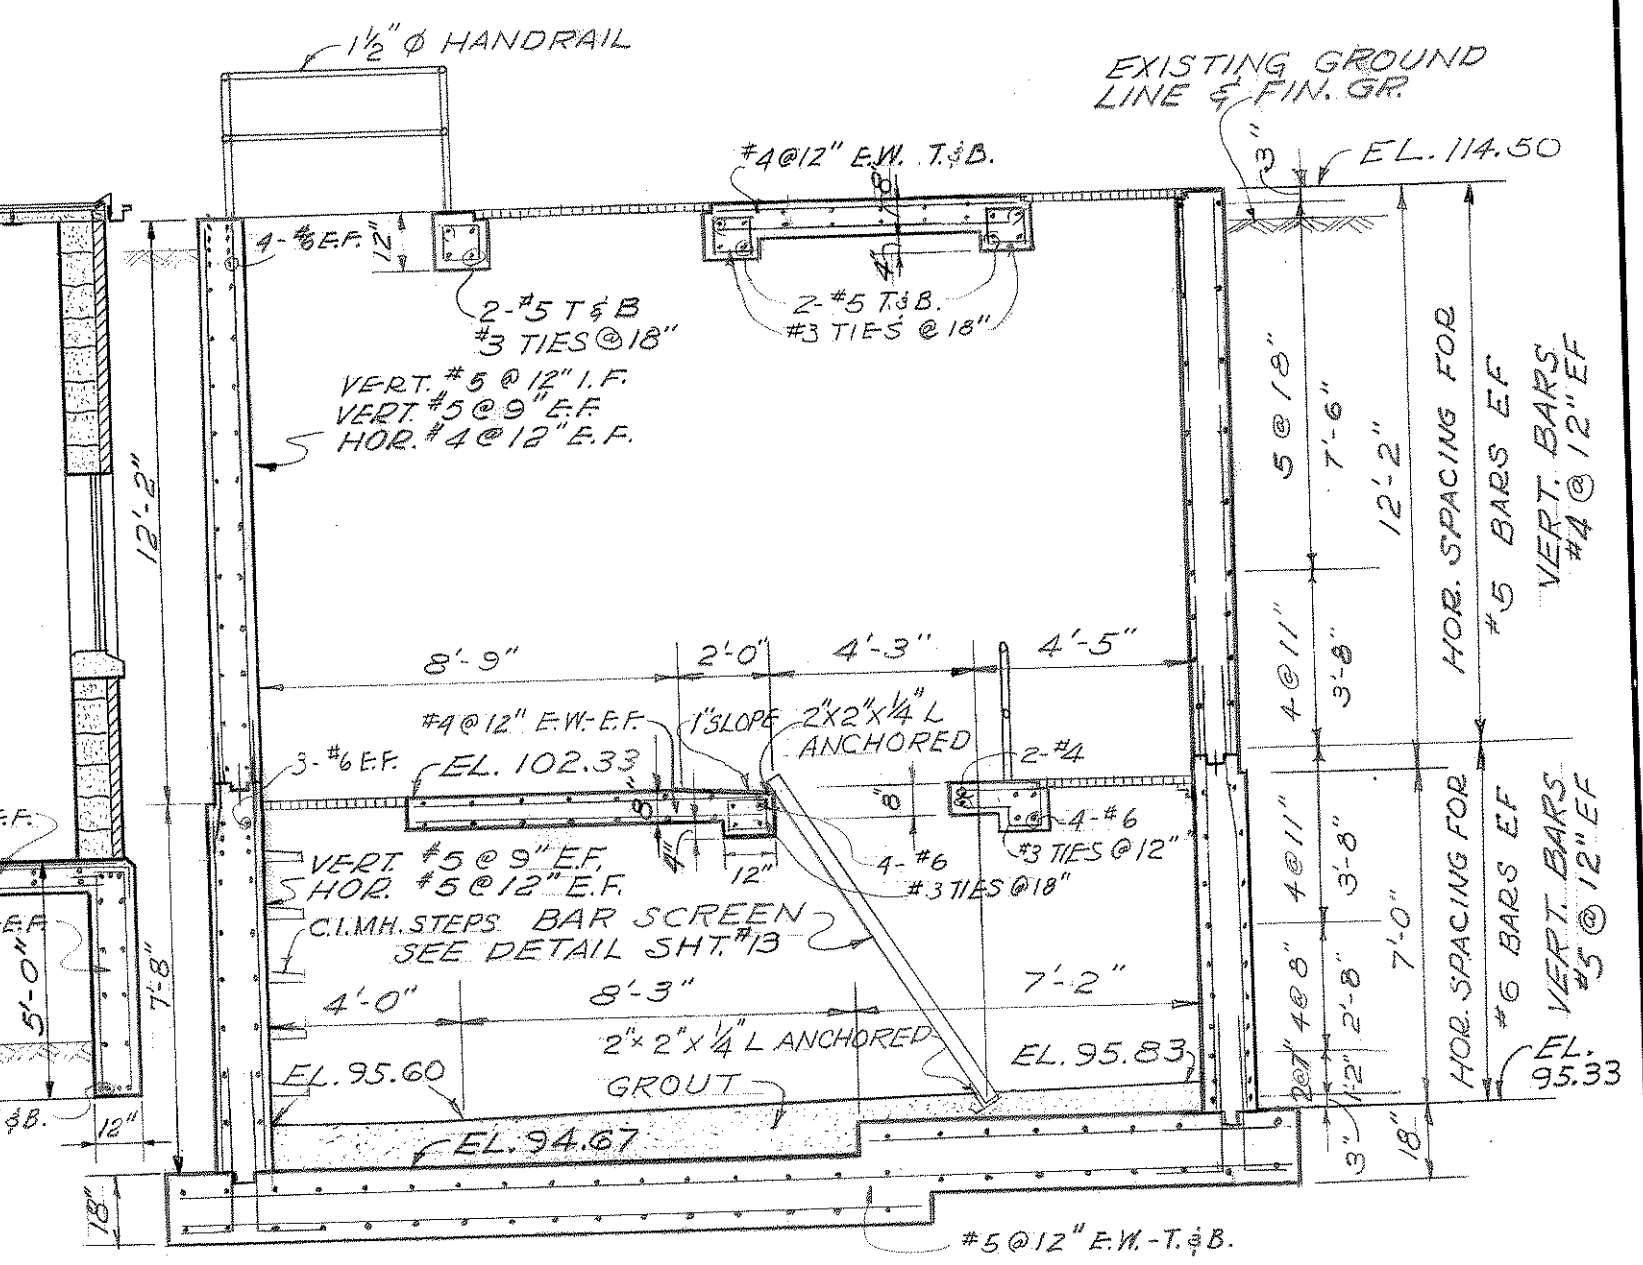


SECTION D-D

SCALE: 1/4" = 1'-0"

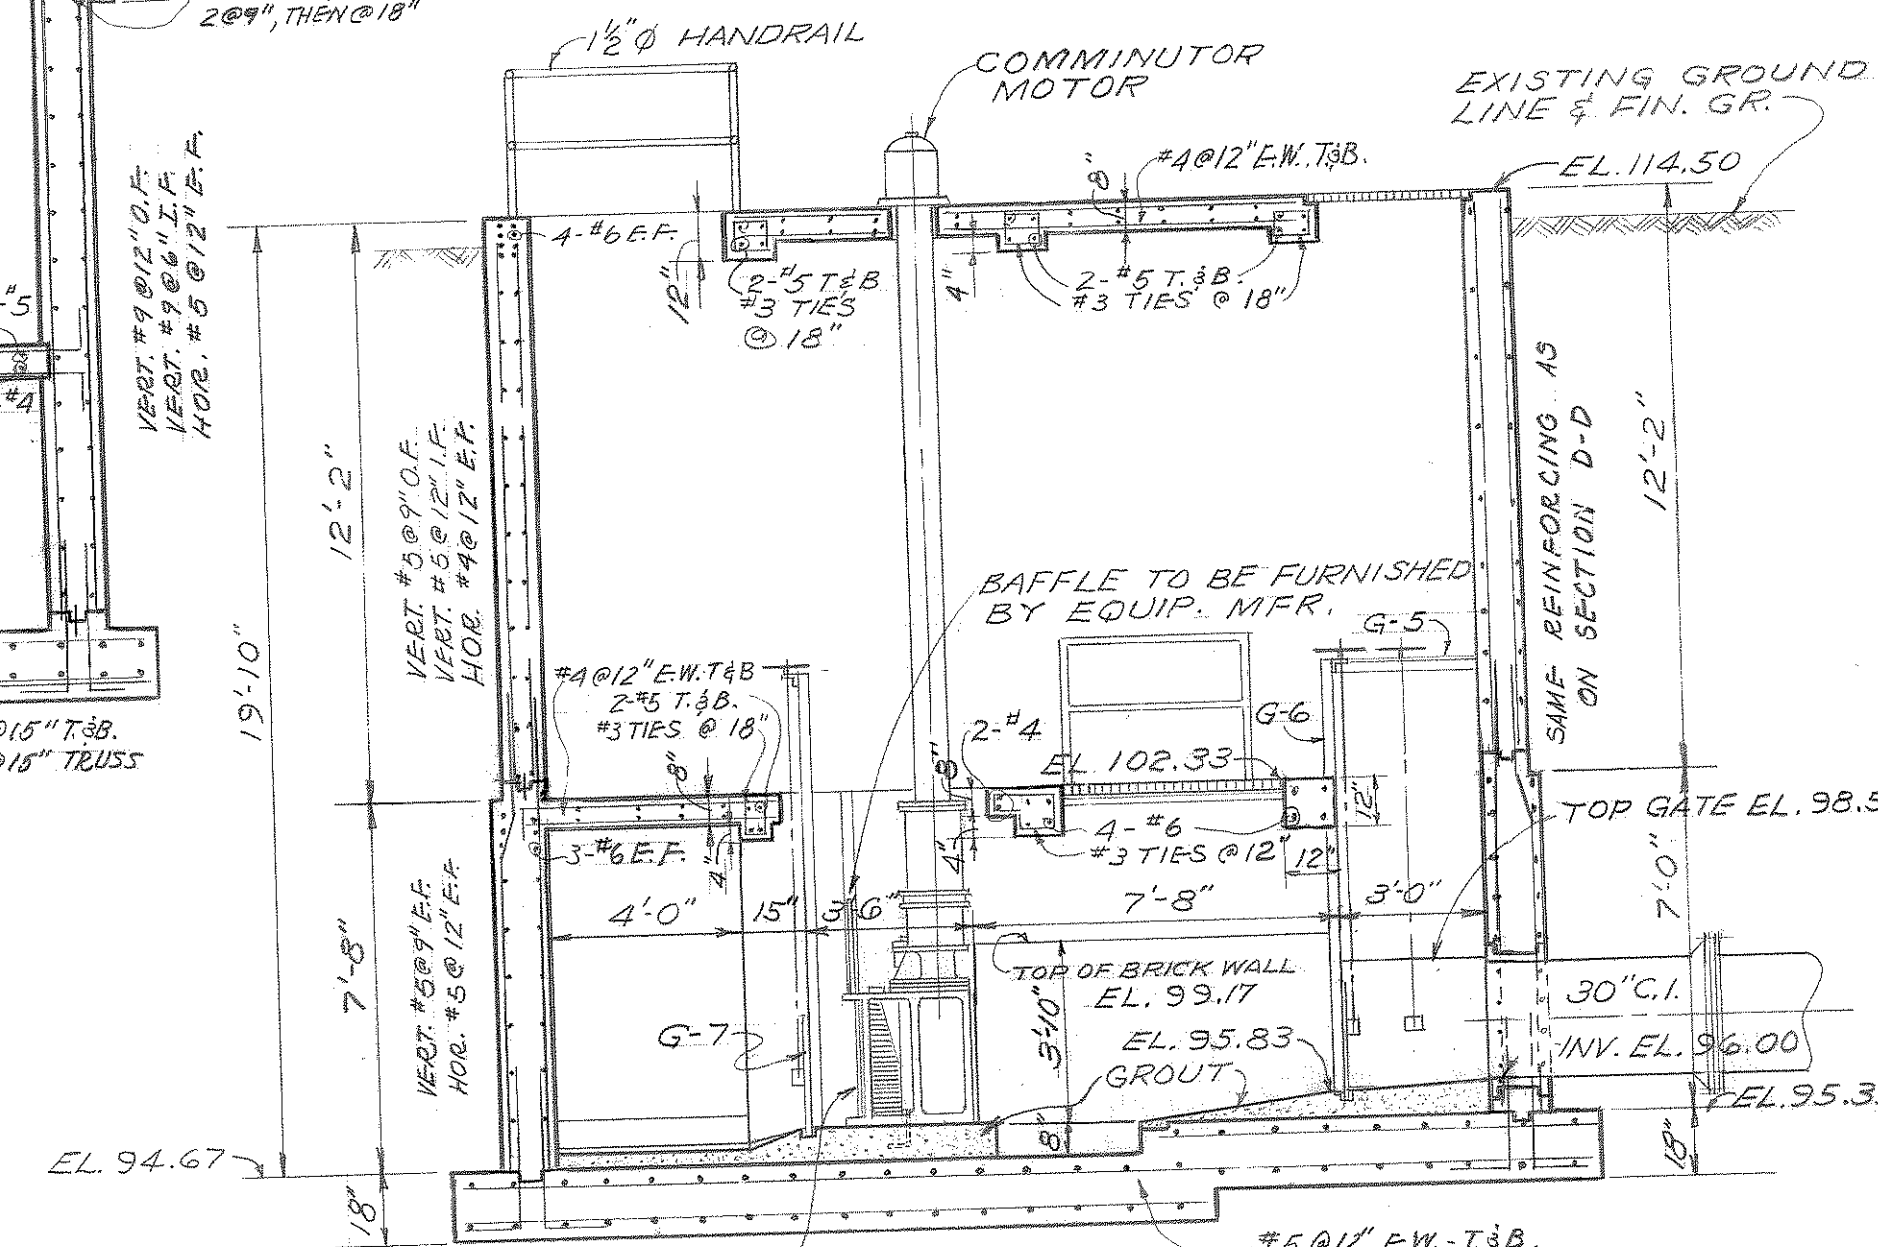


SECTION E-E

SCALE: 1/4" = 1'-0"

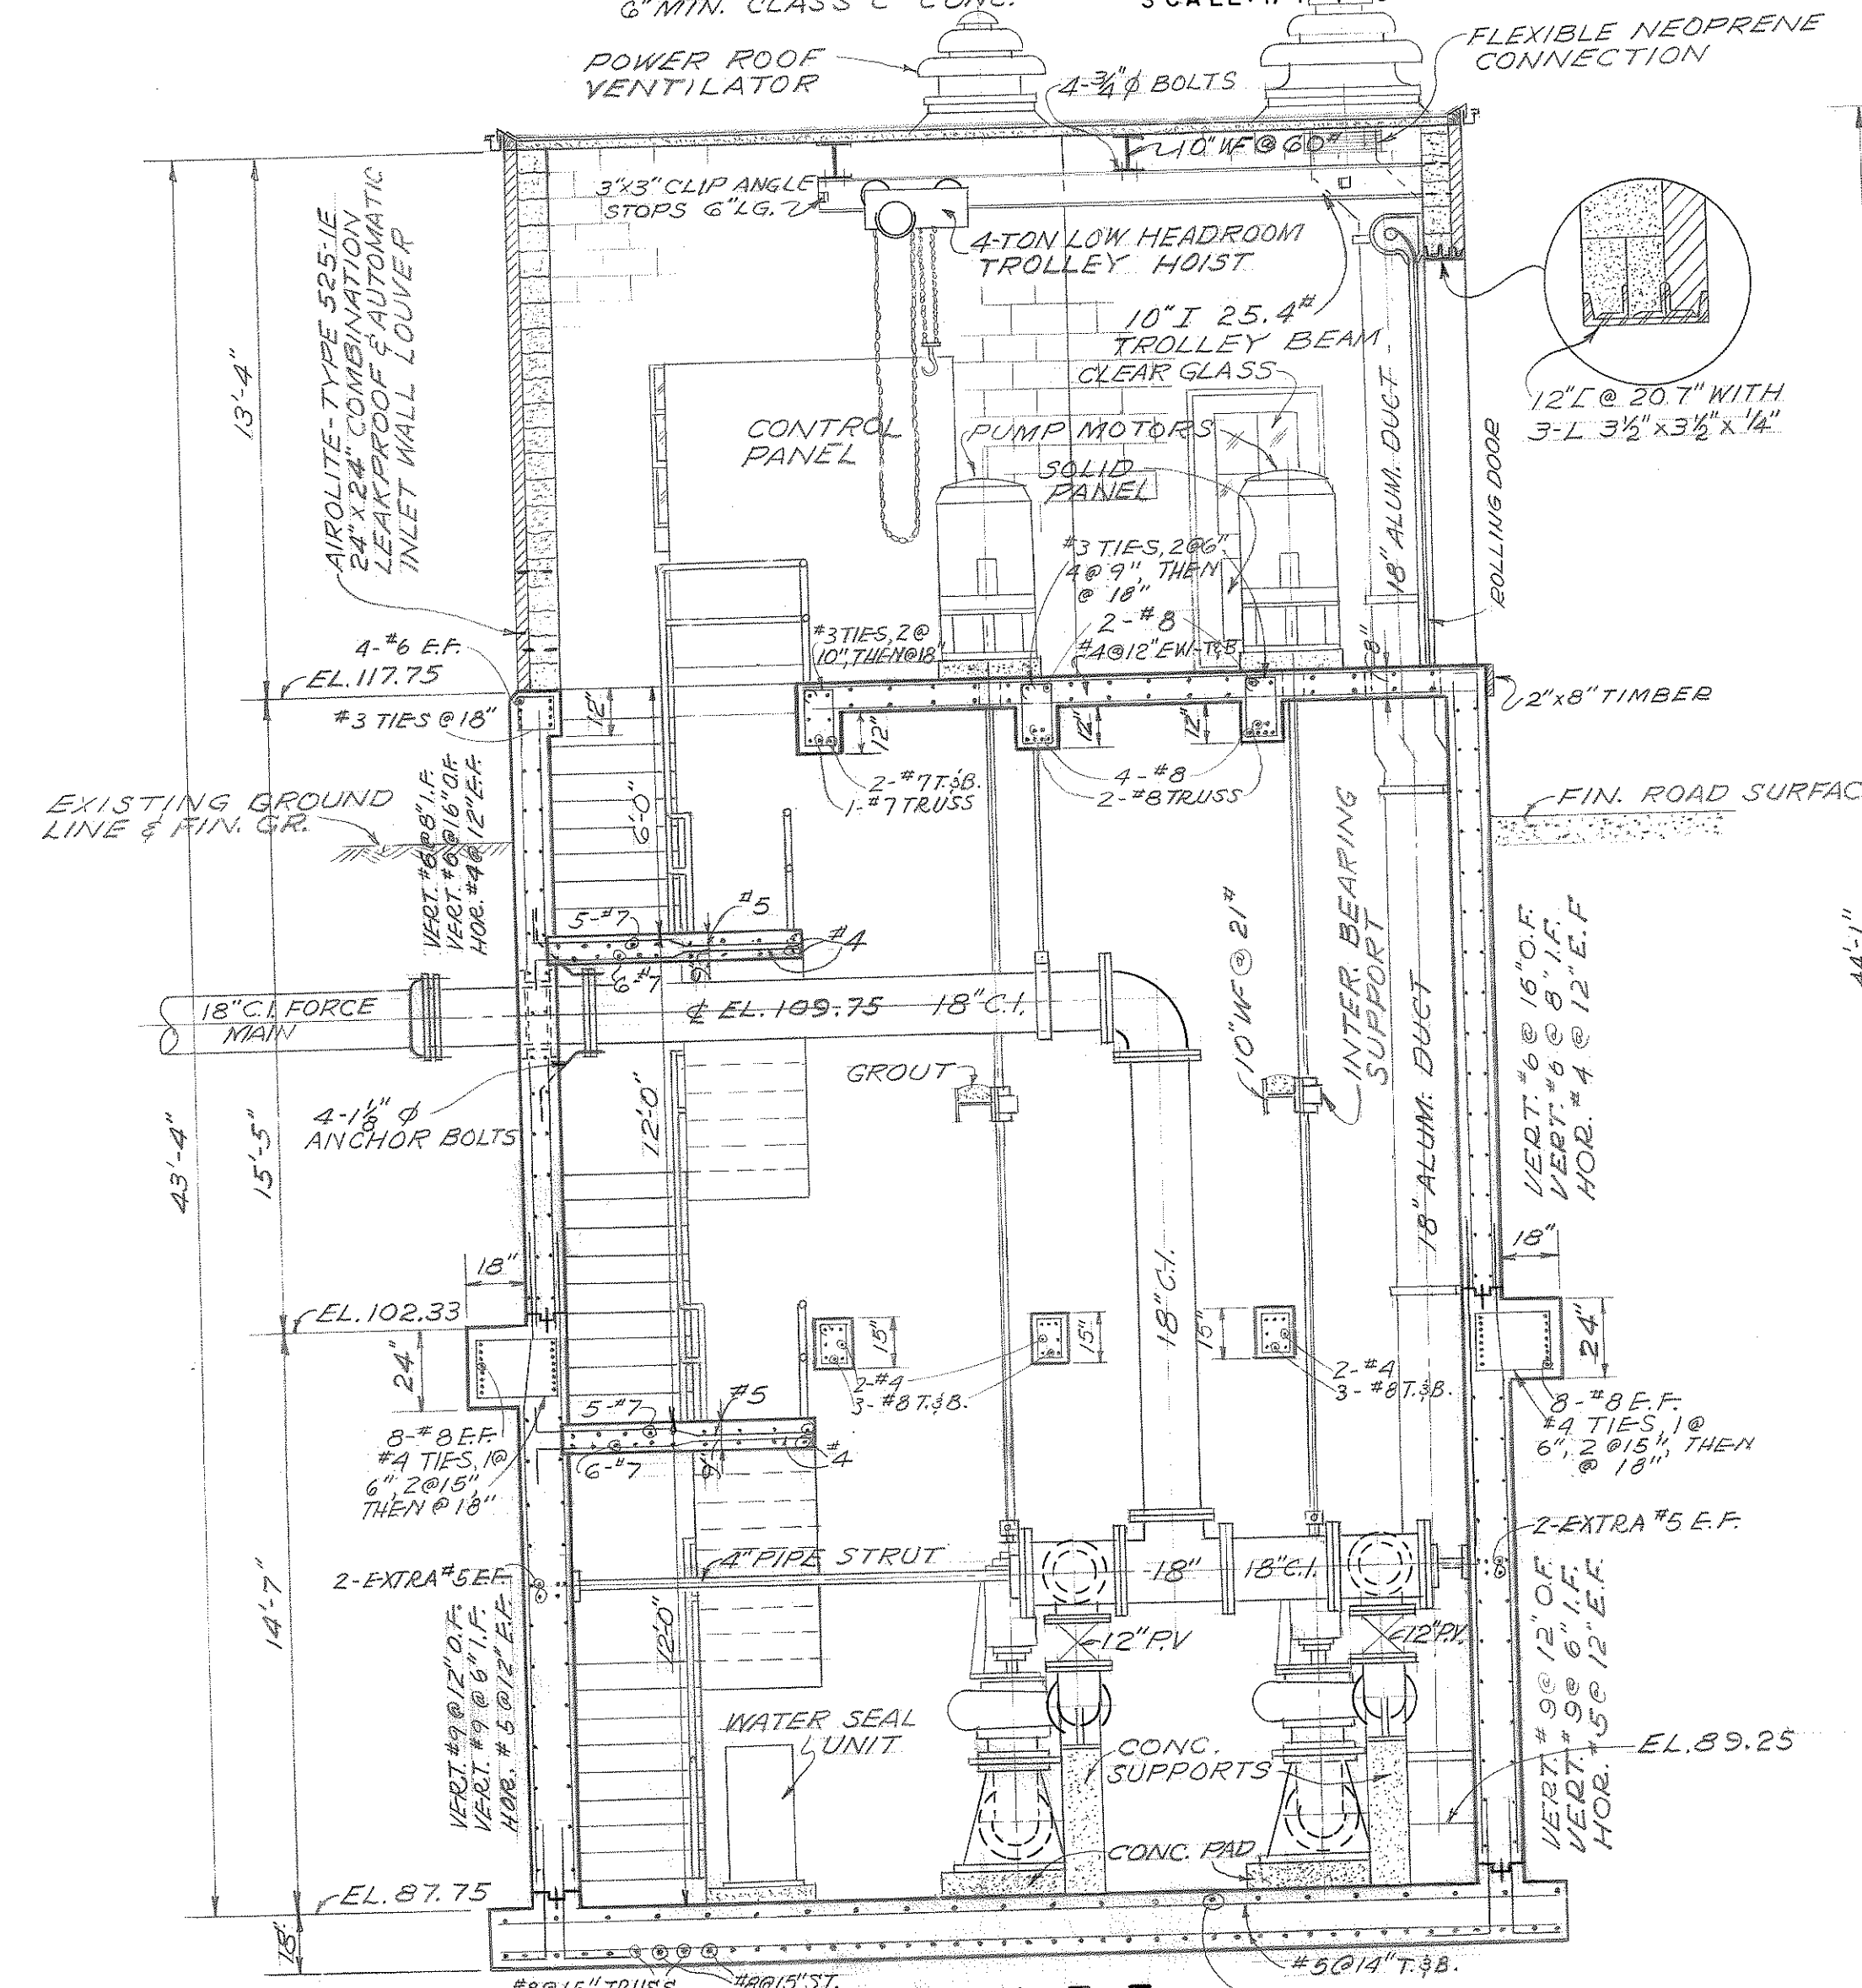


SECTION F-F

SCALE: 1/4" = 1'-0"

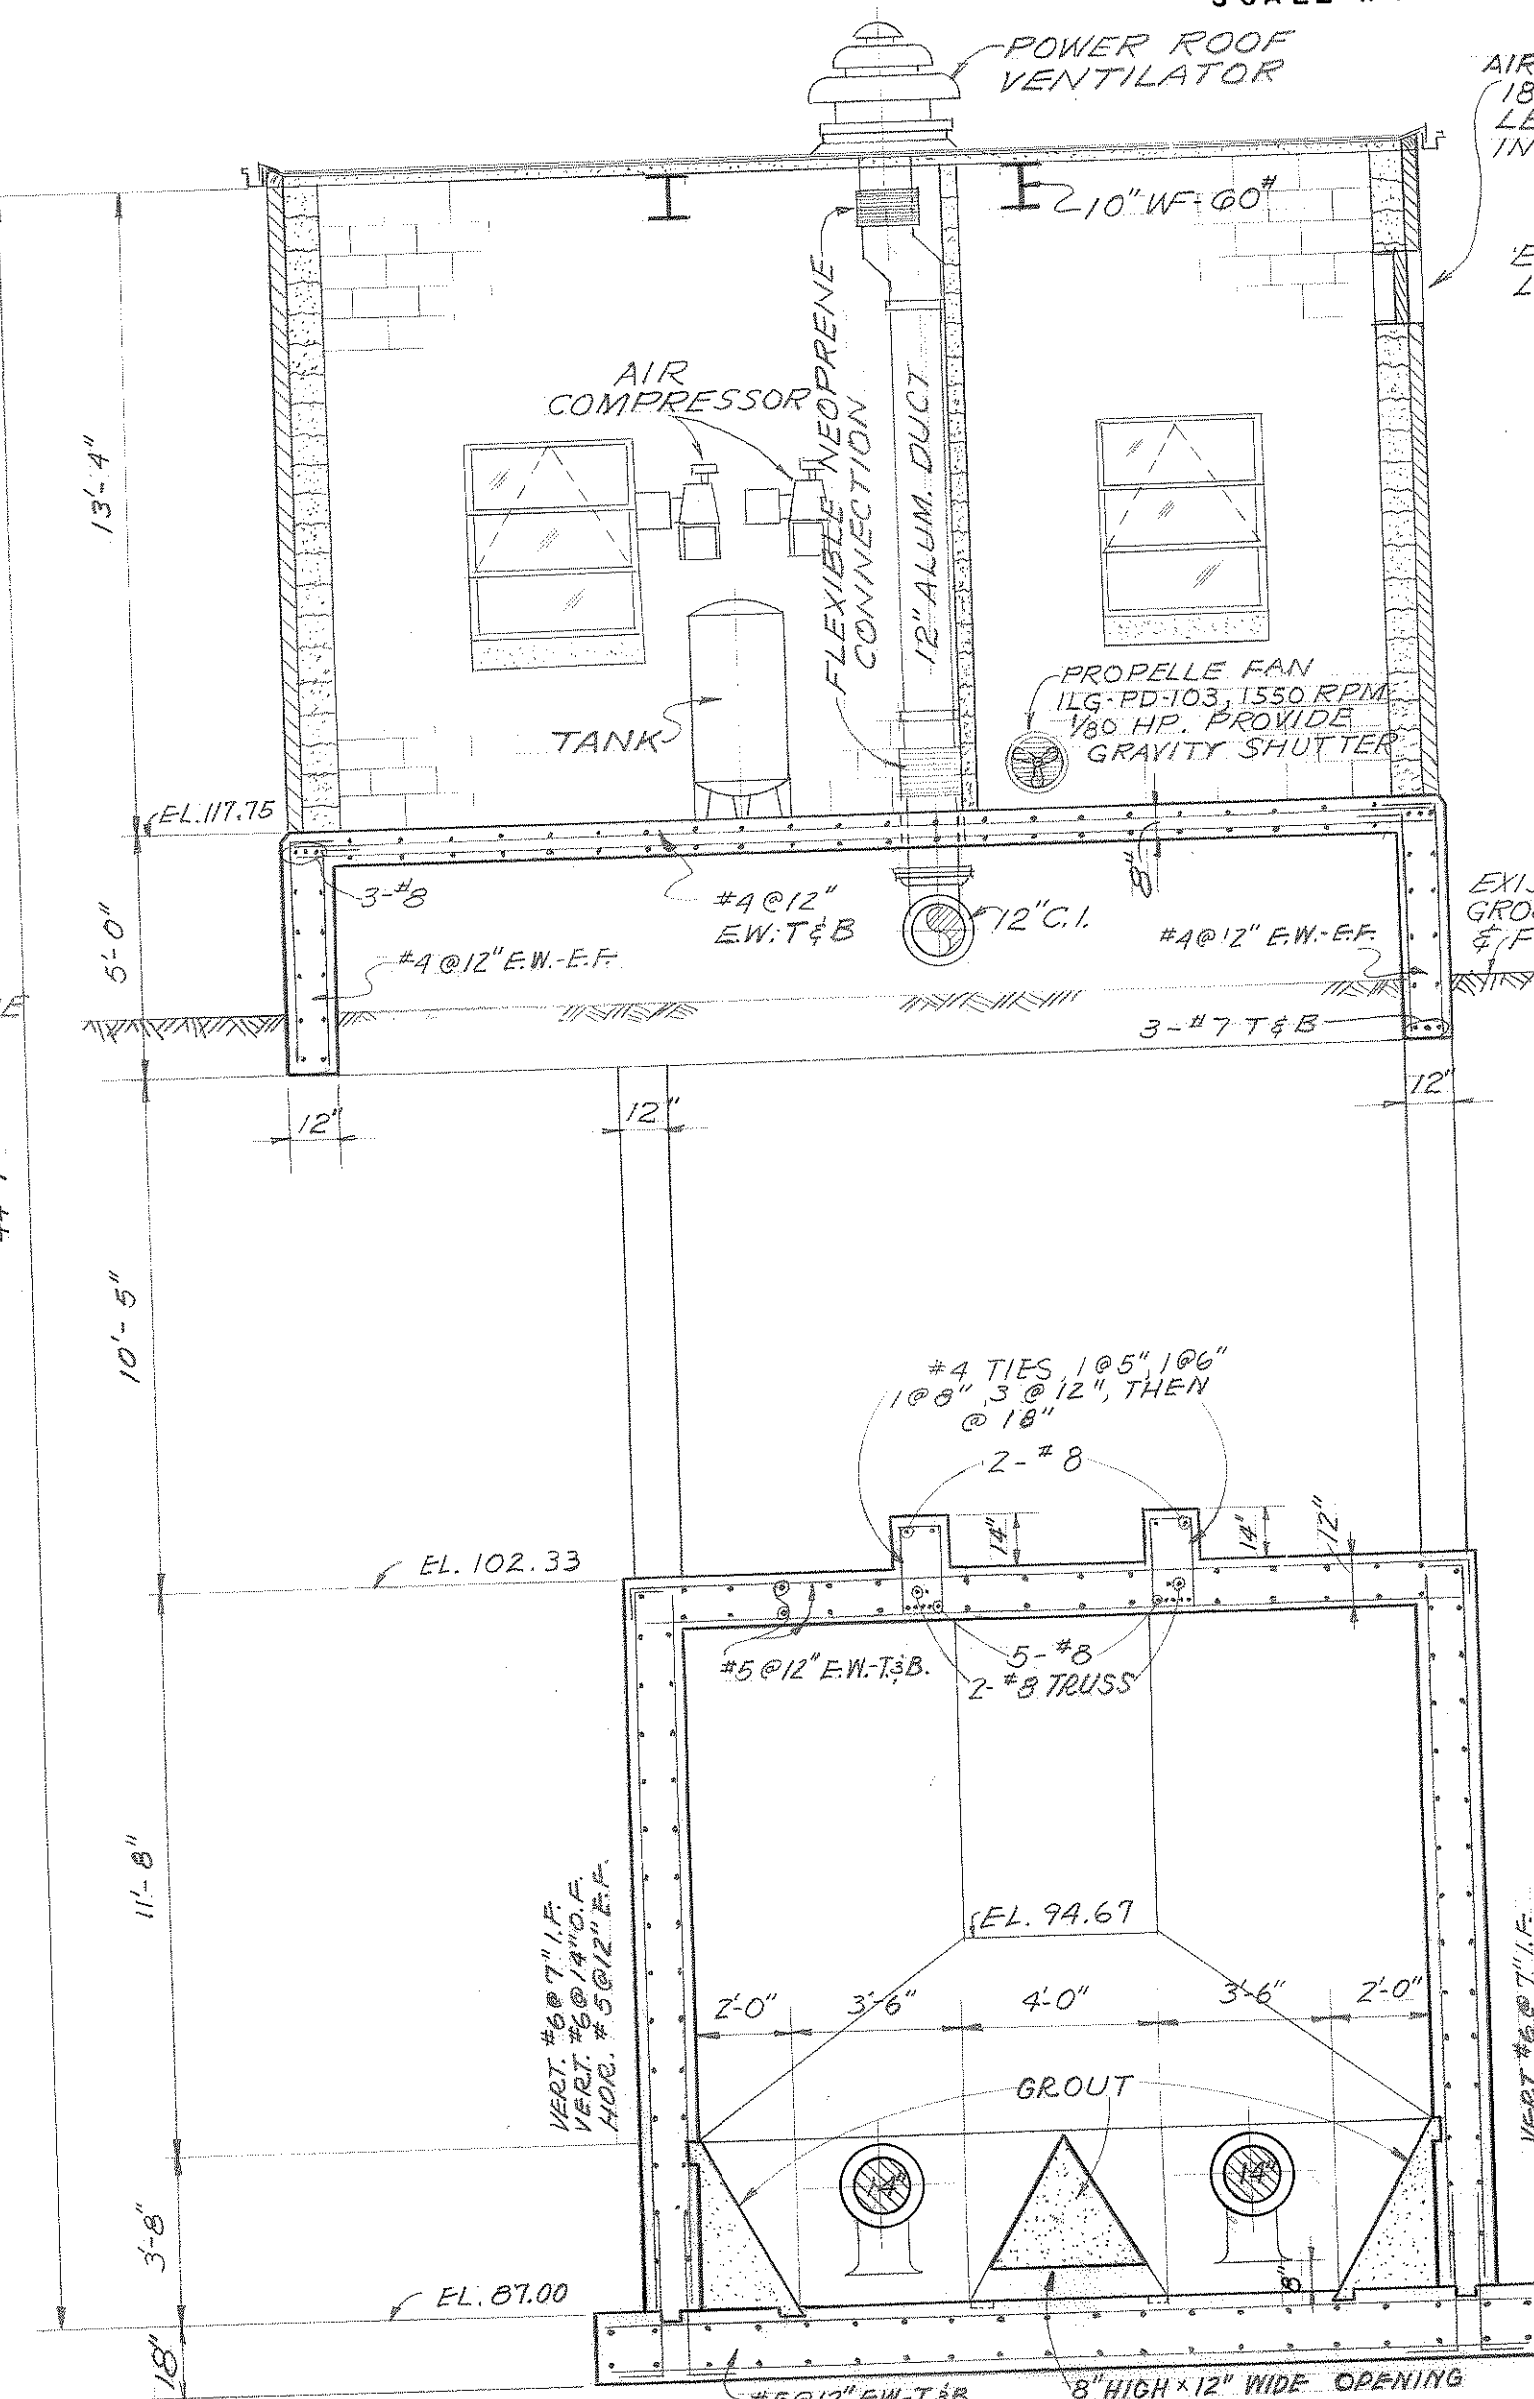


SECTION G-G

SCALE: 1/4" = 1'-0"

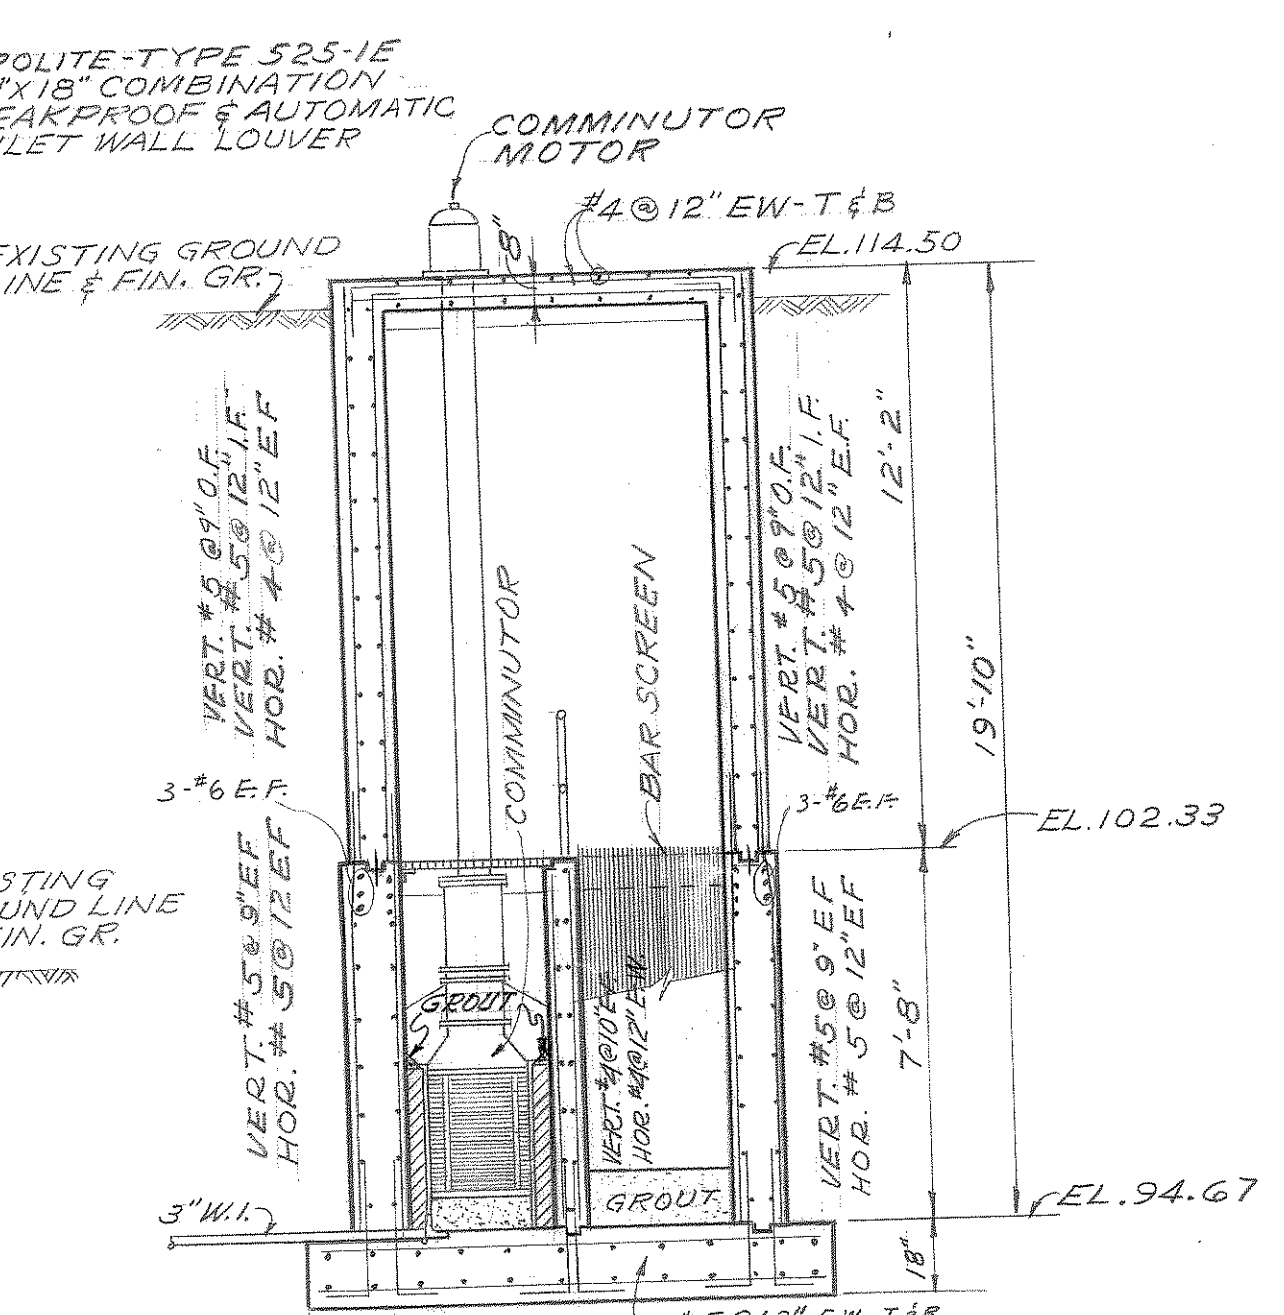


SECTION H-H

SCALE: 1/4" = 1'-0"

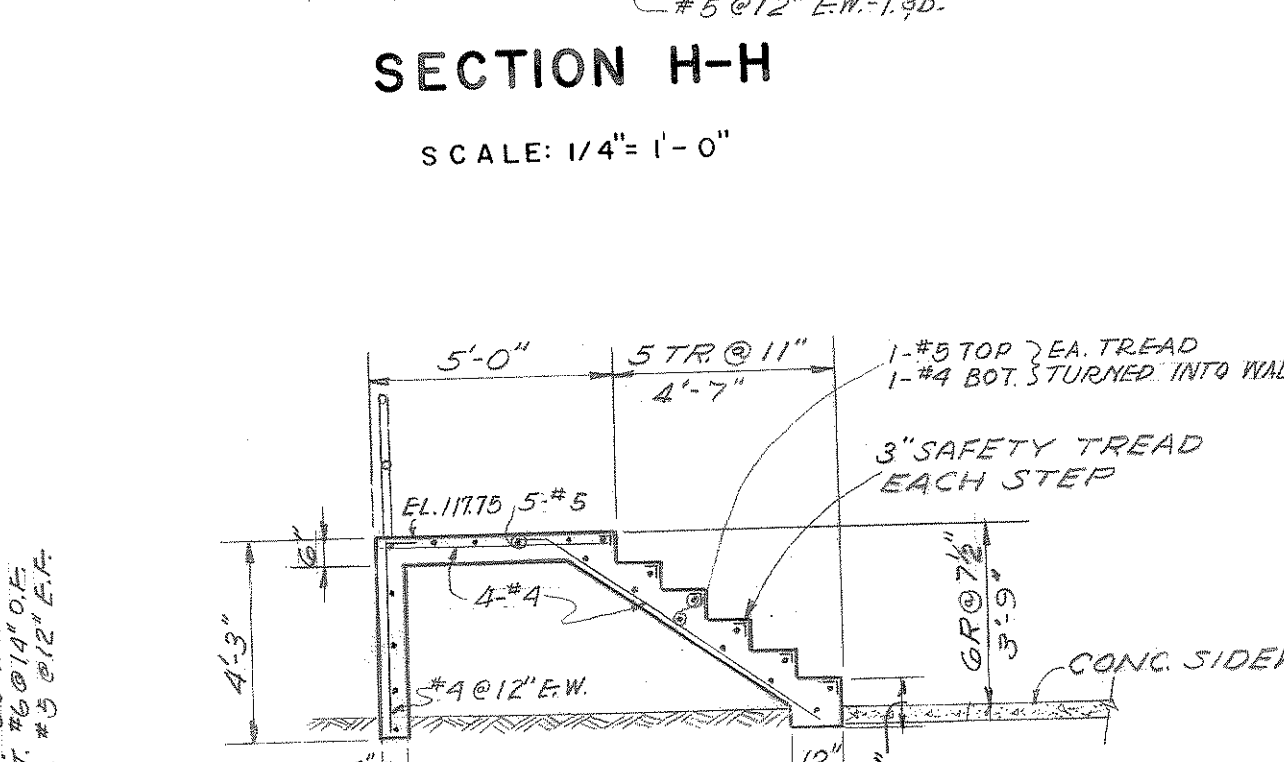

SECTION J-J

SCALE: 1/4" = 1'-0"

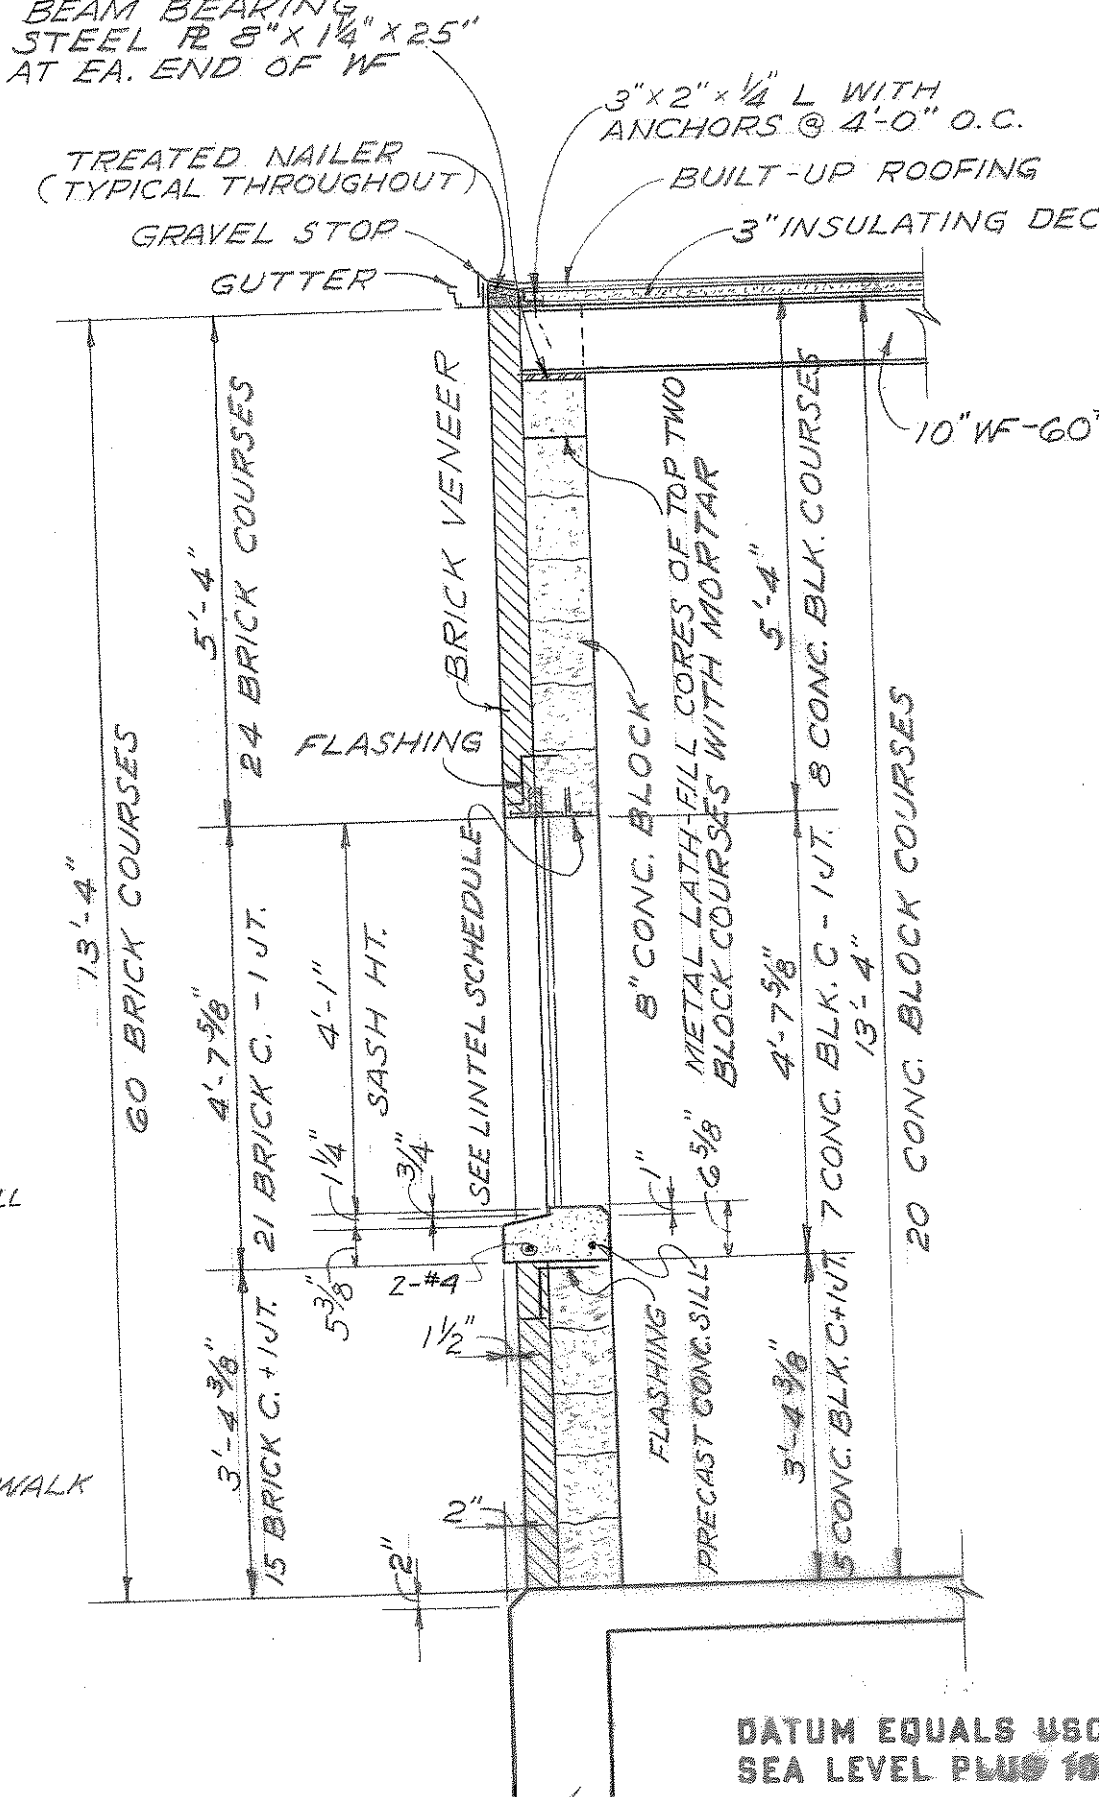

TYPICAL WALL SECTION
SCALE: 1/2" = 1'-0"
(FOR PUMPING STATION NO. 2, 3, 5)


NOTE:
PROVIDE "4" @ 12" FOR CONCRETE PIERS
OR FOUNDATIONS FOR ALL PUMPS,
BASE ELLS AND PIPING.
EXTEND PIERS UNDER PIPING UP TO
MIDPOINT OF PIPE.

CONTRACT 'C'


CITY OF BRUNSWICK, GEORGIA
SEWERAGE SYSTEM IMPROVEMENTS

RAW SEWAGE
PUMPING STATION NO. 3


SCALE AS SHOWN	WIEDEMAN AND SINGLETON ENGINEERS	SHEET 7
DATE JULY, 1963	ATLANTA	GEORGIA
		OF 15

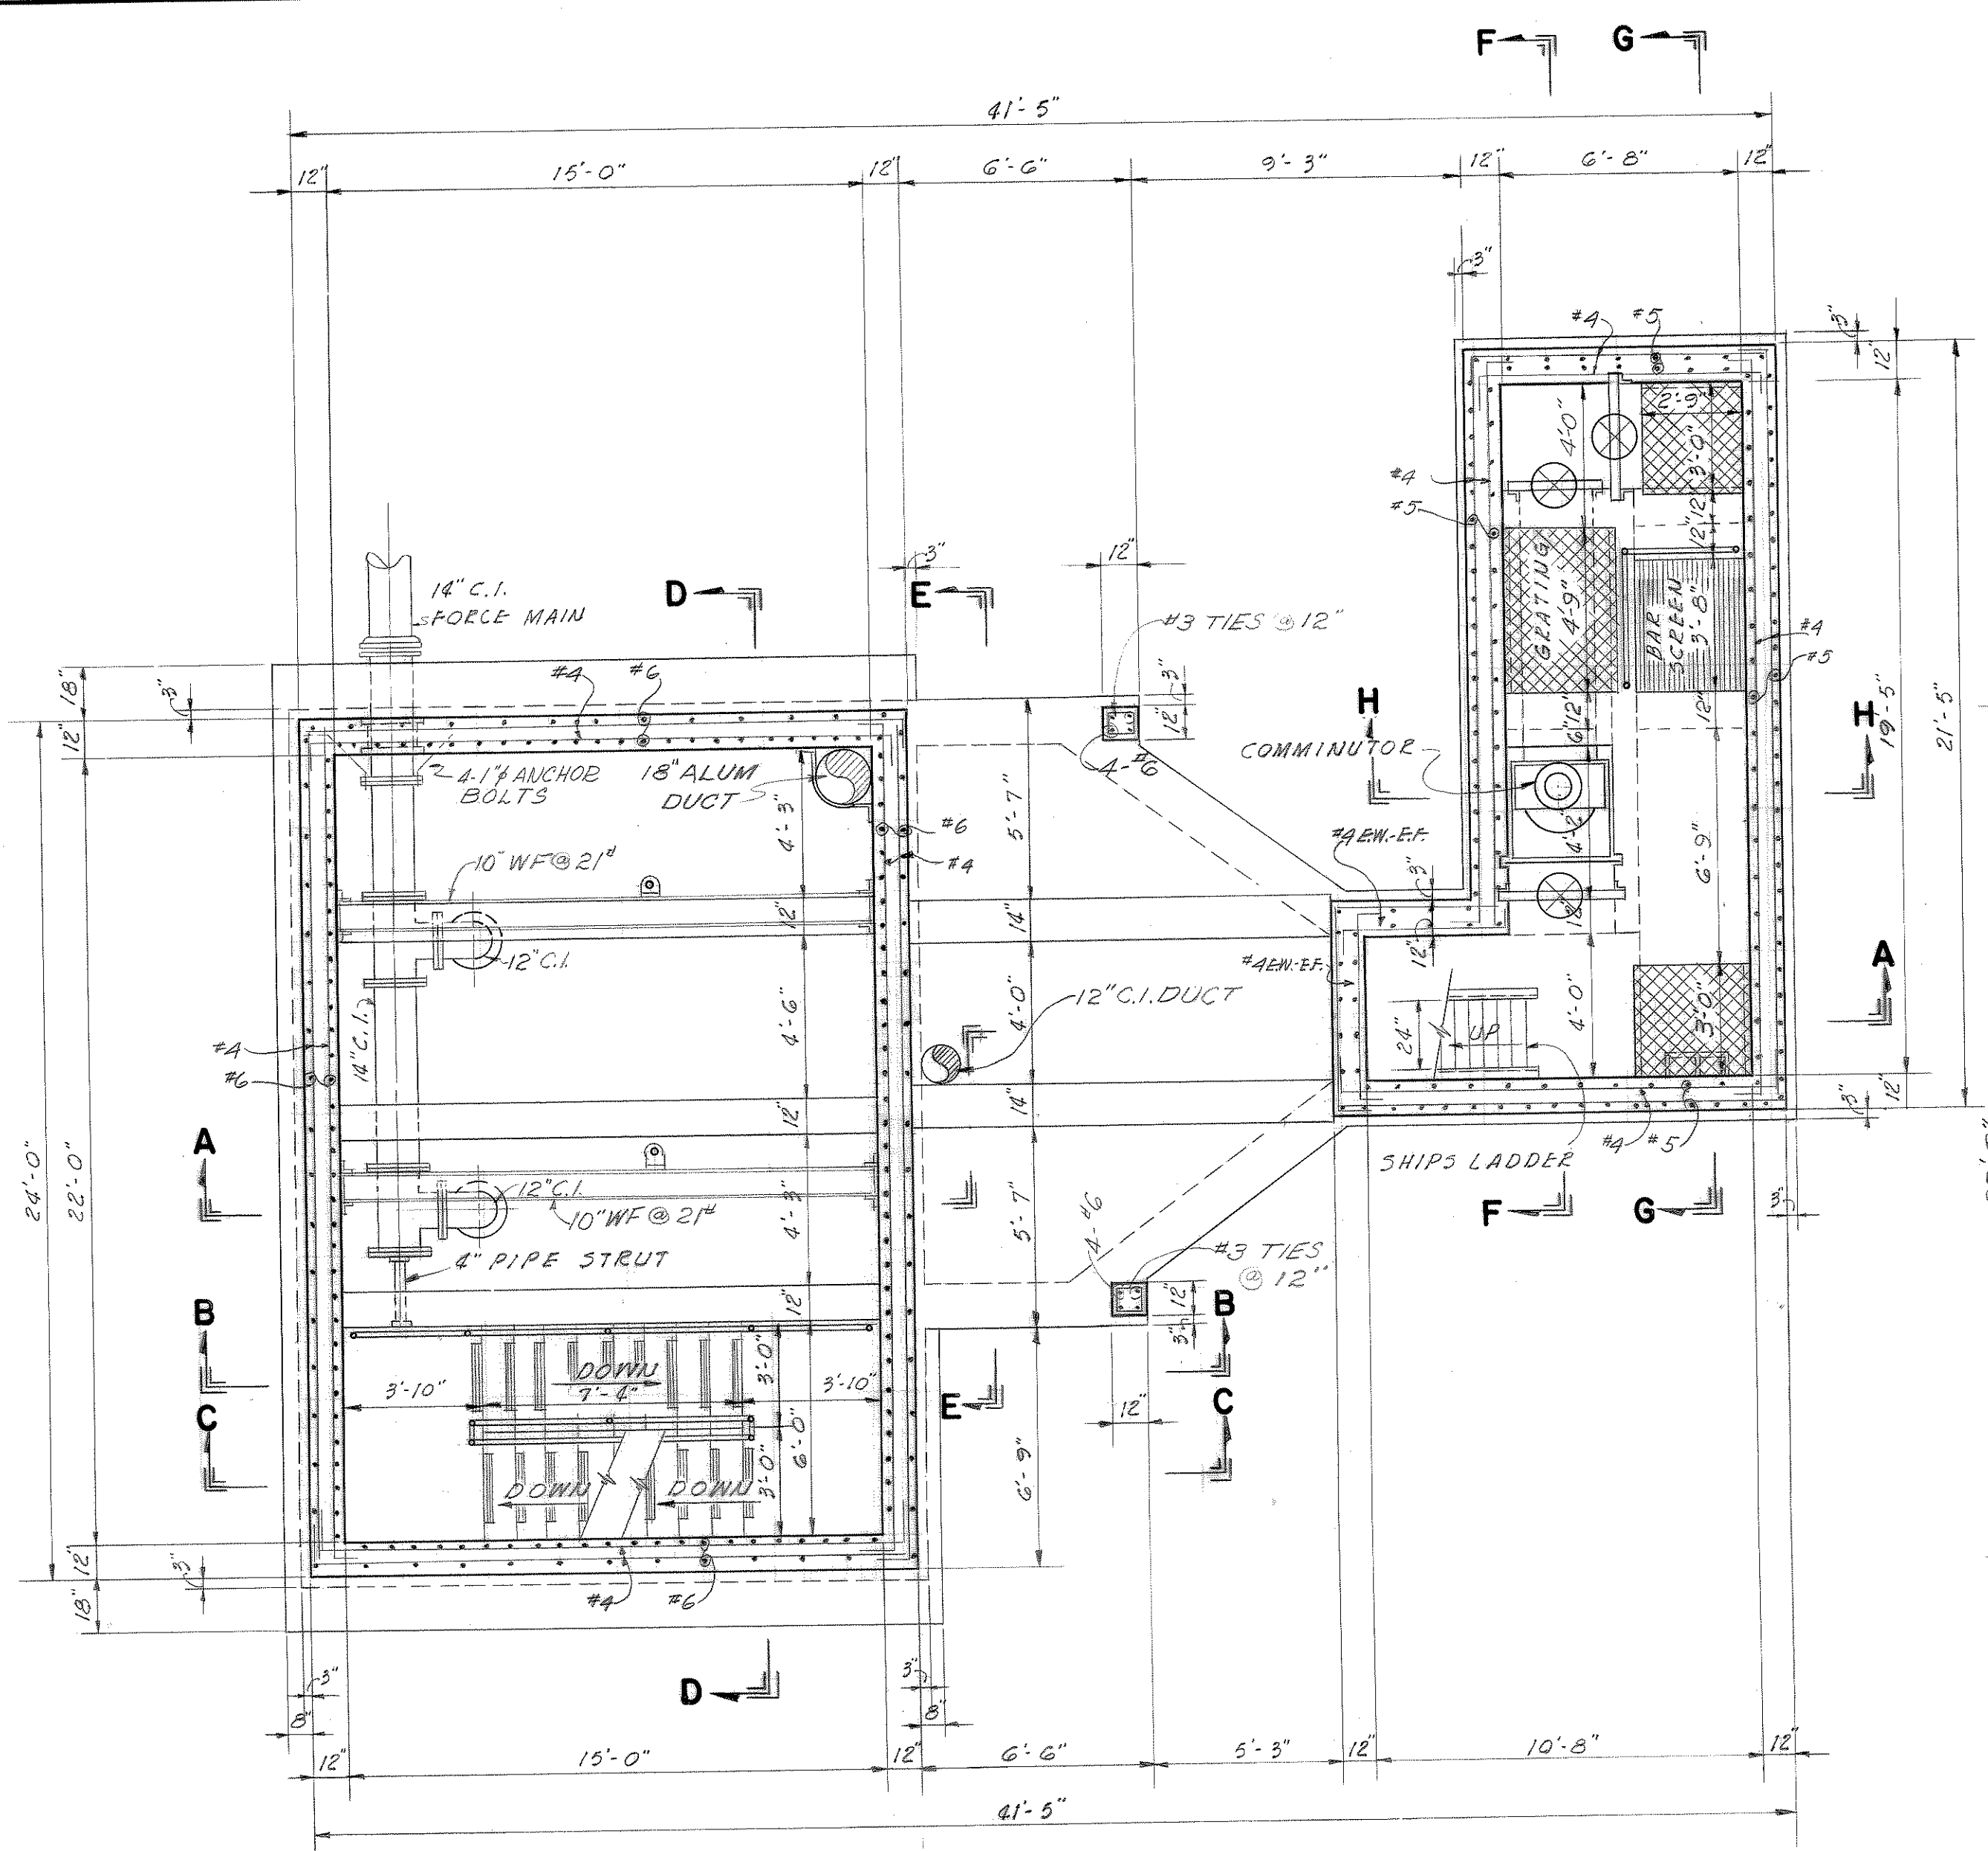


WALL PLAN
SCALE: 1/4" = 1'-0"

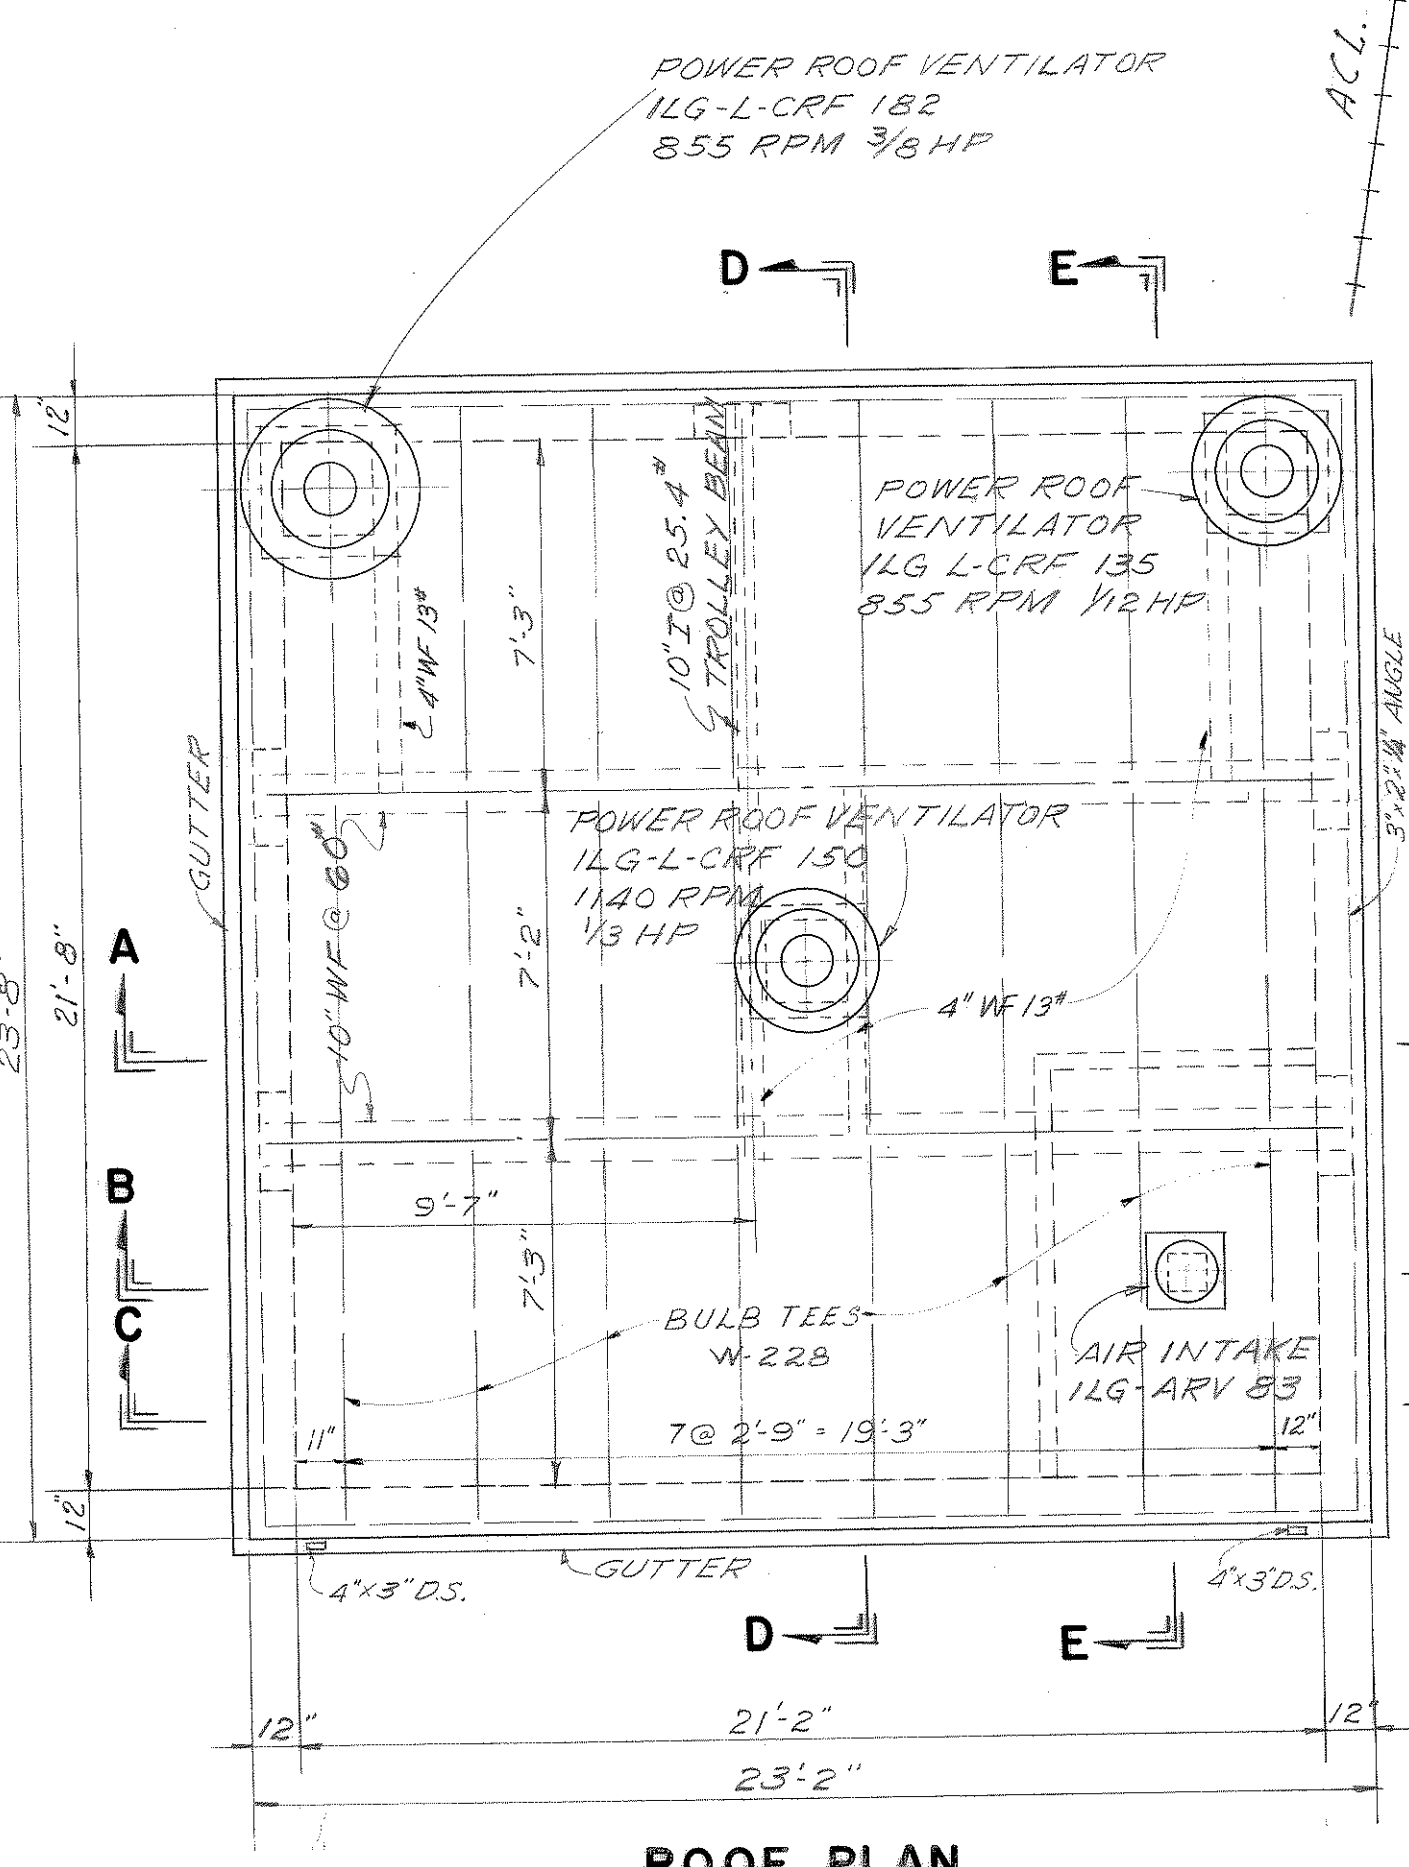


ROOF PLAN
SCALE: 1/4" = 1'-0"

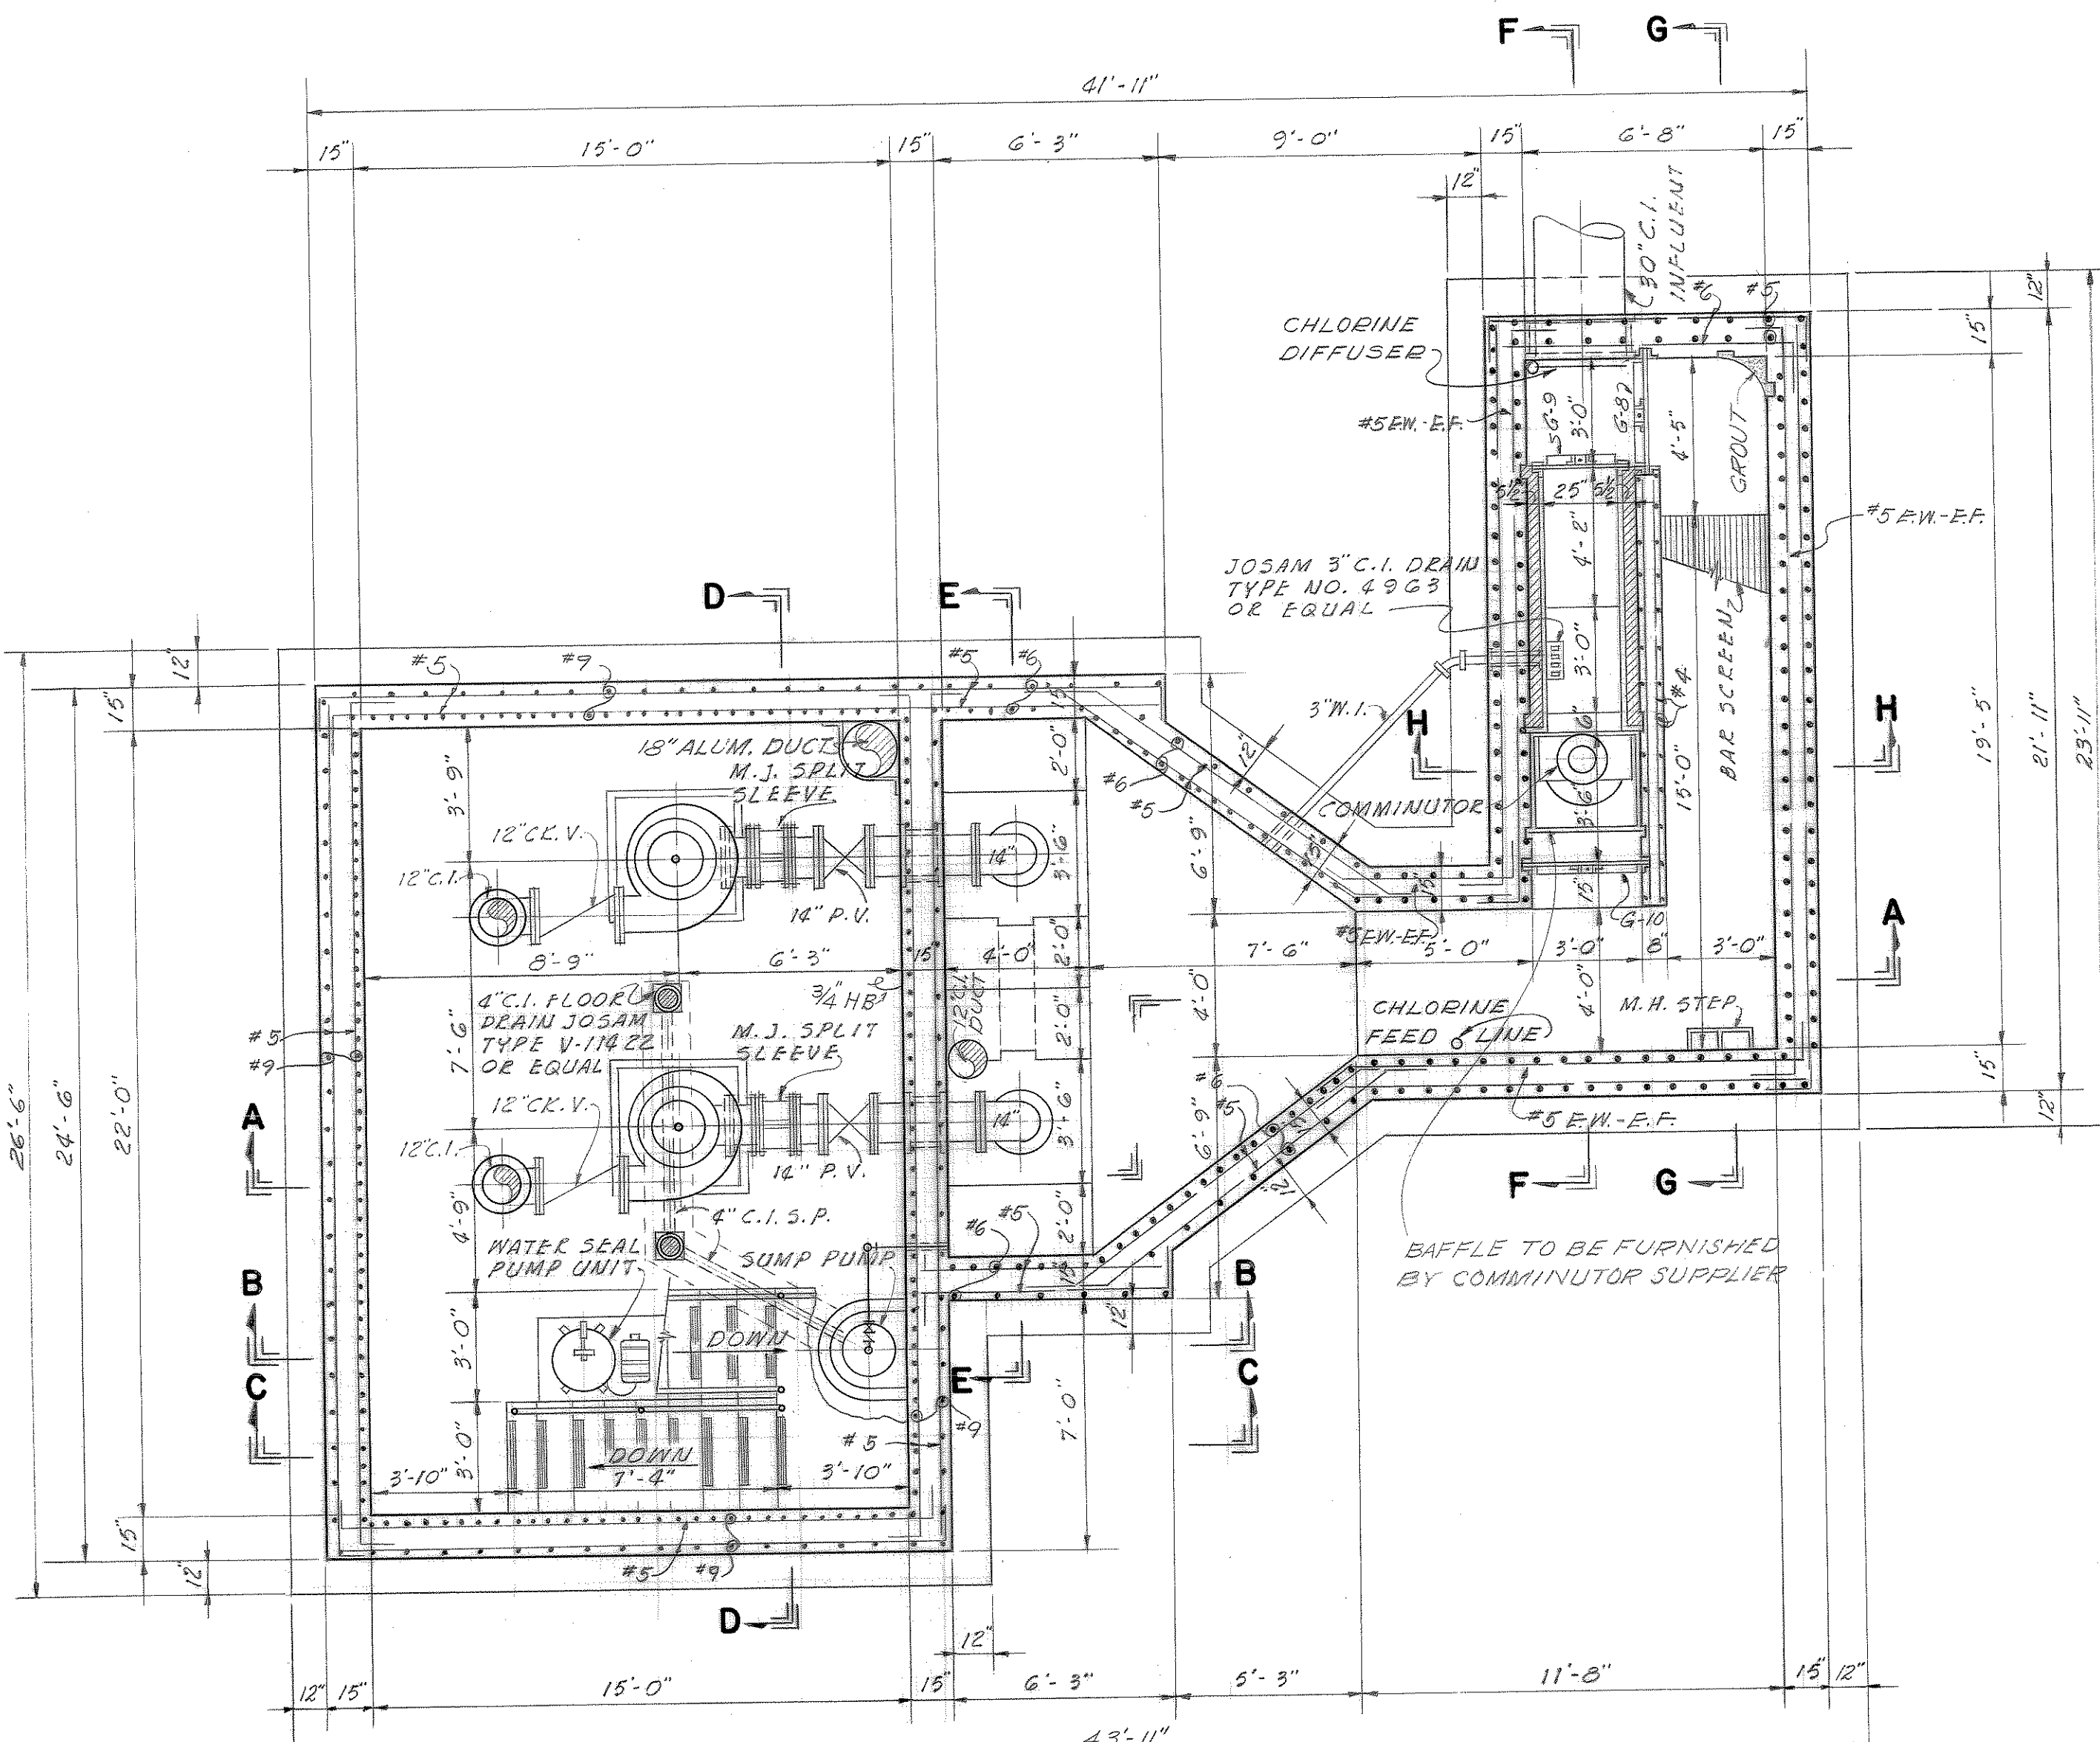

FOUNDATION PLAN
SCALE: 1/4" = 1'-0"

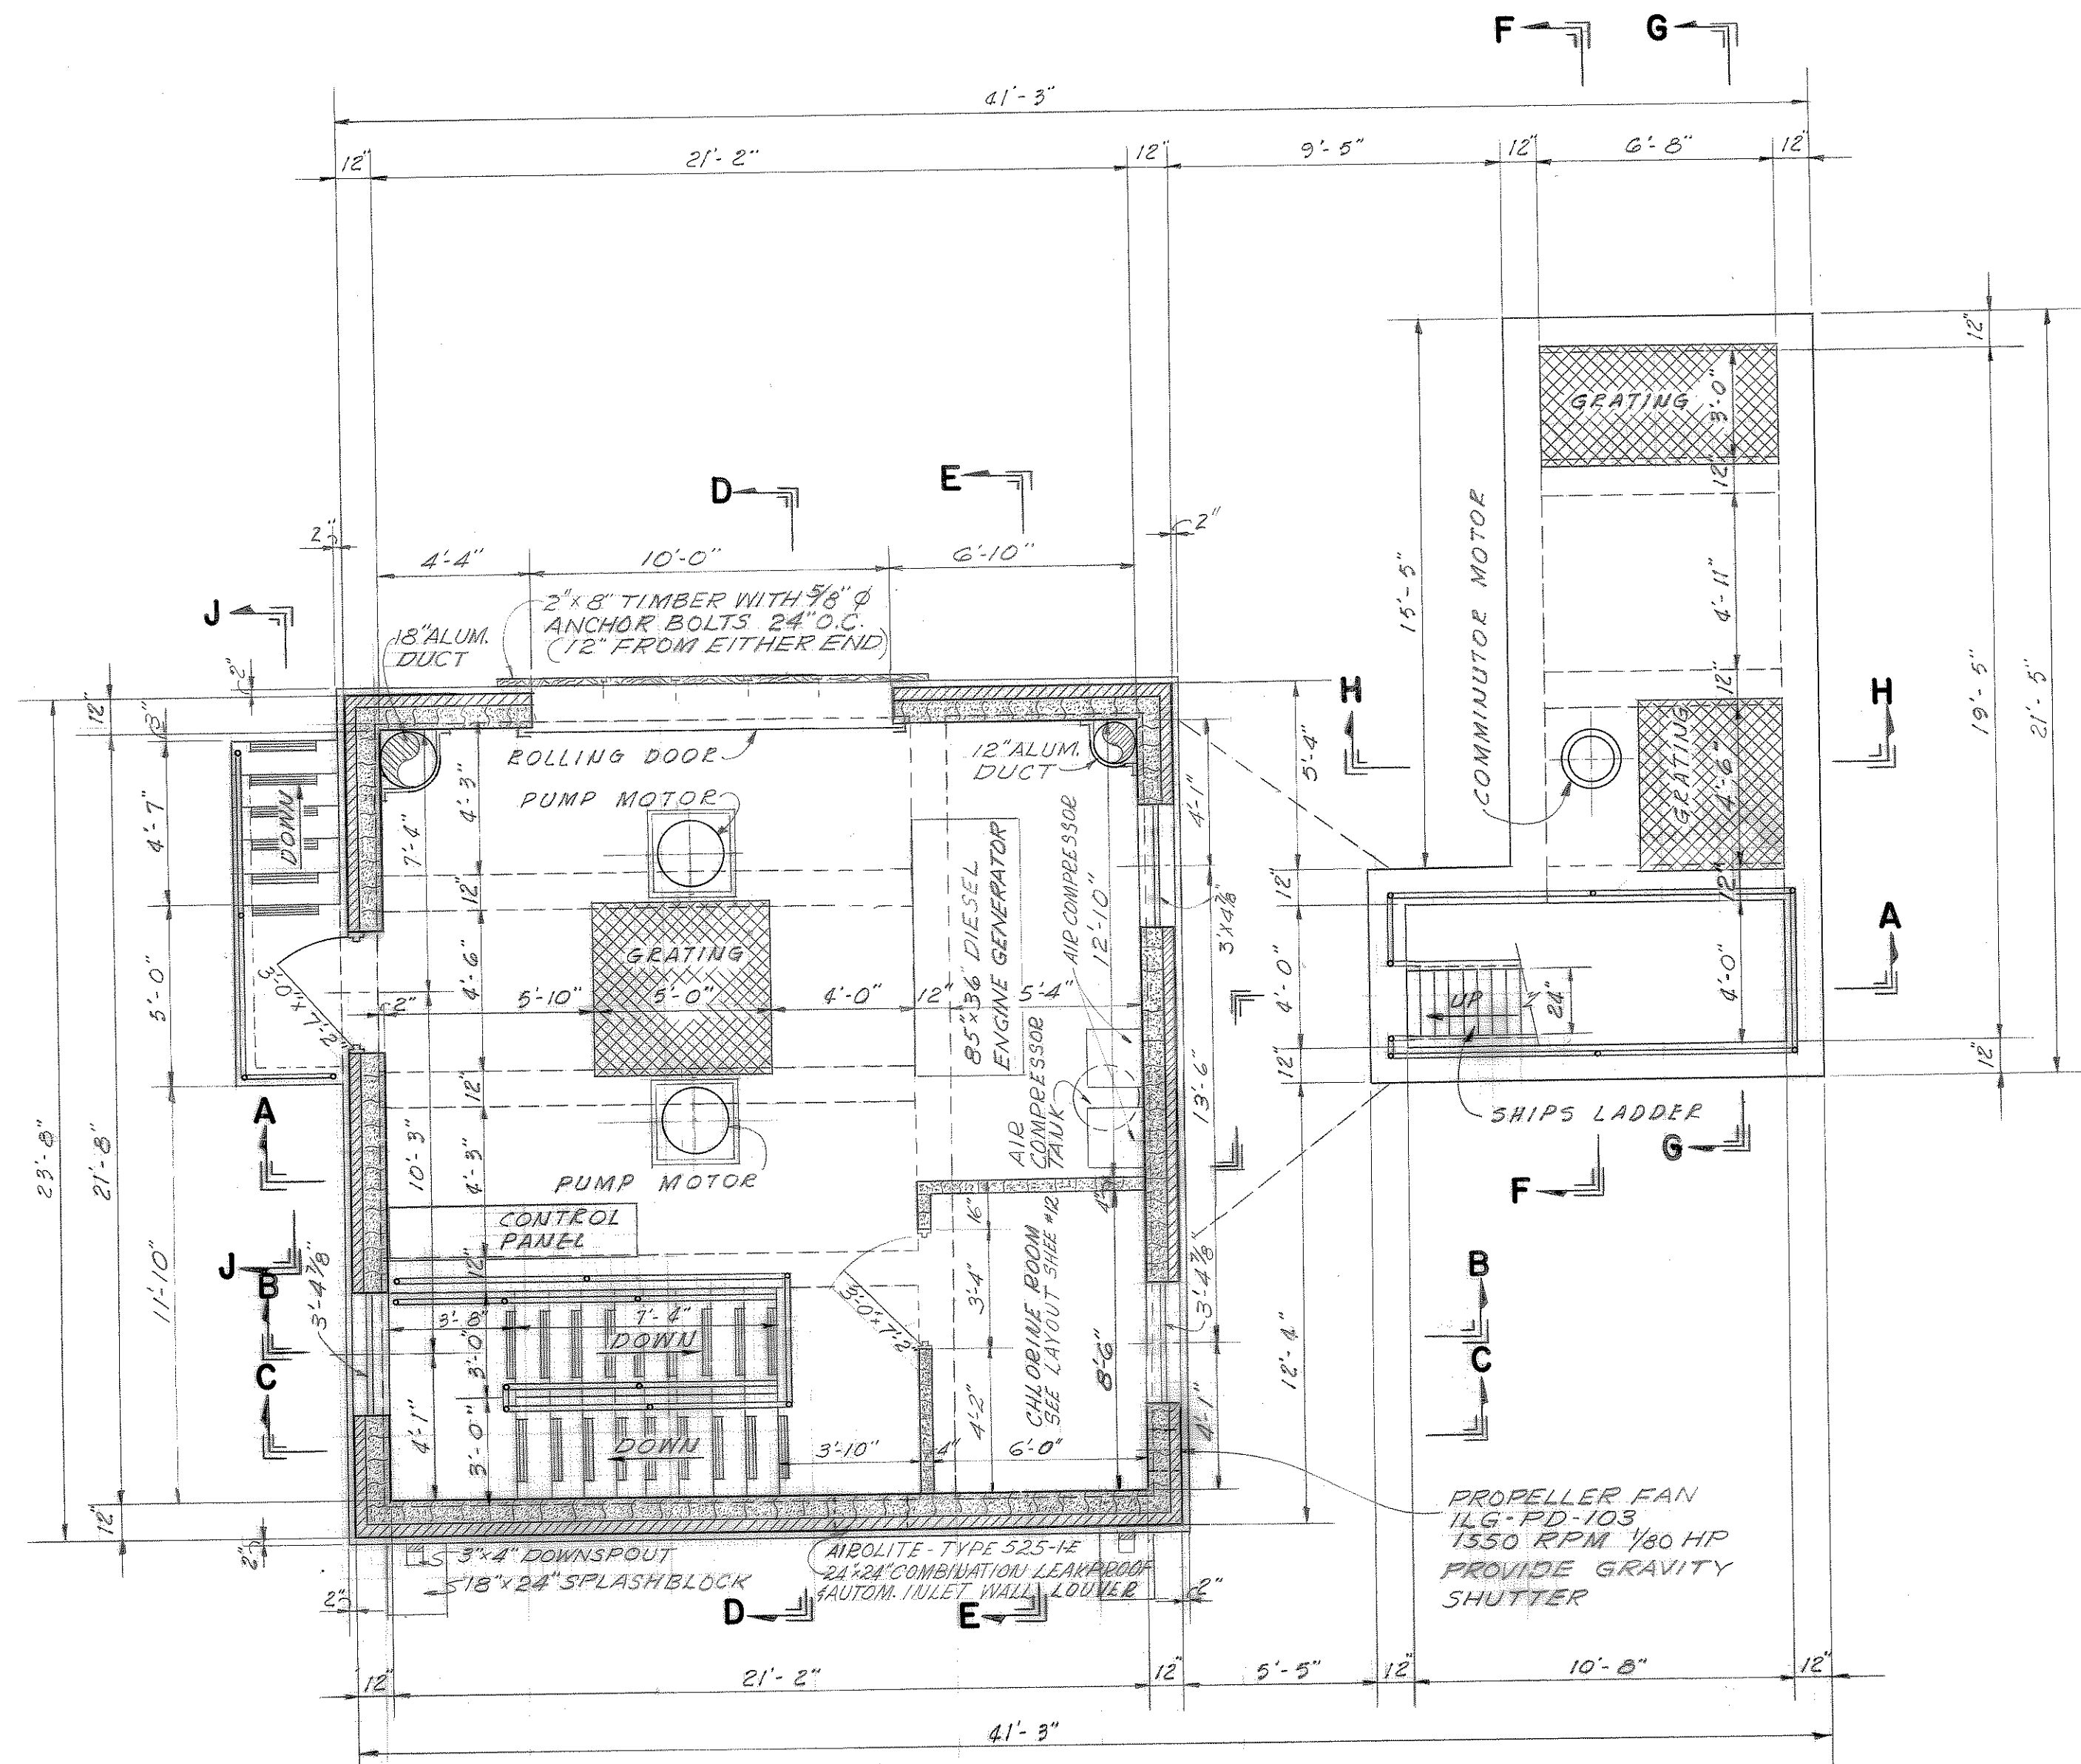

ENTRANCE FLOOR PLAN
SCALE: 1/4" = 1'-0"

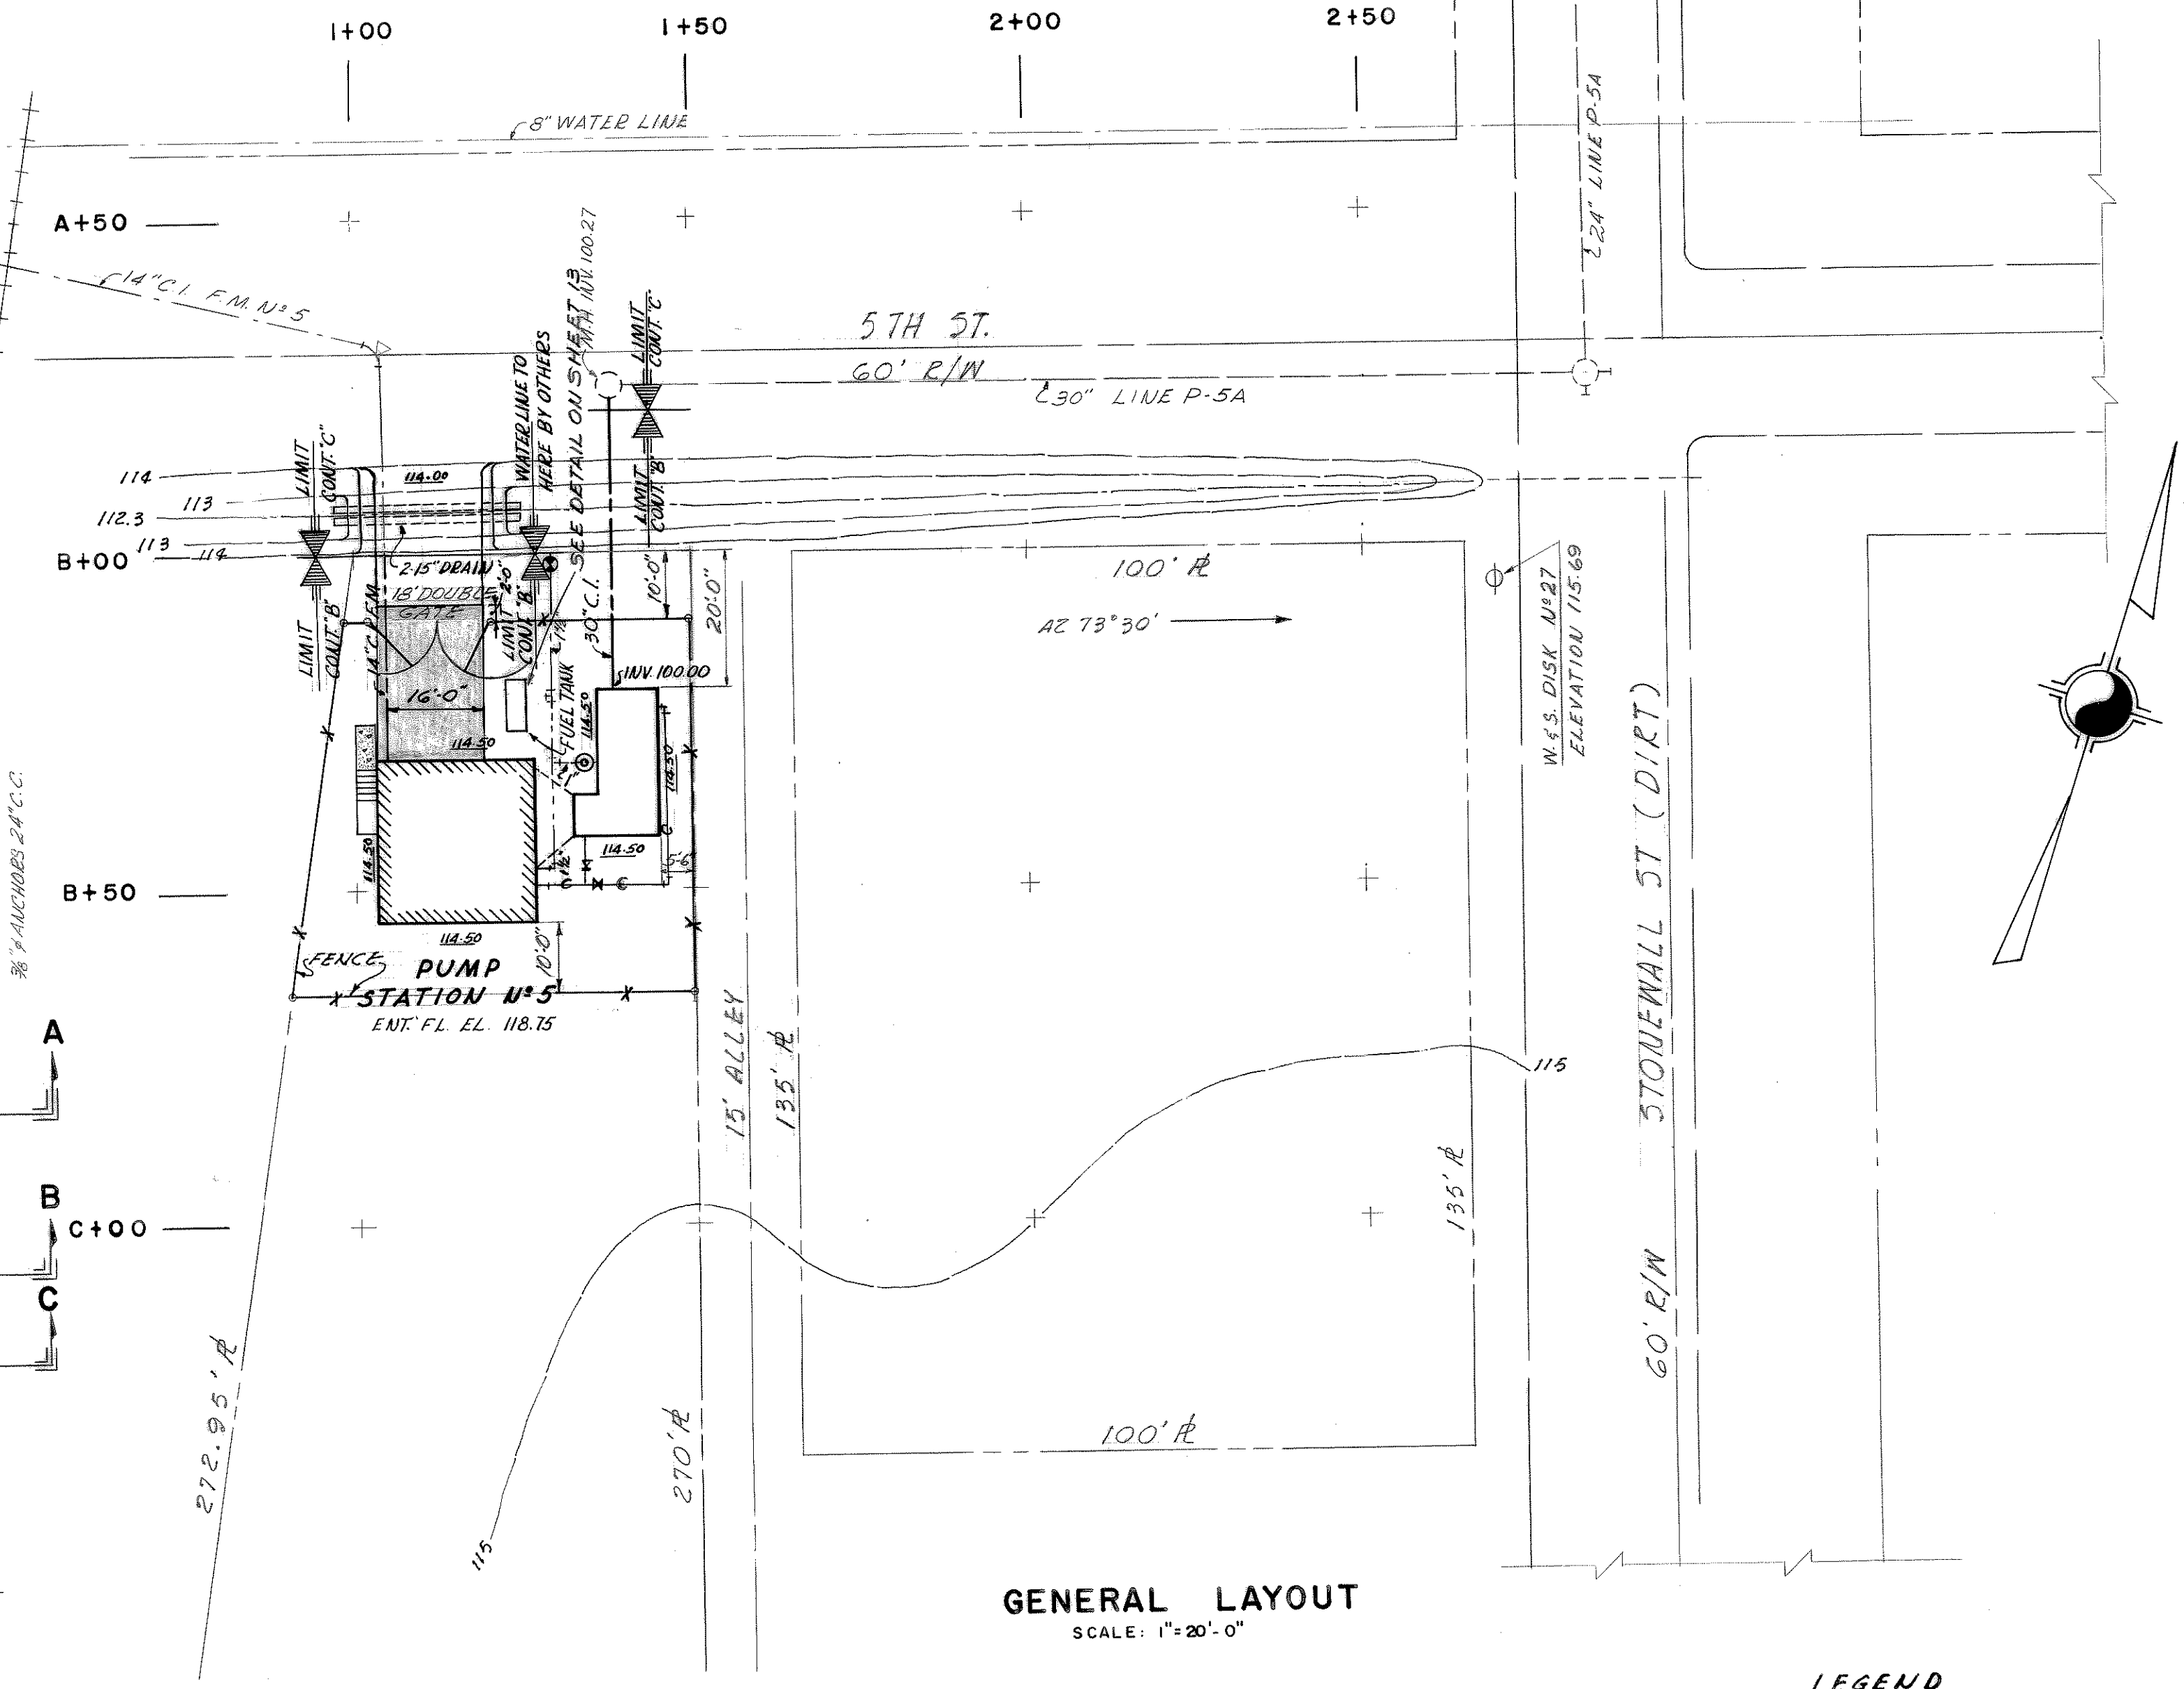

GENERAL LAYOUT
SCALE: 1" = 20'-0"

LEGEND		STRUCTURE
EXISTING	PROPOSED	
114	114.50	CONTOUR
---	---	FIN. GRADE ELEVATION
---	---	SAN. SEWER
---	---	C.I. PIPE
---	---	VALVE & VALVE BOX
---	---	GALV. IRON PIPE
---	---	YARD HYDRANT
---	---	R/W OR R
---	---	PAVED ROADWAY
---	---	CHLORINE LINE (PVC)










CONTRACT 'C'

CITY OF BRUNSWICK, GEORGIA
SEWERAGE SYSTEM IMPROVEMENTS

RAW SEWAGE
PUMPING STATION NO. 5

SCALE	WIEDEMAN AND SINGLETON	SHEET
AS SHOWN	ENGINEERS	8
DATE	ATLANTA	OF 15
JULY, 1963	GEORGIA	

DATUM EQUALS USCGS MEAN
SEA LEVEL PLUS 100.00 FT.

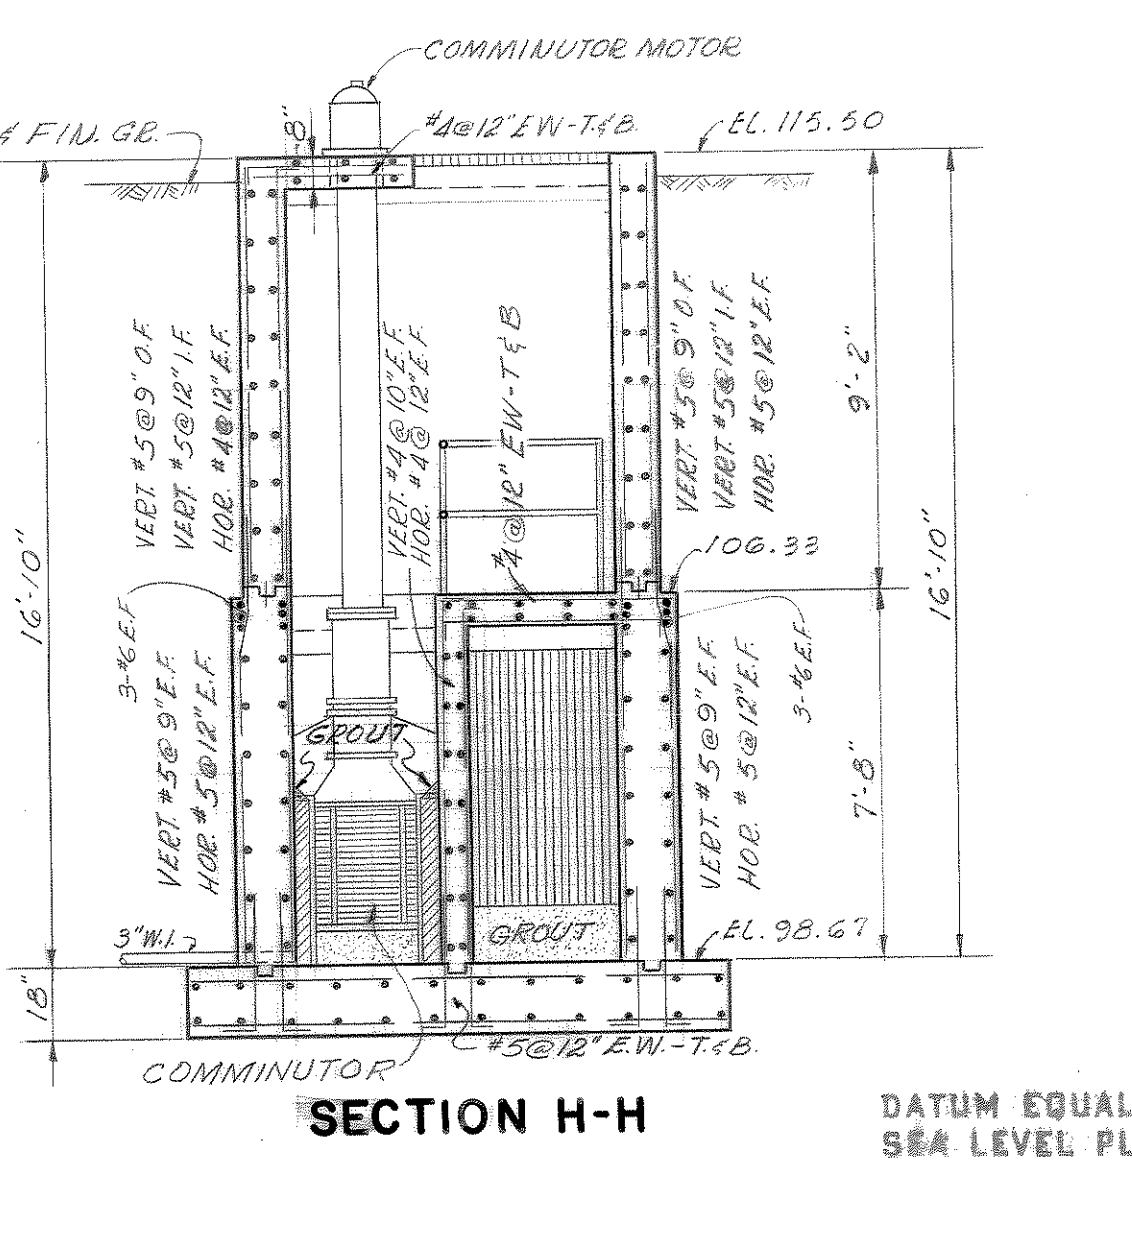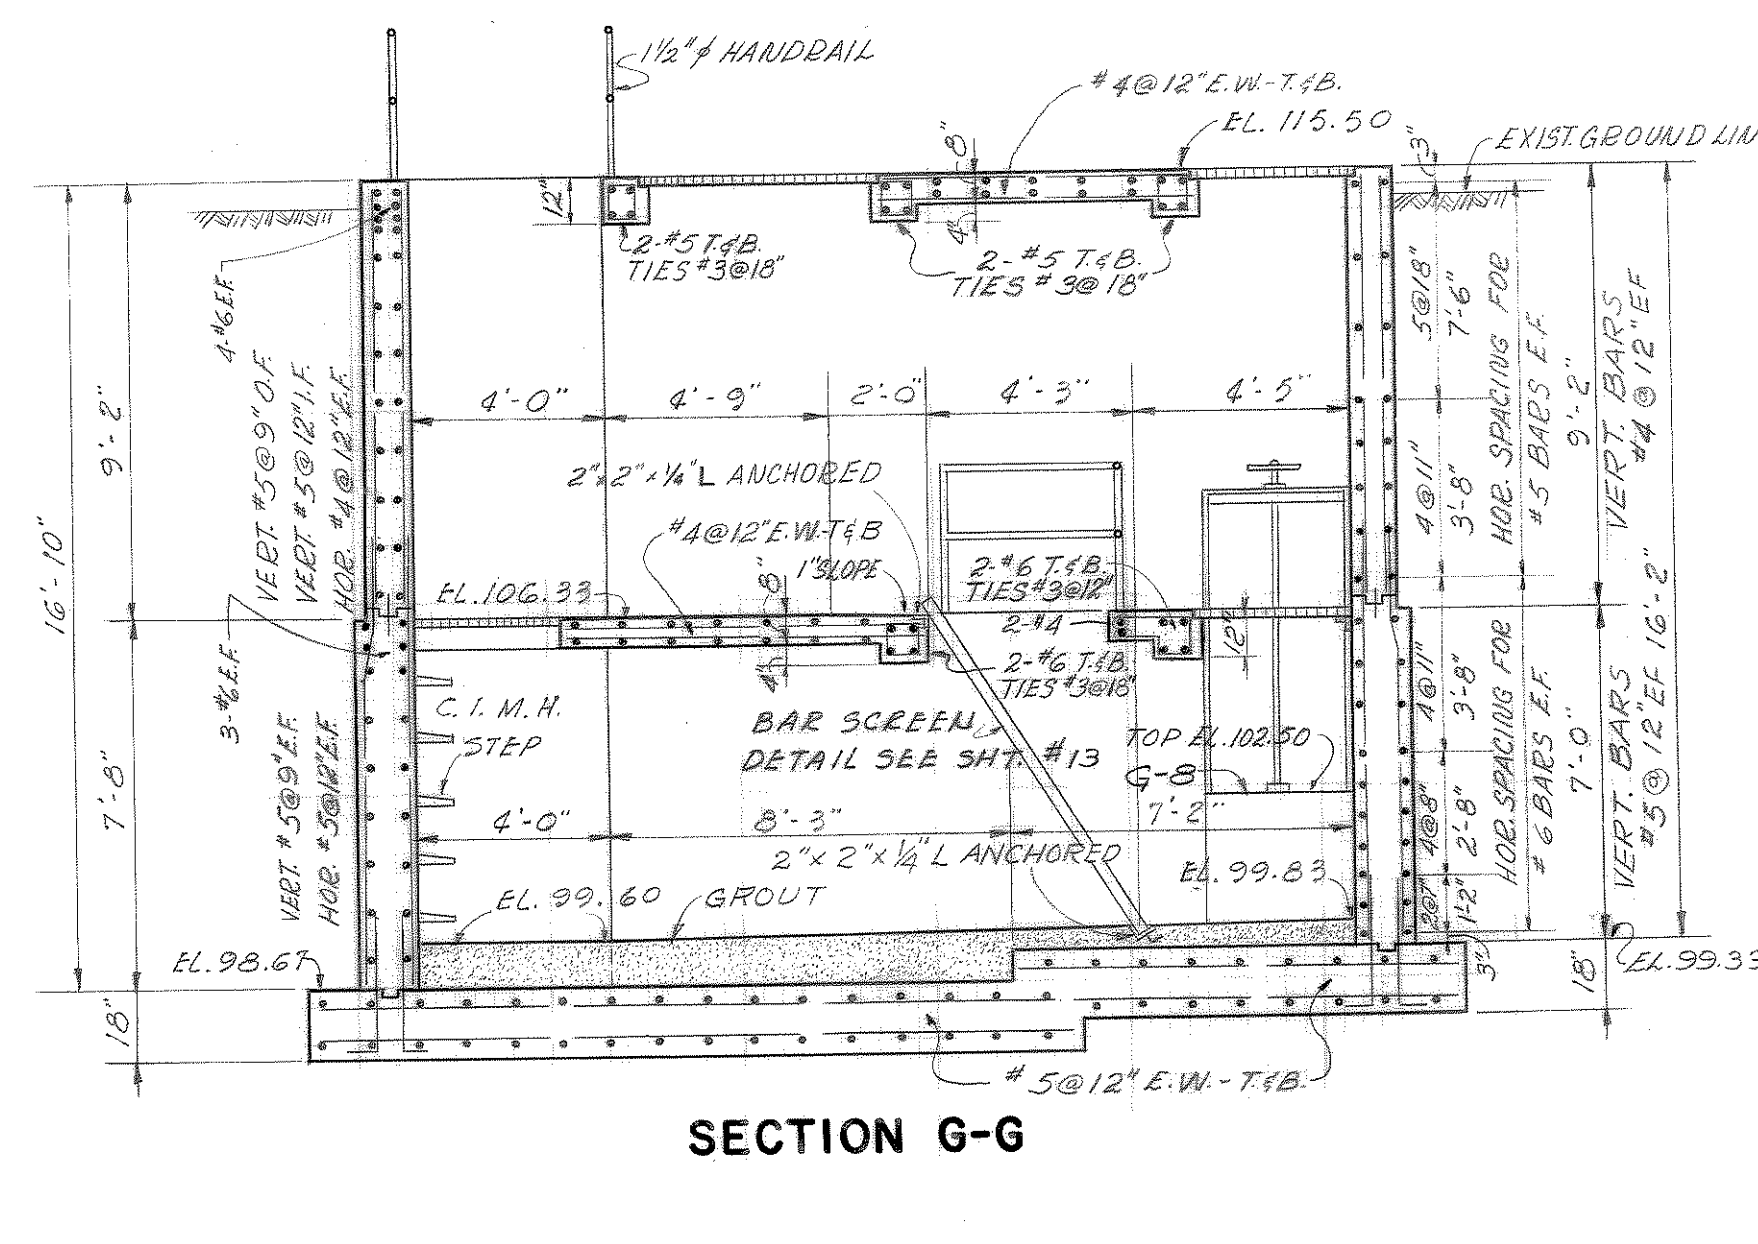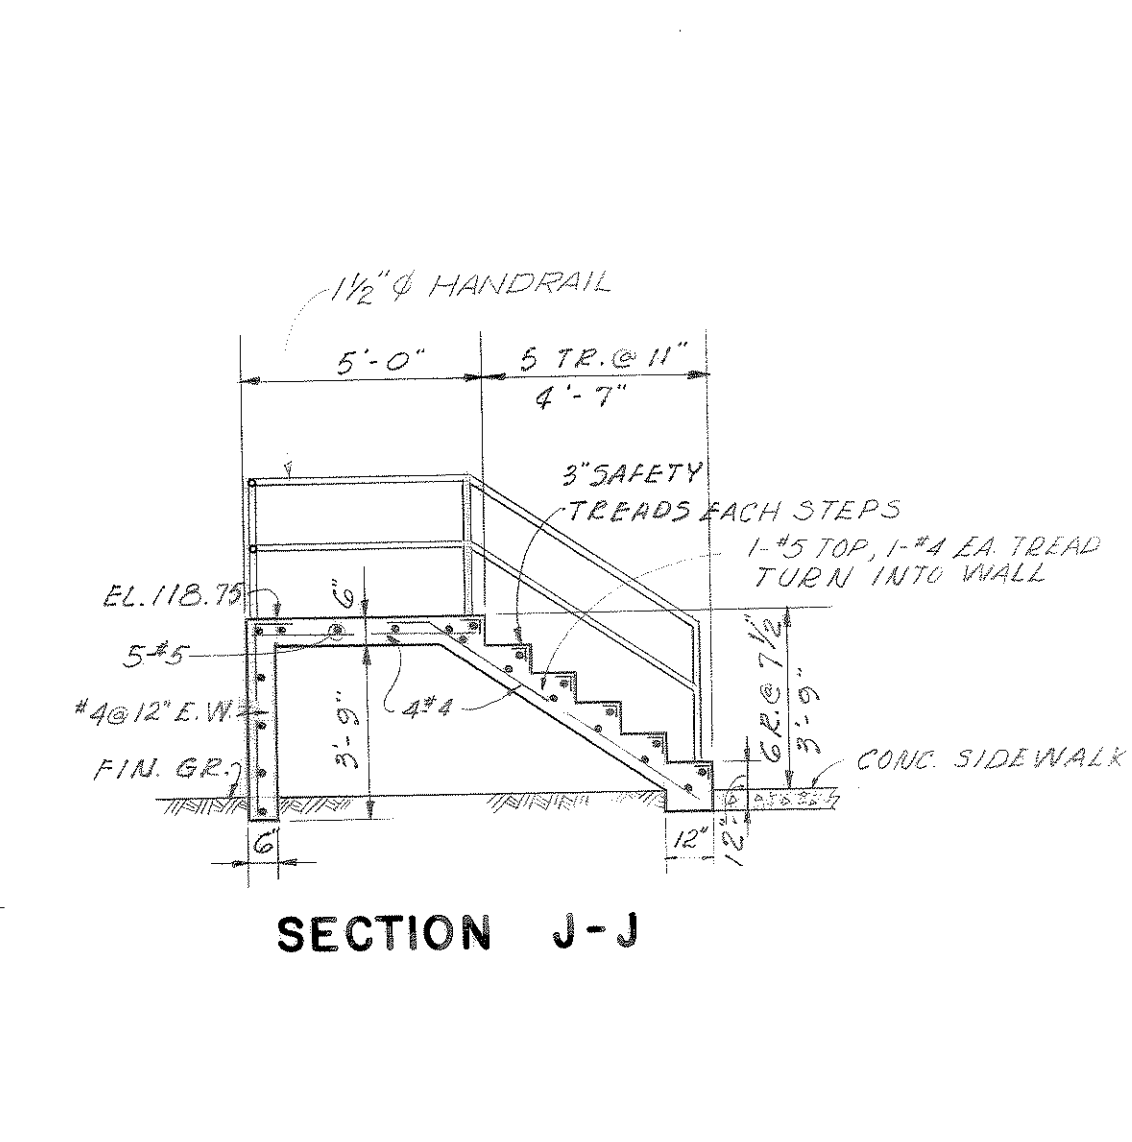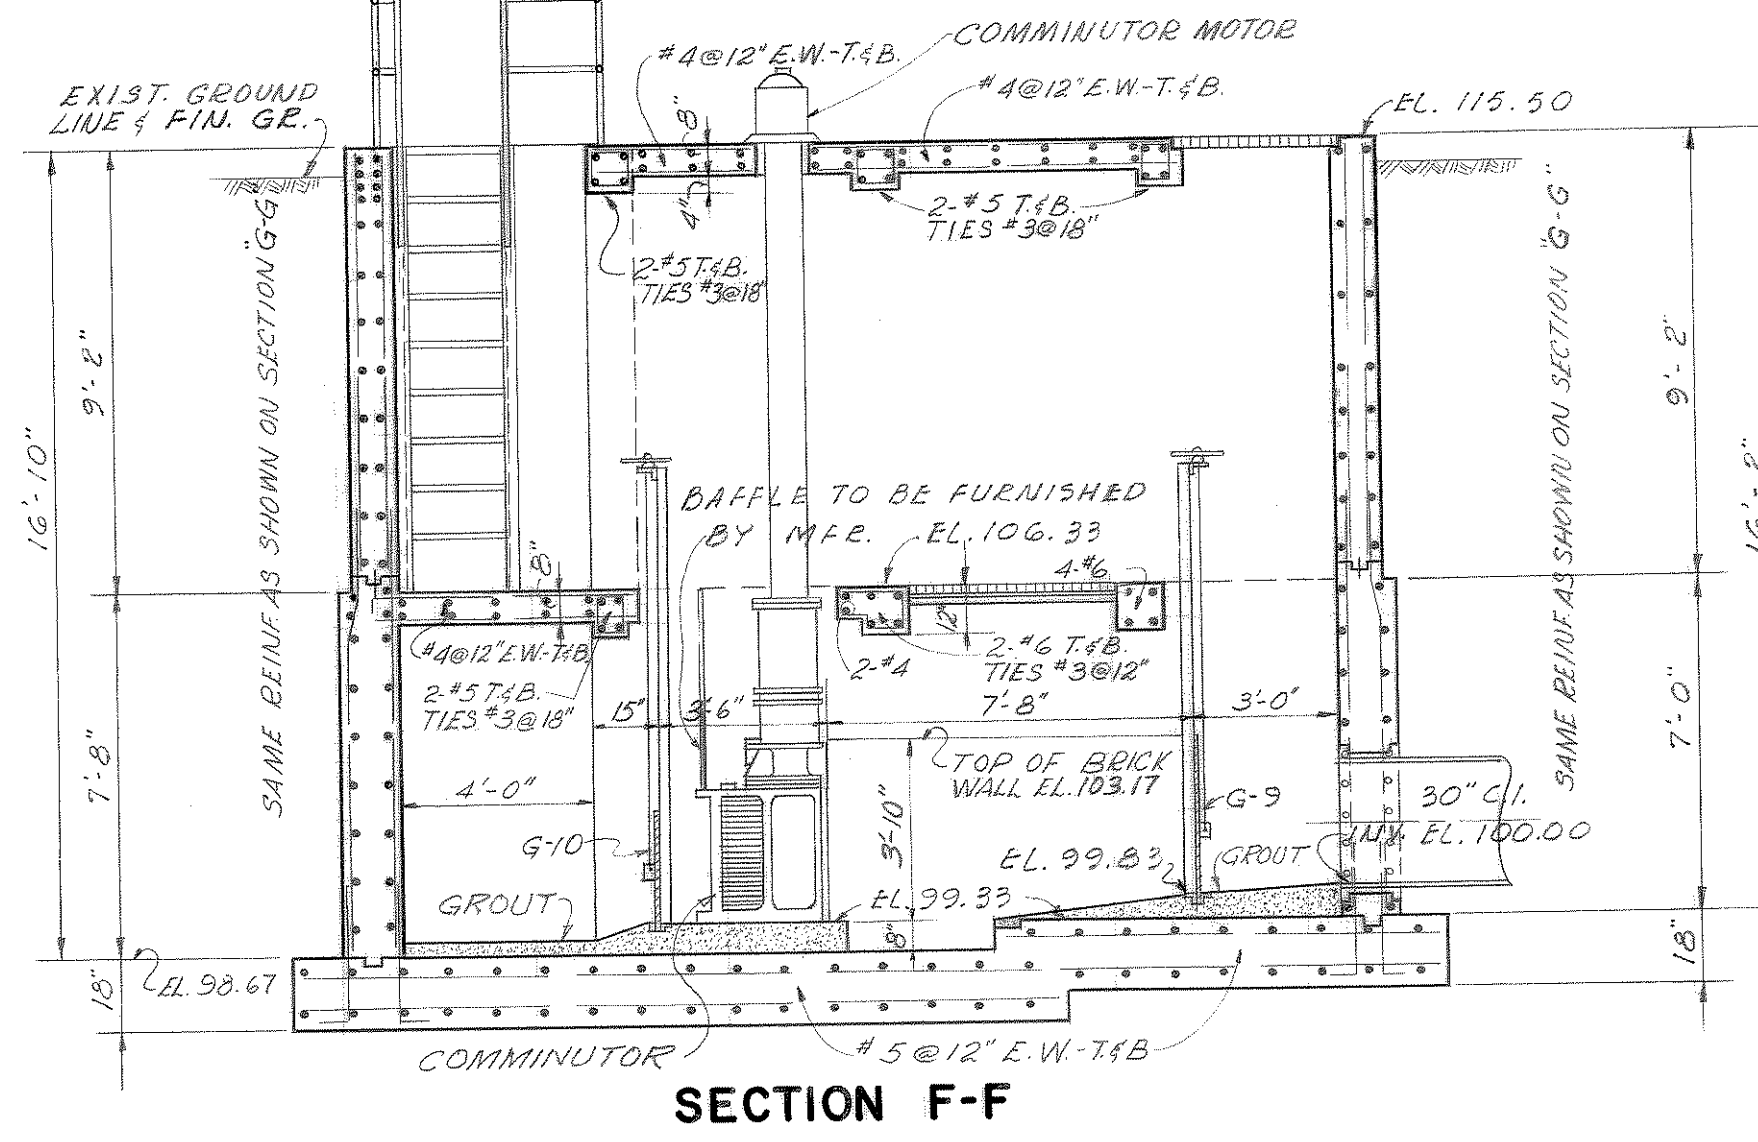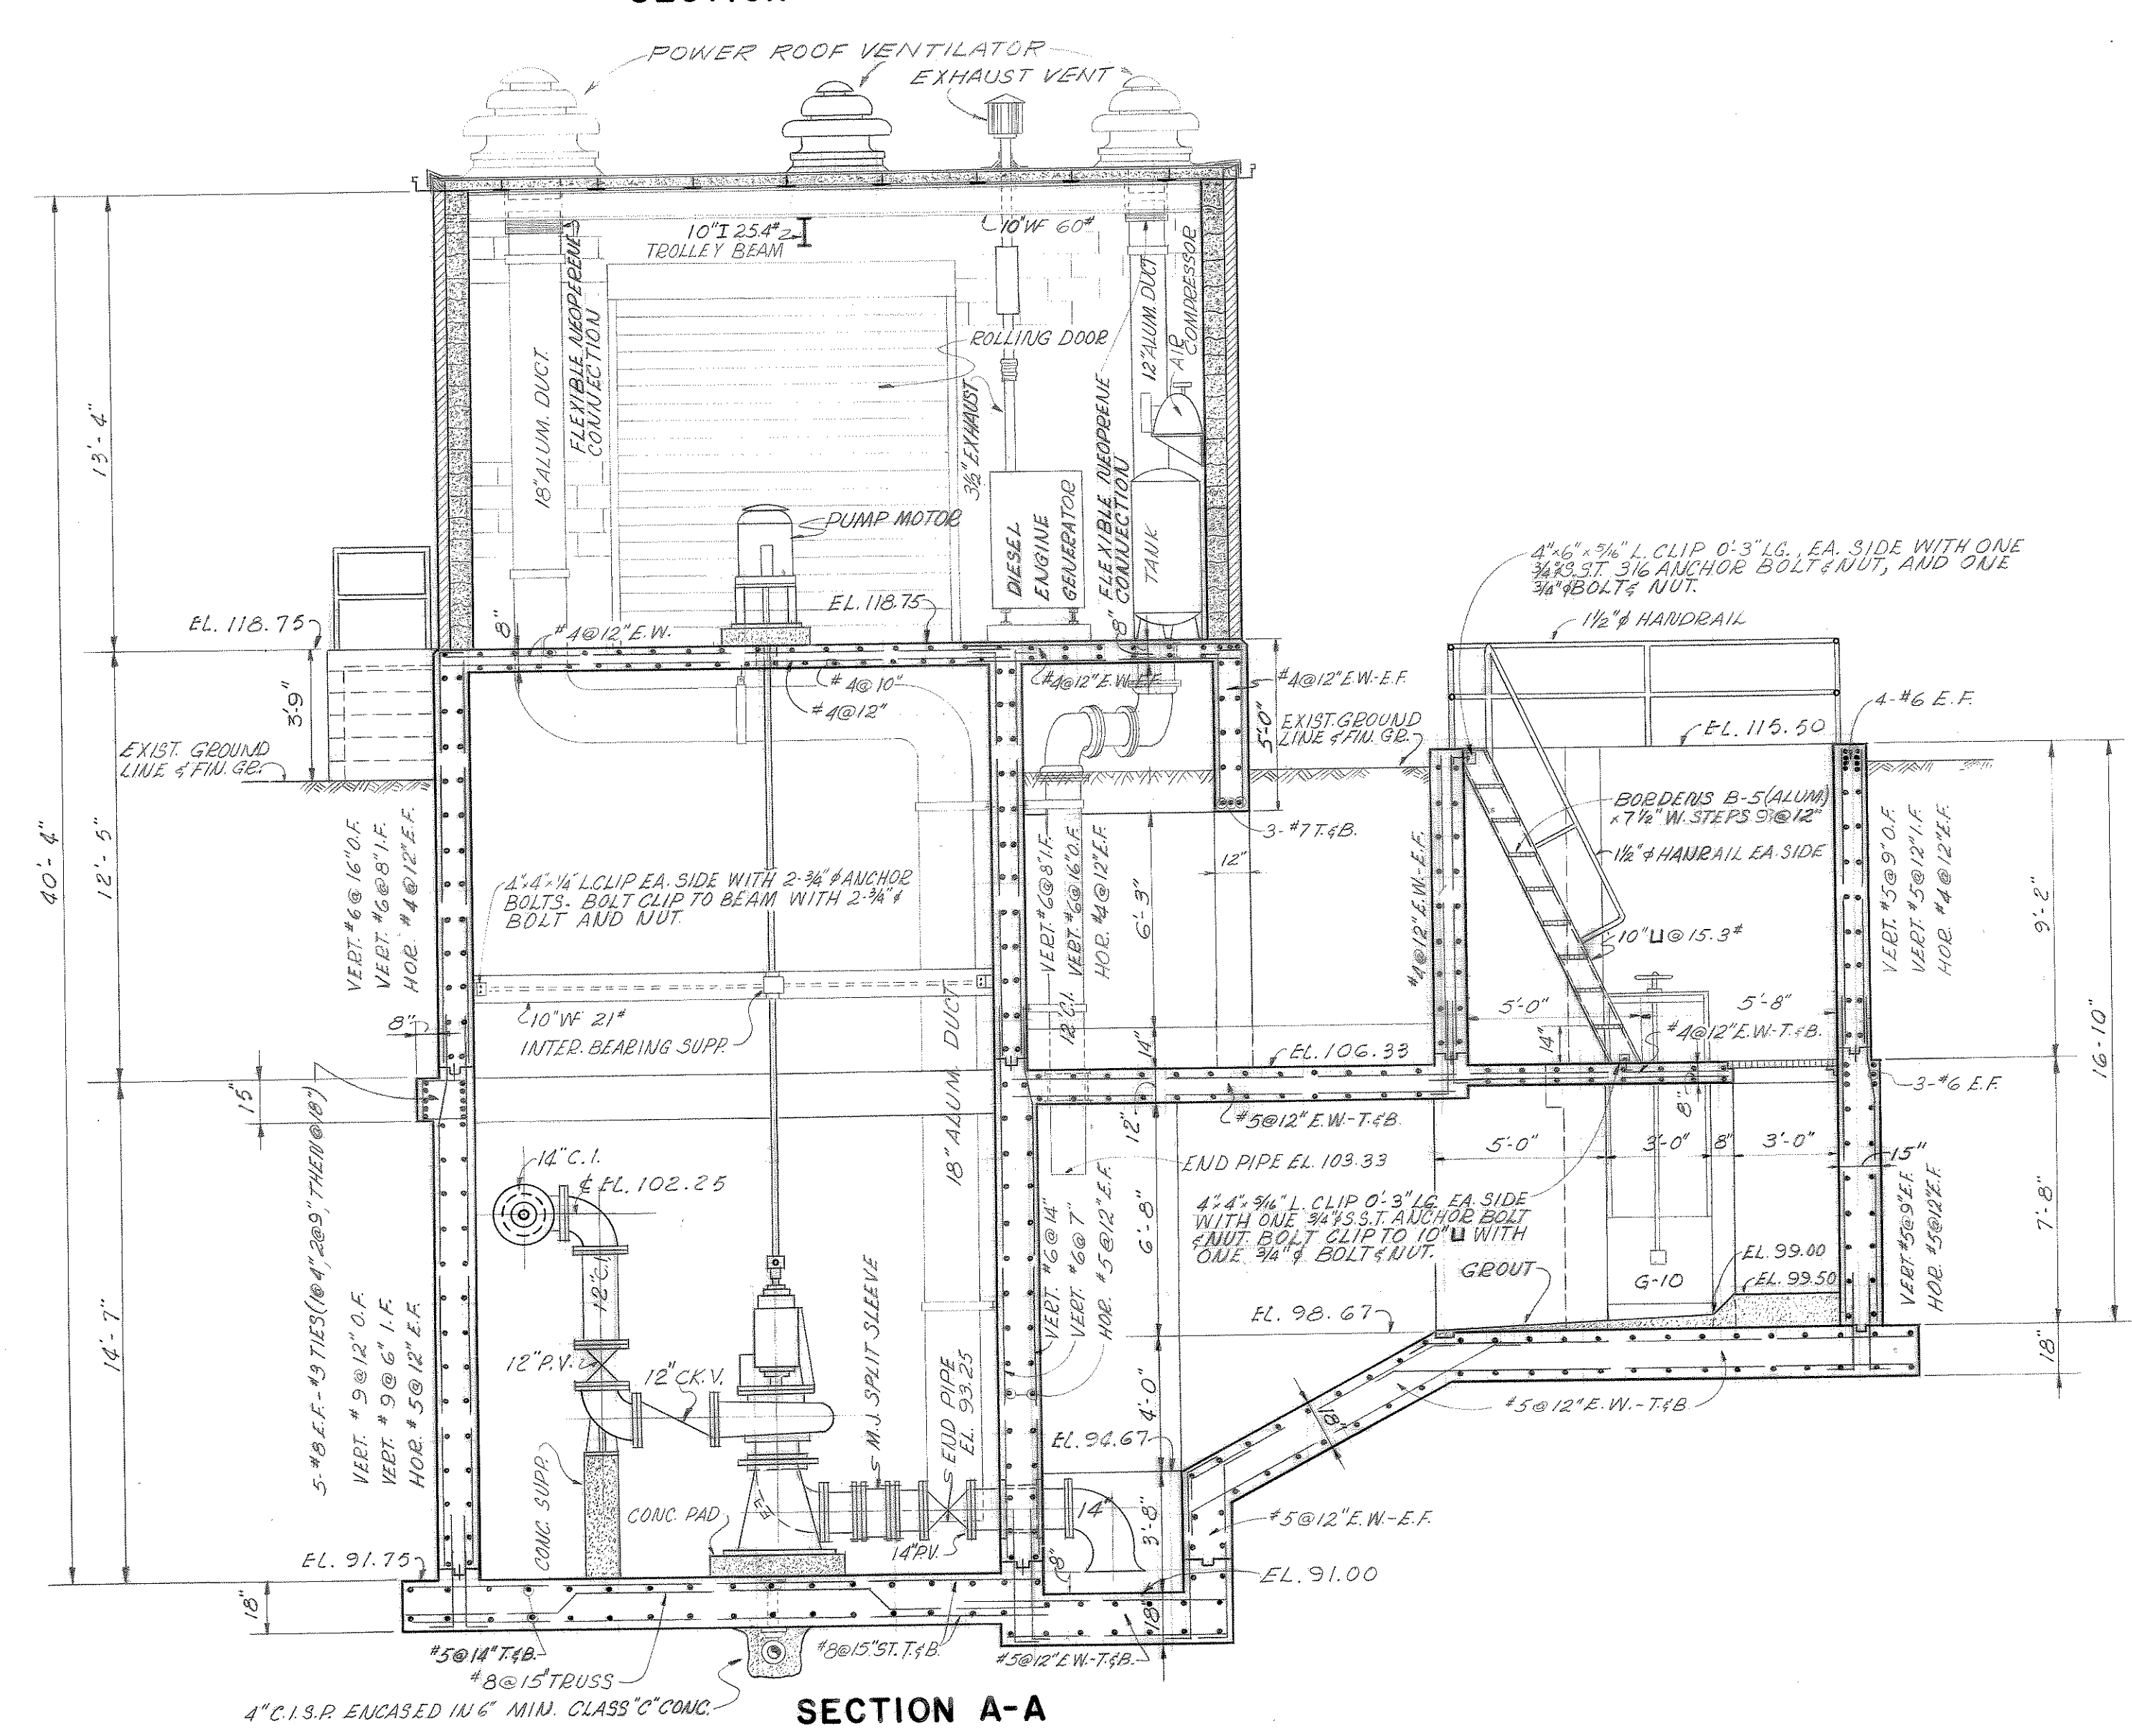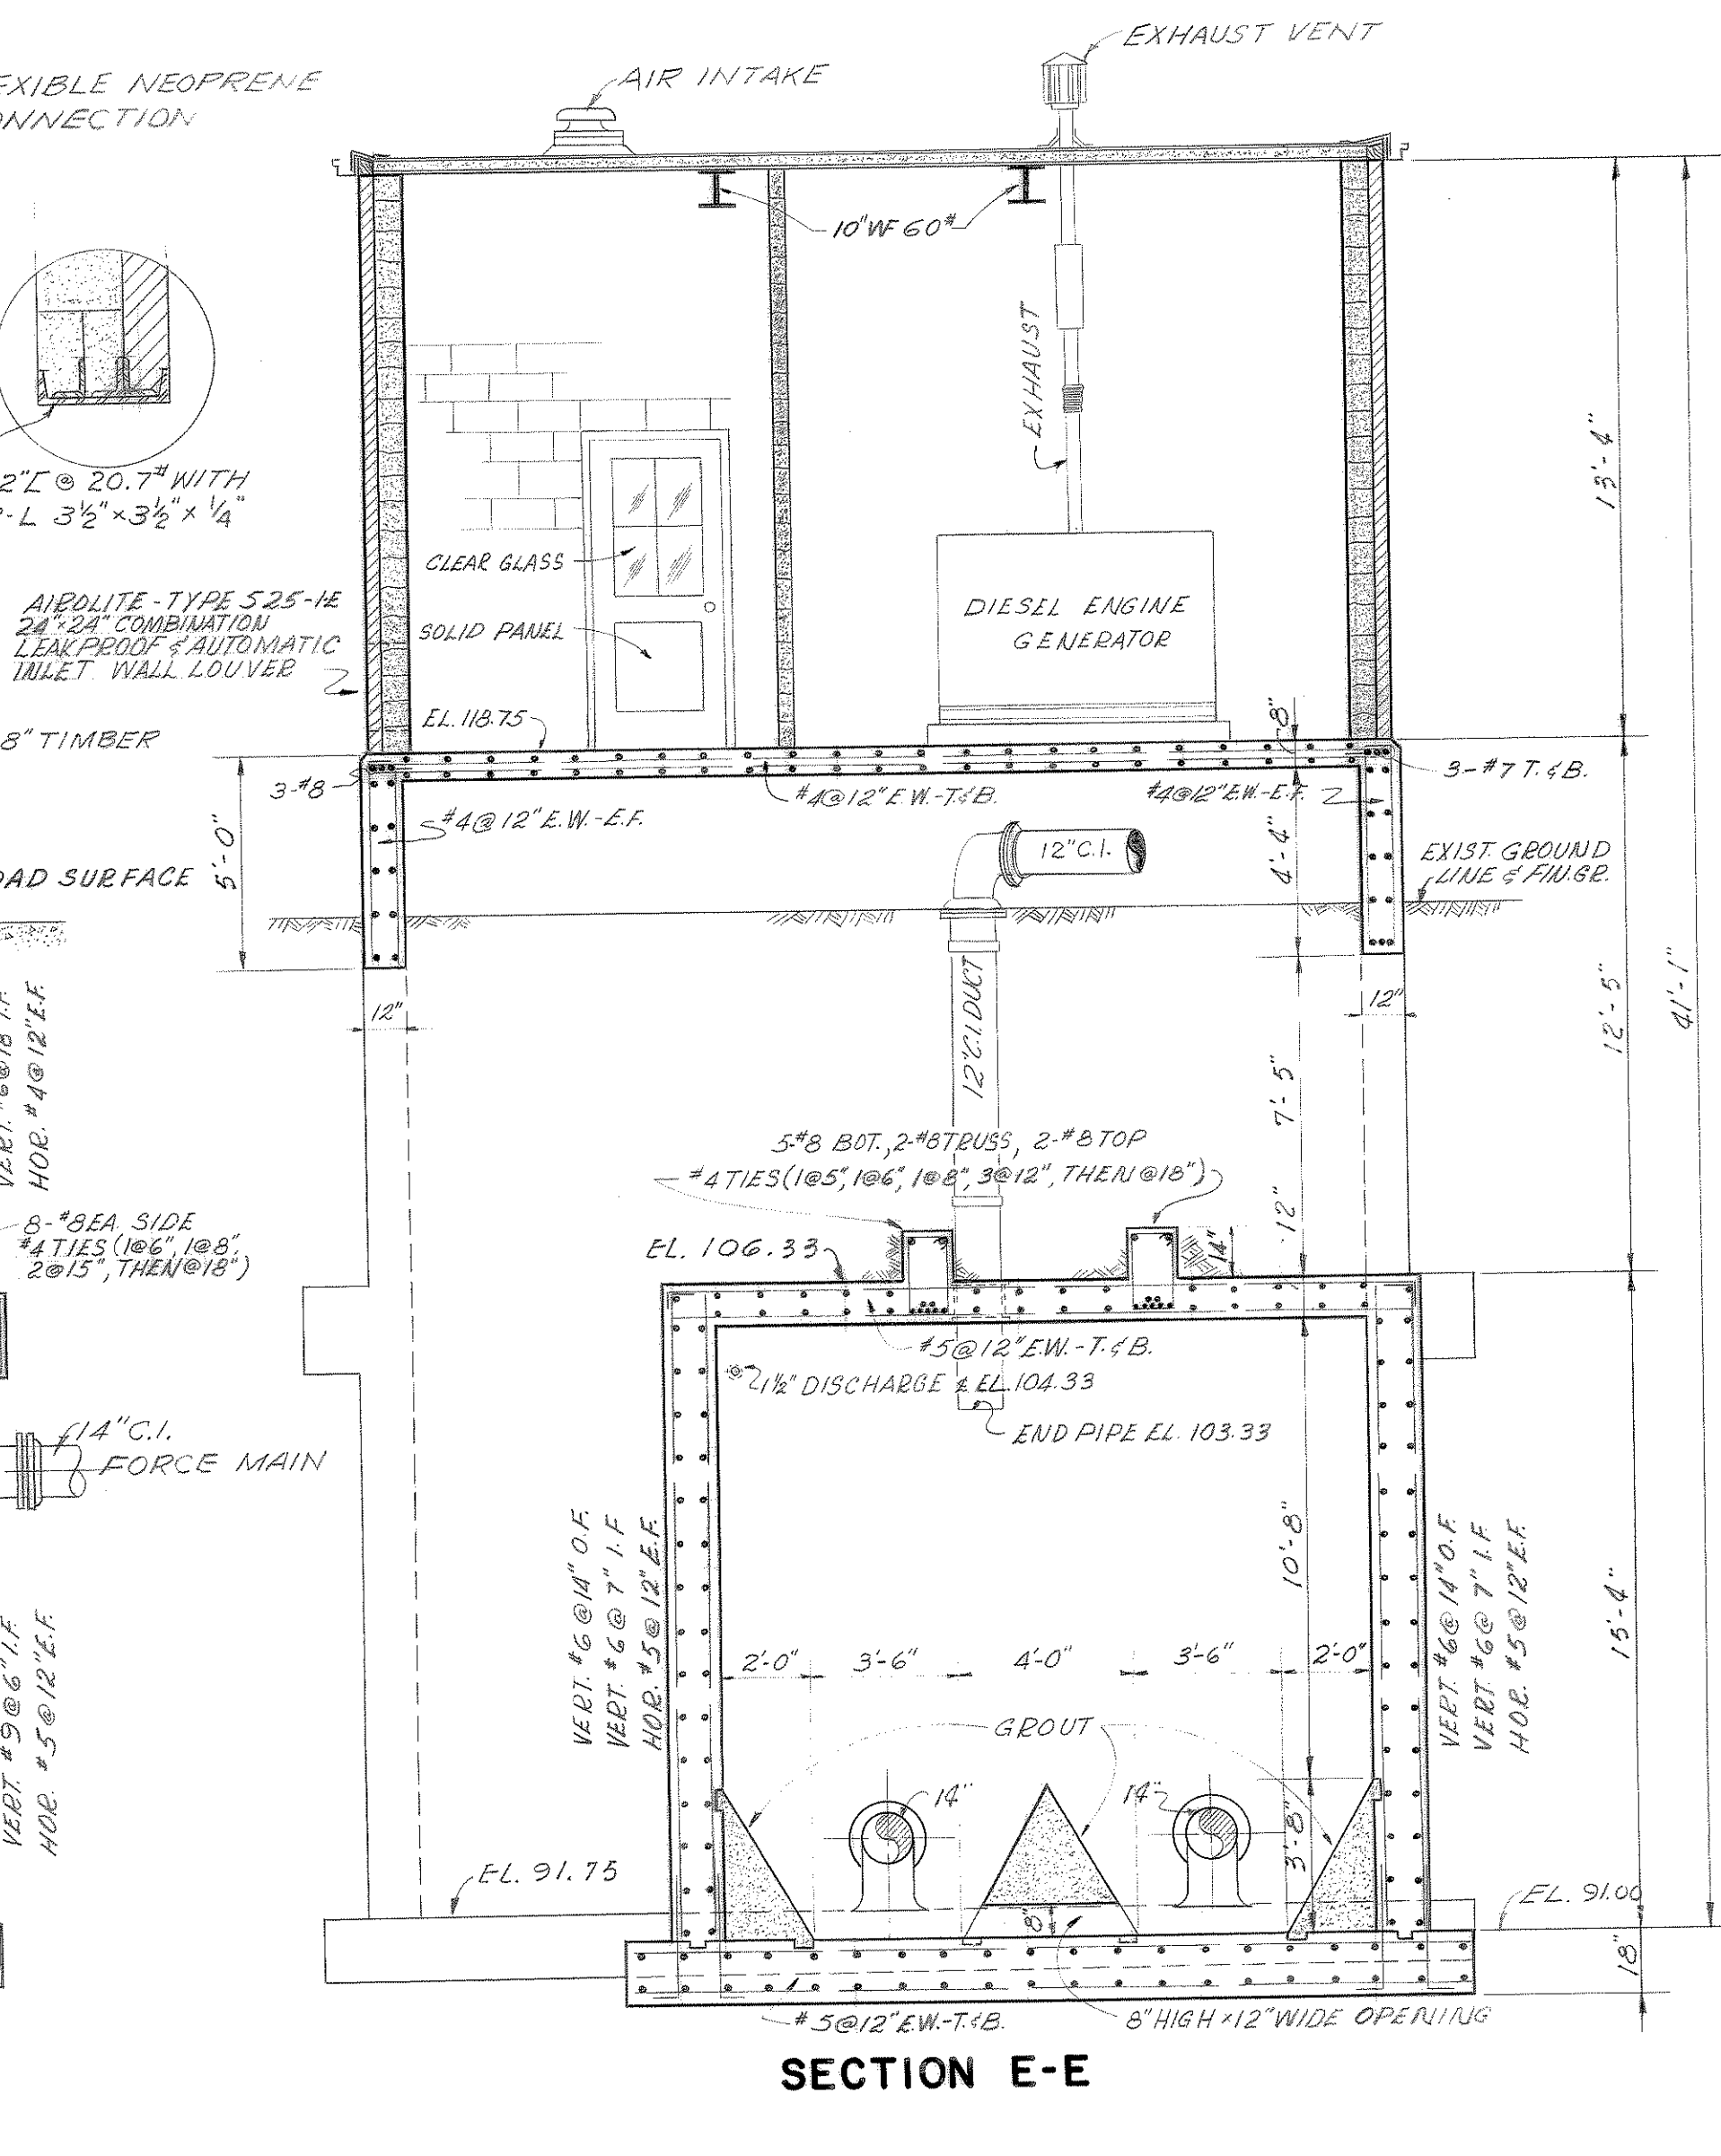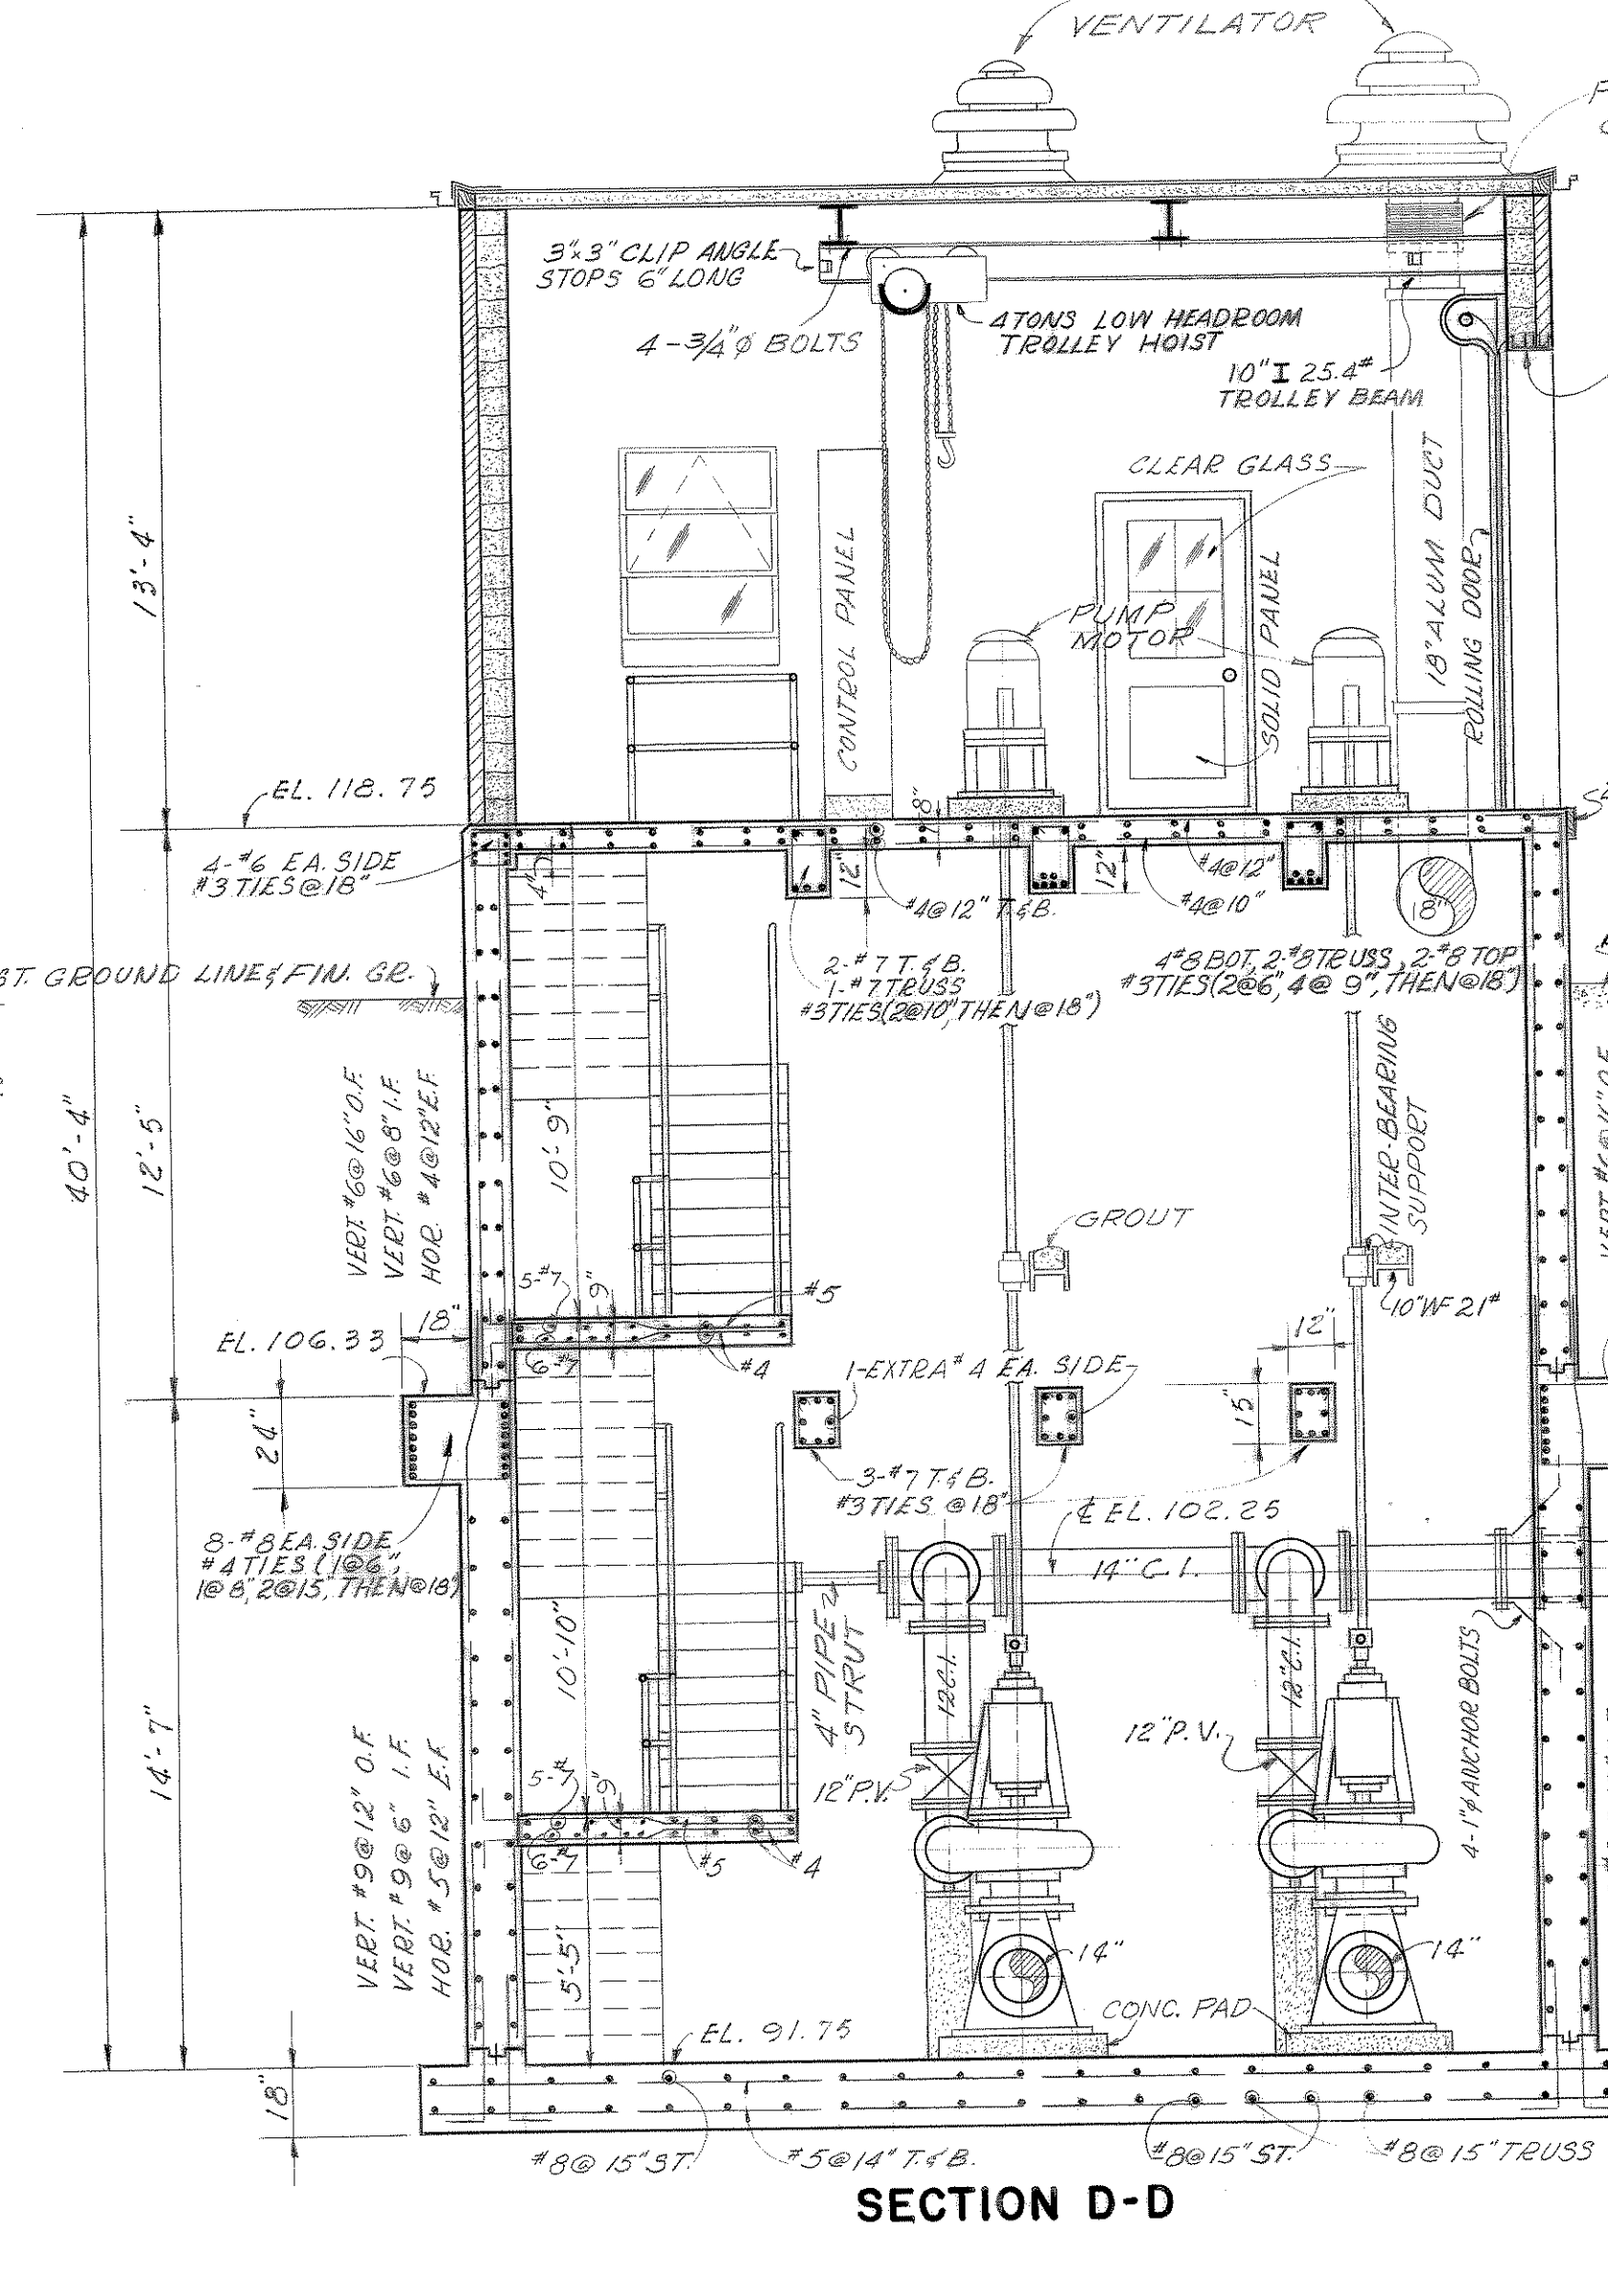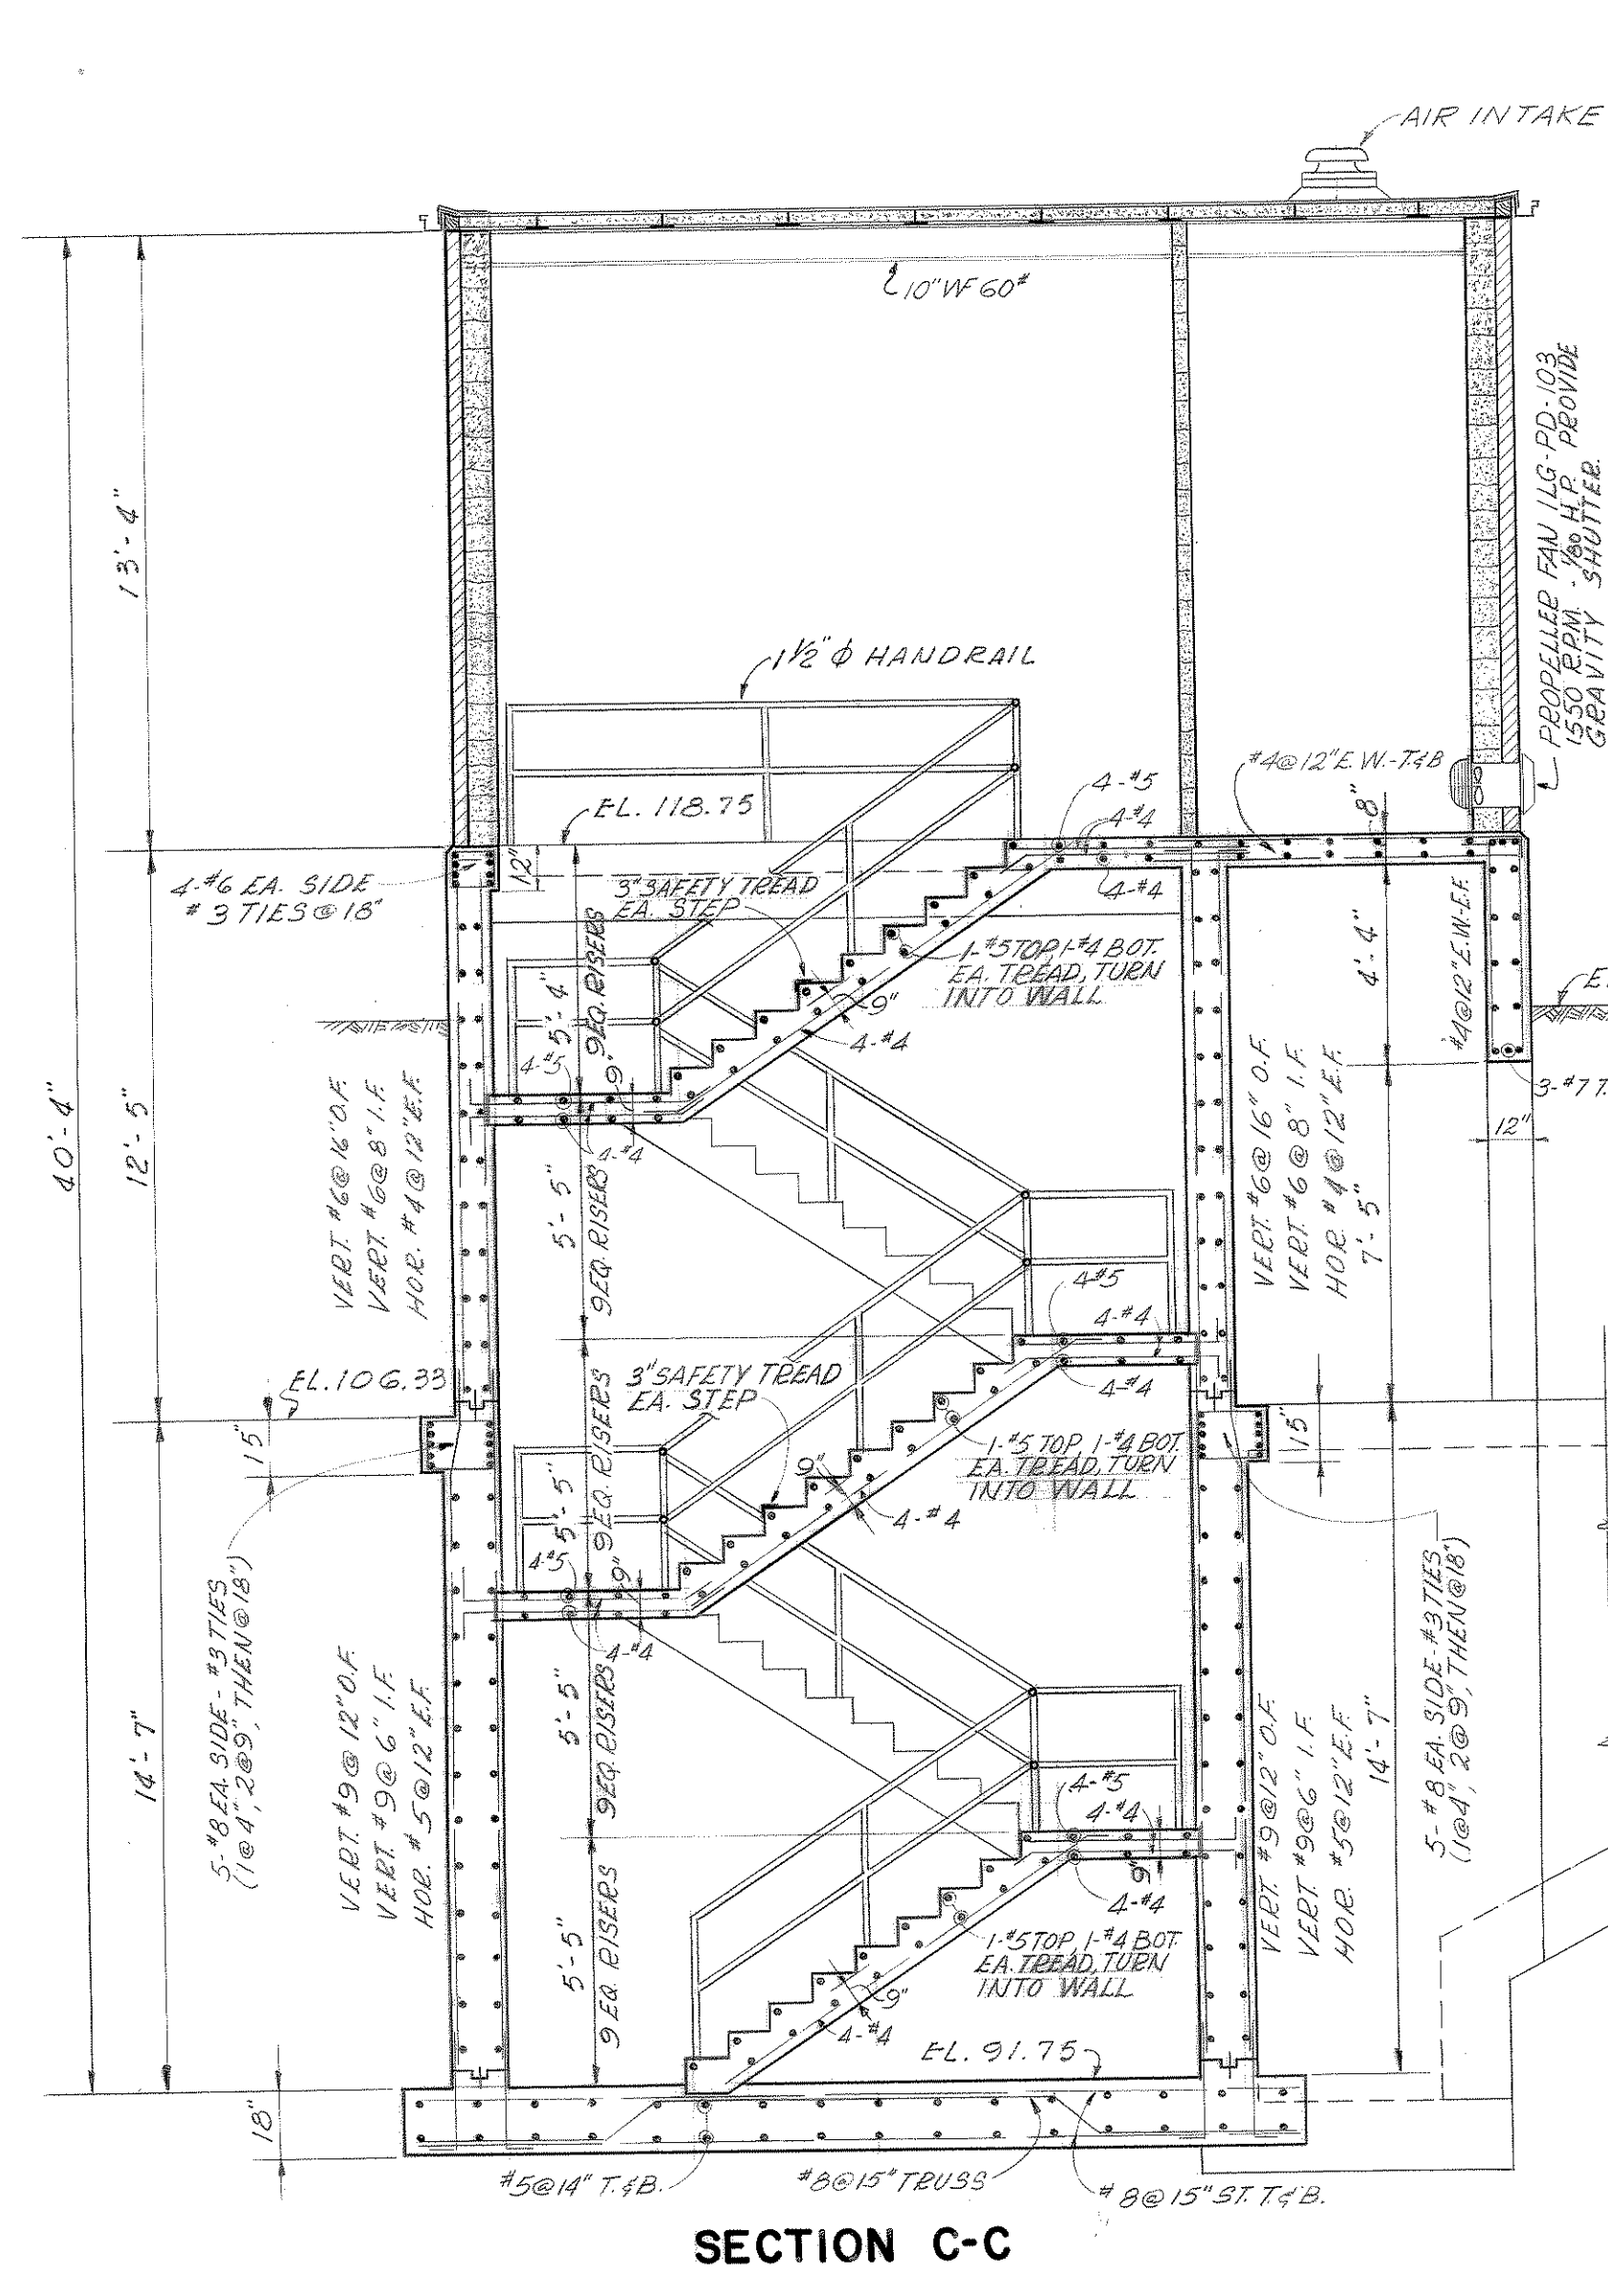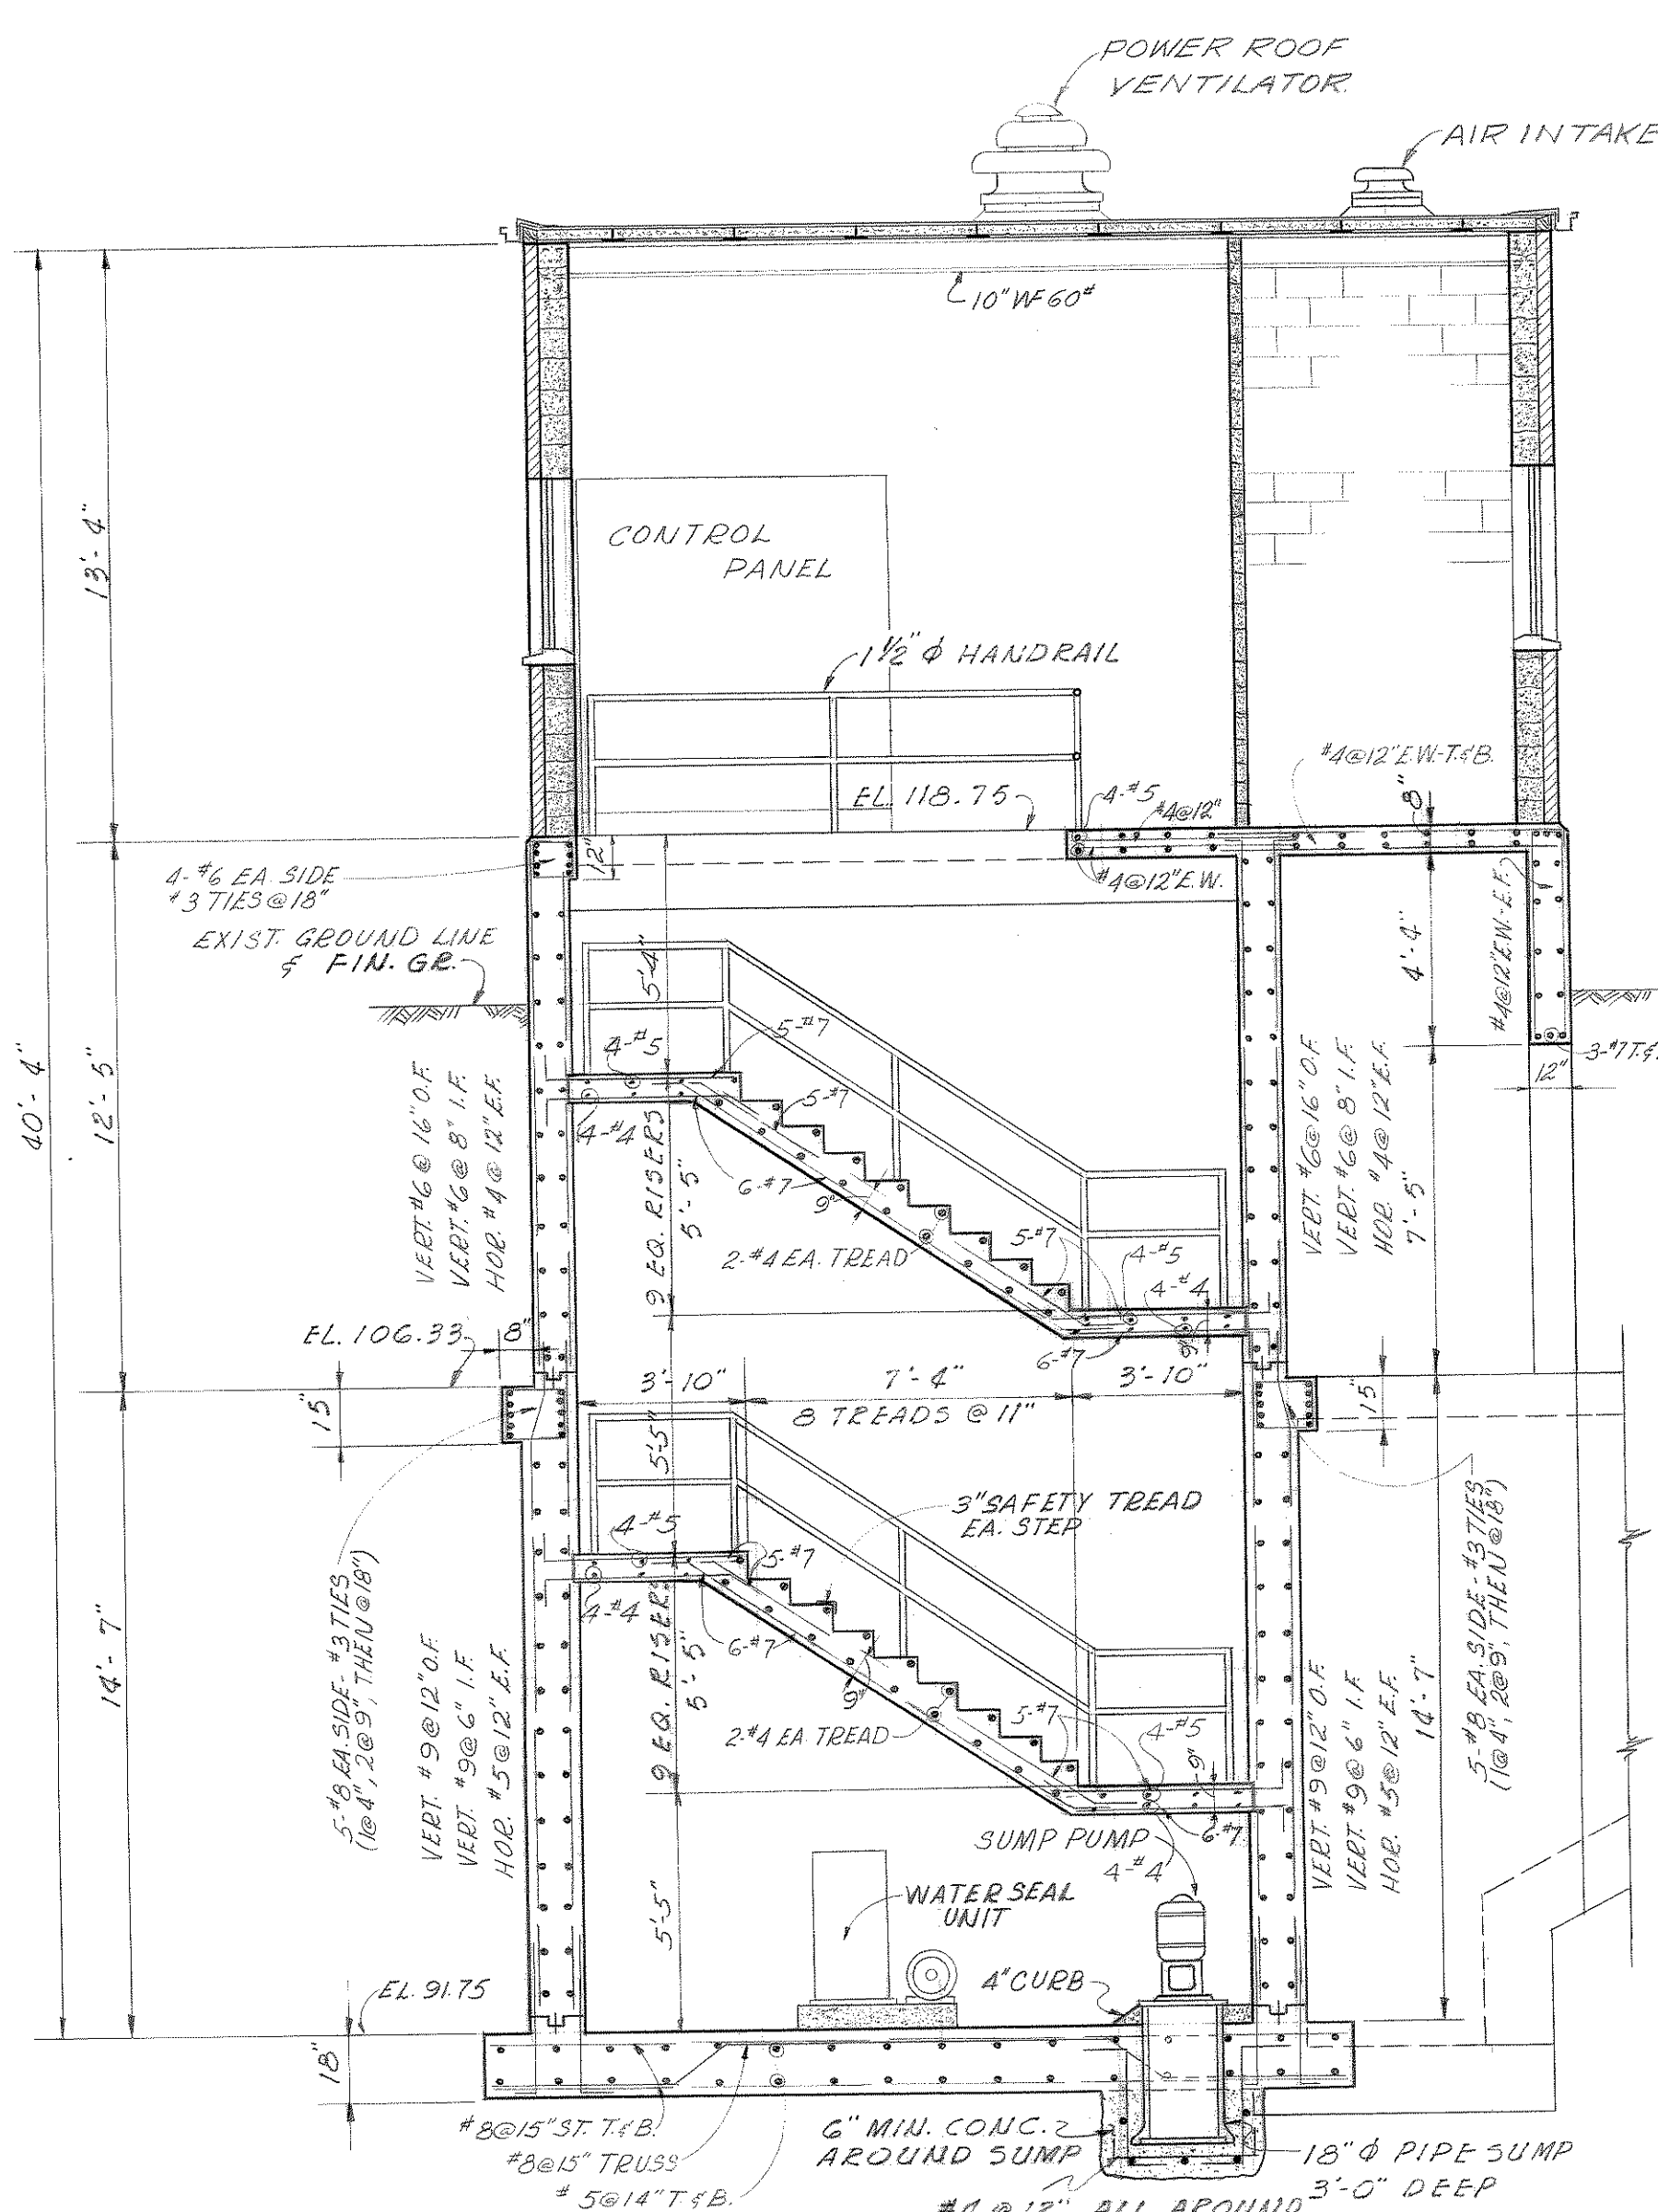





NOTE:
 1. PROVIDE #4 @ 12" FOR CONCRETE PIERS OR FOUNDATIONS FOR ALL PUMPS, BASE ELLS AND PIPING.
 2. EXTEND PIERS UNDER PIPING UP TO MIDPOINT OF PIPE.
 3. FOR TYPICAL WALL SECTION SEE SHEET N-7

CONTRACT 'C'

CITY OF BRUNSWICK, GEORGIA
SEWERAGE SYSTEM IMPROVEMENTS

RAW SEWAGE
PUMPING STATION NO. 5

SCALE 1/4"=1'-0"	WIEDEMAN AND SINGLETON ENGINEERS ATLANTA	SHEET 9 OF 15
DATE JULY, 1963	GEORGIA	






 
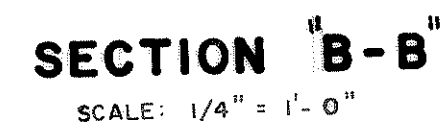
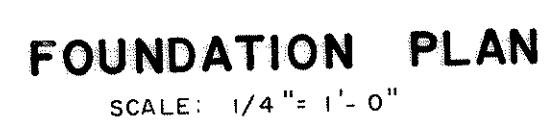
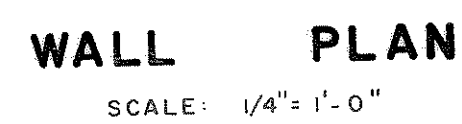


CITY OF BRUNSWICK, GEORGIA
SEWERAGE SYSTEM IMPROVEMENTS

RAW SEWAGE
PUMPING STATION NO.6

DATUM EQUALS USC&GS MEAN
SEA LEVEL PLUS 100.00 FT.

SCALE AS SHOWN DATE JULY, 1963	WIEDEMAN AND SINGLETON ENGINEERS ATLANTA	SHEET 10 OF 15
---	--	----------------------

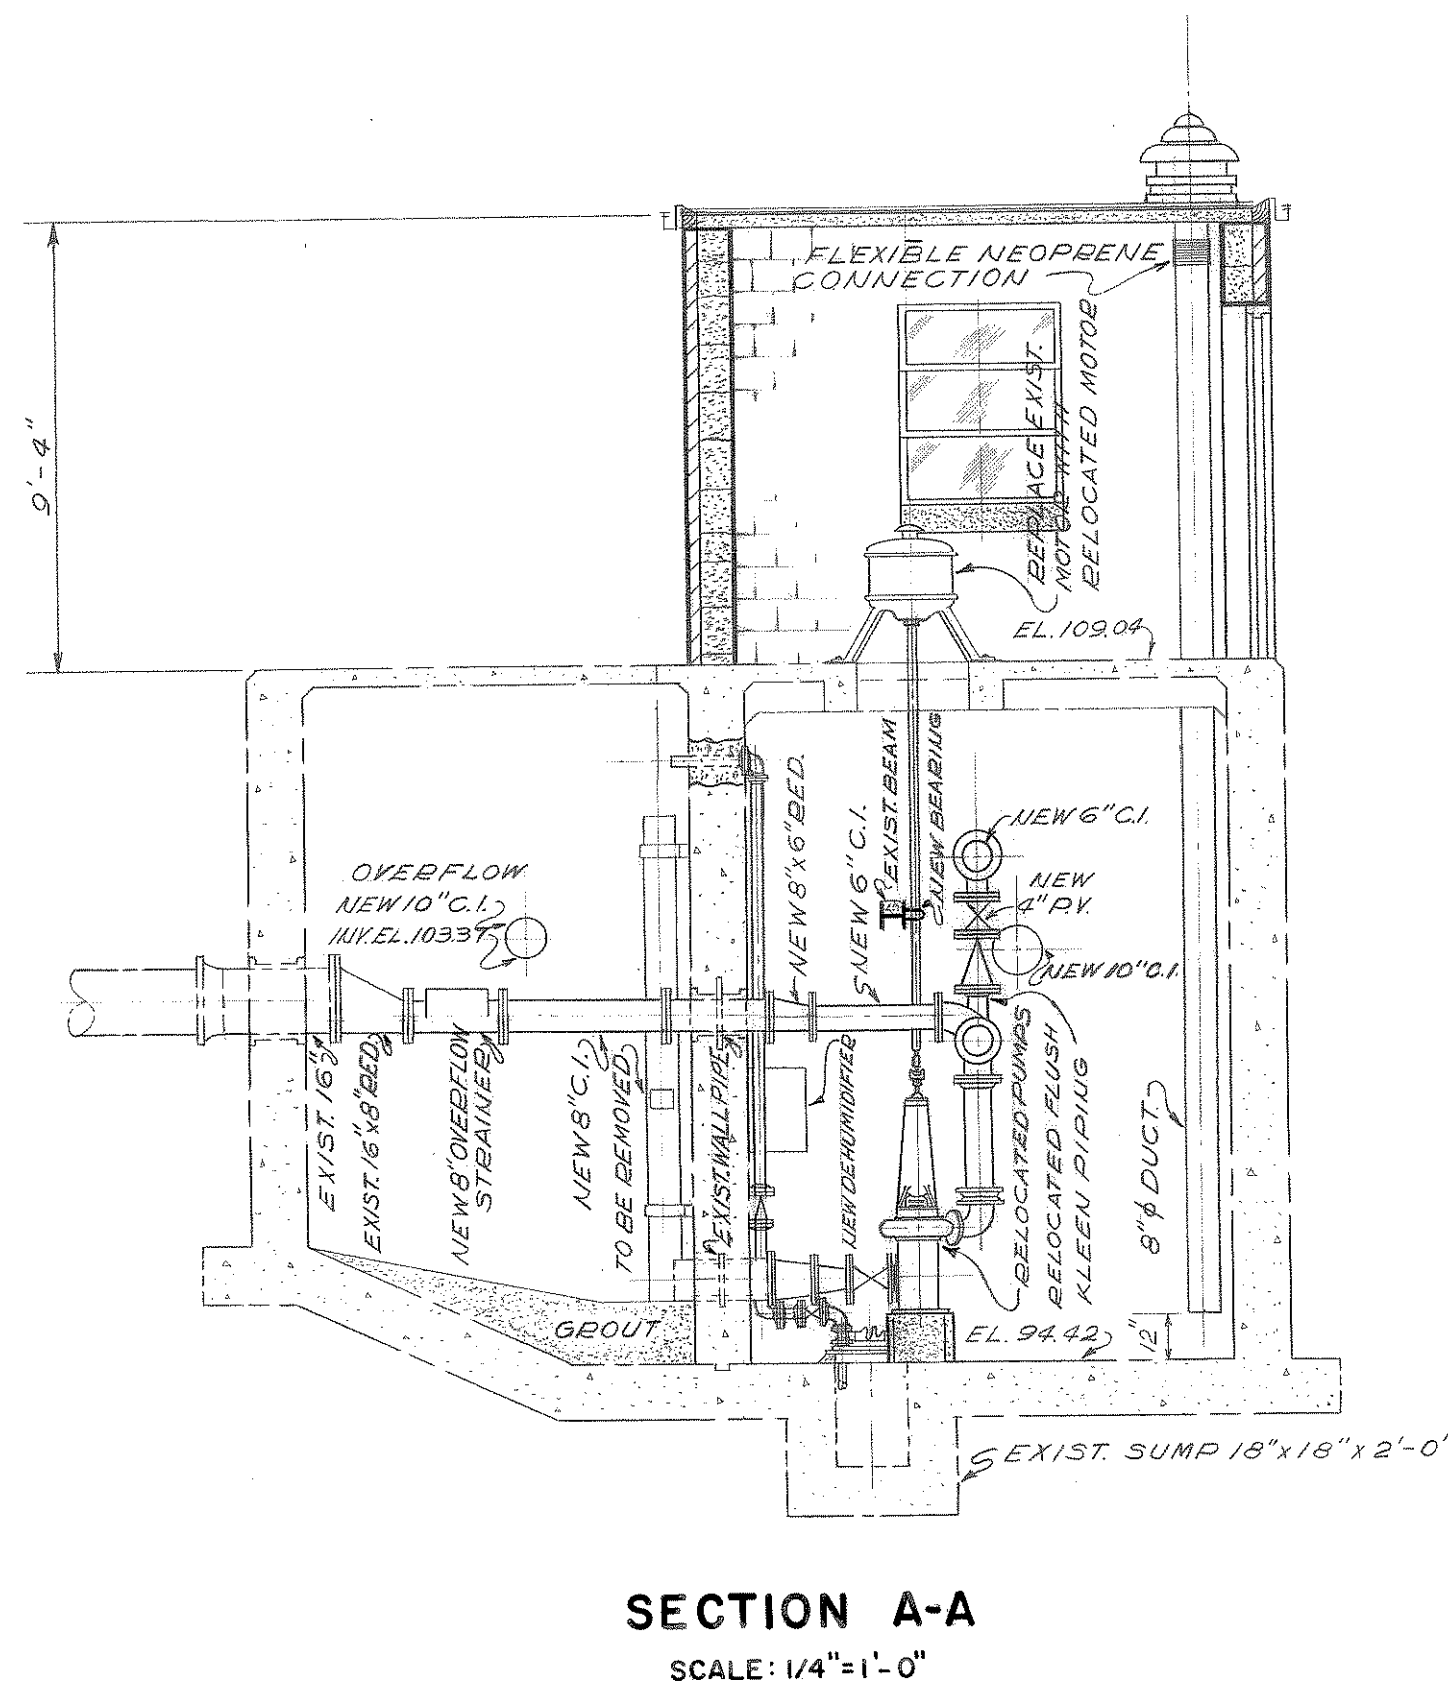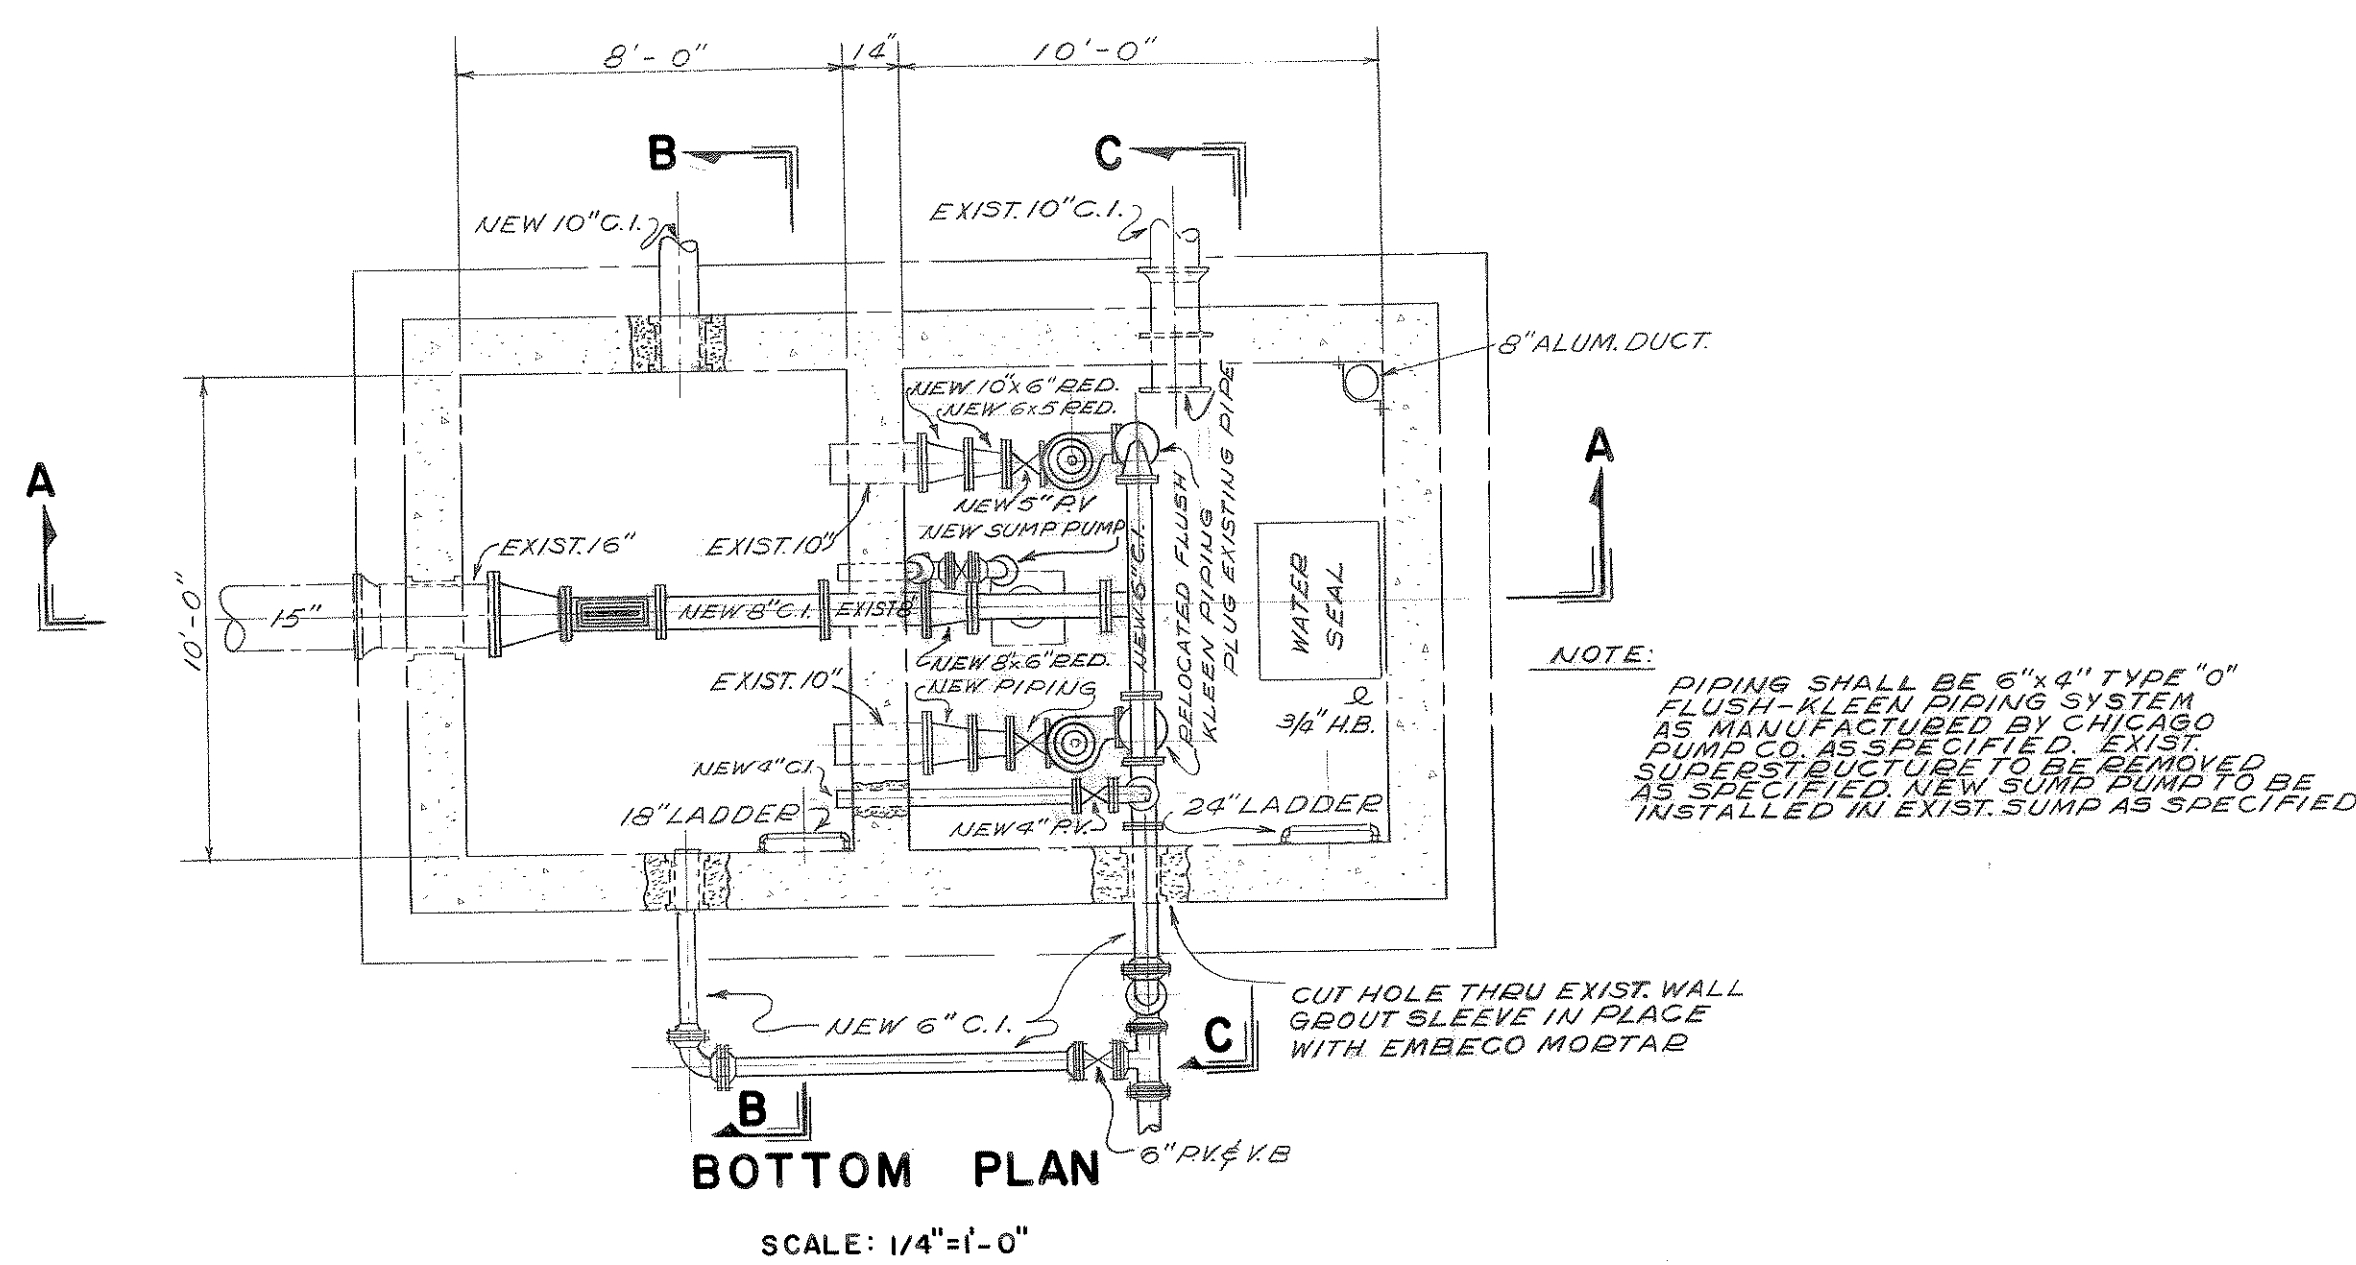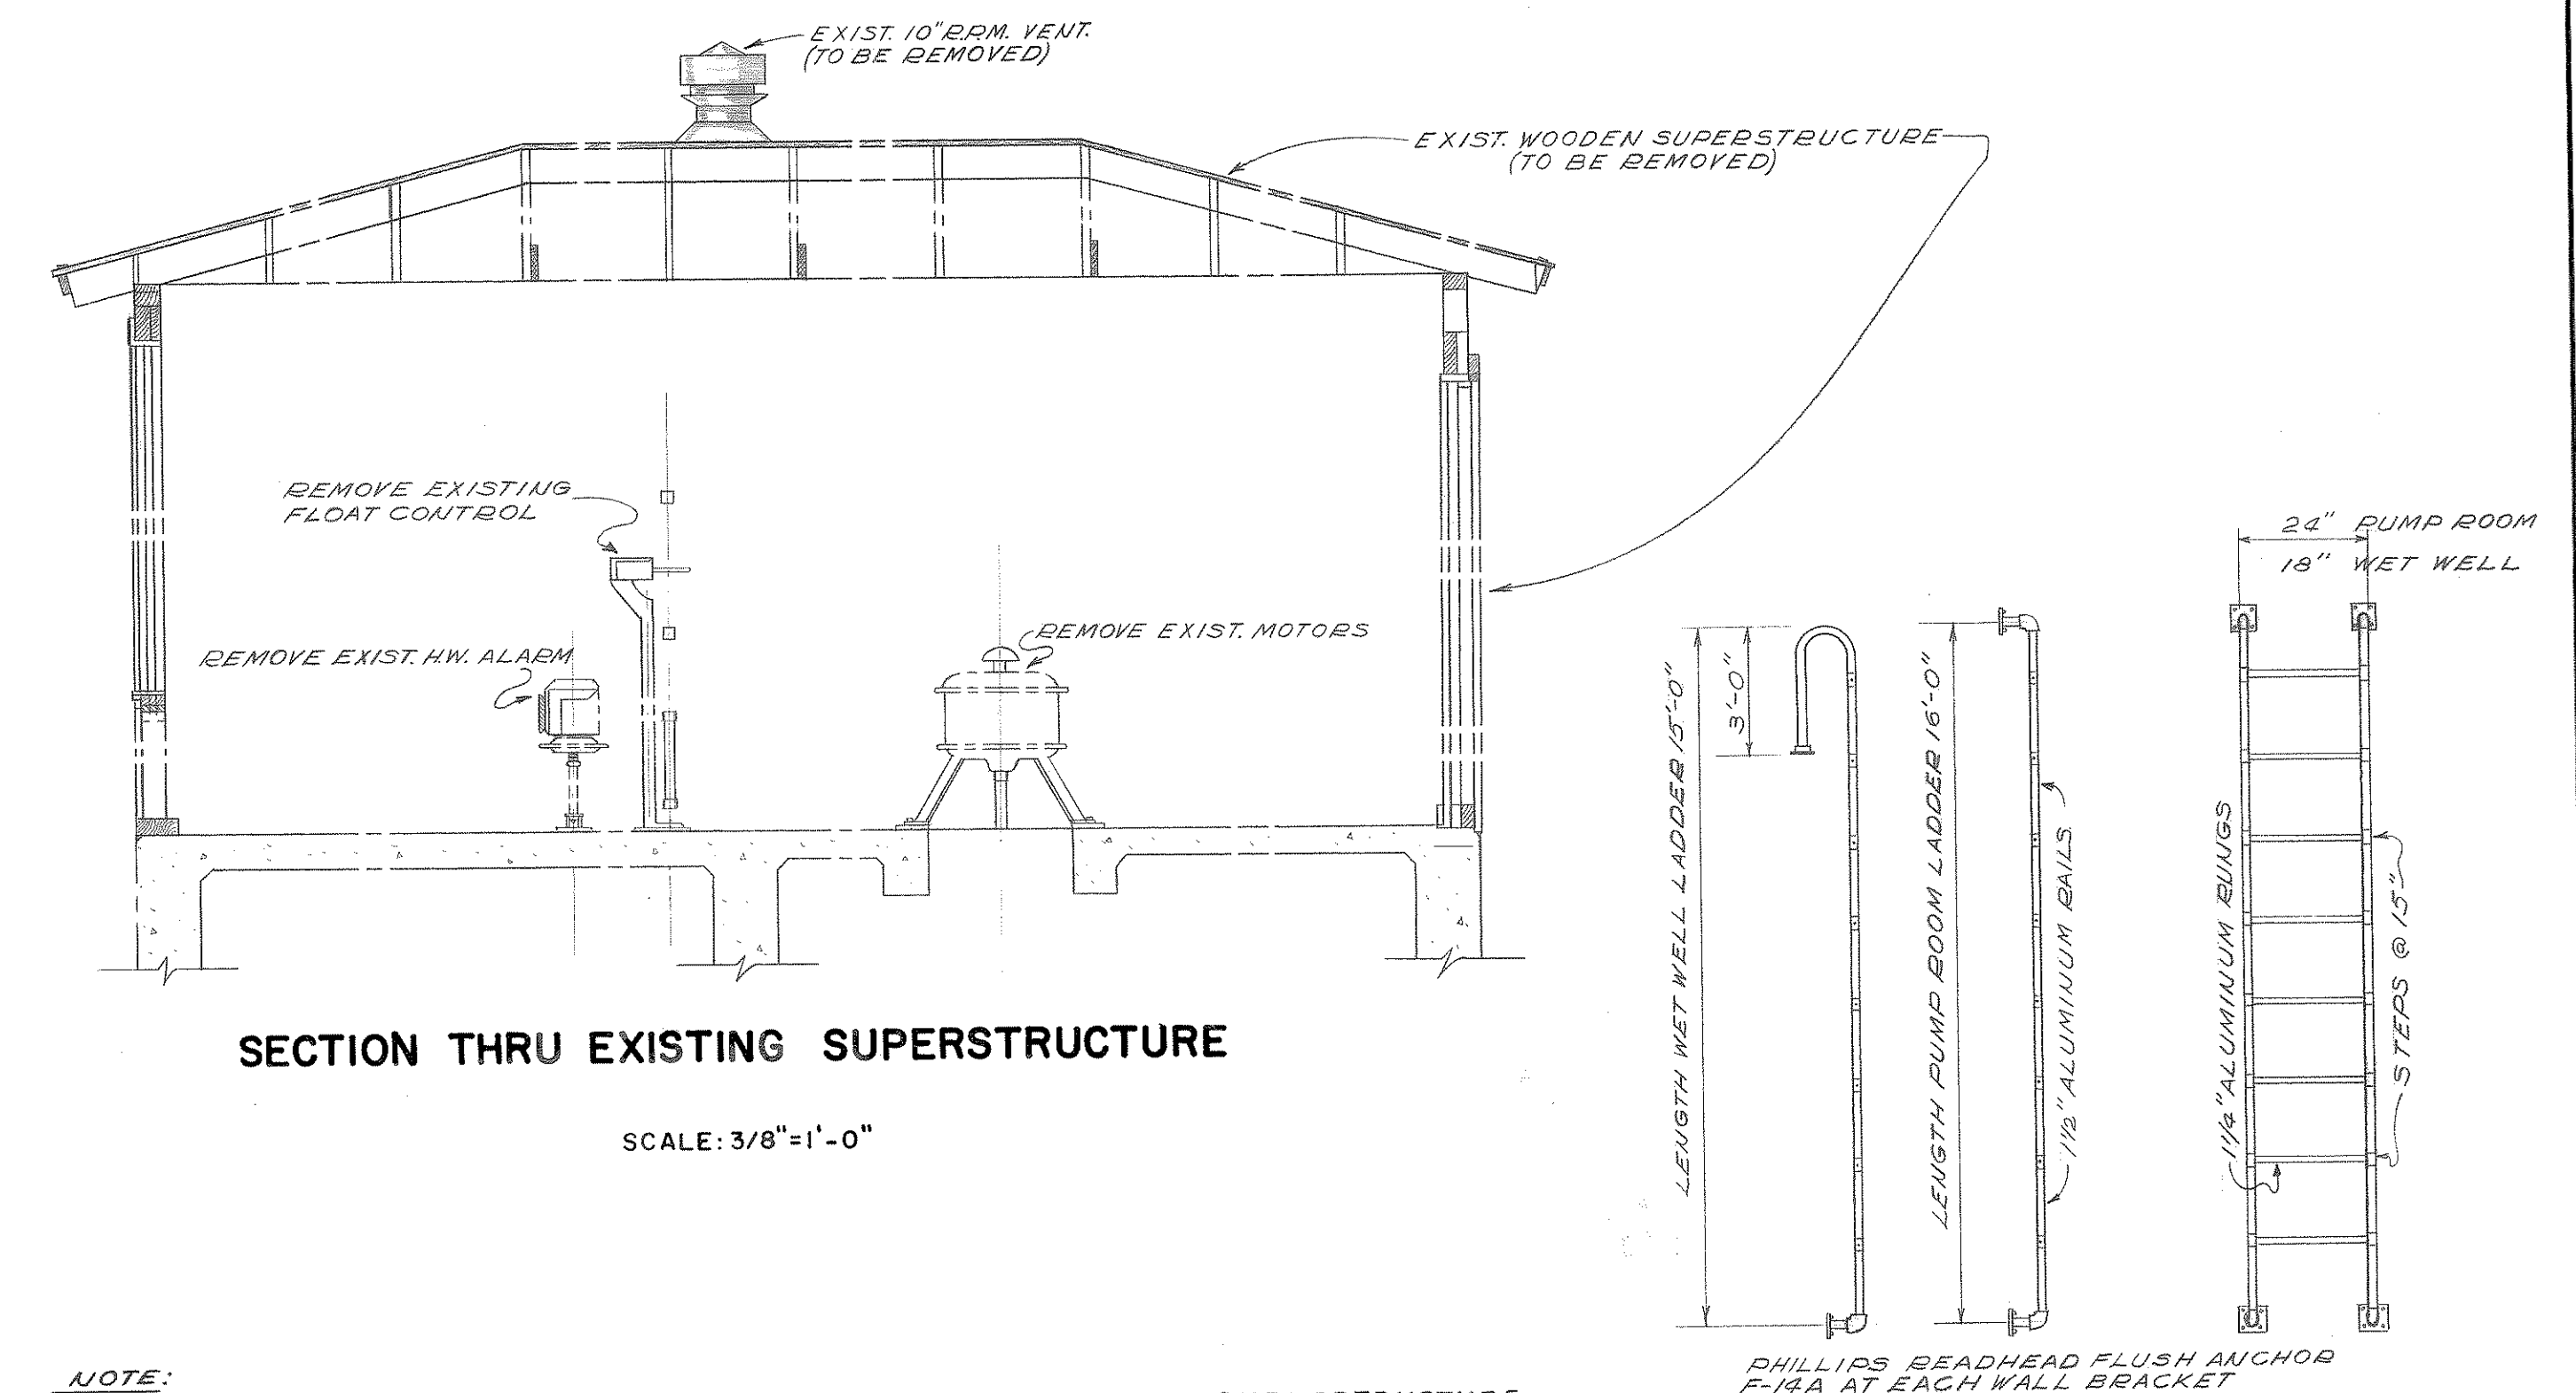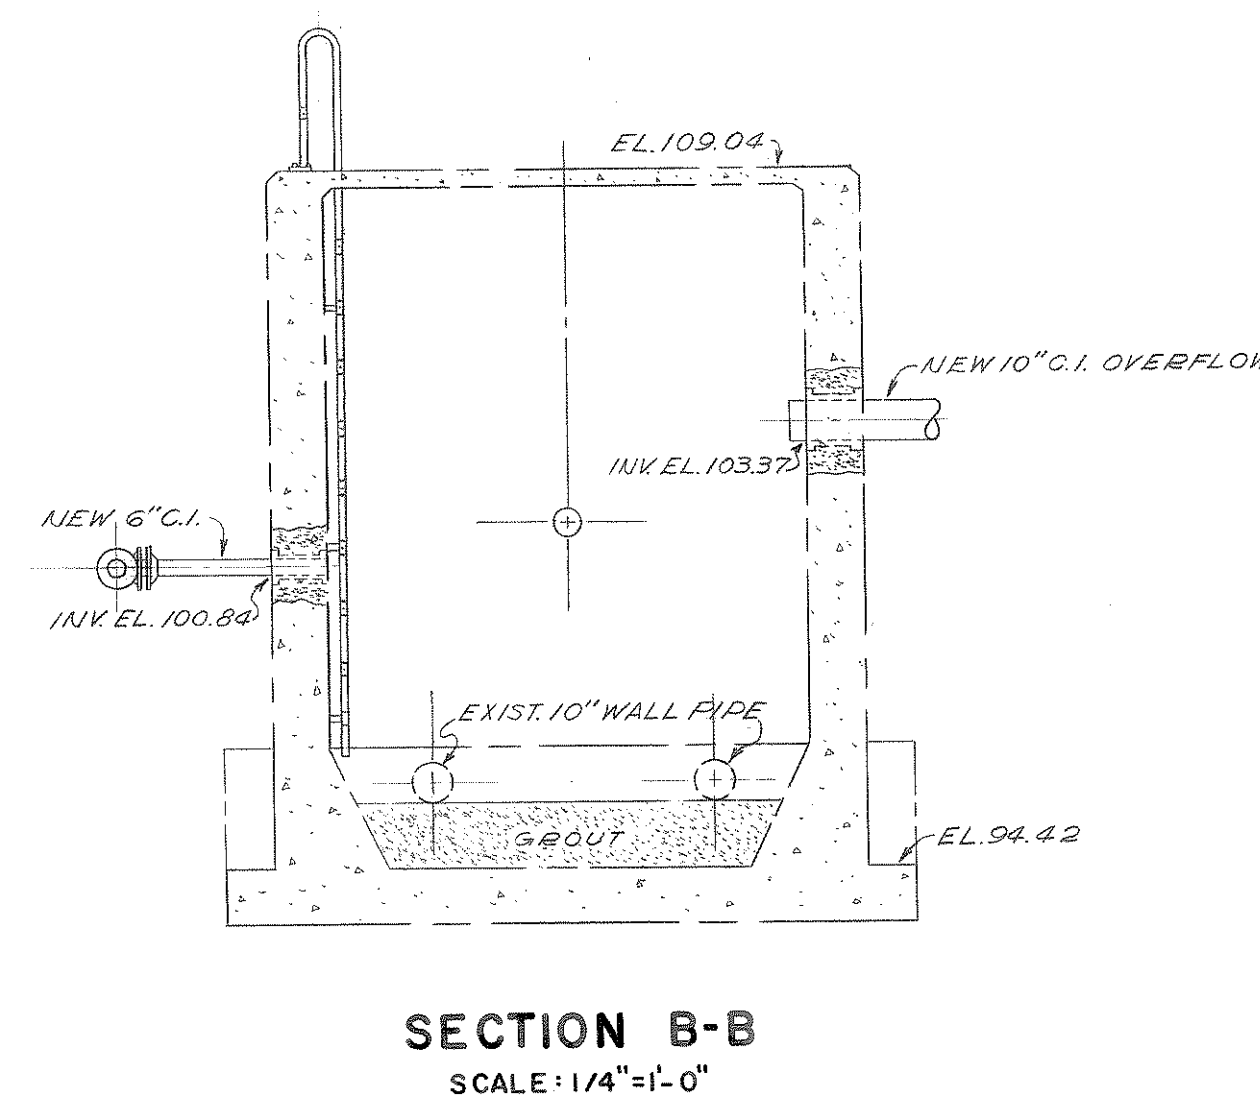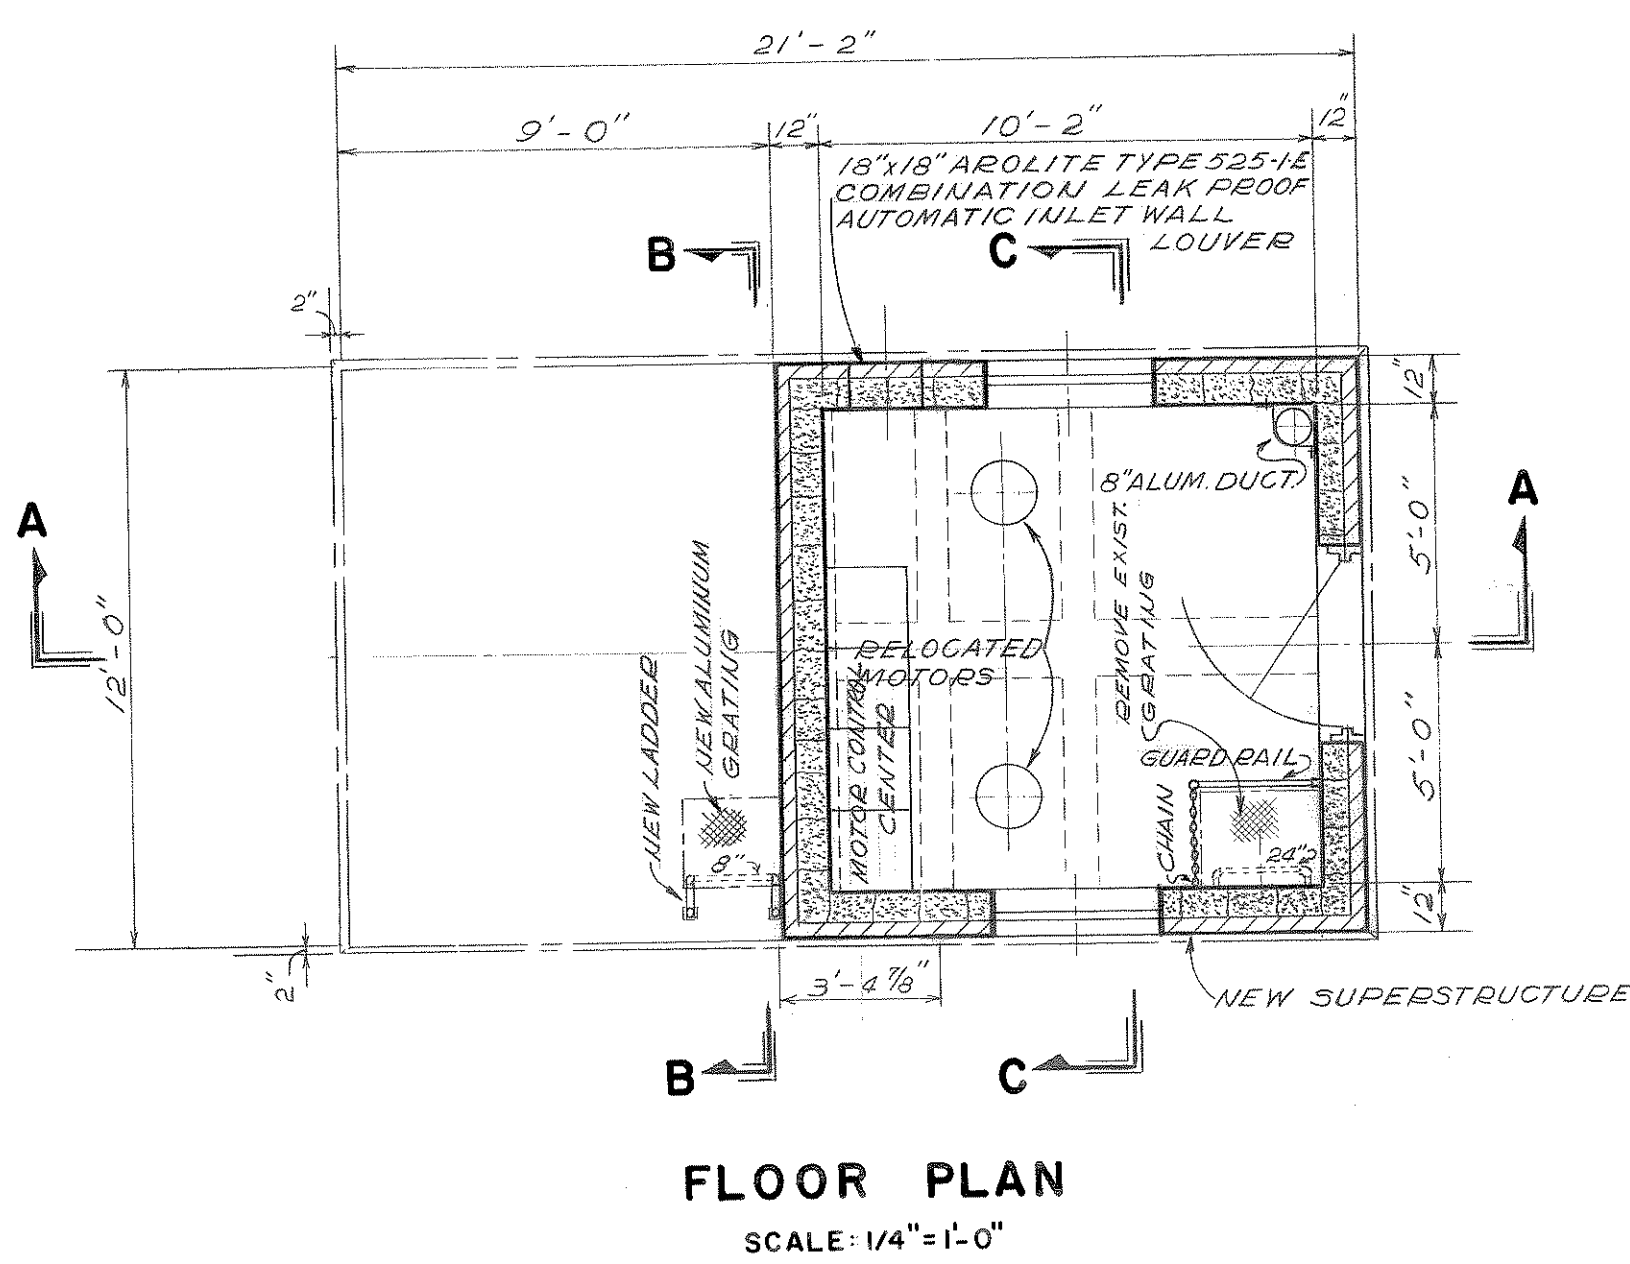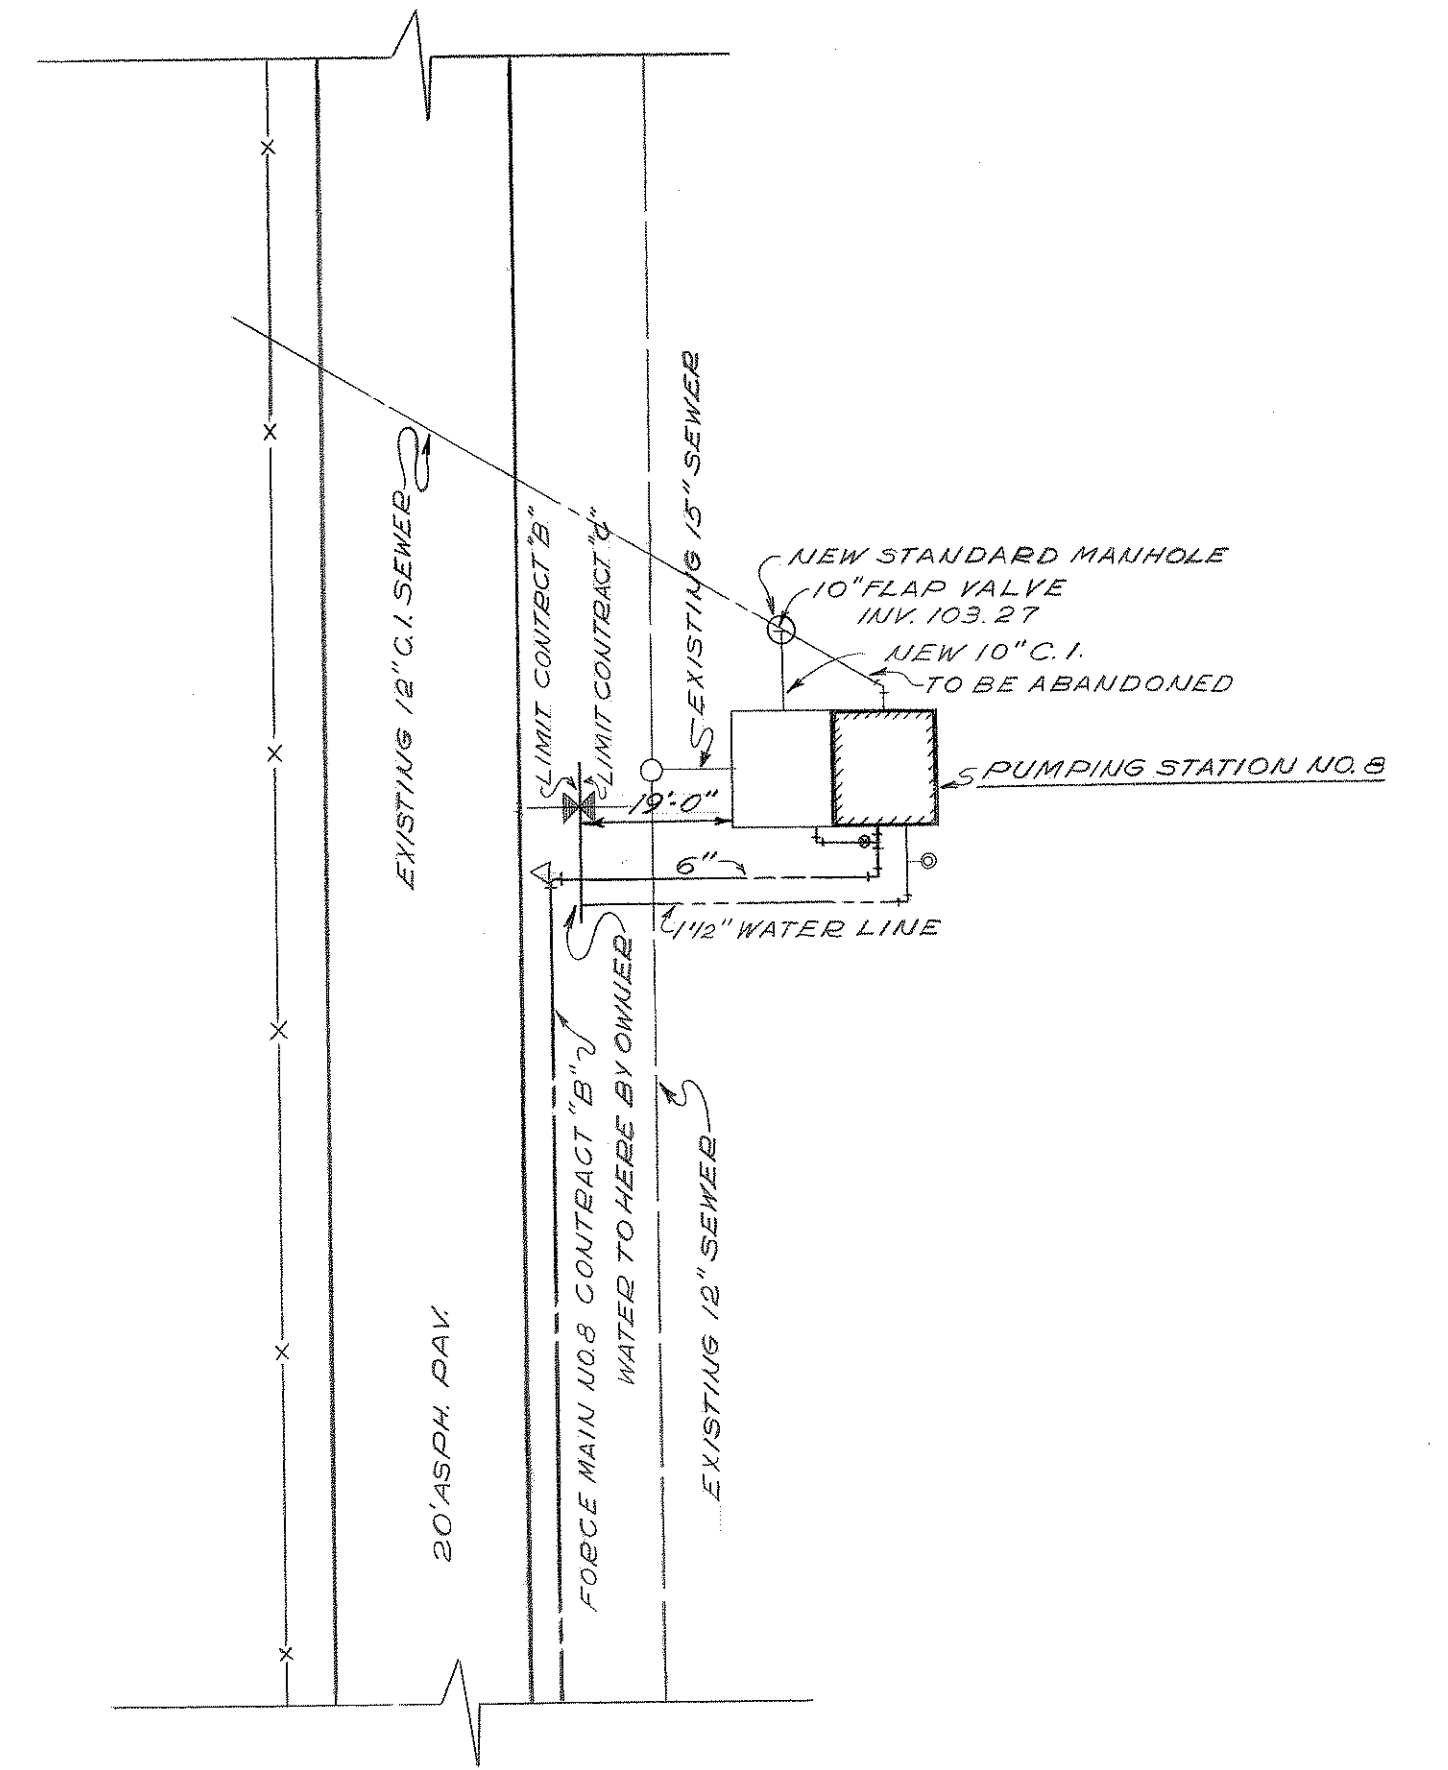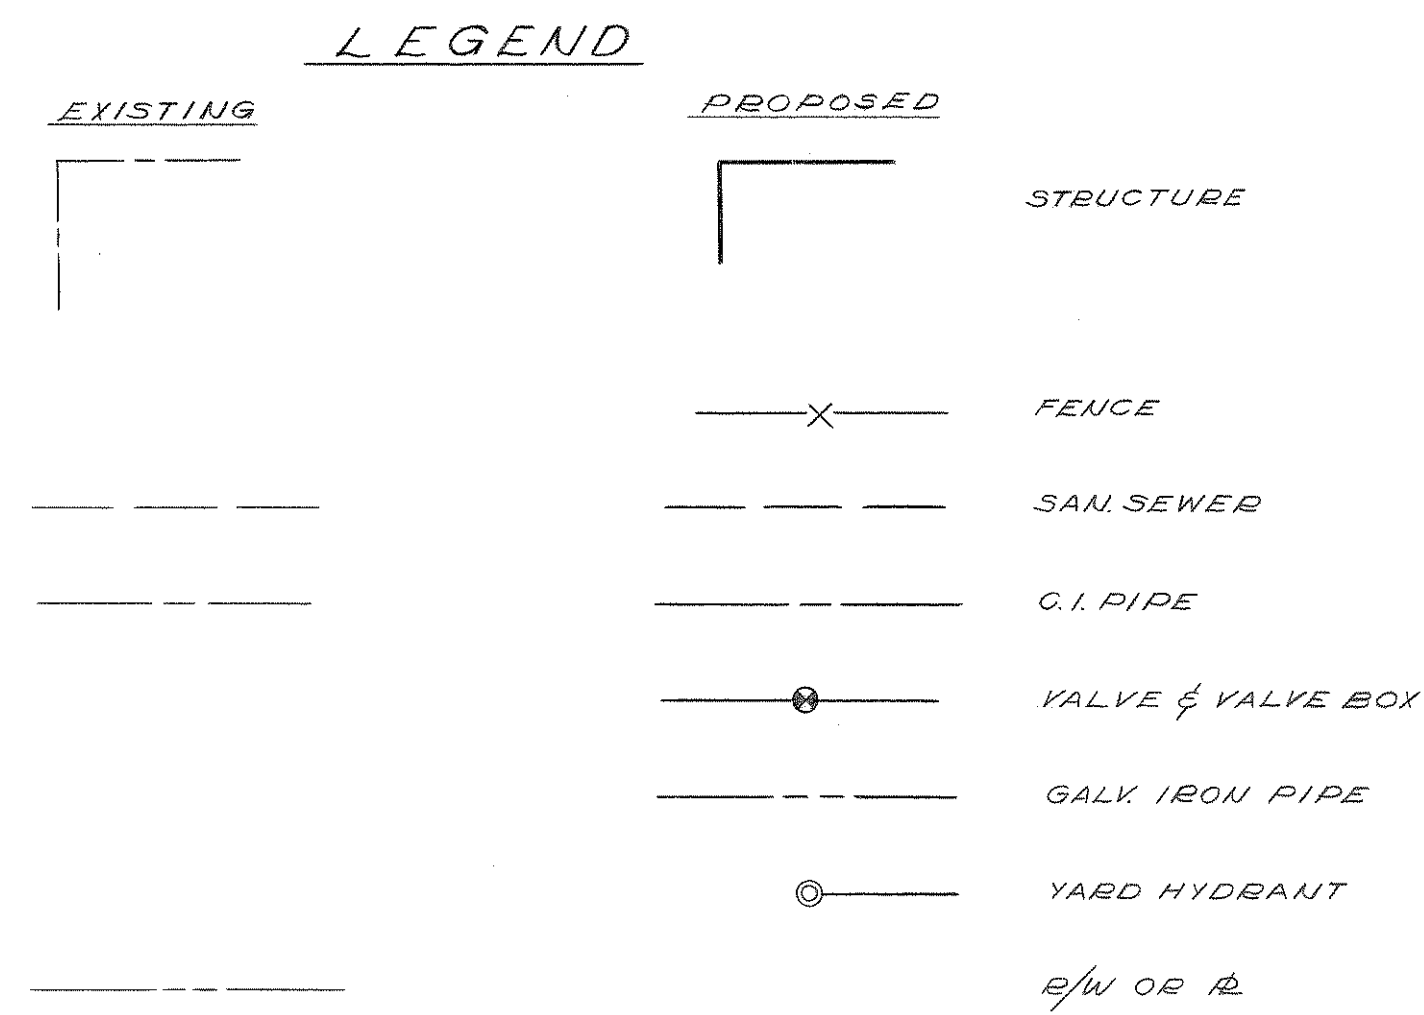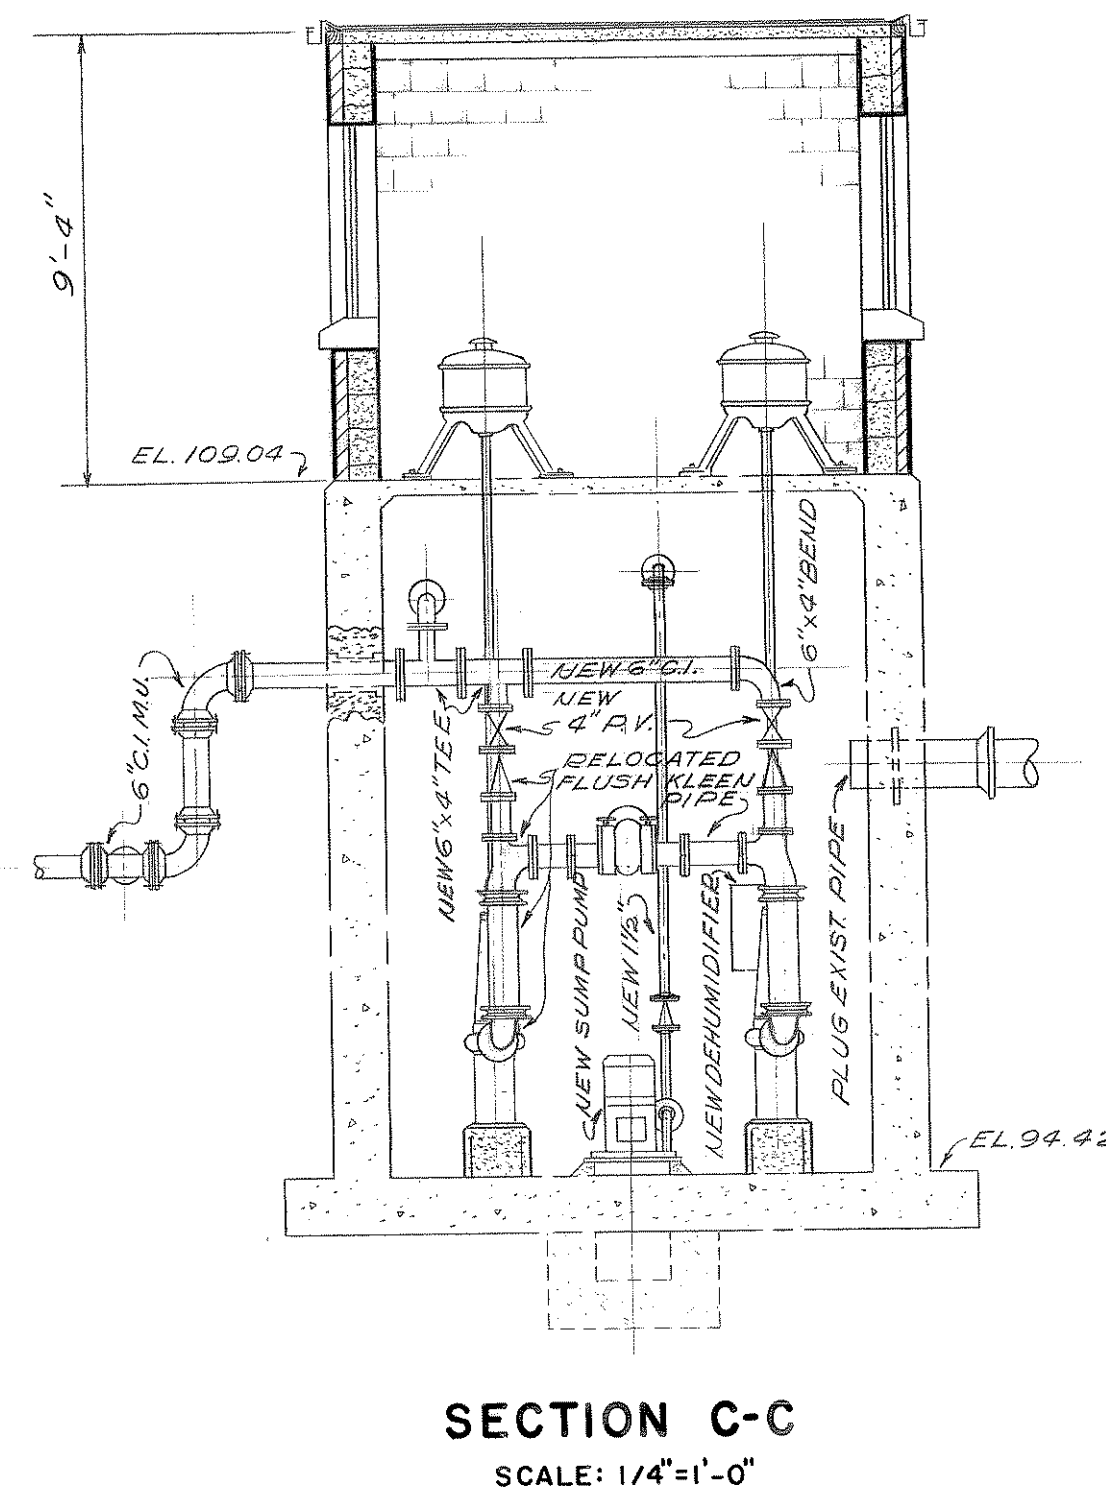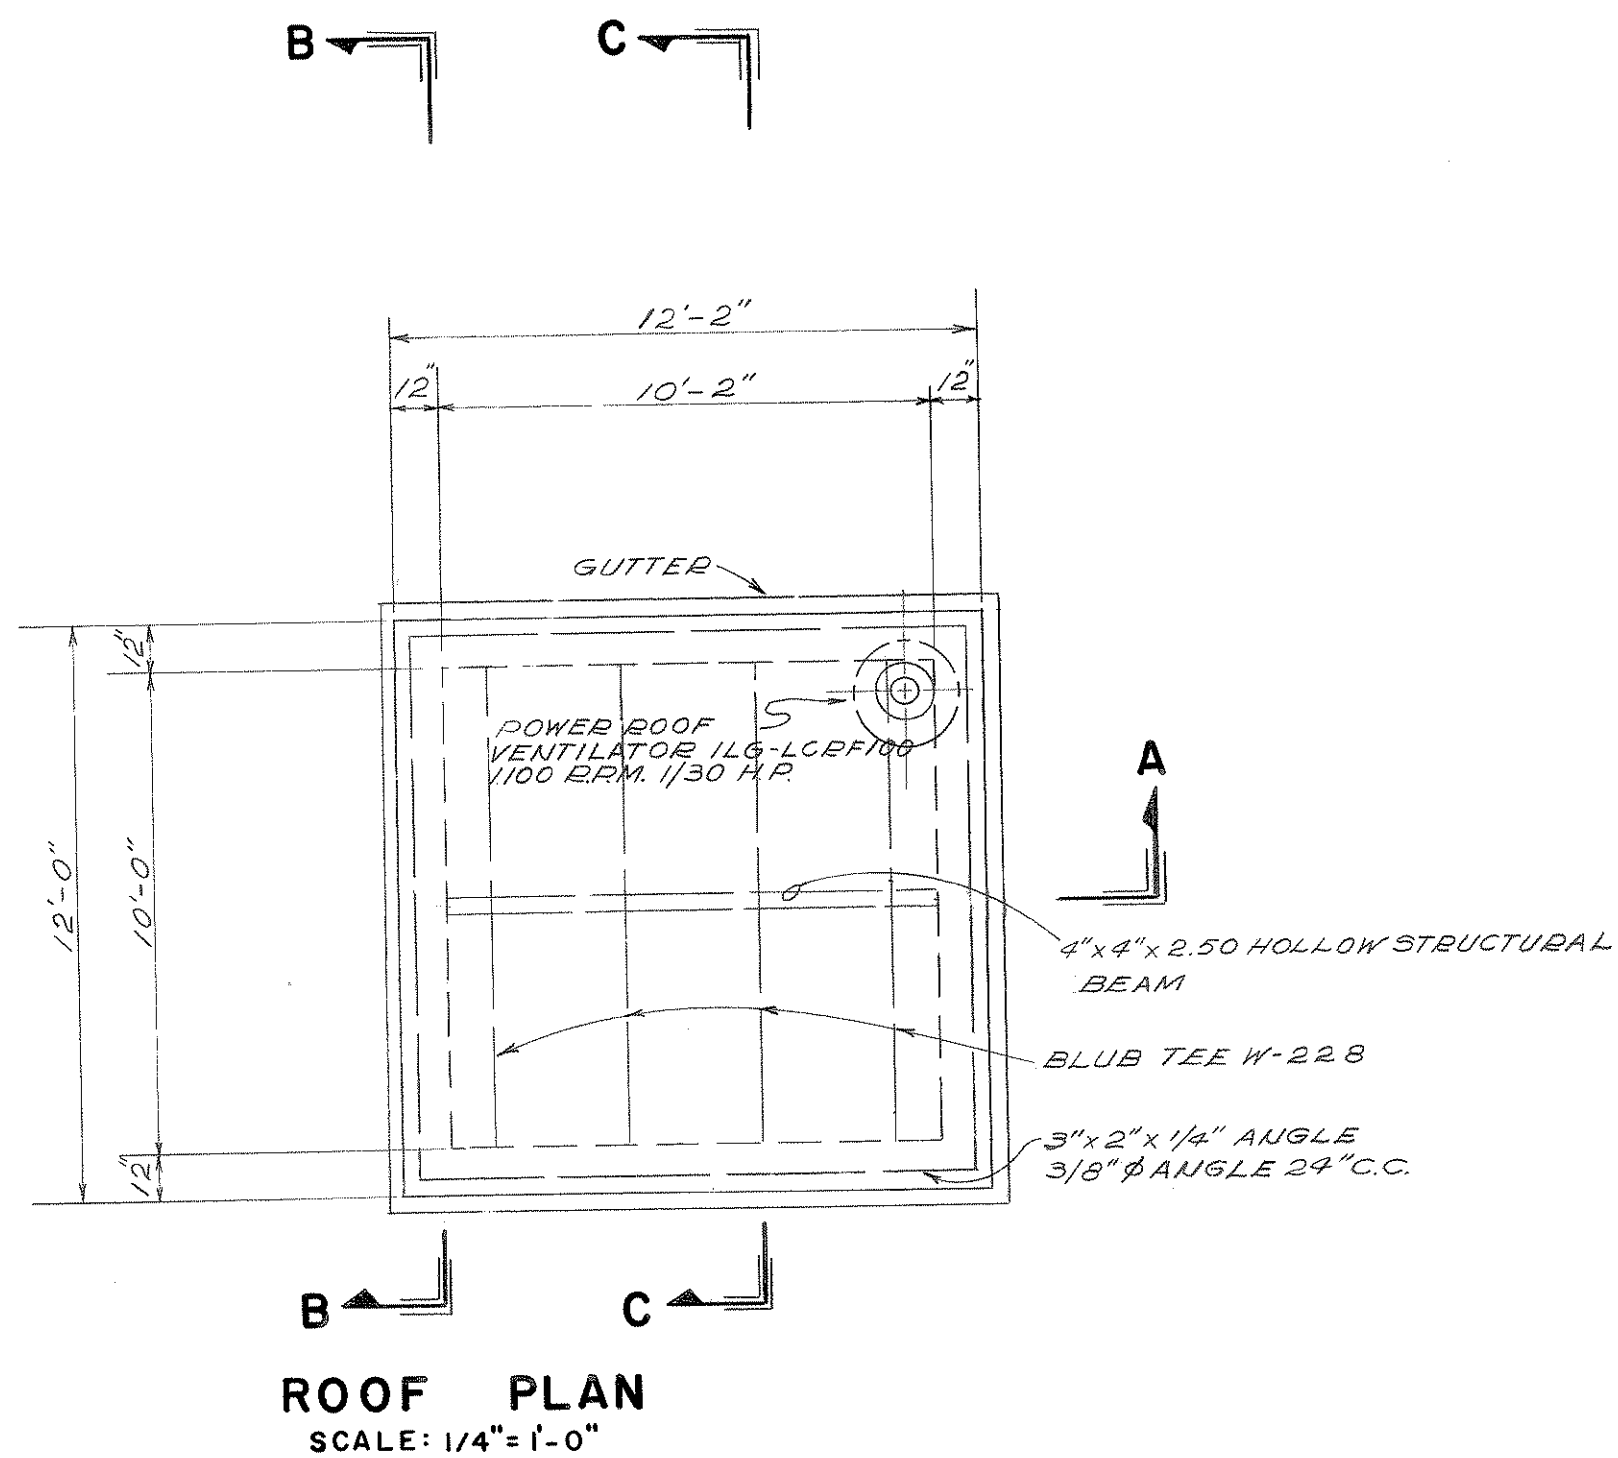

NOTE:
CONTRACTOR TO DISMANTLE AND REMOVE EXISTING WOODEN SUPERSTRUCTURE. ALL MECHANICAL EQUIPMENT TO REMAIN THE PROPERTY OF THE OWNER, TO BE REMOVED AND STORED AT LOCATION DESIGNED BY OWNER. ALL SUPERSTRUCTURE MATERIAL SHALL BECOME THE PROPERTY OF THE CONTRACTOR AND SHALL BE REMOVED FROM THE SITE.


LADDER DETAIL
CONTRACT 'C'

CITY OF BRUNSWICK, GEORGIA
SEWERAGE SYSTEM IMPROVEMENTS


RAW SEWAGE
PUMPING STATION NO. 8

SCALE AS SHOWN DATE JULY, 1963
WIEDEMAN AND SINGLETON ENGINEERS ATLANTA GEORGIA
SHEET 11 OF 15


DATUM EQUALS USCGS MEAN
SEA LEVEL PLUS 106.00 FT.

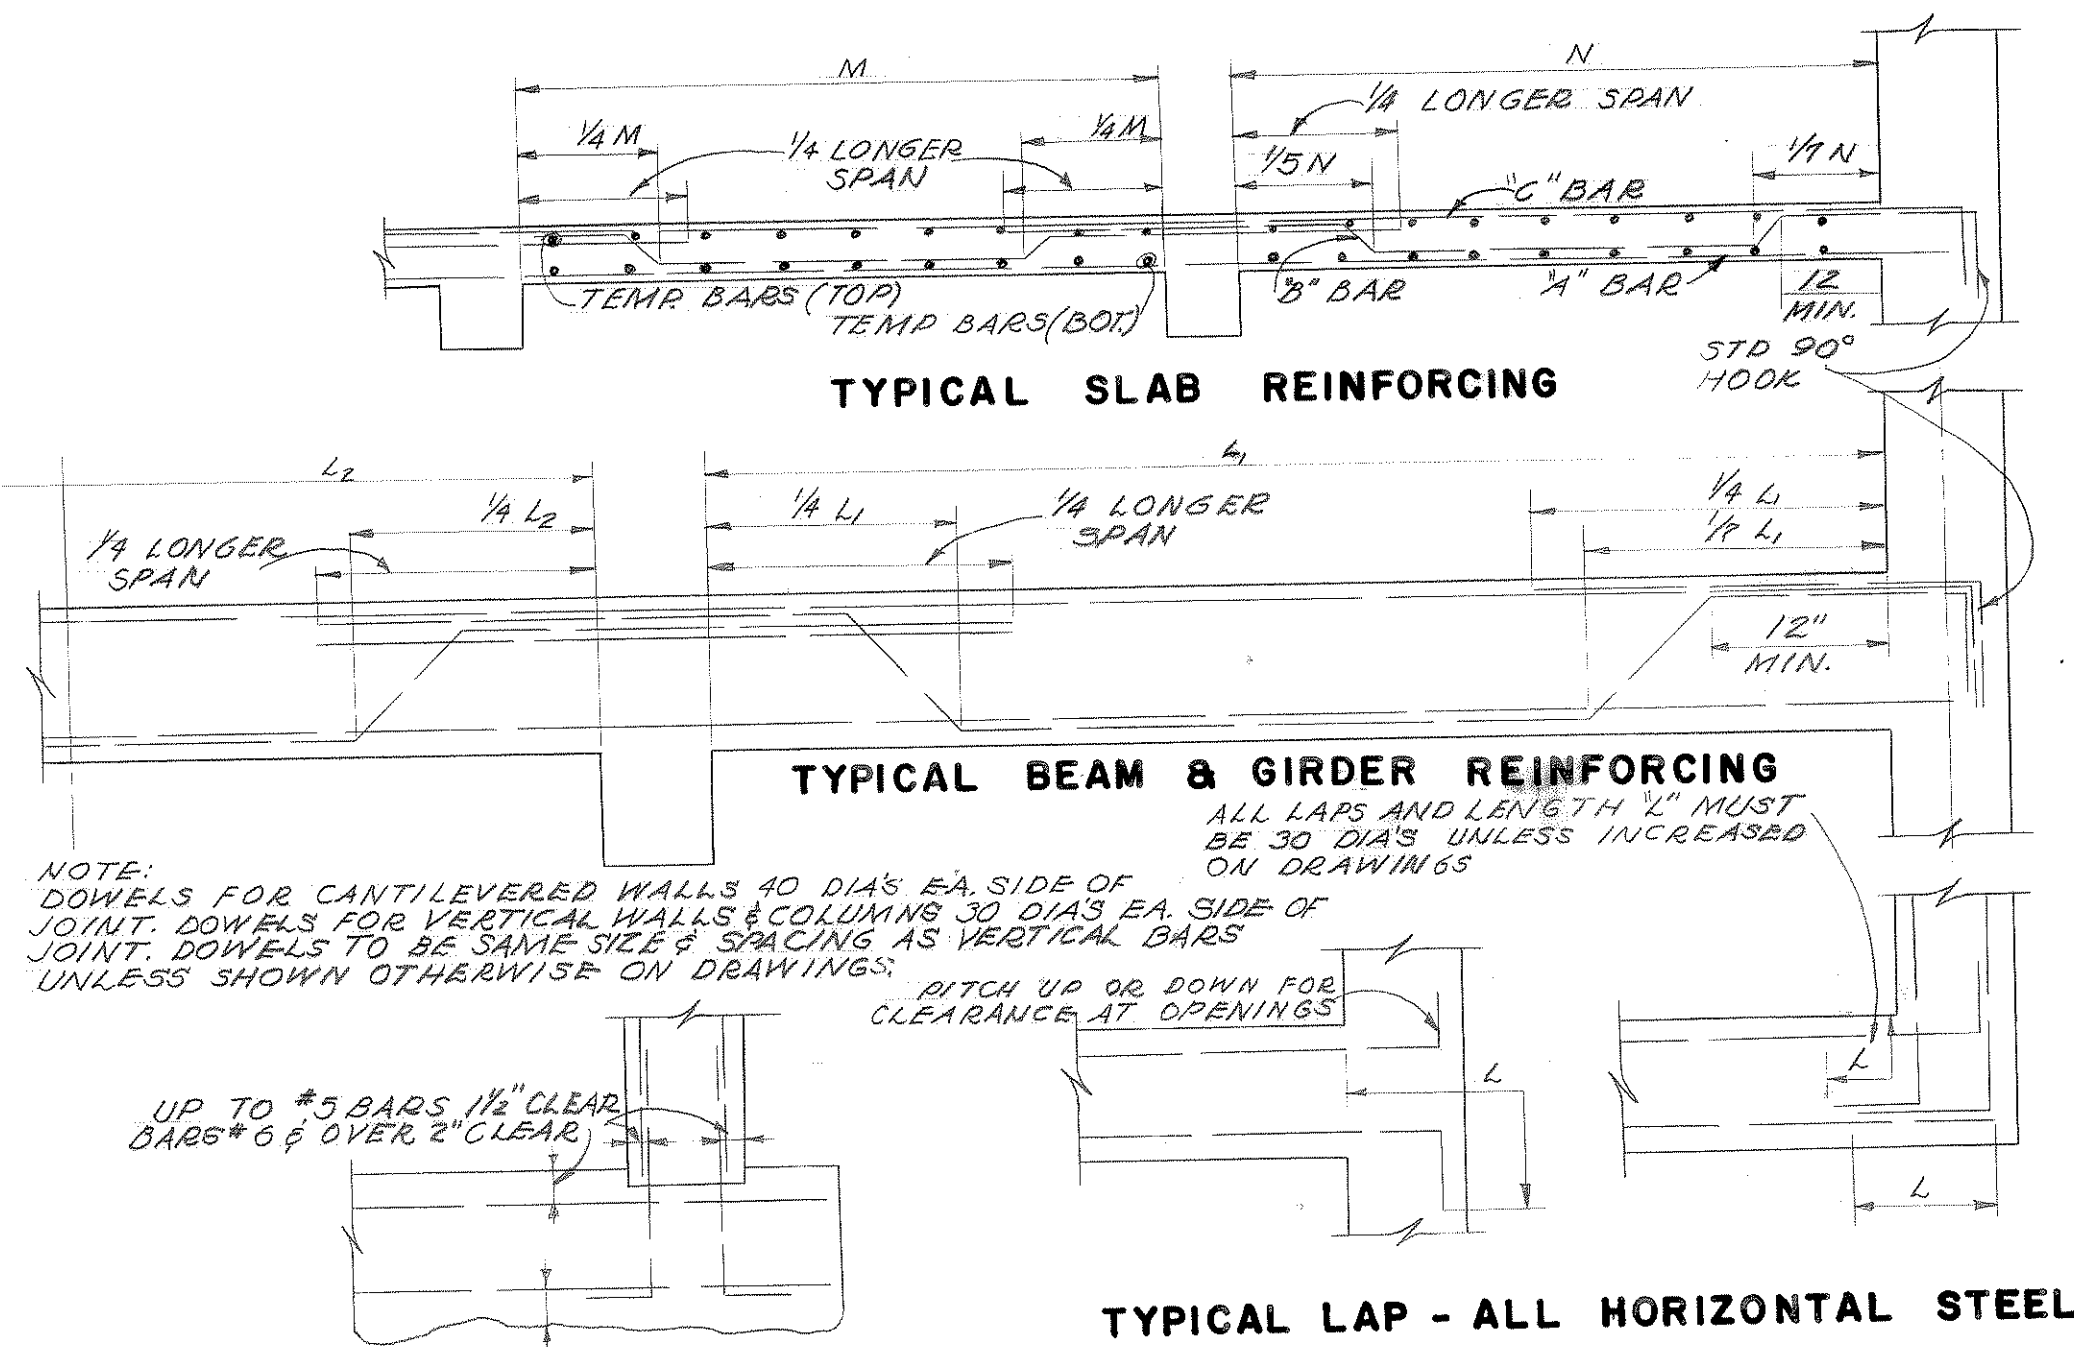


BENDING & PLACING REINFORCING ALL STRUCTURES

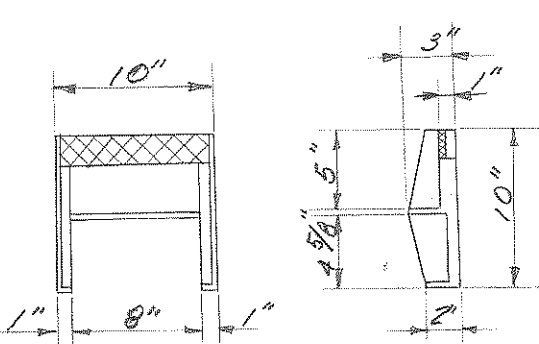


NOTE: C.I. M.H. STEPS IN M.H. OR OTHER STRUCTURES ARE TO BE 15" O.C. STAGGERED CLOW NO. 4. 3650 OR EQUAL

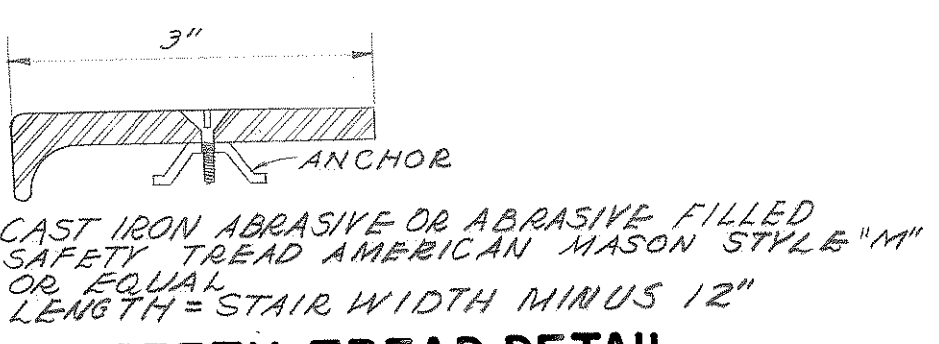


SAFETY TREAD DETAIL

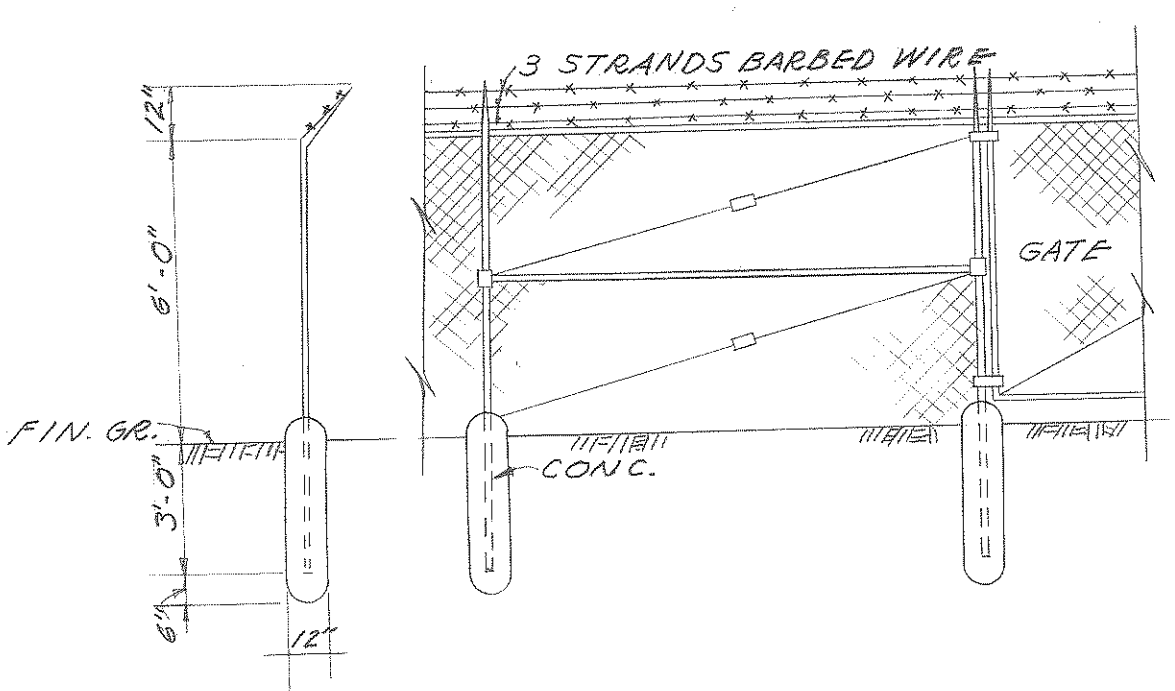


FENCE DETAIL

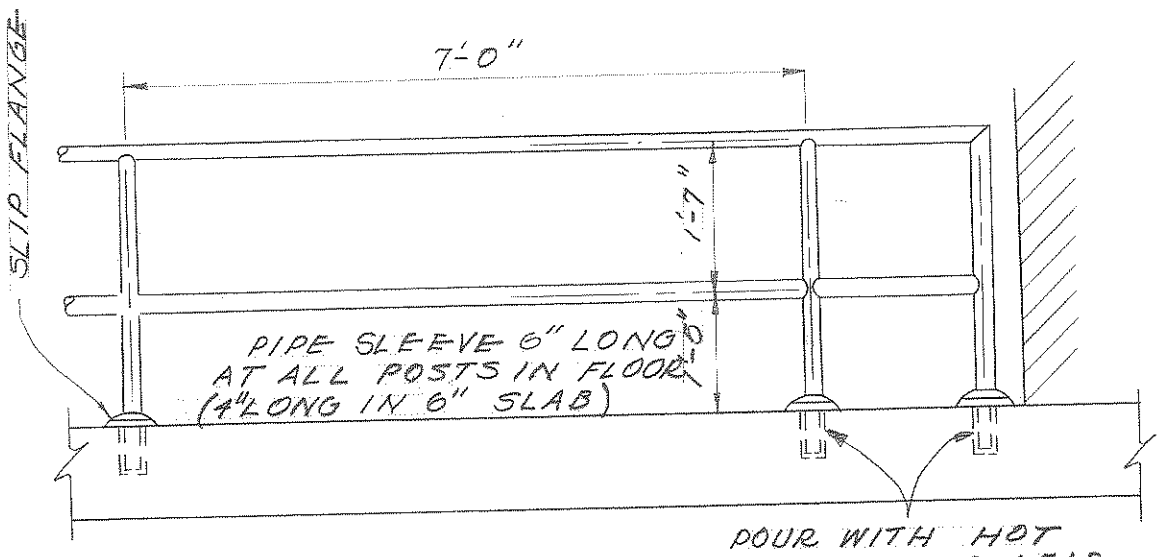

1 1/2" DIAMETER HANDRAIL DETAIL

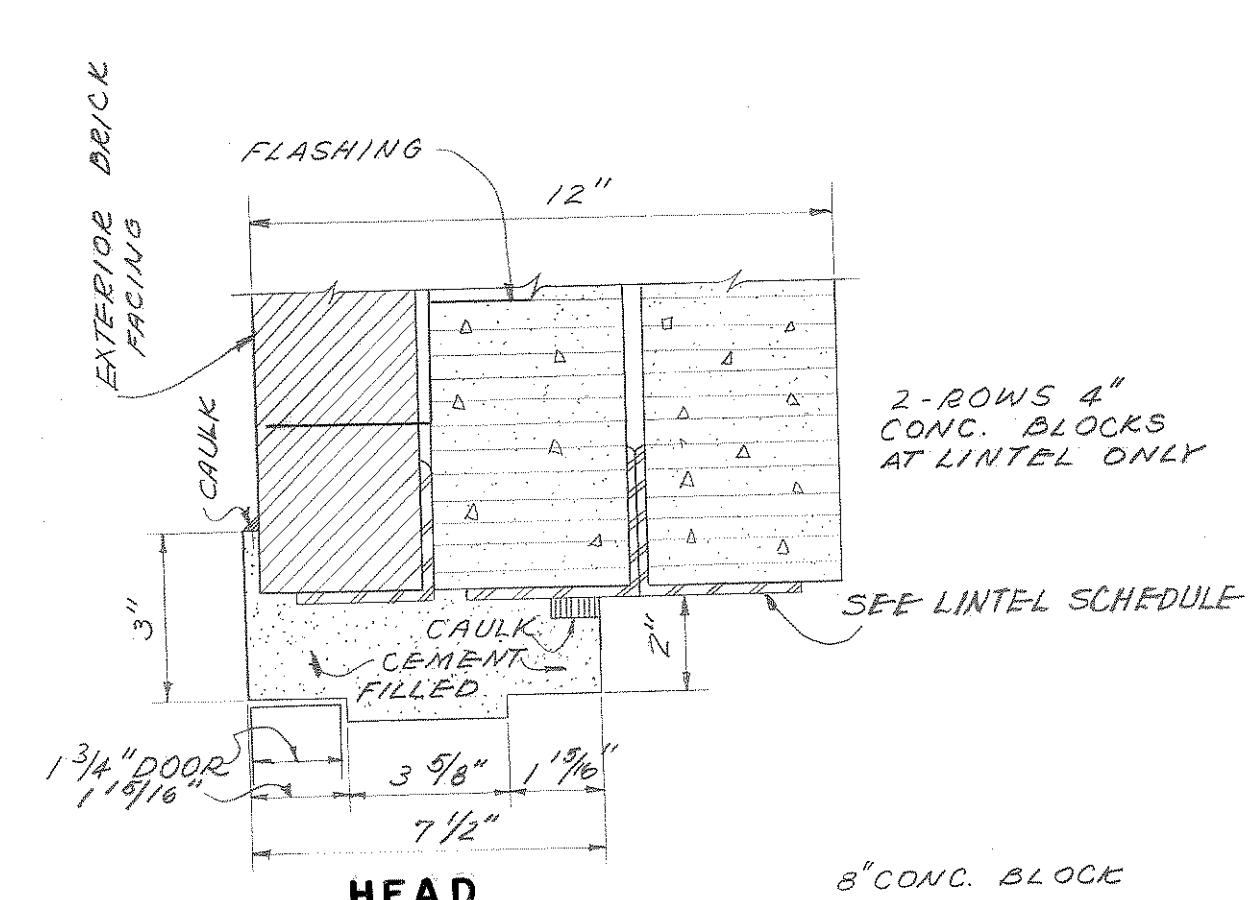

PIPE VENT DETAIL

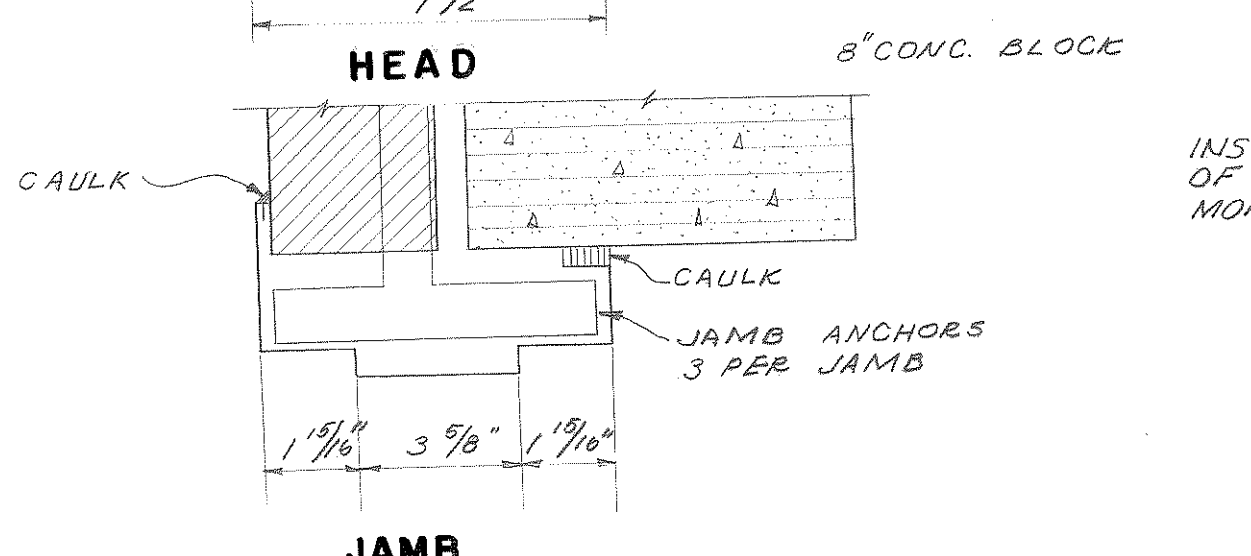


THRESHOLD

EXTERIOR DOOR

NOT TO SCALE


WOODSTOCK ABRASIVE CAST ALUM. THRESHOLD TYPE 115-3 OR EQUAL

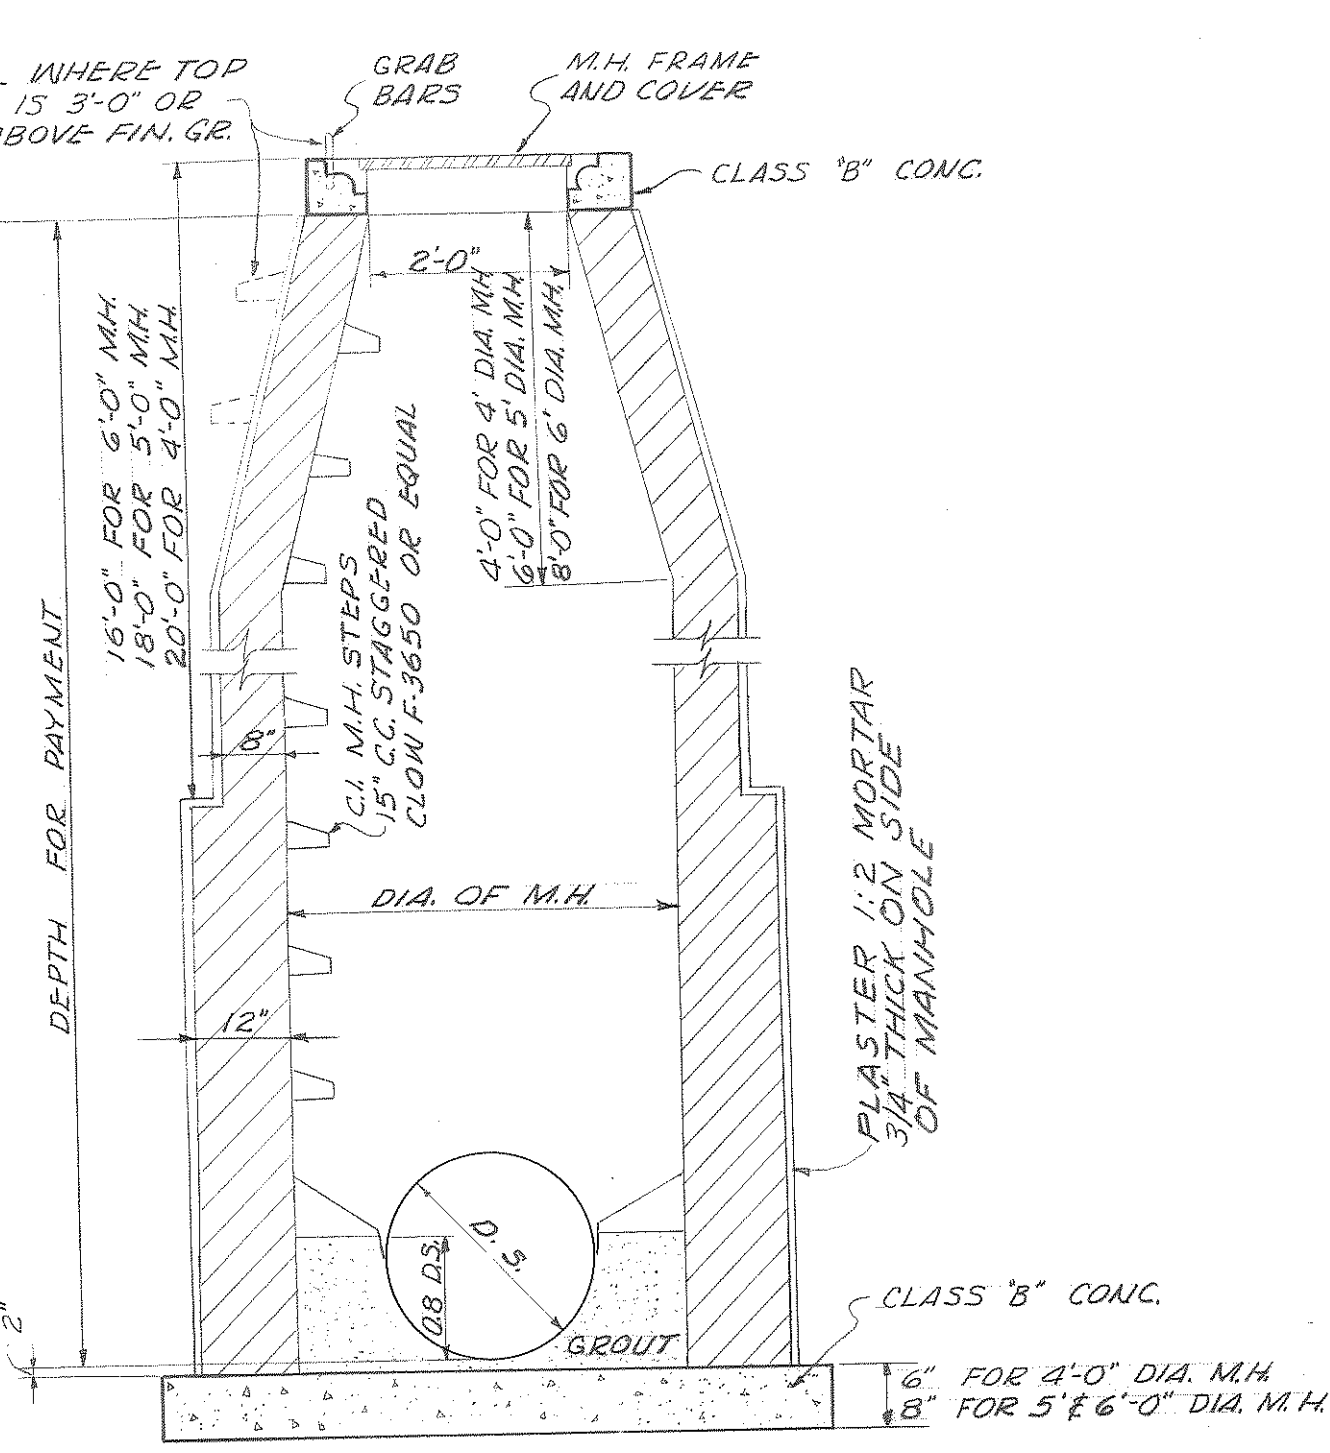

STANDARD BRICK MANHOLE




NOT TO SCALE

OPENINGS IN WALLS & SLABS

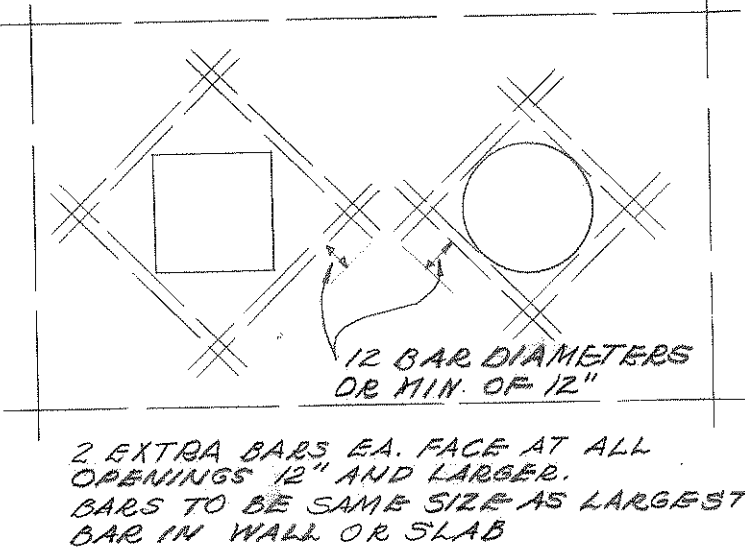


TYPICAL WATER STOP

NOT TO SCALE

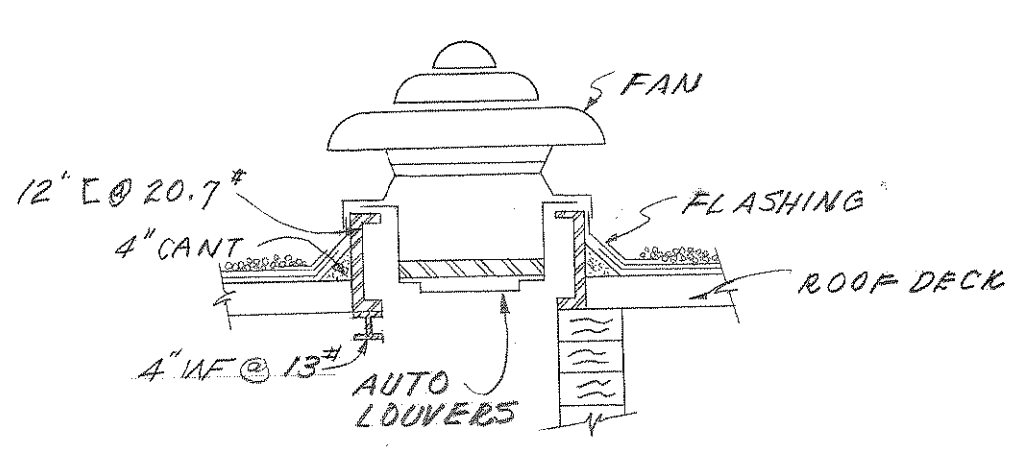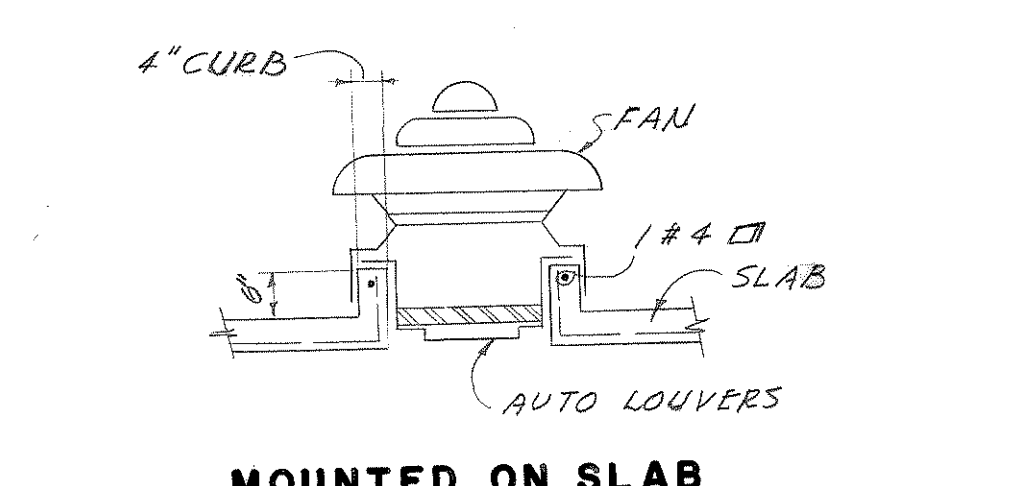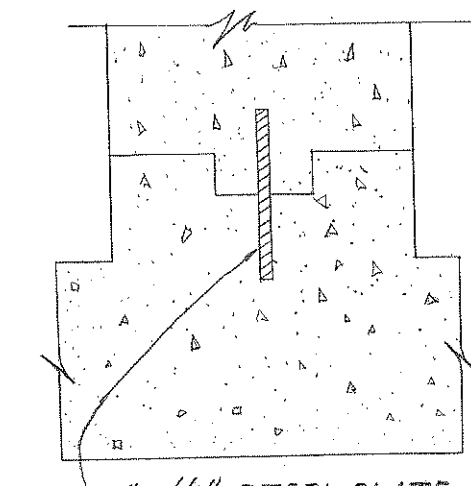


POWER ROOF VENTILATOR

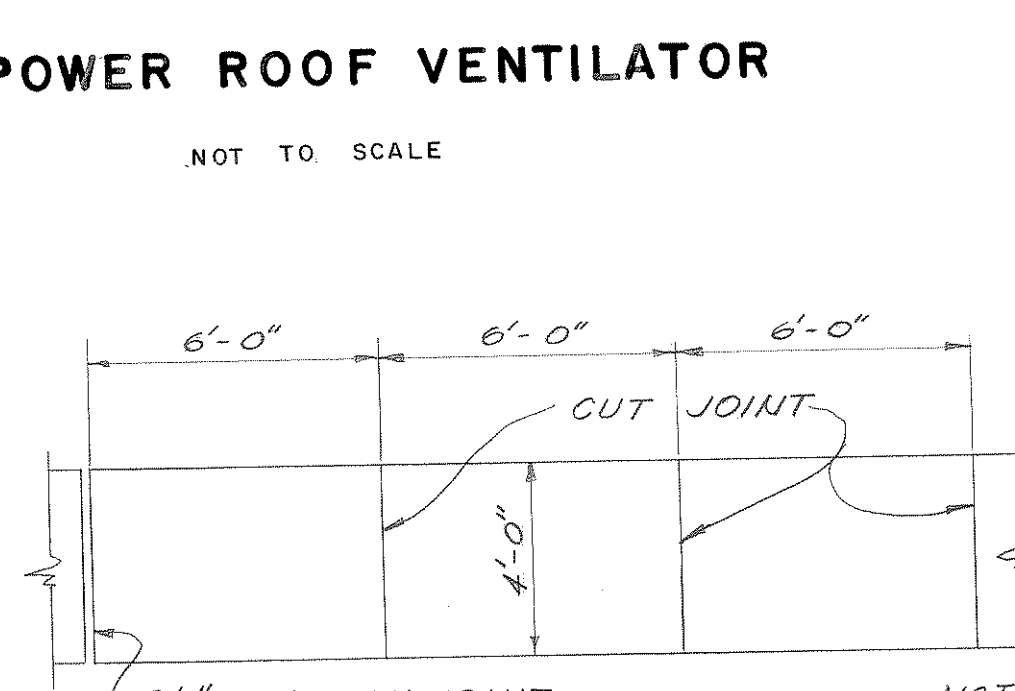


CONCRETE WALKWAYS

SCALE: 1/4" = 1'-0"

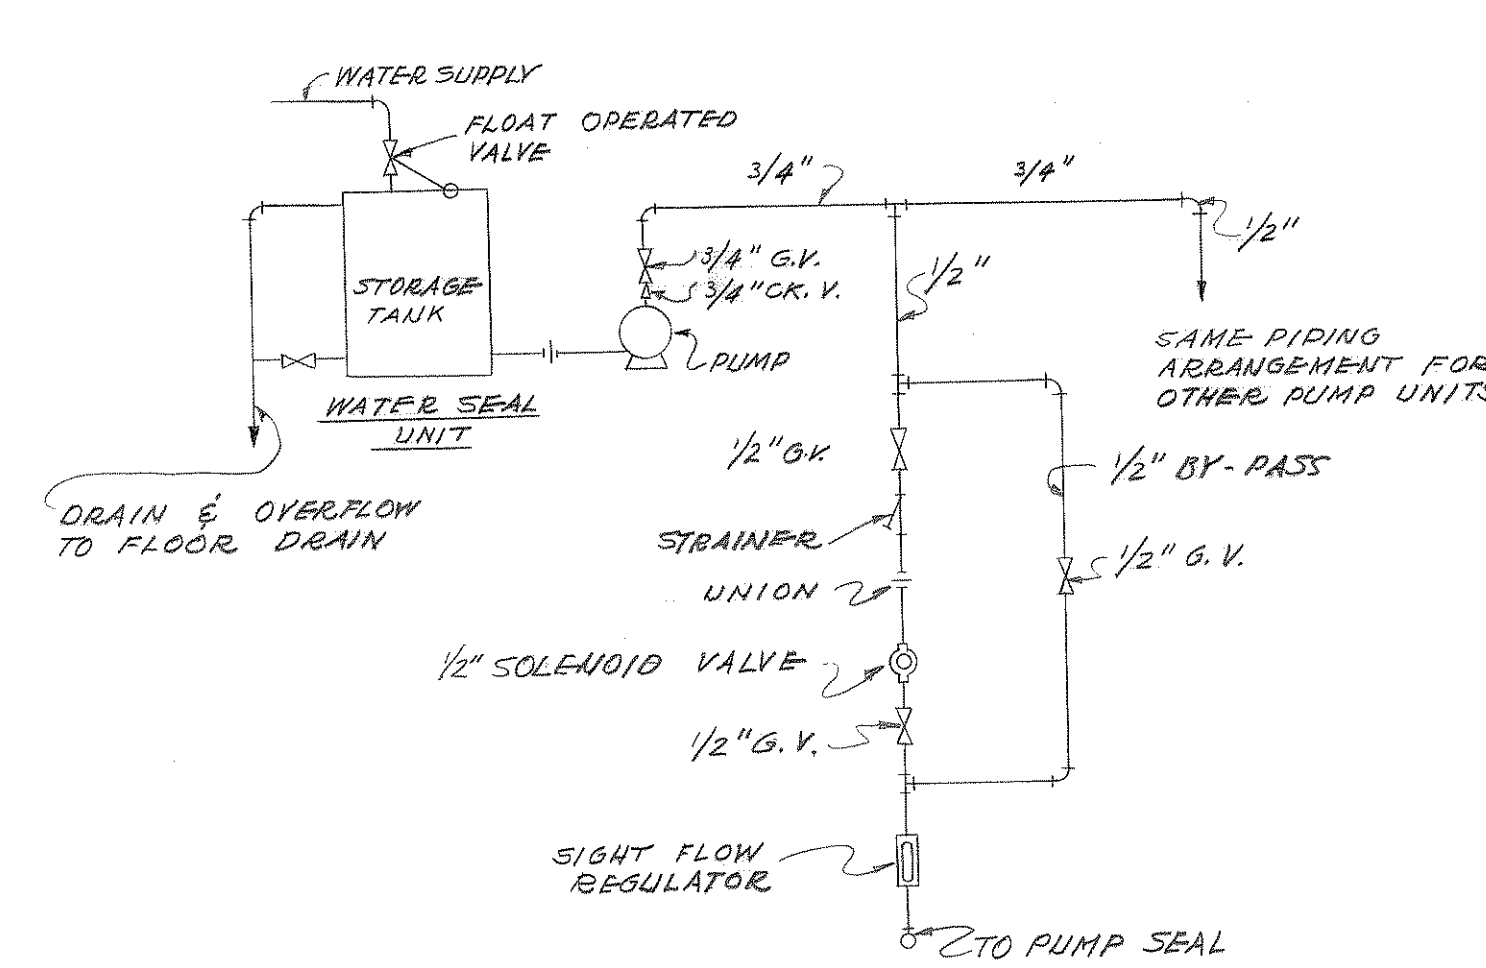


TYPICAL WATER SEAL PIPING

NOT TO SCALE

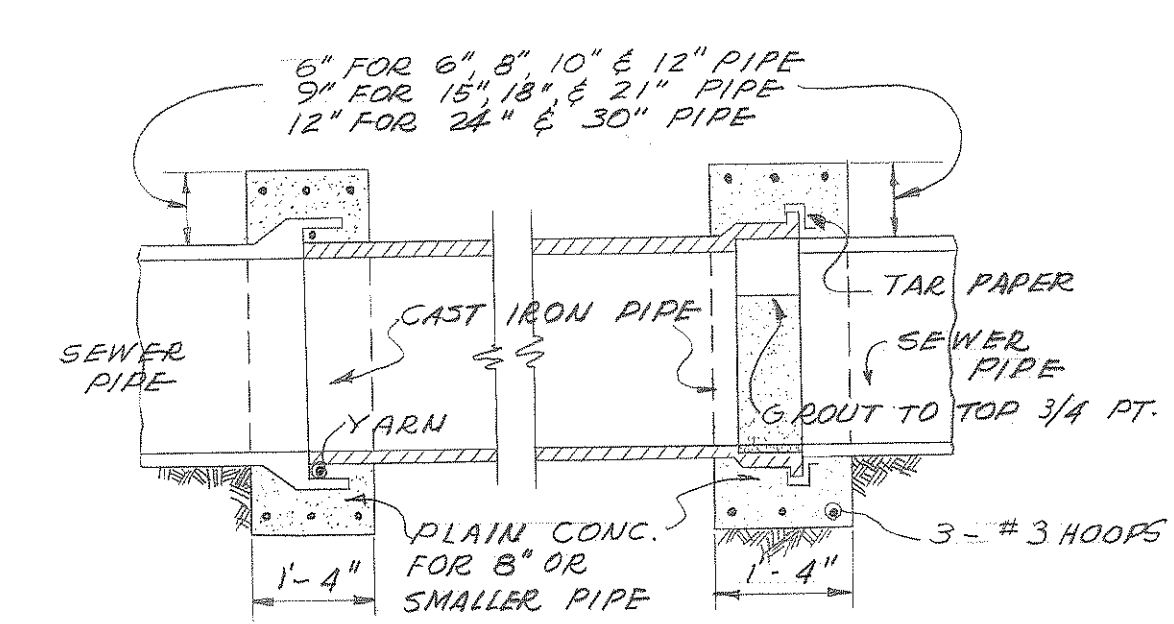

SQ. CONC. COLLAR JOINING C.I. PIPE TO SEWER PIPE

NOT TO SCALE

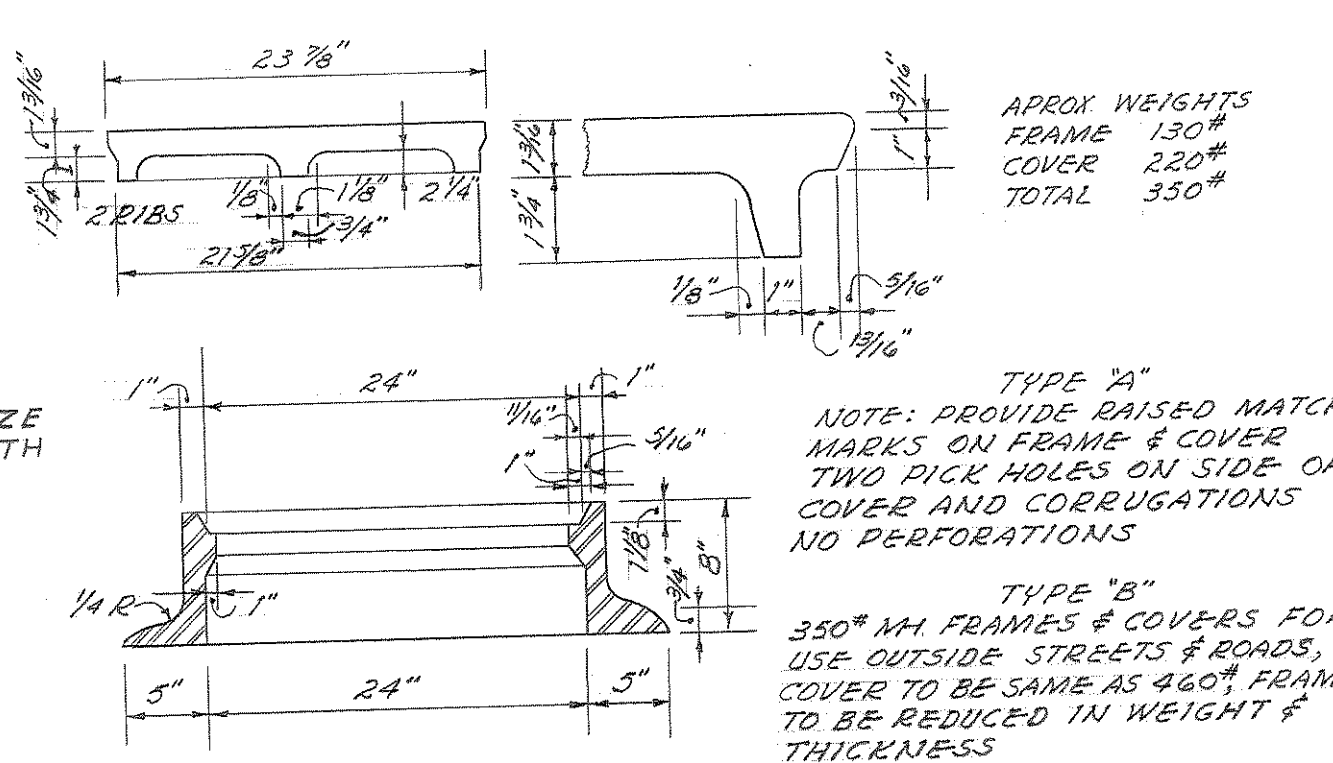


STANDARD MANHOLE FRAME & COVER

NOT TO SCALE

GATE SCHEDULE										
MARK	LOCATION	DWG. NO.	NO. REQD.	GATE EQUAL TO	GATE SIZE	HT. INK TO FL.	LIFT	REMARKS		
G-1	PUMP STATION #1	2	1	SERIES 165	12" x 12"	13'-6"	FLOOR STAND			
G-2	"	"	1	"	74" x 33"	6'-6"	ANGLE			
G-3	"	"	1	"	25" x 43"	6'-6"	"			
G-4	"	"	1	"	36" x 43"	7'-0"	"			
G-5	"	"	1	"	36" x 33"	6'-6"	"			
G-6	"	"	1	"	25" x 43"	6'-6"	"			
G-7	"	"	1	"	36" x 33"	7'-0"	"			
G-8	"	"	1	"	36" x 33"	6'-6"	"			
G-9	"	"	1	"	25" x 43"	6'-6"	"			
G-10	"	"	1	"	36" x 43"	7'-0"	"			
G-11	"	"	1	"	165	26" x 18'-10 3/16"	FLOOR STAND			

LINTEL SCHEDULE


CLEAR OPENING SIZE	SIZE OF LINTEL L'S
0" TO 3'-6"	3'3 1/2" x 3 1/2" x 1/4" L'S
3'-6" TO 6'-0"	3'-5" x 3 1/2" x 1/4" L'S
6'-0" TO 8'-0"	3'-6" x 3 1/2" x 1/4" L'S

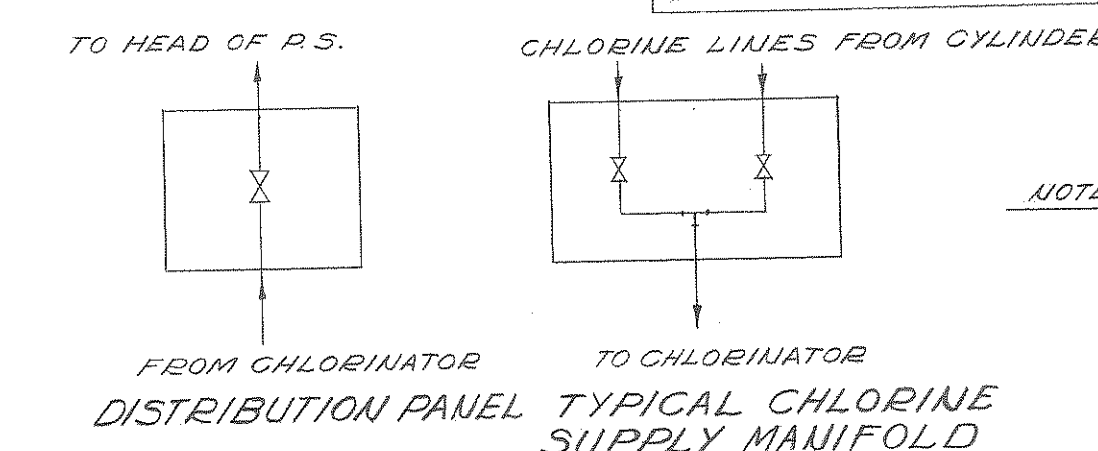

CHLORINE MANIFOLD

NOT TO SCALE

TO BE SUPPLIED BY CHLORINE EQUIPMENT MANUFACTURERS

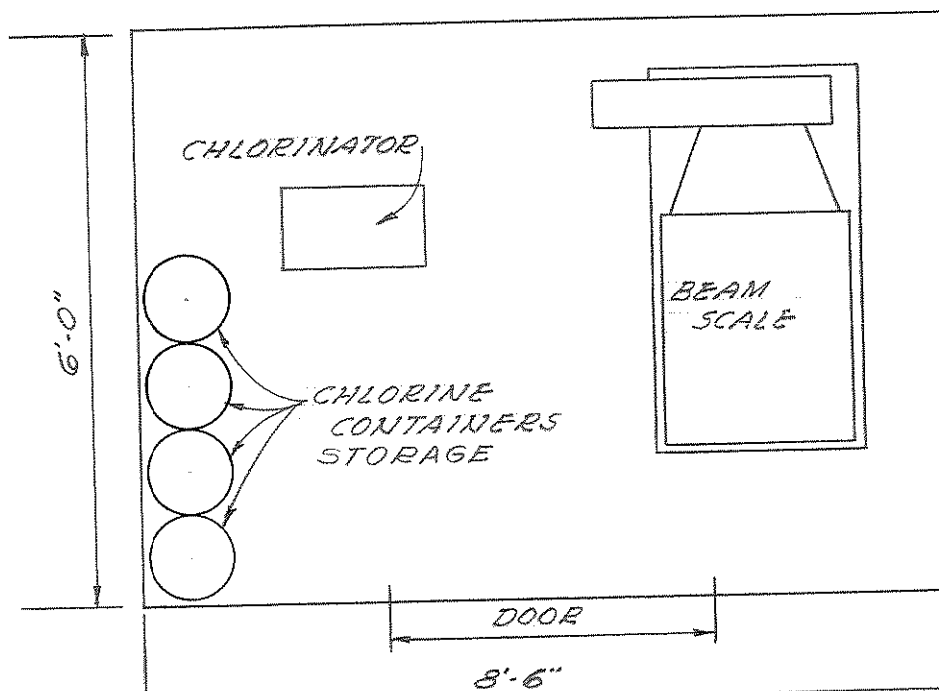

CHLORINE ROOM LAYOUT

NOT TO SCALE


CONTRACT "C"

CITY OF BRUNSWICK, GEORGIA SEWERAGE SYSTEM IMPROVEMENTS


MISCELLANEOUS DETAILS

DATUM EQUALS USCGS MEAN SEA LEVEL PLUS 100.00 FT.


SCALE AS SHOWN	WIEDEMAN AND SINGLETON ENGINEERS	SHEET 12 OF 15
DATE JULY, 1963	ATLANTA GEORGIA	

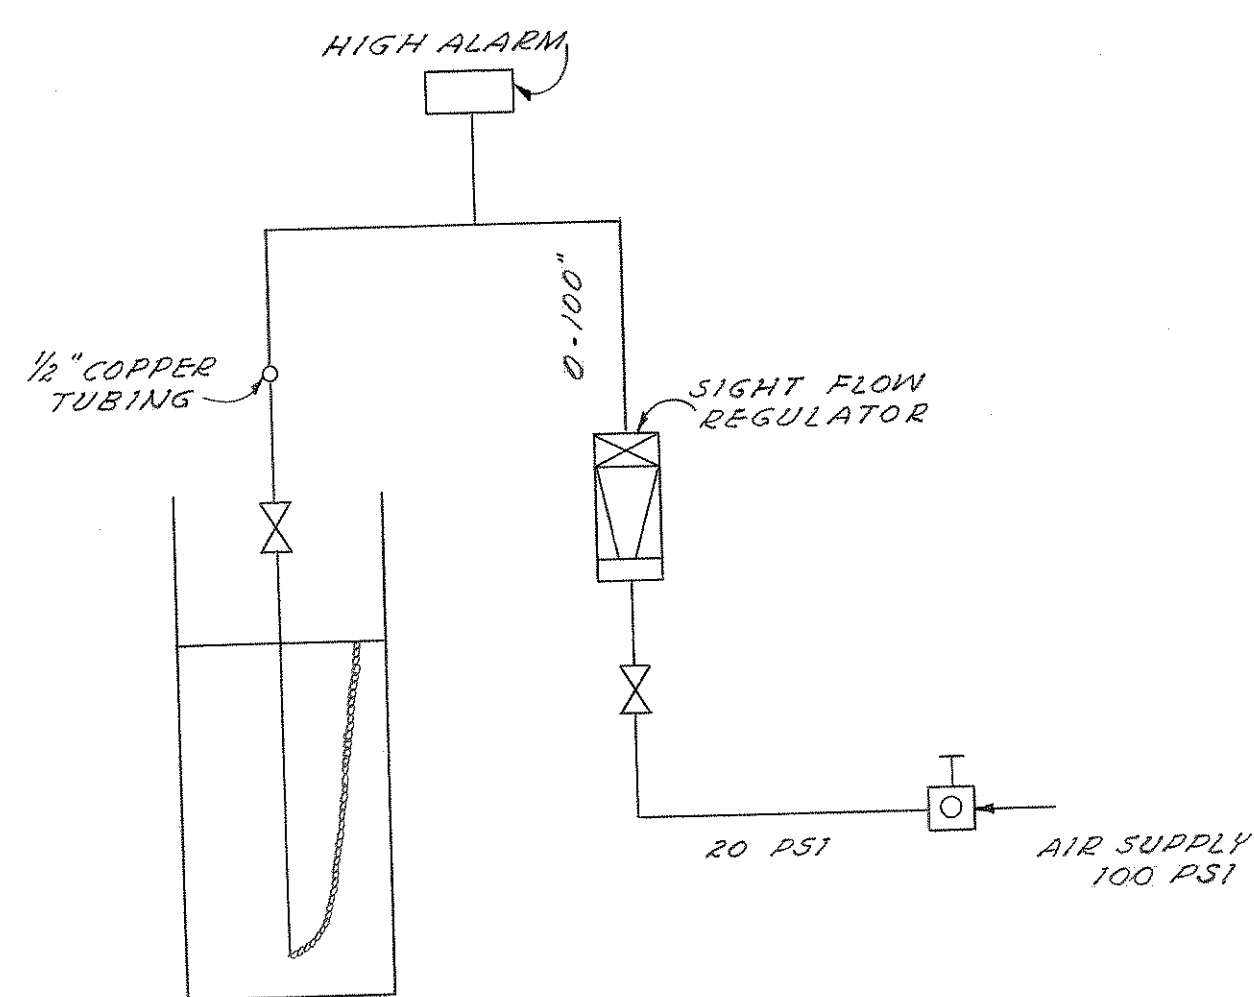


COMMUNUTOR HIGH LEVEL ALARM SYSTEM

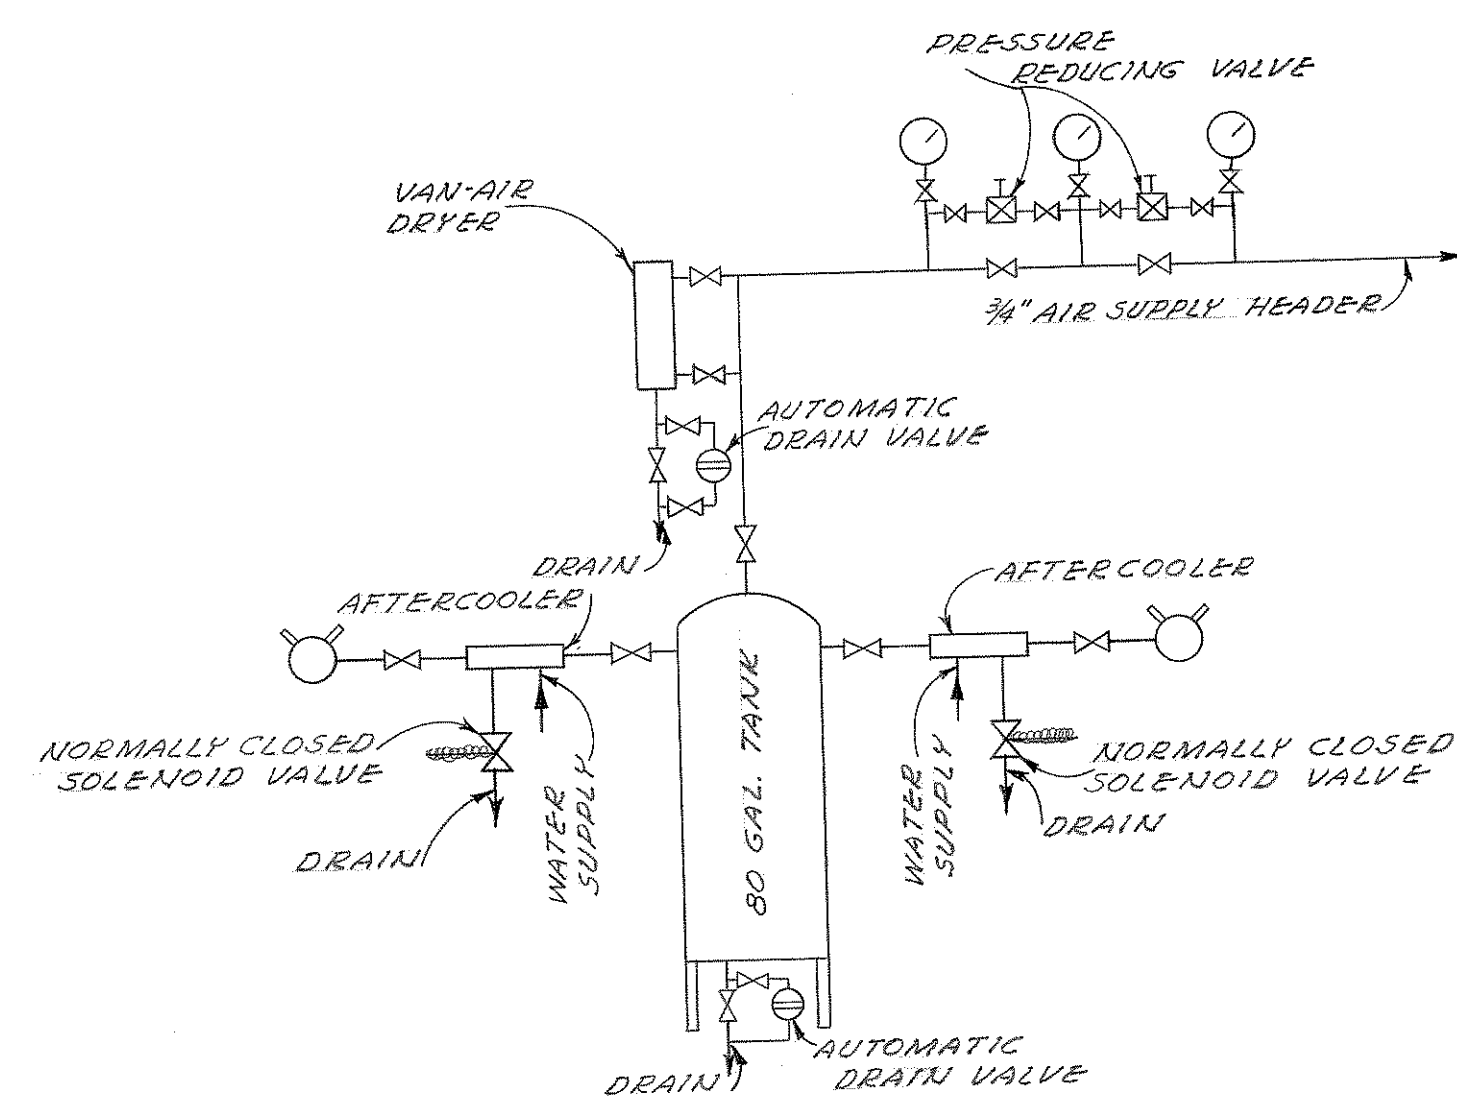


TYPICAL AIR COMPRESSOR CONNECTION

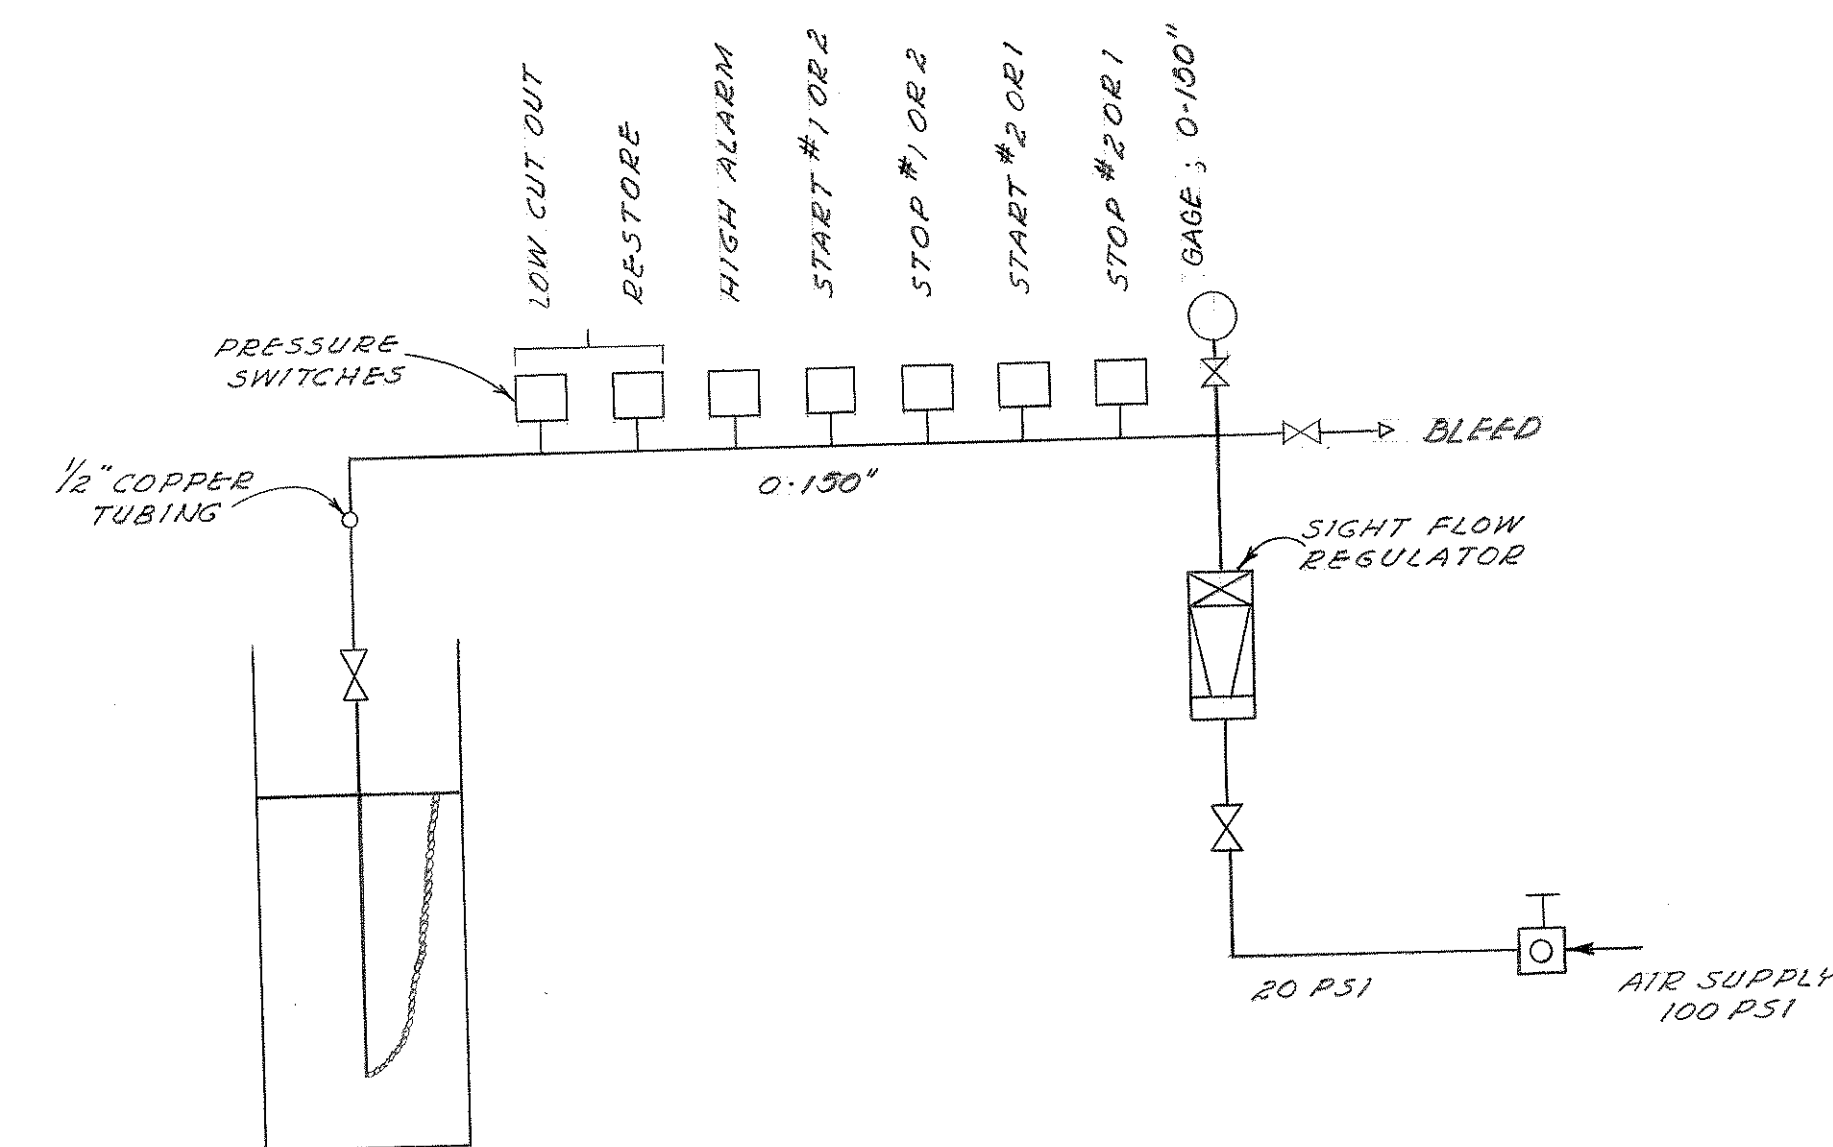


PNEUMATIC CONTROL DIAGRAM
PUMPING STATION NO. 8

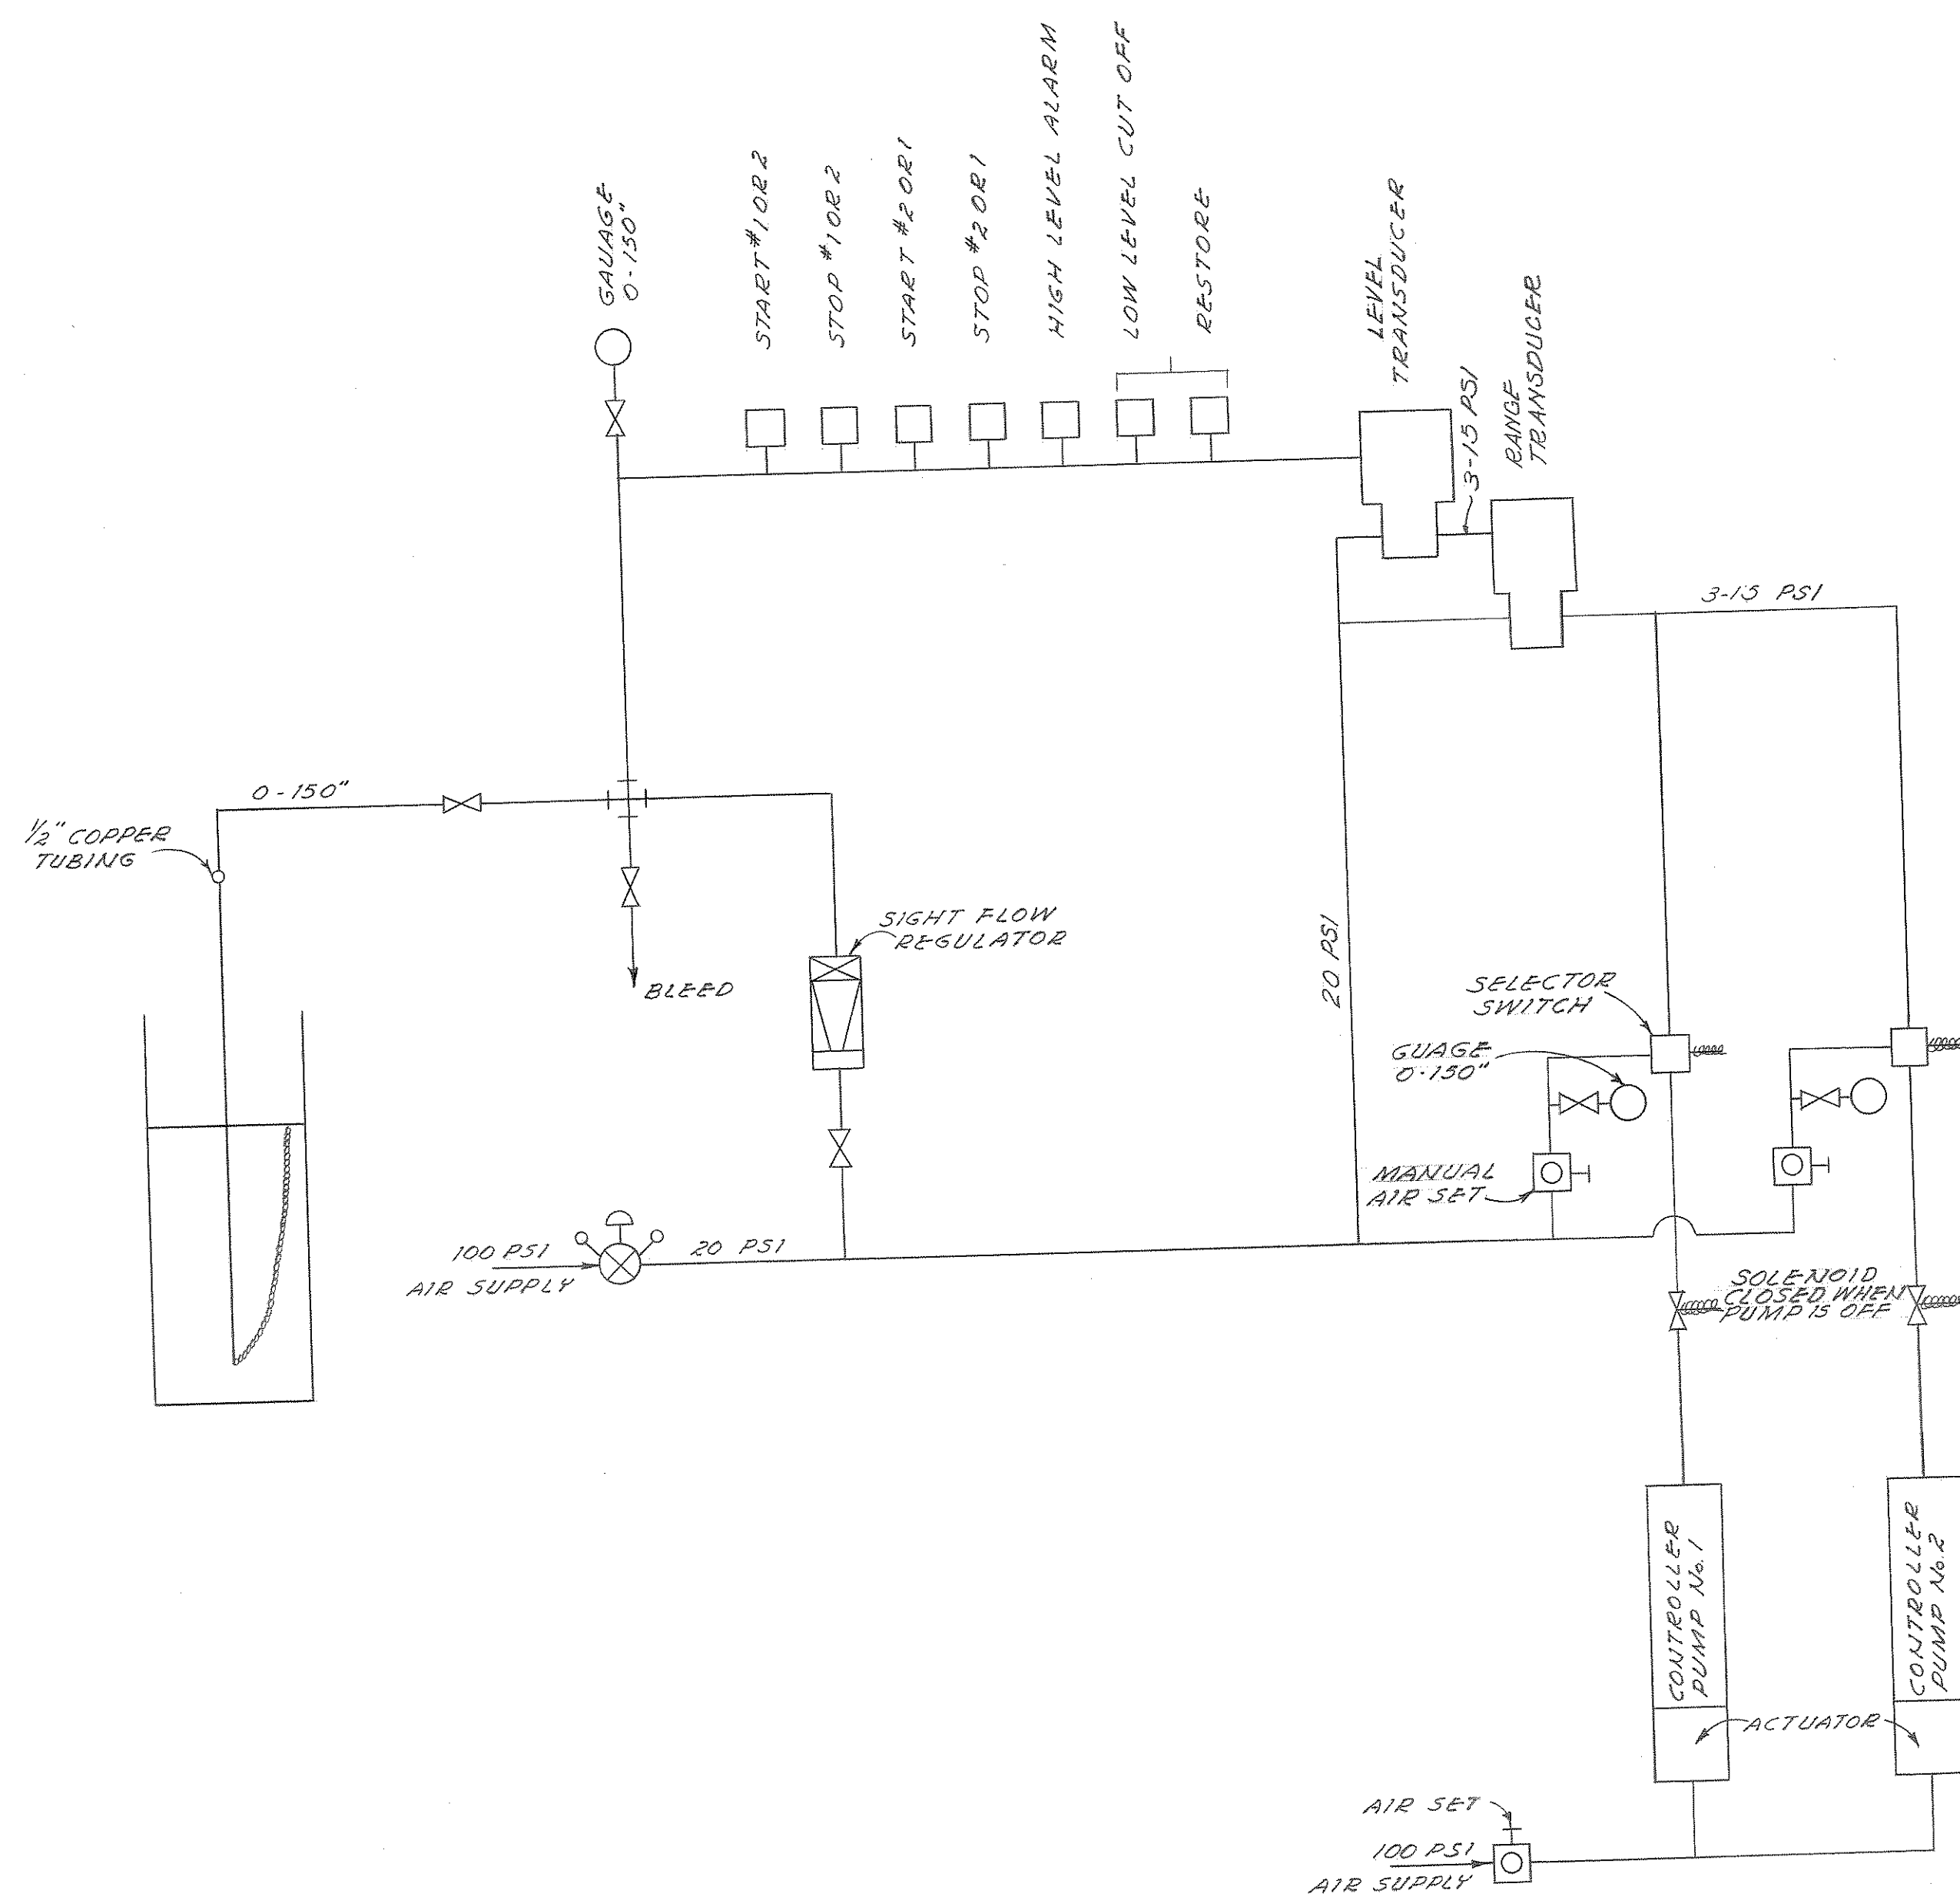

PNEUMATIC CONTROL DIAGRAM
ALL PUMPING STATIONS EXCEPT NO. 8

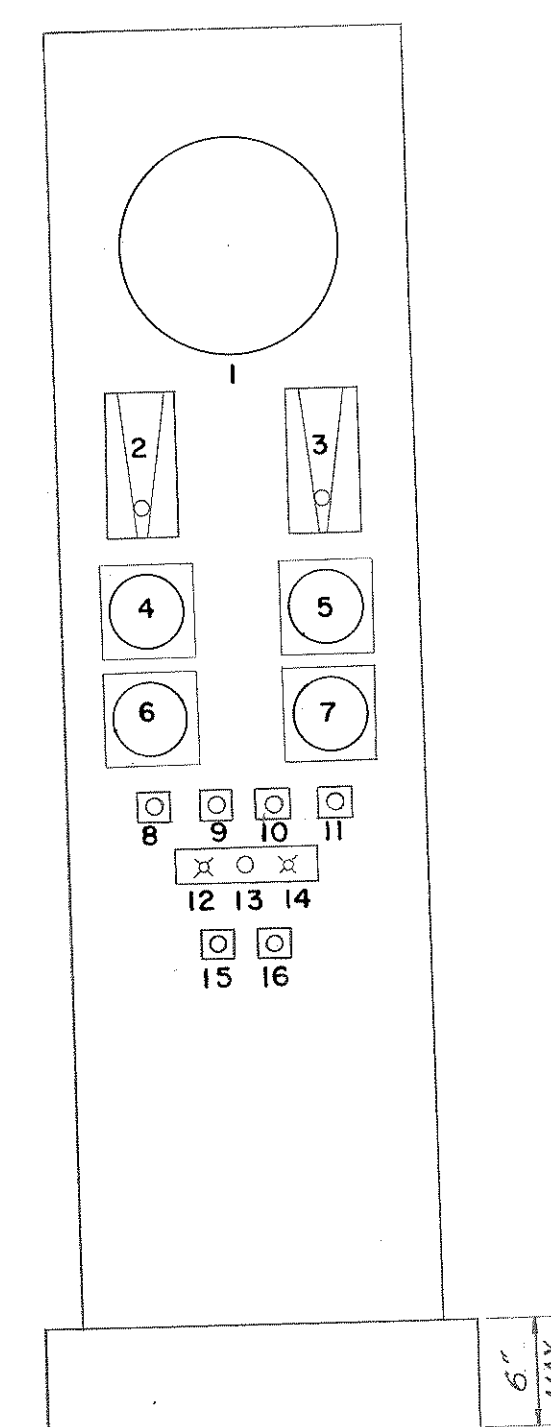


PUMPING STATIONS 2,3,5

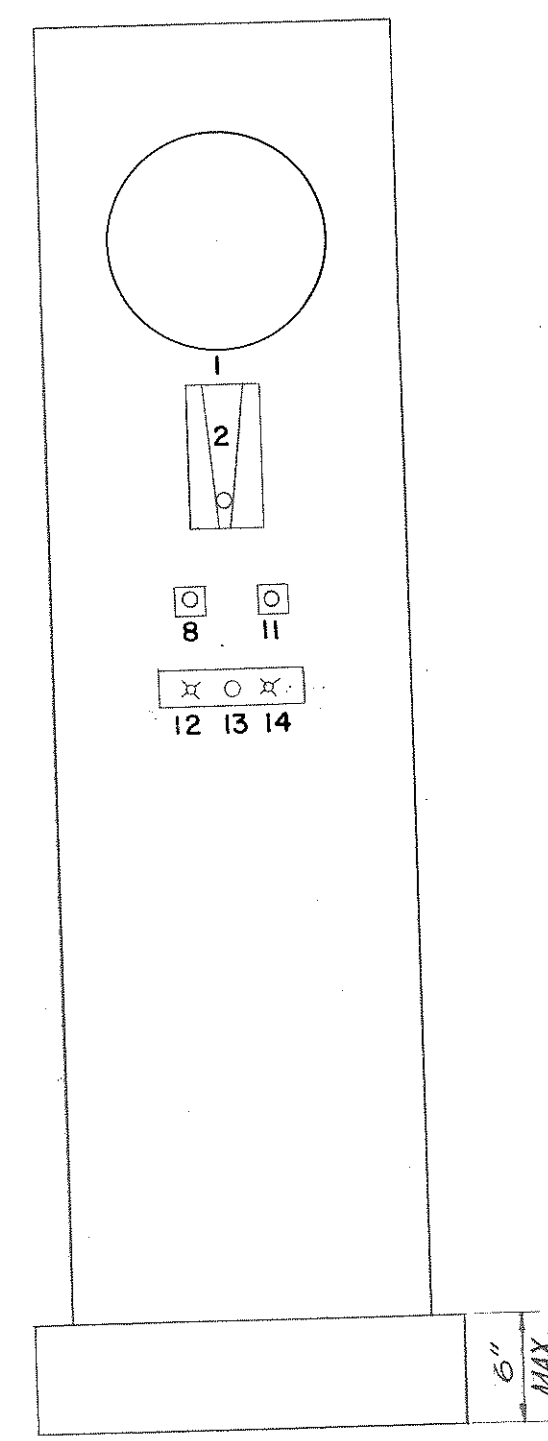


PUMPING STATION 8

INSTRUMENT PANELS
NOT TO SCALE

INSTRUMENT PANELS SCHEDULE		
NO.	INSTRUMENT	SERVICE
1	12" DIAL	WET WELL LEVEL
2	AIR FLOW METER	WET WELL
3	AIR FLOW METER	COMMUNUTOR PIT LEVEL
4	4" DIAL	NO. 1 PUMP SETTING
5	4" DIAL	NO. 2 PUMP SETTING
6	4" DIAL	MANUAL SIGNAL, NO. 1 PUMP
7	4" DIAL	MANUAL SIGNAL, NO. 2 PUMP
8	2 POSITION SWITCH	AUTO-MANUAL SELECTOR SWITCH NO. 1 PUMP
9	MANUAL AIR SET	MANUAL SIGNAL, NO. 1 PUMP
10	MANUAL AIR SET	MANUAL SIGNAL, NO. 2 PUMP
11	2 POSITION SWITCH	AUTO-MANUAL SELECTOR SWITCH NO. 2 PUMP
12	RED ALARM LIGHT	WET WELL HIGH LEVEL ALARM
13	RESET BUTTON	COMMUNUTOR PIT HIGH LEVEL ALARM
14	RED ALARM LIGHT	ALARM RESET
15	2 POSITION SWITCH	PUMP SEQUENCE SWITCH
16	PNEUMATIC BLEED	WET WELL LEVEL LINE

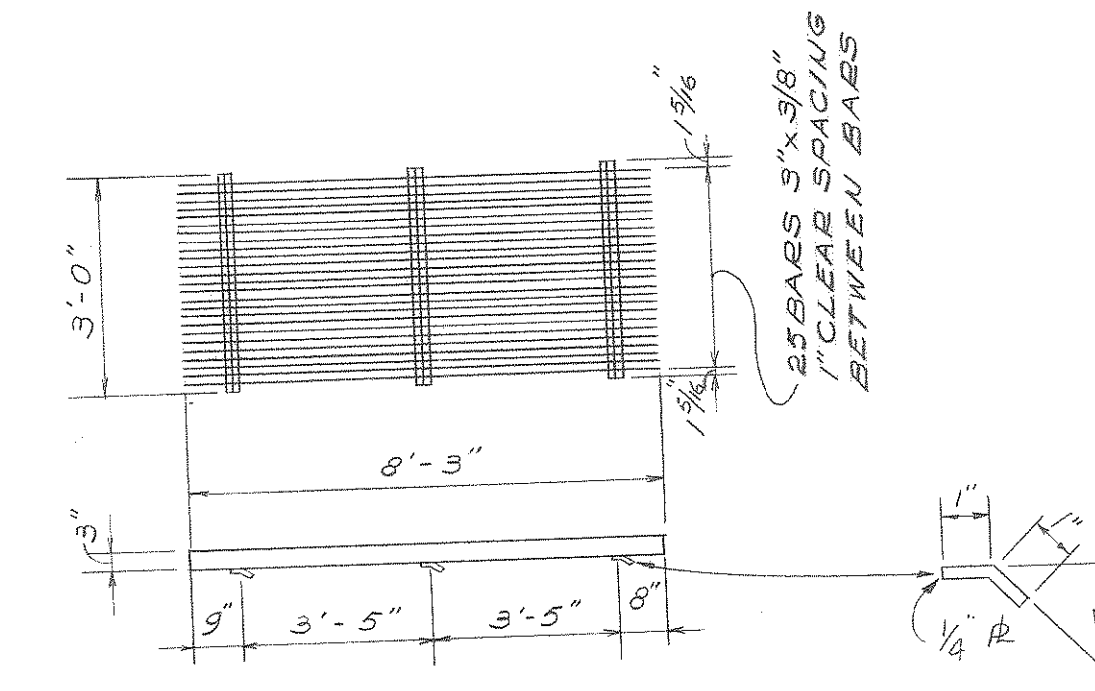

BAR SCREEN DETAIL
SCALE: 3/8" = 1'-0"

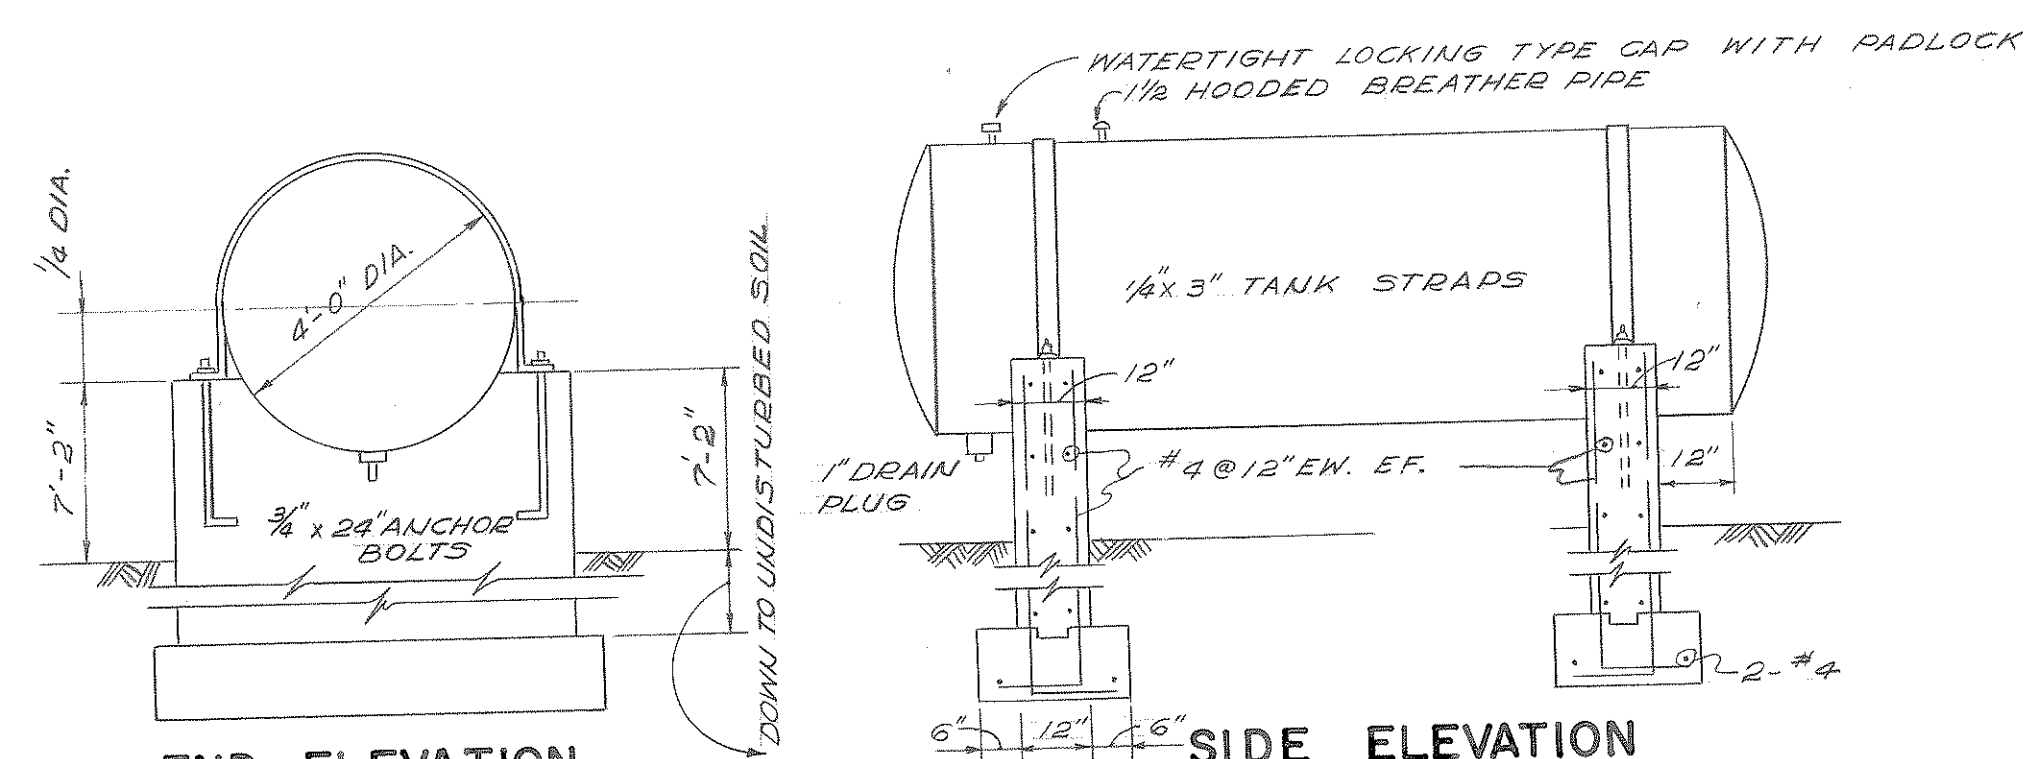

DETAILS OF 250 GALLON OIL STORAGE TANK
NOT TO SCALE

NOTE:
1. TANK TO BE GALVANIZED & ALL METAL WORK TO BE PAINTED, IN ACCORDANCE WITH PAINTING SPECIFICATIONS.
2. PROVIDE CONNECTIONS FOR 1/4" SUCTION 1/2" RETURN 3/4" GAGE LINES TO BE RUN TO CONTROL BUILDING IN 3" TRANSITE CONDUIT.

CONTRACT 'C'

CITY OF BRUNSWICK, GEORGIA
SEWERAGE SYSTEM IMPROVEMENTS






PNEUMATIC CONTROLS
& INSTRUMENTATION

DATUM EQUALS USC&GS MEAN
SEA LEVEL PLUS 100.00 FT.


SCALE
NOT TO SCALE
DATE
JULY, 1963

WIEDEMAN AND SINGLETON
ENGINEERS
ATLANTA GEORGIA


SHEET
13
OF 15

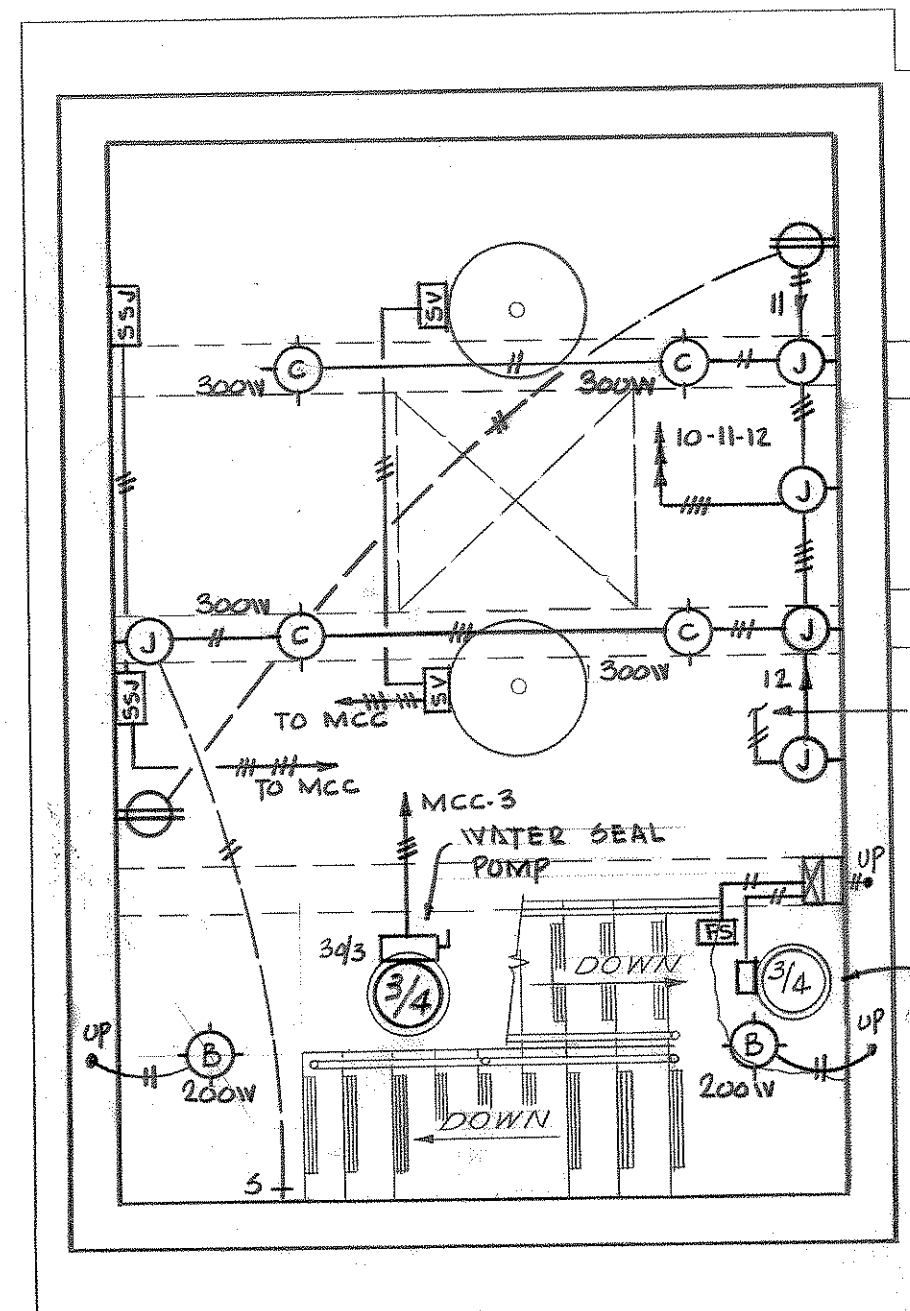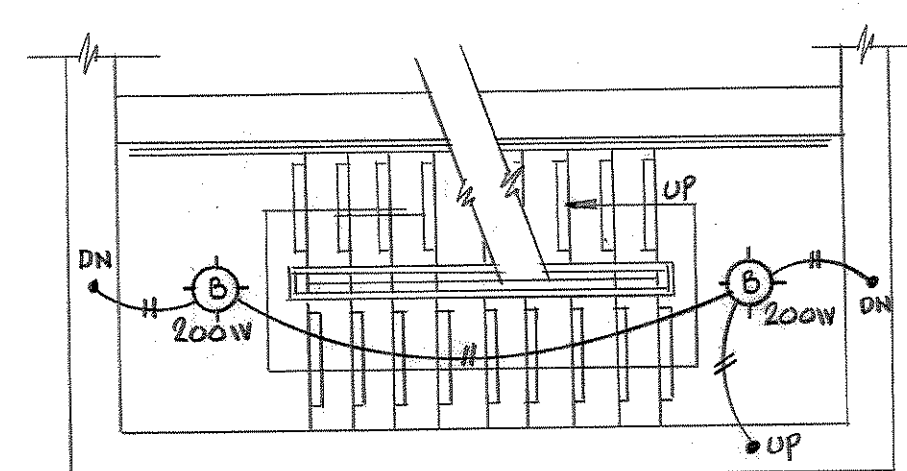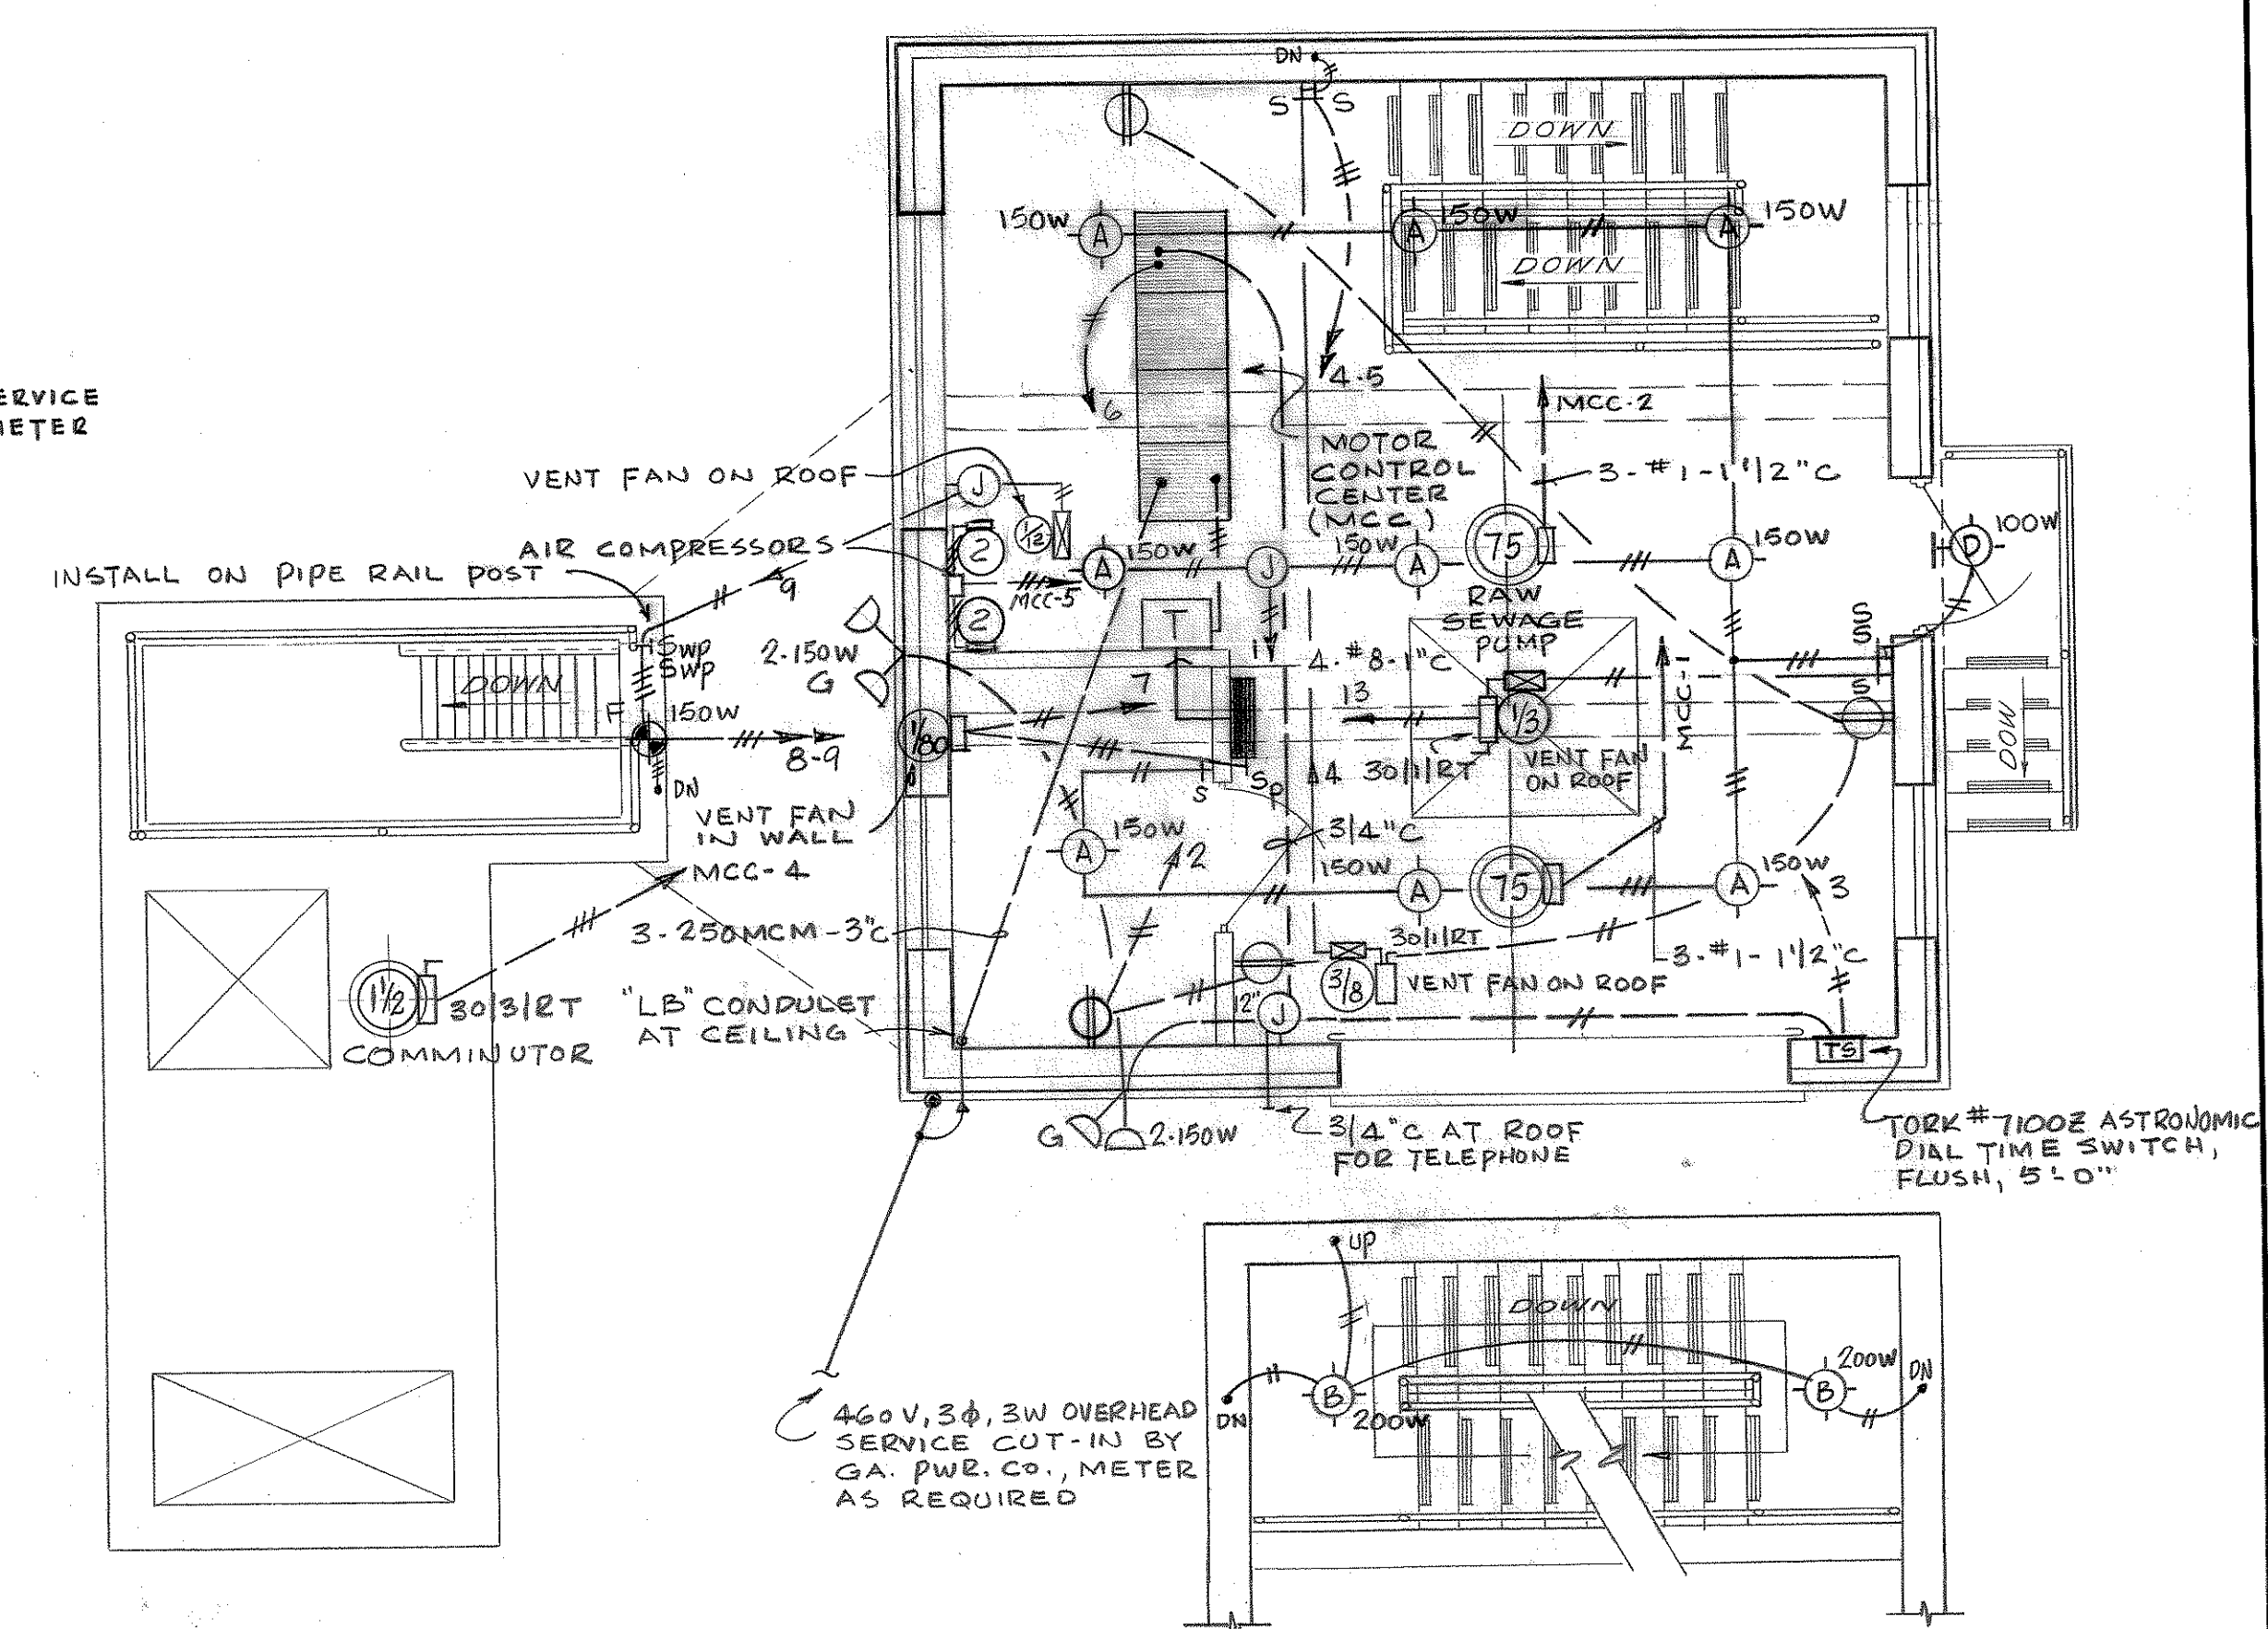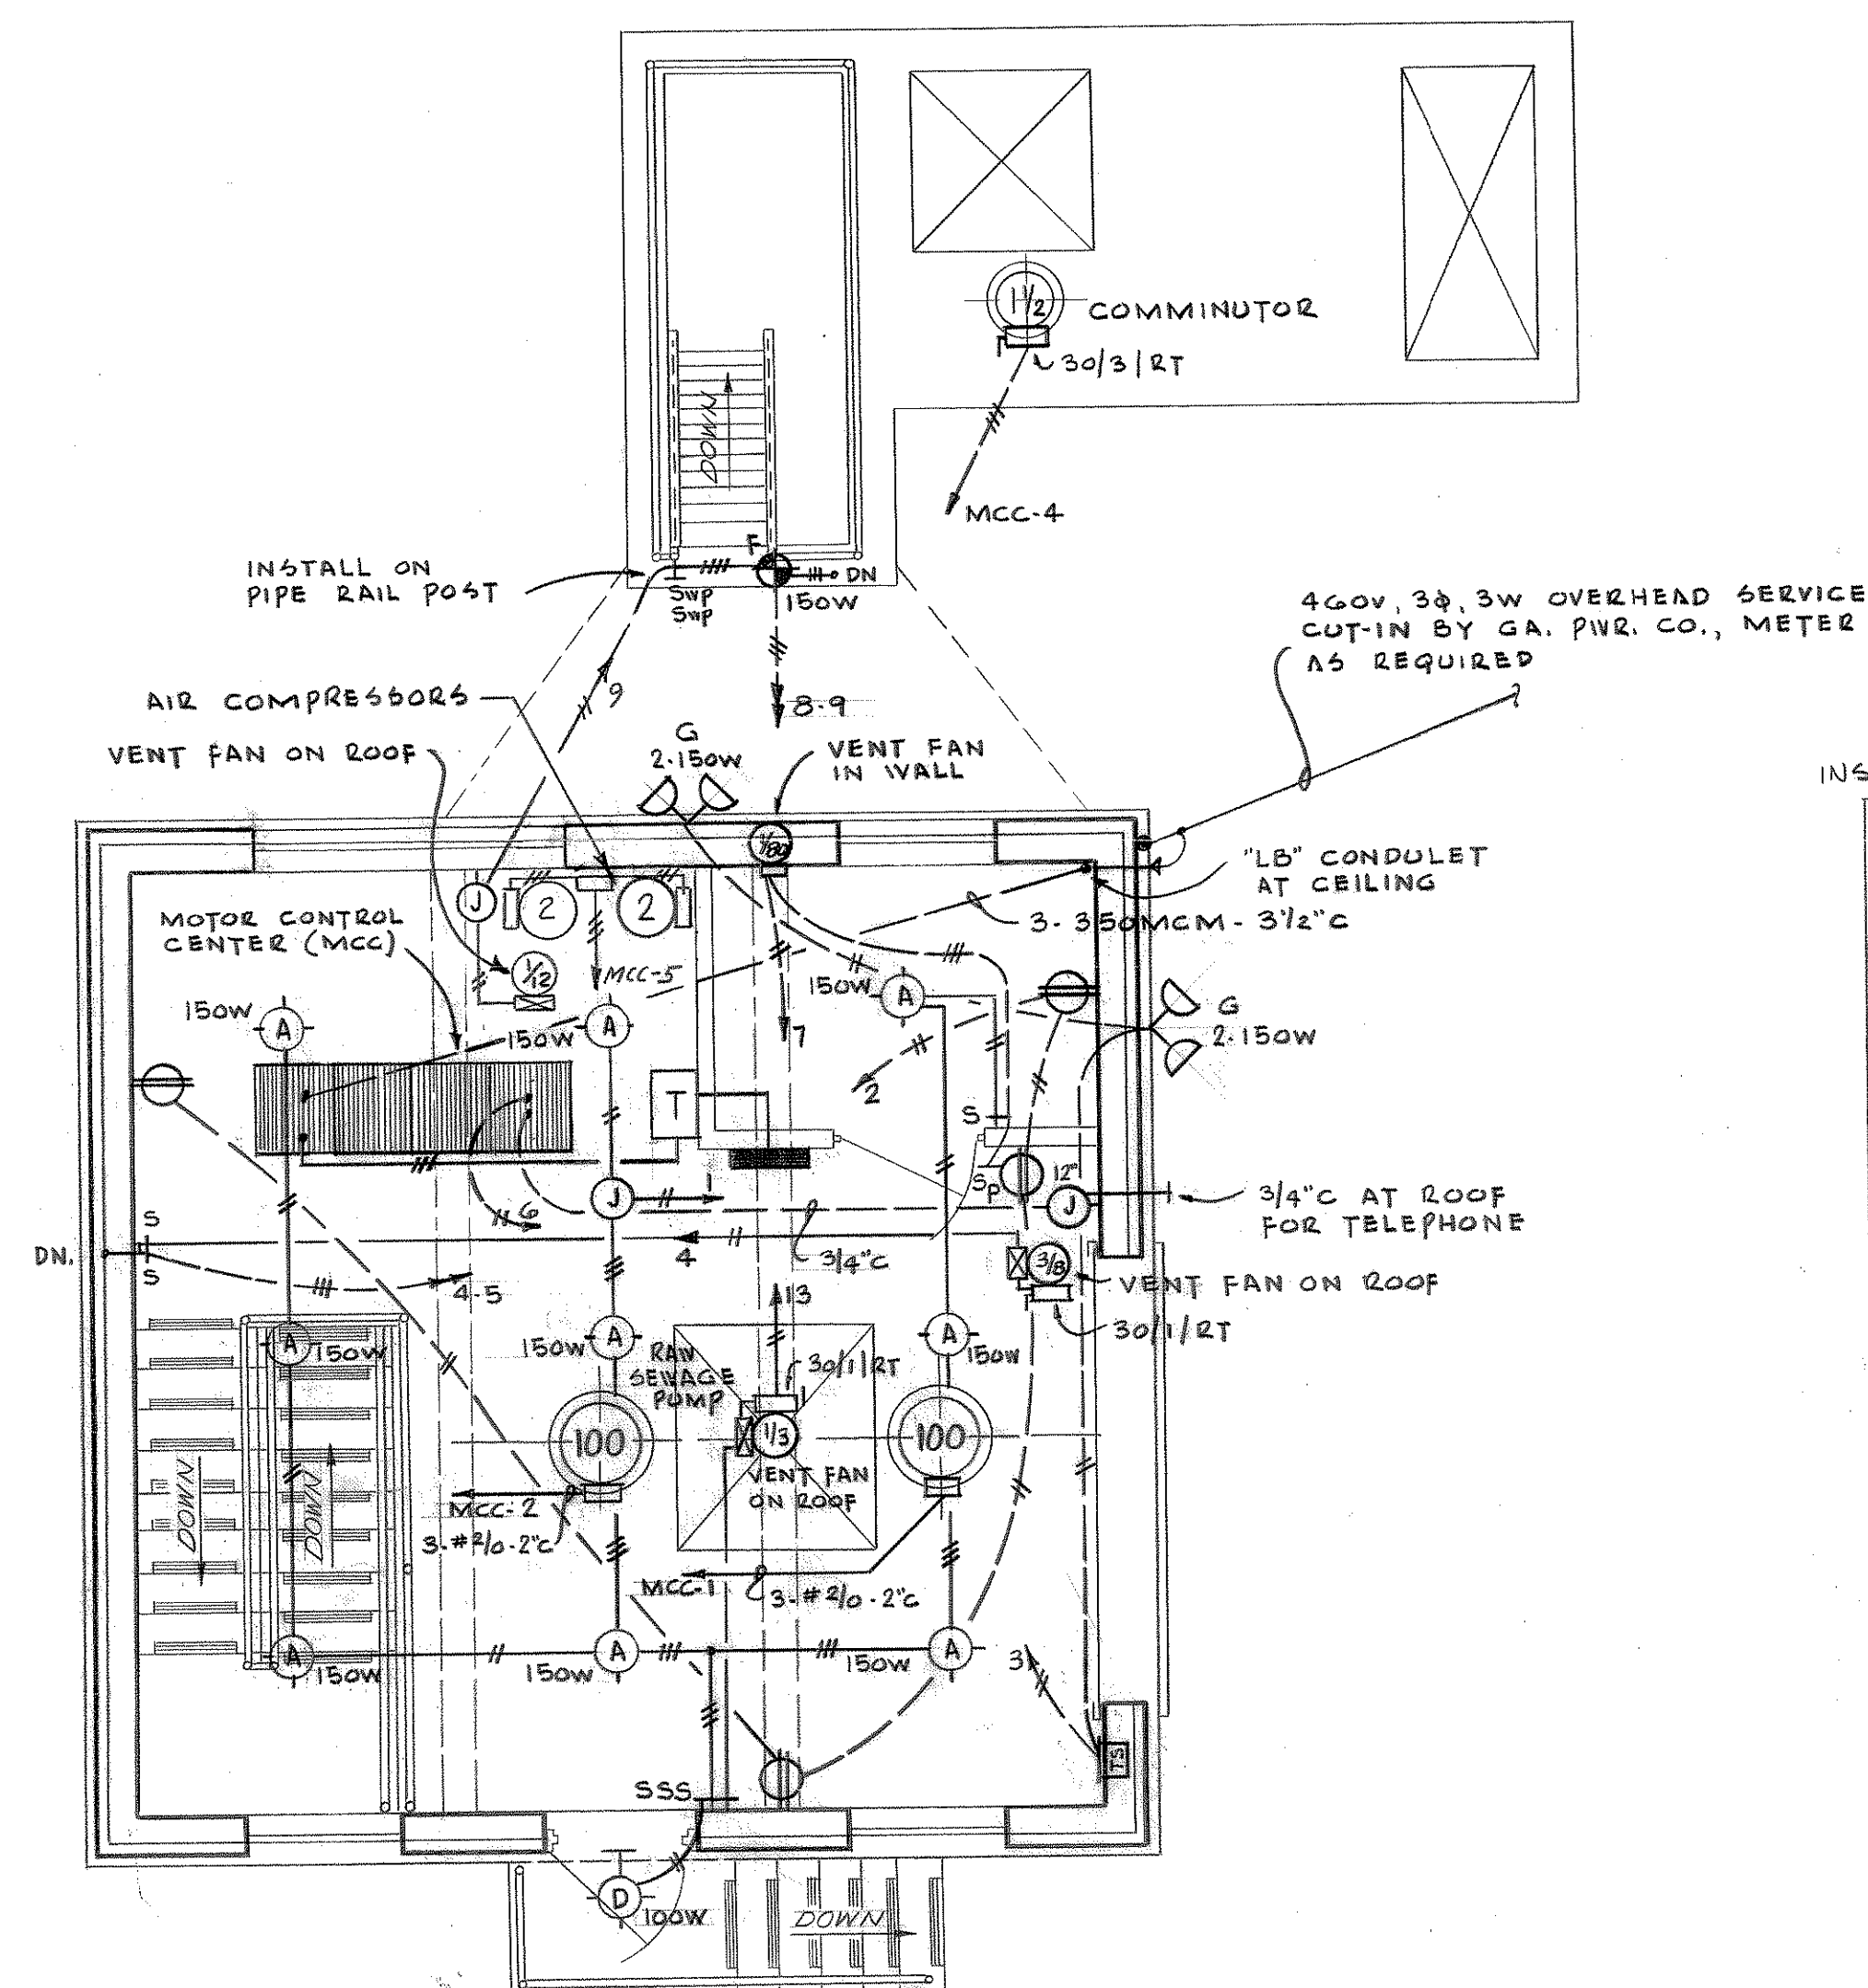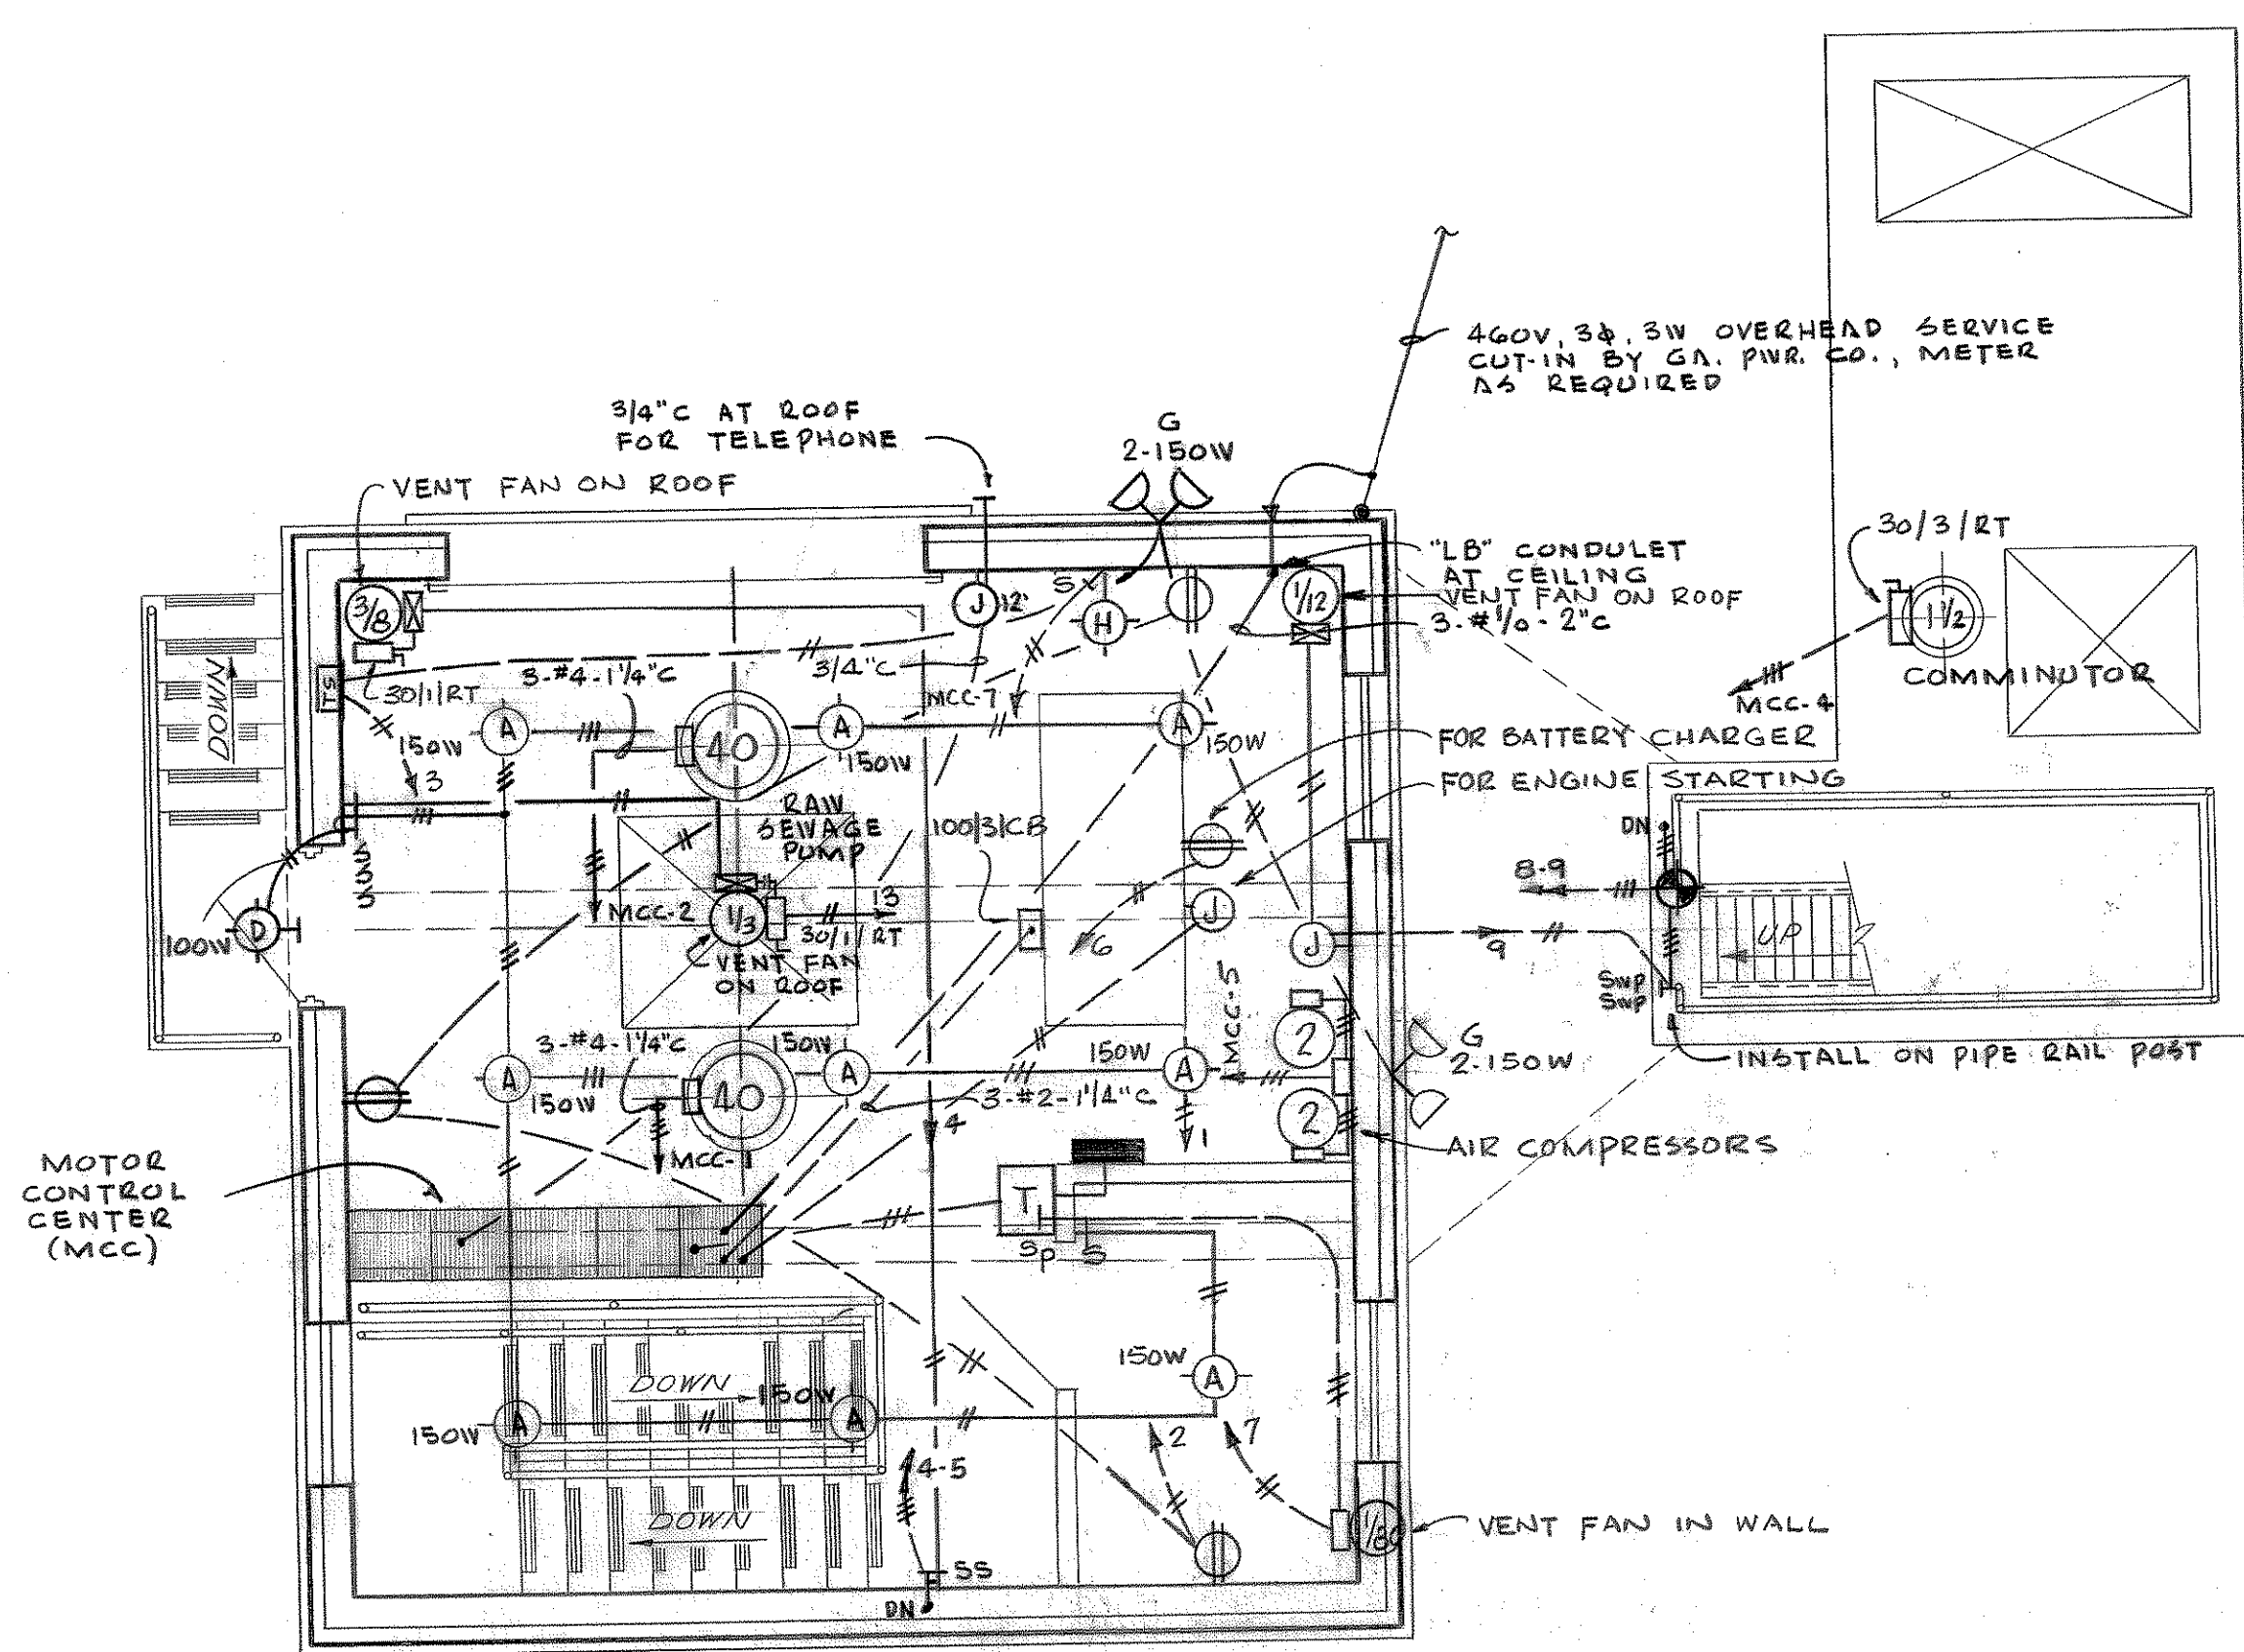

PUMPING STATION NO. 5

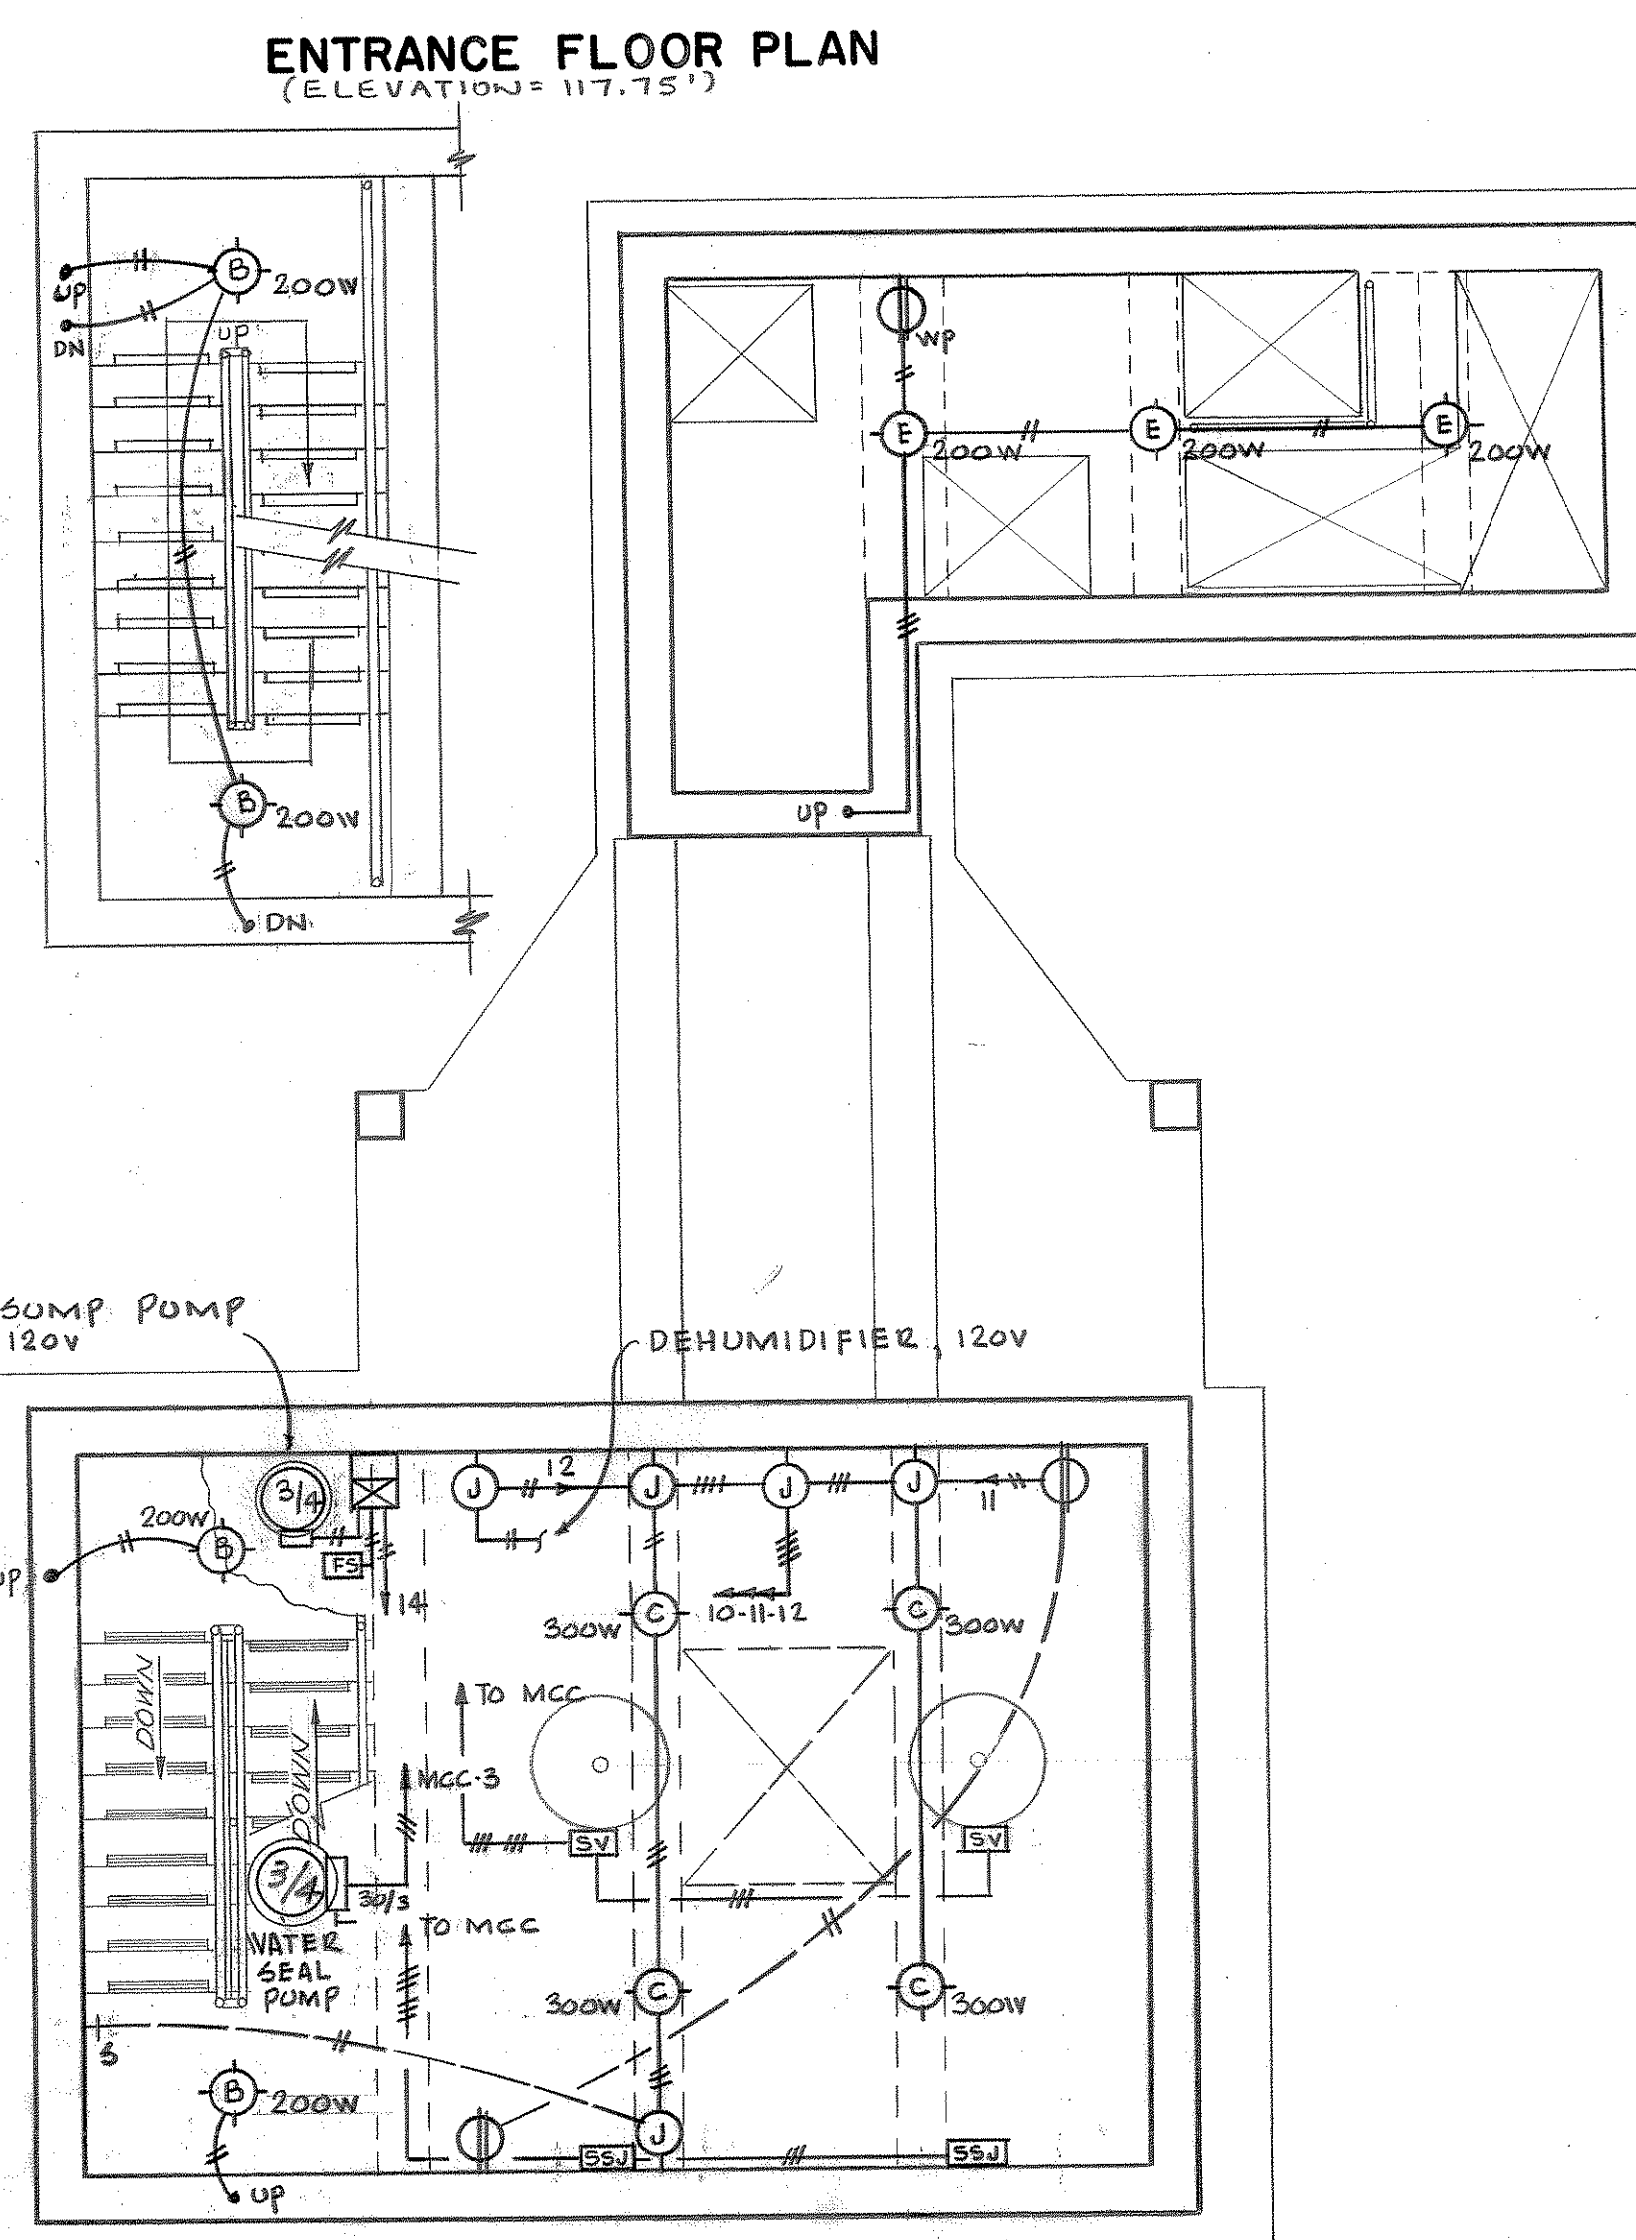

PUMPING STATION NO. 3

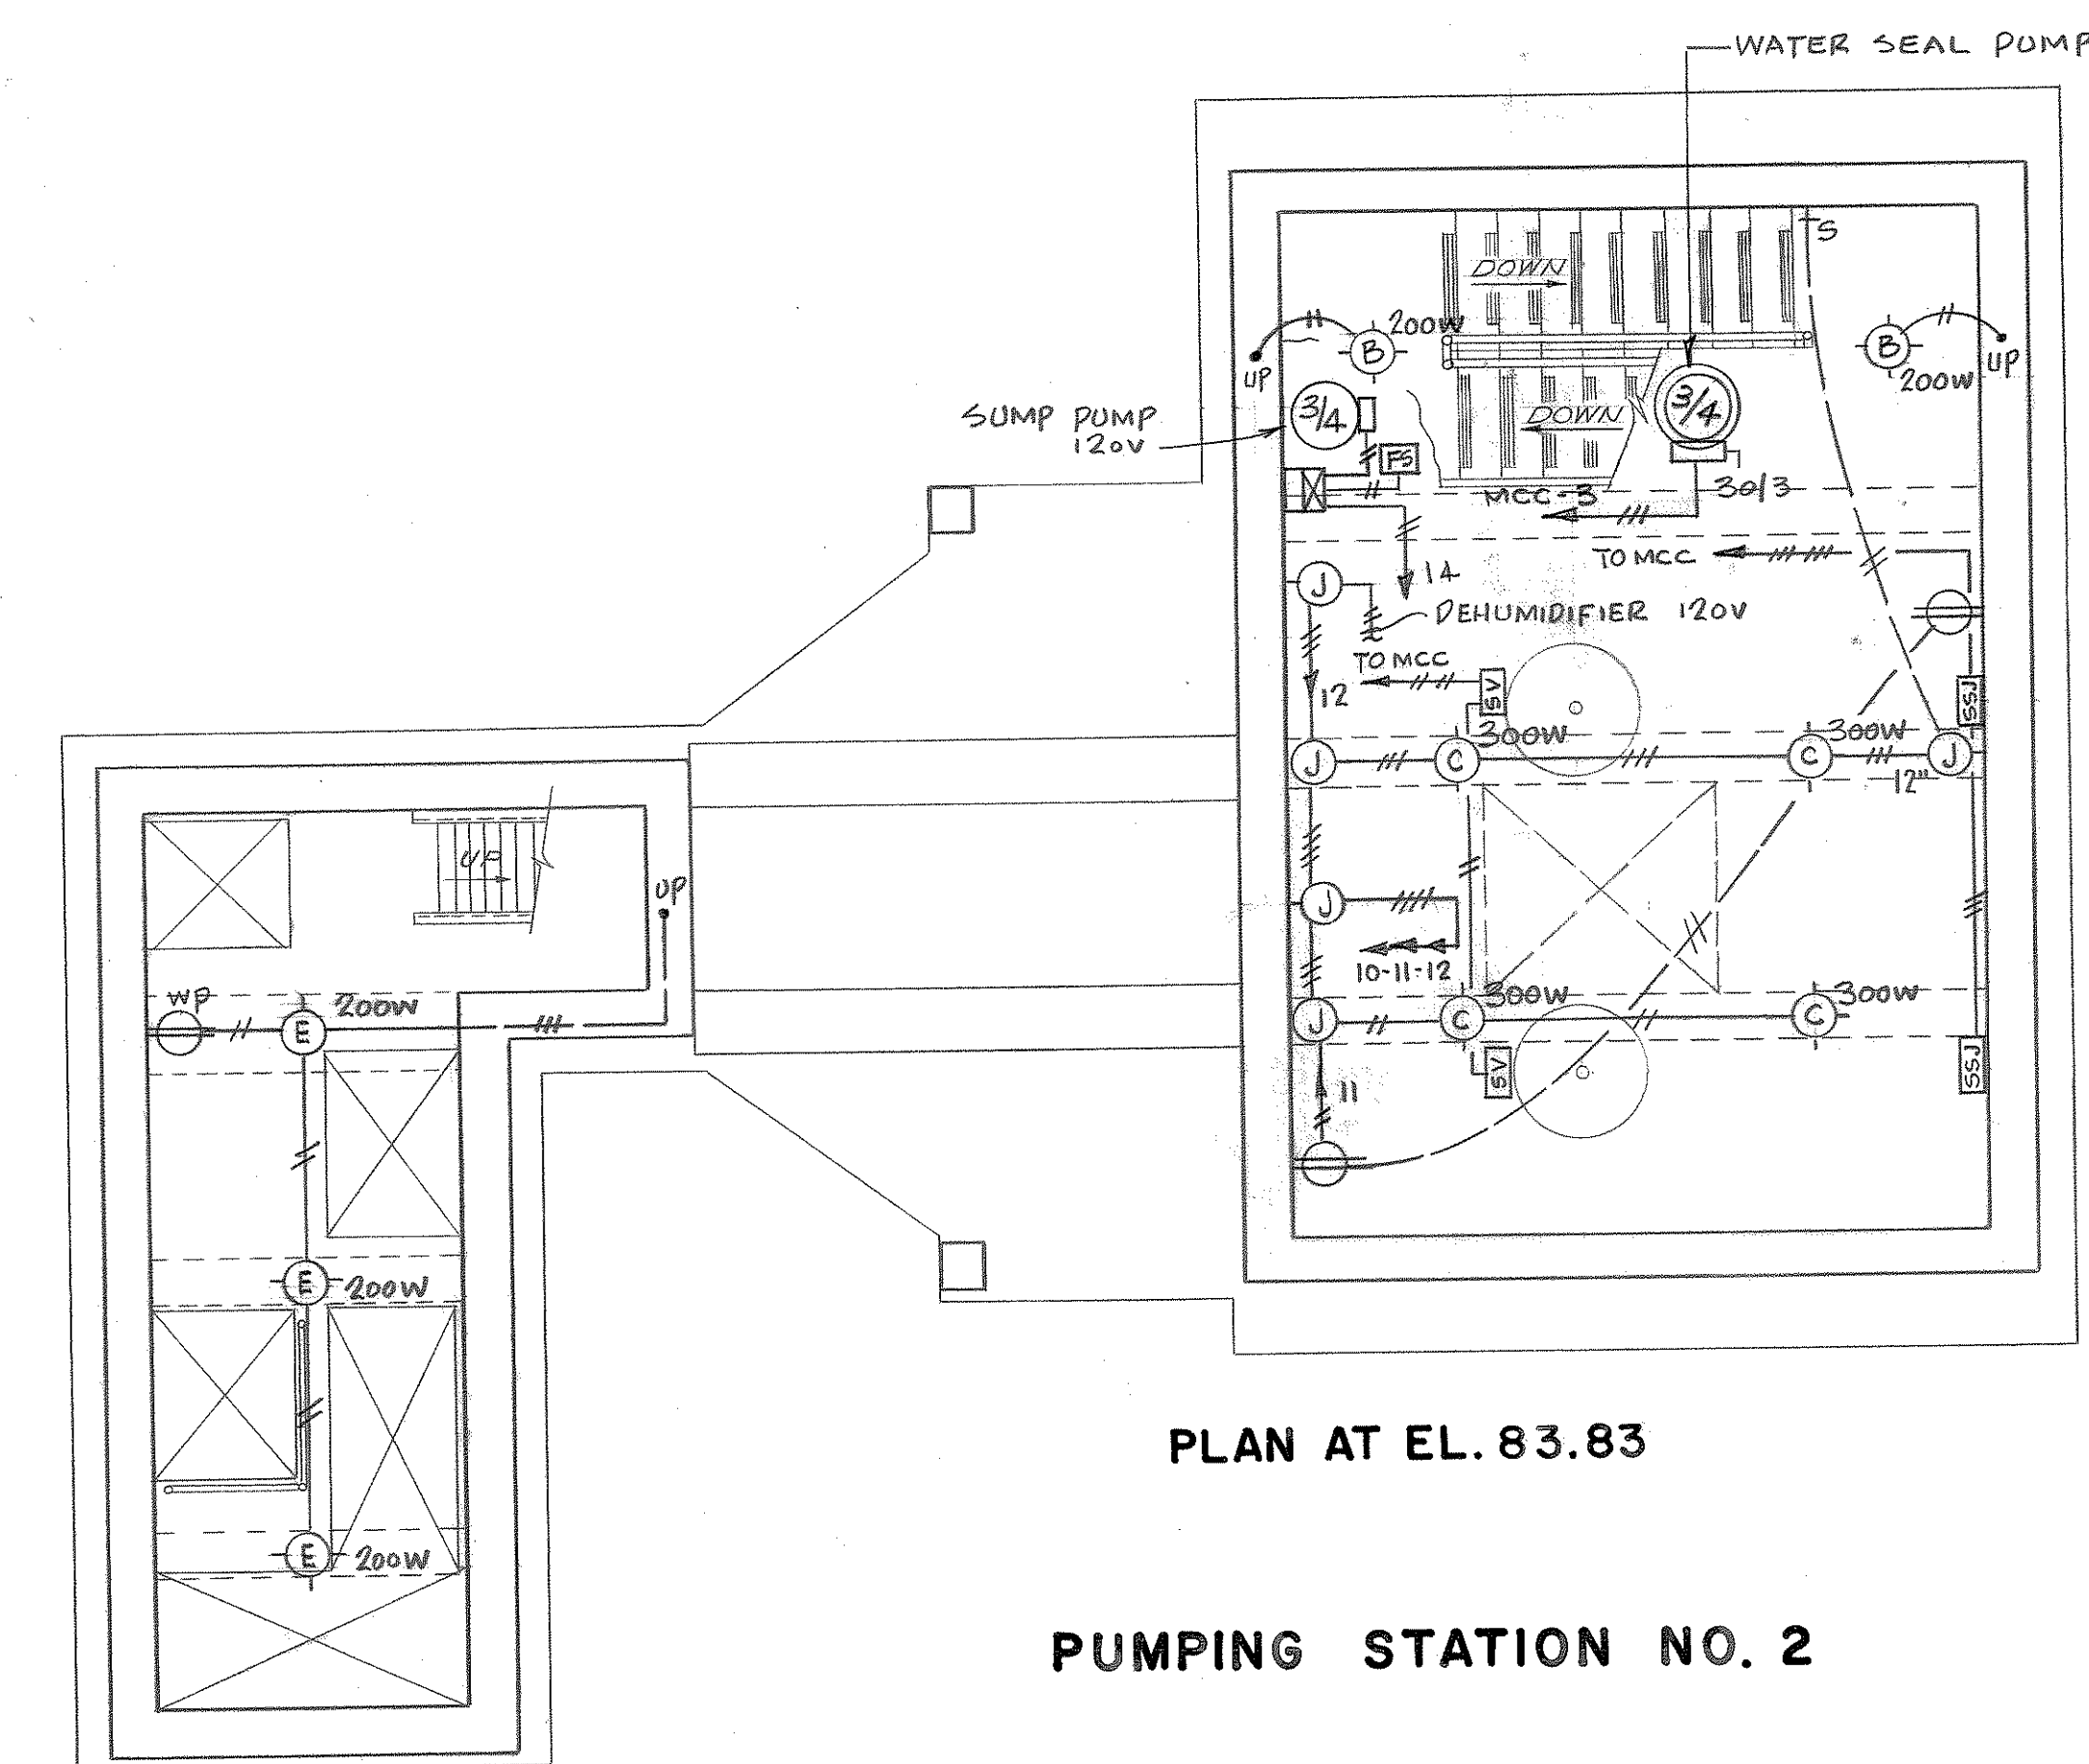

PUMPING STATION NO. 2

CONTRACT 'C'

CITY OF BRUNSWICK, GEORGIA
SEWERAGE SYSTEM IMPROVEMENTS


ELECTRICAL

DATUM EQUALS USC&GS MEAN
SEA LEVEL PLUS 100.00 FT.


SCALE
1/4"=1'-0"
DATE
JULY, 1963

WIEDEMAN AND SINGLETON
ENGINEERS
ATLANTA
GEORGIA

SHEET
14
OF 15

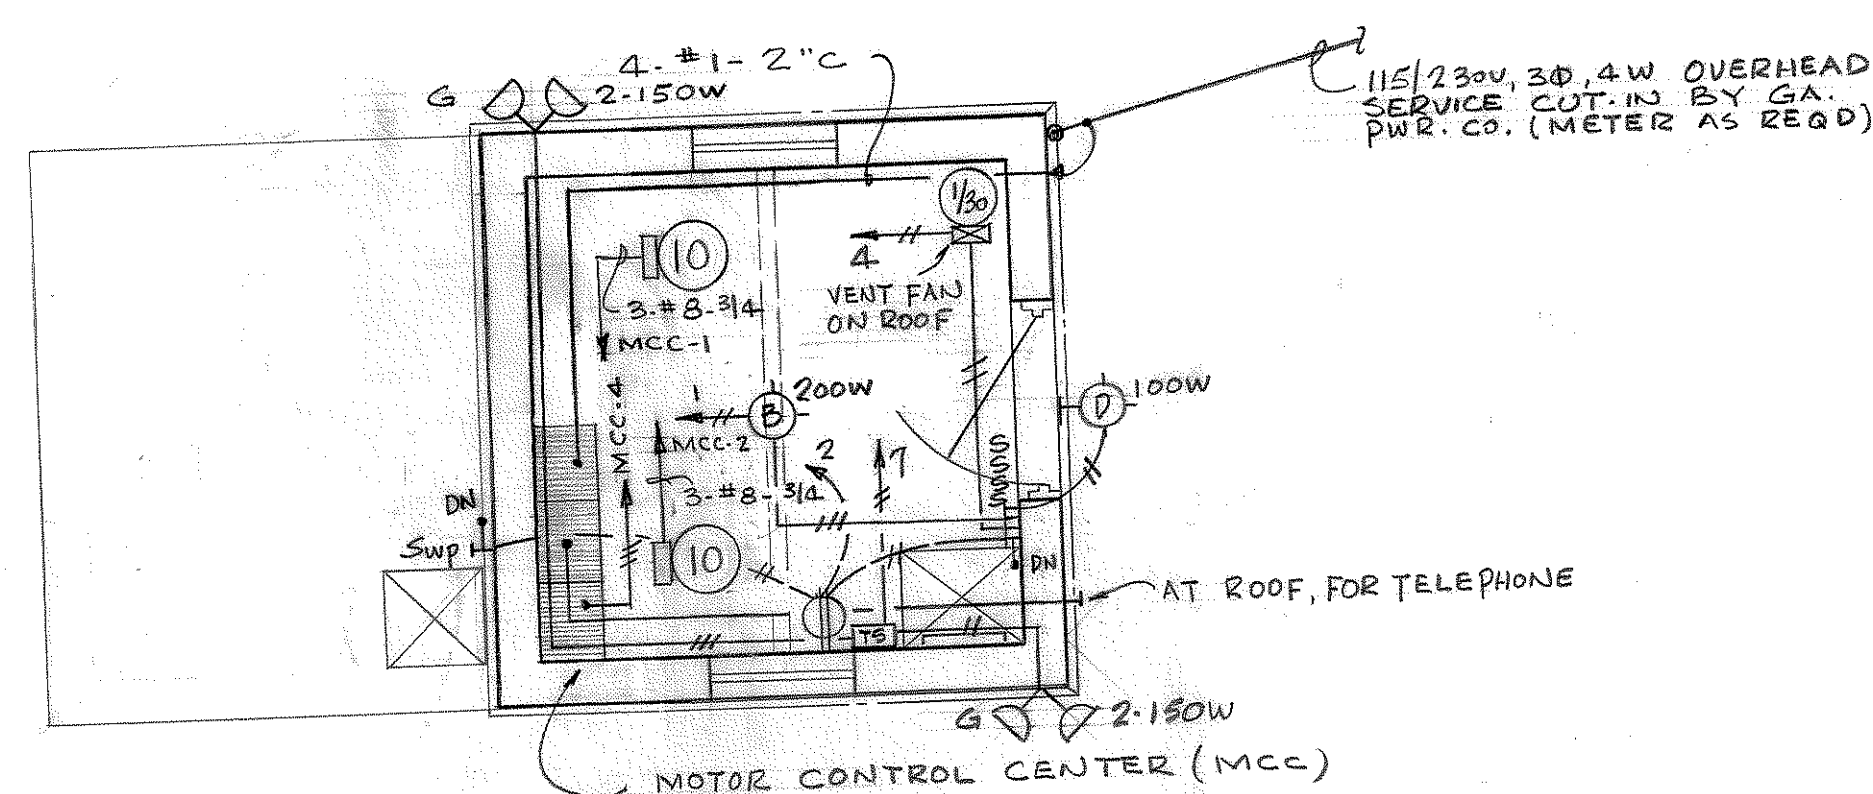


ENTRANCE FLOOR PLAN

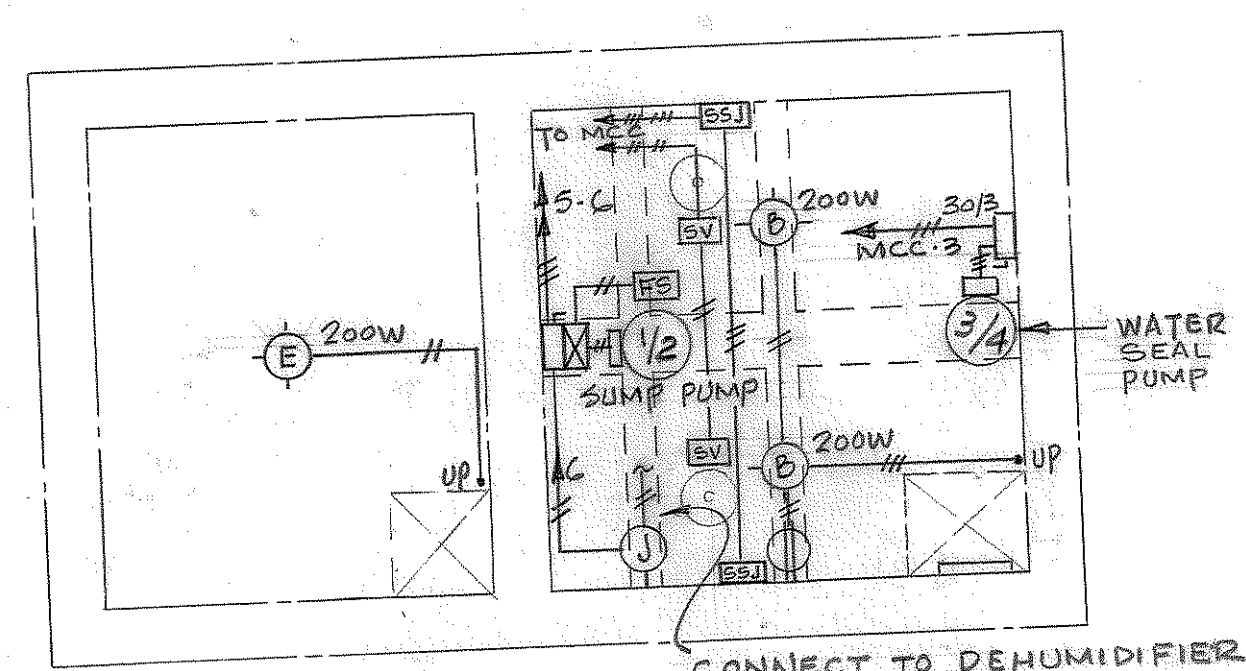

PLAN AT ELEVATION 94.42

PUMPING STATION No. 8

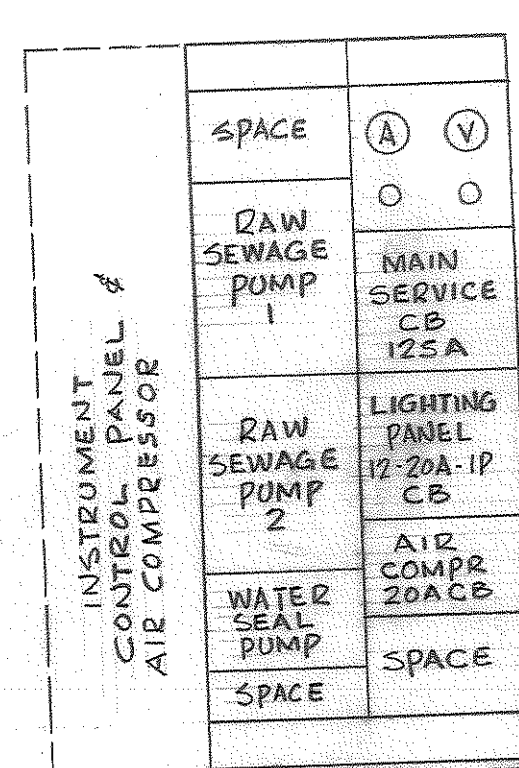

MOTOR CONTROL CENTER (PS # 8)

LIGHTING PNL. SCHED. - PUMPING STA. NO. 2, 3 & 5
120/208V, 3Ø, 4W

CIRCUIT #	VOLTS	CD AMP	DESCRIPTION
1	120	20/1	LIGHTING
2			RECEPTACLE
3			FLOODLIGHTS
4			VENT FAN
5			STAIR LIGHTING
6			CONTROL PANEL #
7			VENT FAN
8			LIGHTING & RECEPTACLES
9			VENT FAN
10			LIGHTING
11			RECEPTACLES
12			DEHUMIDIFIER
13			VENT FAN
14			SUMP PUMP (#5 OMIT)
15-18			SPARES

* BATTERY CHARGER ON STATION # 5

(A)	(V)	SPACE
MAIN CB	100A	
EMERG. TRANSFER SWITCH	100A	
LTG. PNL	20A	
PROGRAM CLOCK		
WATER SEAL PUMP		
AIR COMP. 20A		
SUMP PUMP 40A		

MOTOR CONTROL CENTER (PS # 5)

(A)	(V)	SPACE
MAIN SERVICE CB #		
RAW SEWAGE PUMP 1		
RAW SEWAGE PUMP 2		
COMMUNICATOR		
WATER SEAL PUMP		
LTG. PNL 20A		
AIR COMP. 20A		

MOTOR CONTROL CENTER (PS # 2 & 3)


* PS # 2 = 250A
PS # 3 = 300A

LIGHTING FIXTURE SCHEDULE


TYPE	DESCRIPTION
A	CURTIS-ELECTRO #25514, 150W, 2LM INDUSTRIAL PORCELAIN ENAMEL STANDARD DOME, CEILING MOUNTED ON 4" OUTLET BOX
B	CURTIS-ELECTRO #25516, 200W, 2LM INDUSTRIAL PORCELAIN ENAMEL STANDARD DOME, CEILING MOUNTED ON 4" OUTLET BOX
C	CURTIS-ELECTRO #25518, 300W, 2LM INDUSTRIAL PORCELAIN ENAMEL STANDARD DOME, CEILING MOUNTED ON 4" OUTLET BOX
D	McPHILBEN #43-44VT, 100W, VAPORTIGHT WALL BRACKET WITH CAST GUARD, INSTALL OVER DOOR
E	CROUSE-HINDS #A8B32, 200W, VAPORTIGHT, CEILING MOUNTED WITH OPAL GLOBE AND GUARD
F	HOLOPHANE #04345, 150W, POST TOP LUMINAIRES WITH HOOD & GUARD. INSTALL ON TOP OF 1"Ø, 7'0" HIGH ALUMINUM PIPE 6ET 3'0" DEEP IN CONCRETE (10'0" TOTAL PIPE LENGTH). INSTALL OUTLET AT BASE AND DRIVE POLE FOR CORRECTION AS REQUIRED.
G	STONCO #40103-L, 2-150W PAR 38 FL LAMPS, 2 LIGHT CLUSTER, WALL MOUNTED 1'0" BELOW ROOF, DIRECT TO ILLUMINATE AREA AT BUILDING, EACH LAMP WITH #201 WIRE GUARD.
H	PRESCOLITE #WEG-24, 100W, WALL MOUNTED 7'0" ABOVE FLOOR, WITH BUILT-IN GROUNDED RECEPTACLE, CONNECT TO 120V EMERGENCY SUPPLY.

ELECTRICAL SYMBOLS

- - INCANDESCENT FIXTURE & OUTLET CEILING OR PENDANT MOUNTED, TYPE AS INDICATED
- ⊕ - DUPLEX RECEPTACLE FLUSH IN WALL, 48", HUBBELL #5252
- ⊕ - WEATHERPROOF DUPLEX RECEPTACLE, 2'0", HUBBELL #5214
- - BRANCH CIRCUIT HOMERUN TO PANEL
- - METALLIC RACEWAY CONCEALED IN CEILING OR WALL
- - METALLIC RACEWAY CONCEALED IN FLOOR OR WALL, OR UNDERGROUND IF OUTSIDE
- - METALLIC RACEWAY EXPOSED ON CEILING OR WALL
- - LIGHTING PANEL, SEE SCHEDULE
- - NON-FUSED DISCONNECT SWITCH, SIZE AS INDICATED
- - COMBINATION MOTOR STARTER
- ⊙ - MOTOR, SIZE AS INDICATED (3 HP) WITH WIRE TERMINATION POINT
- S - SINGLE POLE SWITCH
- SS - THREE WAY SWITCH
- ⊙ - OUTLET BOX USED AS JUNCTION BOX (FLUSH OR SURFACE AS REQUIRED)
- SV - SOLENOID VALVE
- SSV - "SAFE STOP-JOG" MOTOR CONTROL SWITCH
- FS - FLOAT SWITCH
- RT - DENOTES RAINTIGHT
- WP - DENOTES WEATHERPROOF
- D - FLOODLIGHT FIXTURE ON BUILDING
- ⊕ - INCANDESCENT POSTLIGHT FIXTURE & OUTLET
- Swp - SINGLE POLE WEATHERPROOF SWITCH, HUBBELL #1781
- ⊕ - DRY-TYPE TRANSFORMER, WALL OR FLOOR MOUNTED, SIZE & CHARACTERISTICS AS INDICATED, WESTINGHOUSE OR EQUAL
- TS - TIME SWITCH FLUSH IN WALL, 5'0", TORC #7100E, ASTRONOMIC, "ON" SUNSET, "OFF" 12:00 MIDNIGHT

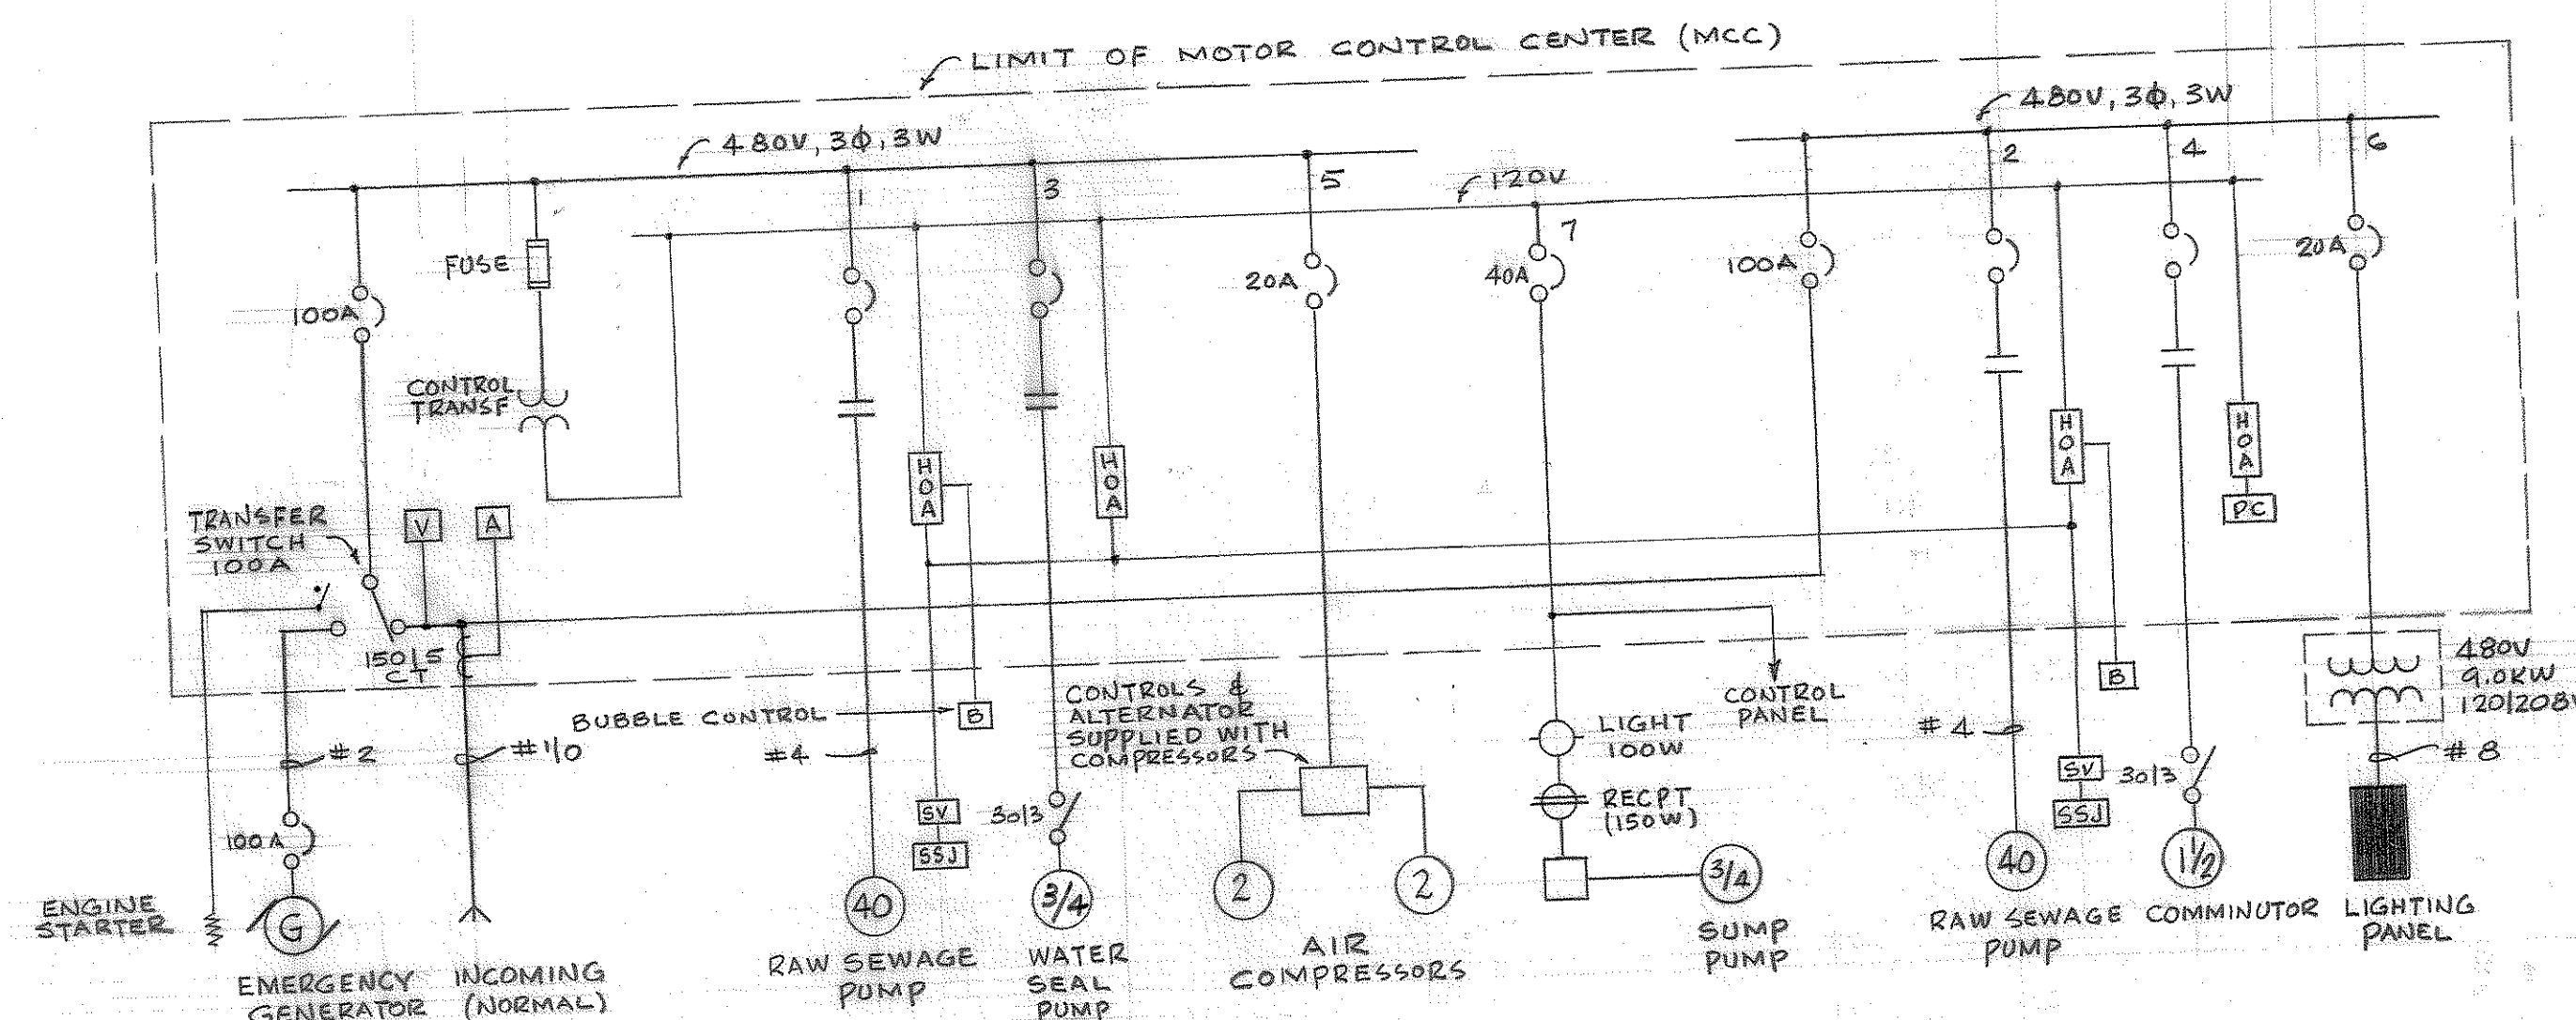


SINGLE LINE DIAGRAM (PS # 5)

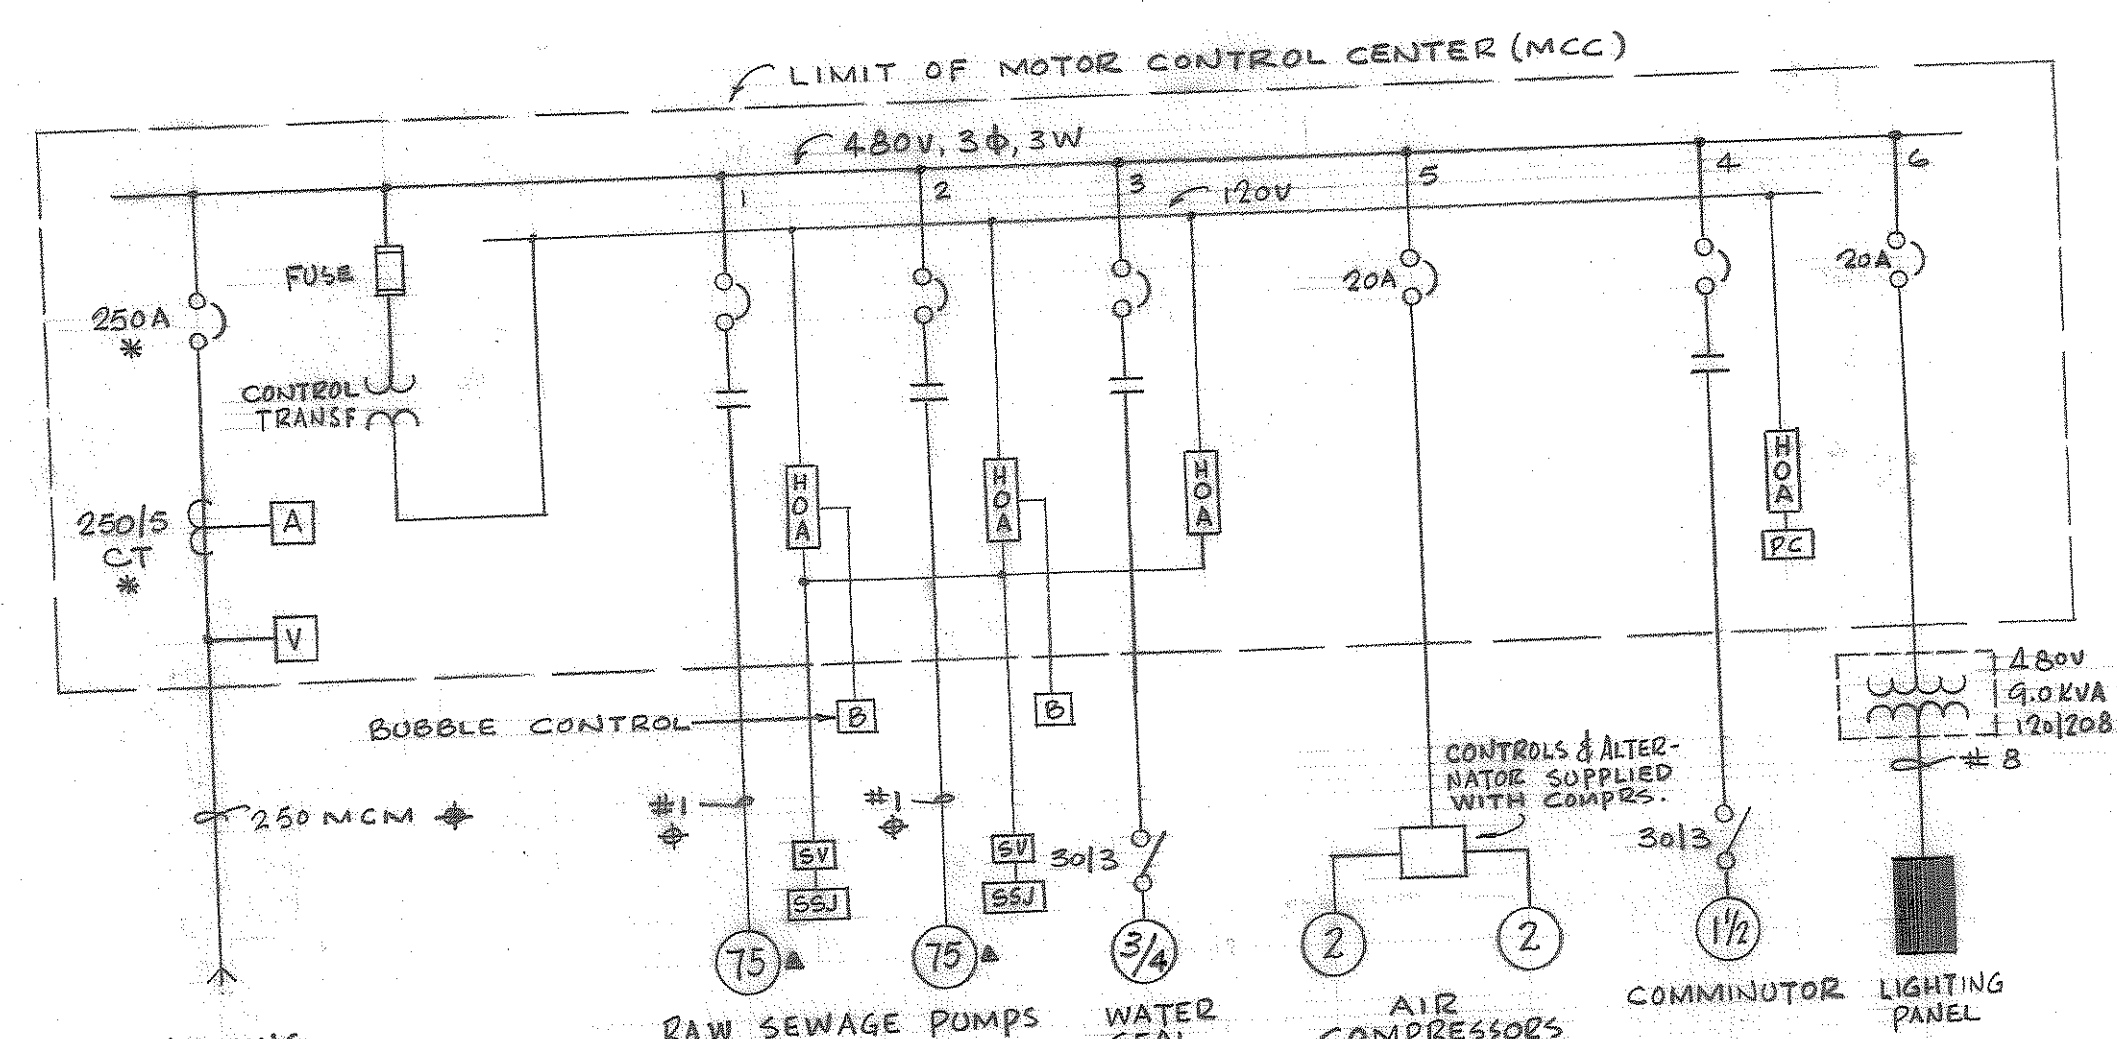

SINGLE LINE DIAGRAM (PS # 2)

PS # 3 SIMILAR EXCEPT AS FOLLOWS:
* - 300 AMPERE
* - 350 MCM
* - 100 HP
* - #2/0

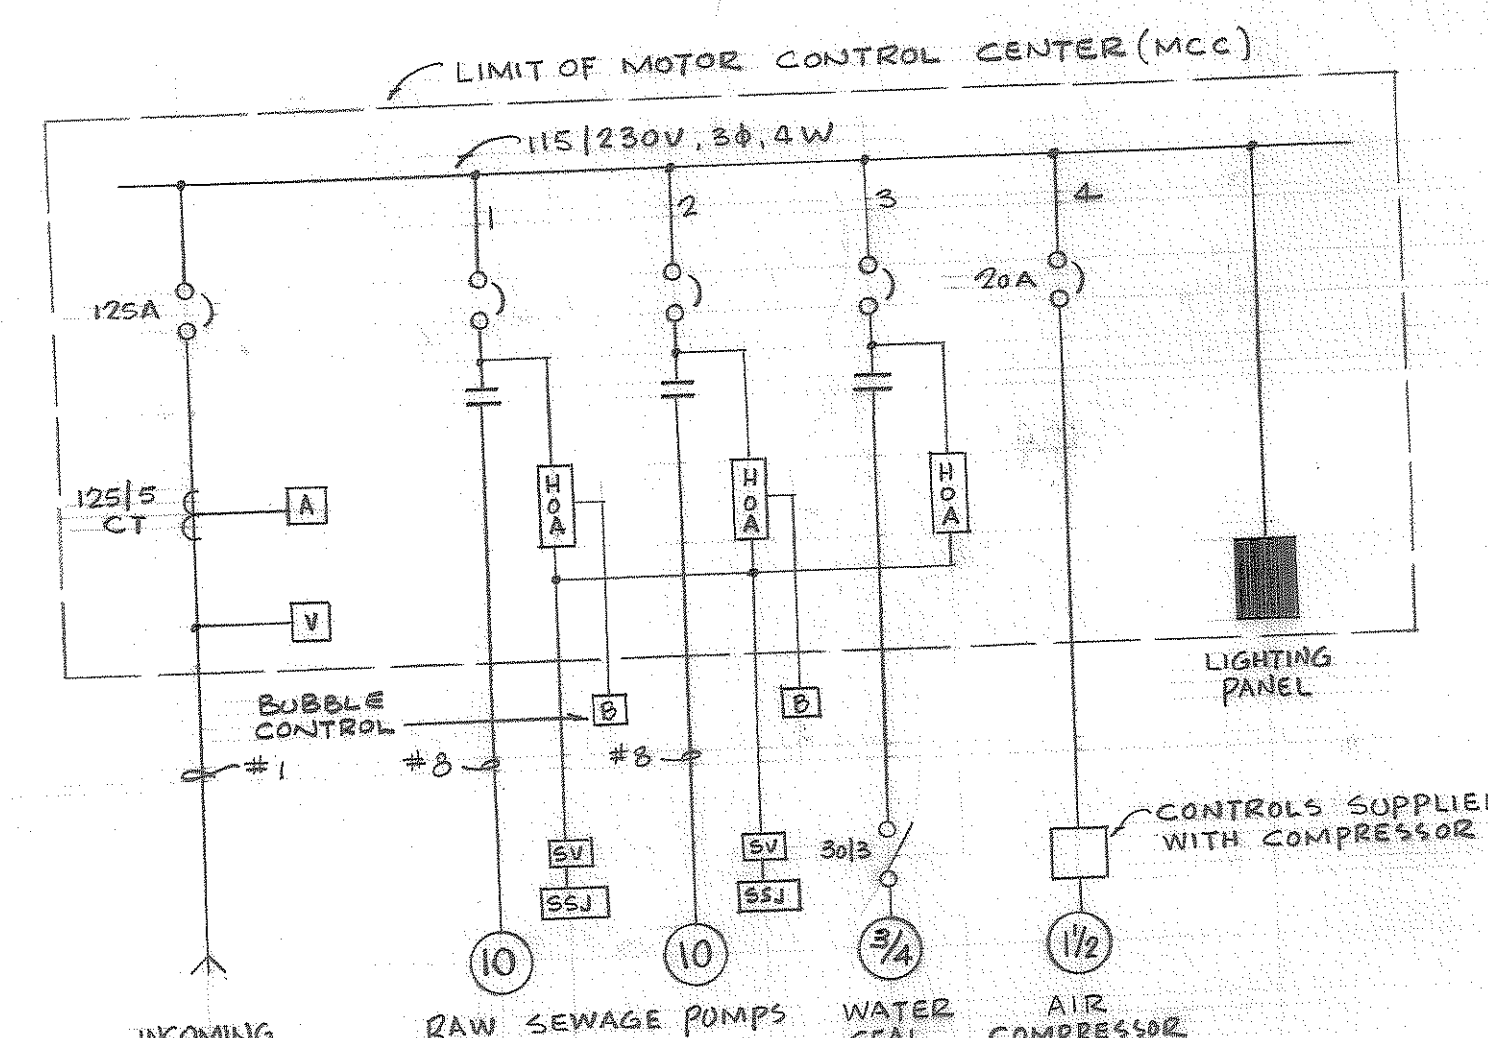

SINGLE LINE DIAGRAM (PS # 8)

LIGHTING PANEL SCHED. - PUMP STA. NO. 8
115/230V, 1Ø, 3W

CIRCUIT #	VOLTS	CD AMP	DESCRIPTION
1	115	20/1	LIGHTING
2			RECEPTACLES
3			SPARE
4			VENT FAN
5			SUMP PUMP
6			DEHUMIDIFIER
7			FLOODLIGHTS
8			CONTROL PANEL
9-12			SPARES

CONTRACT 'C'

CITY OF BRUNSWICK, GEORGIA
SEWERAGE SYSTEM IMPROVEMENTS

ELECTRICAL

DATUM EQUALS USC&GS MEAN
SEA LEVEL PLUS 100.00 FT.

SCALE 1/4"=1'-0"
DATE JULY 1963
WIEDEMAN AND SINGLETON
ENGINEERS
ATLANTA
GEORGIA
SHEET 15 OF 15