




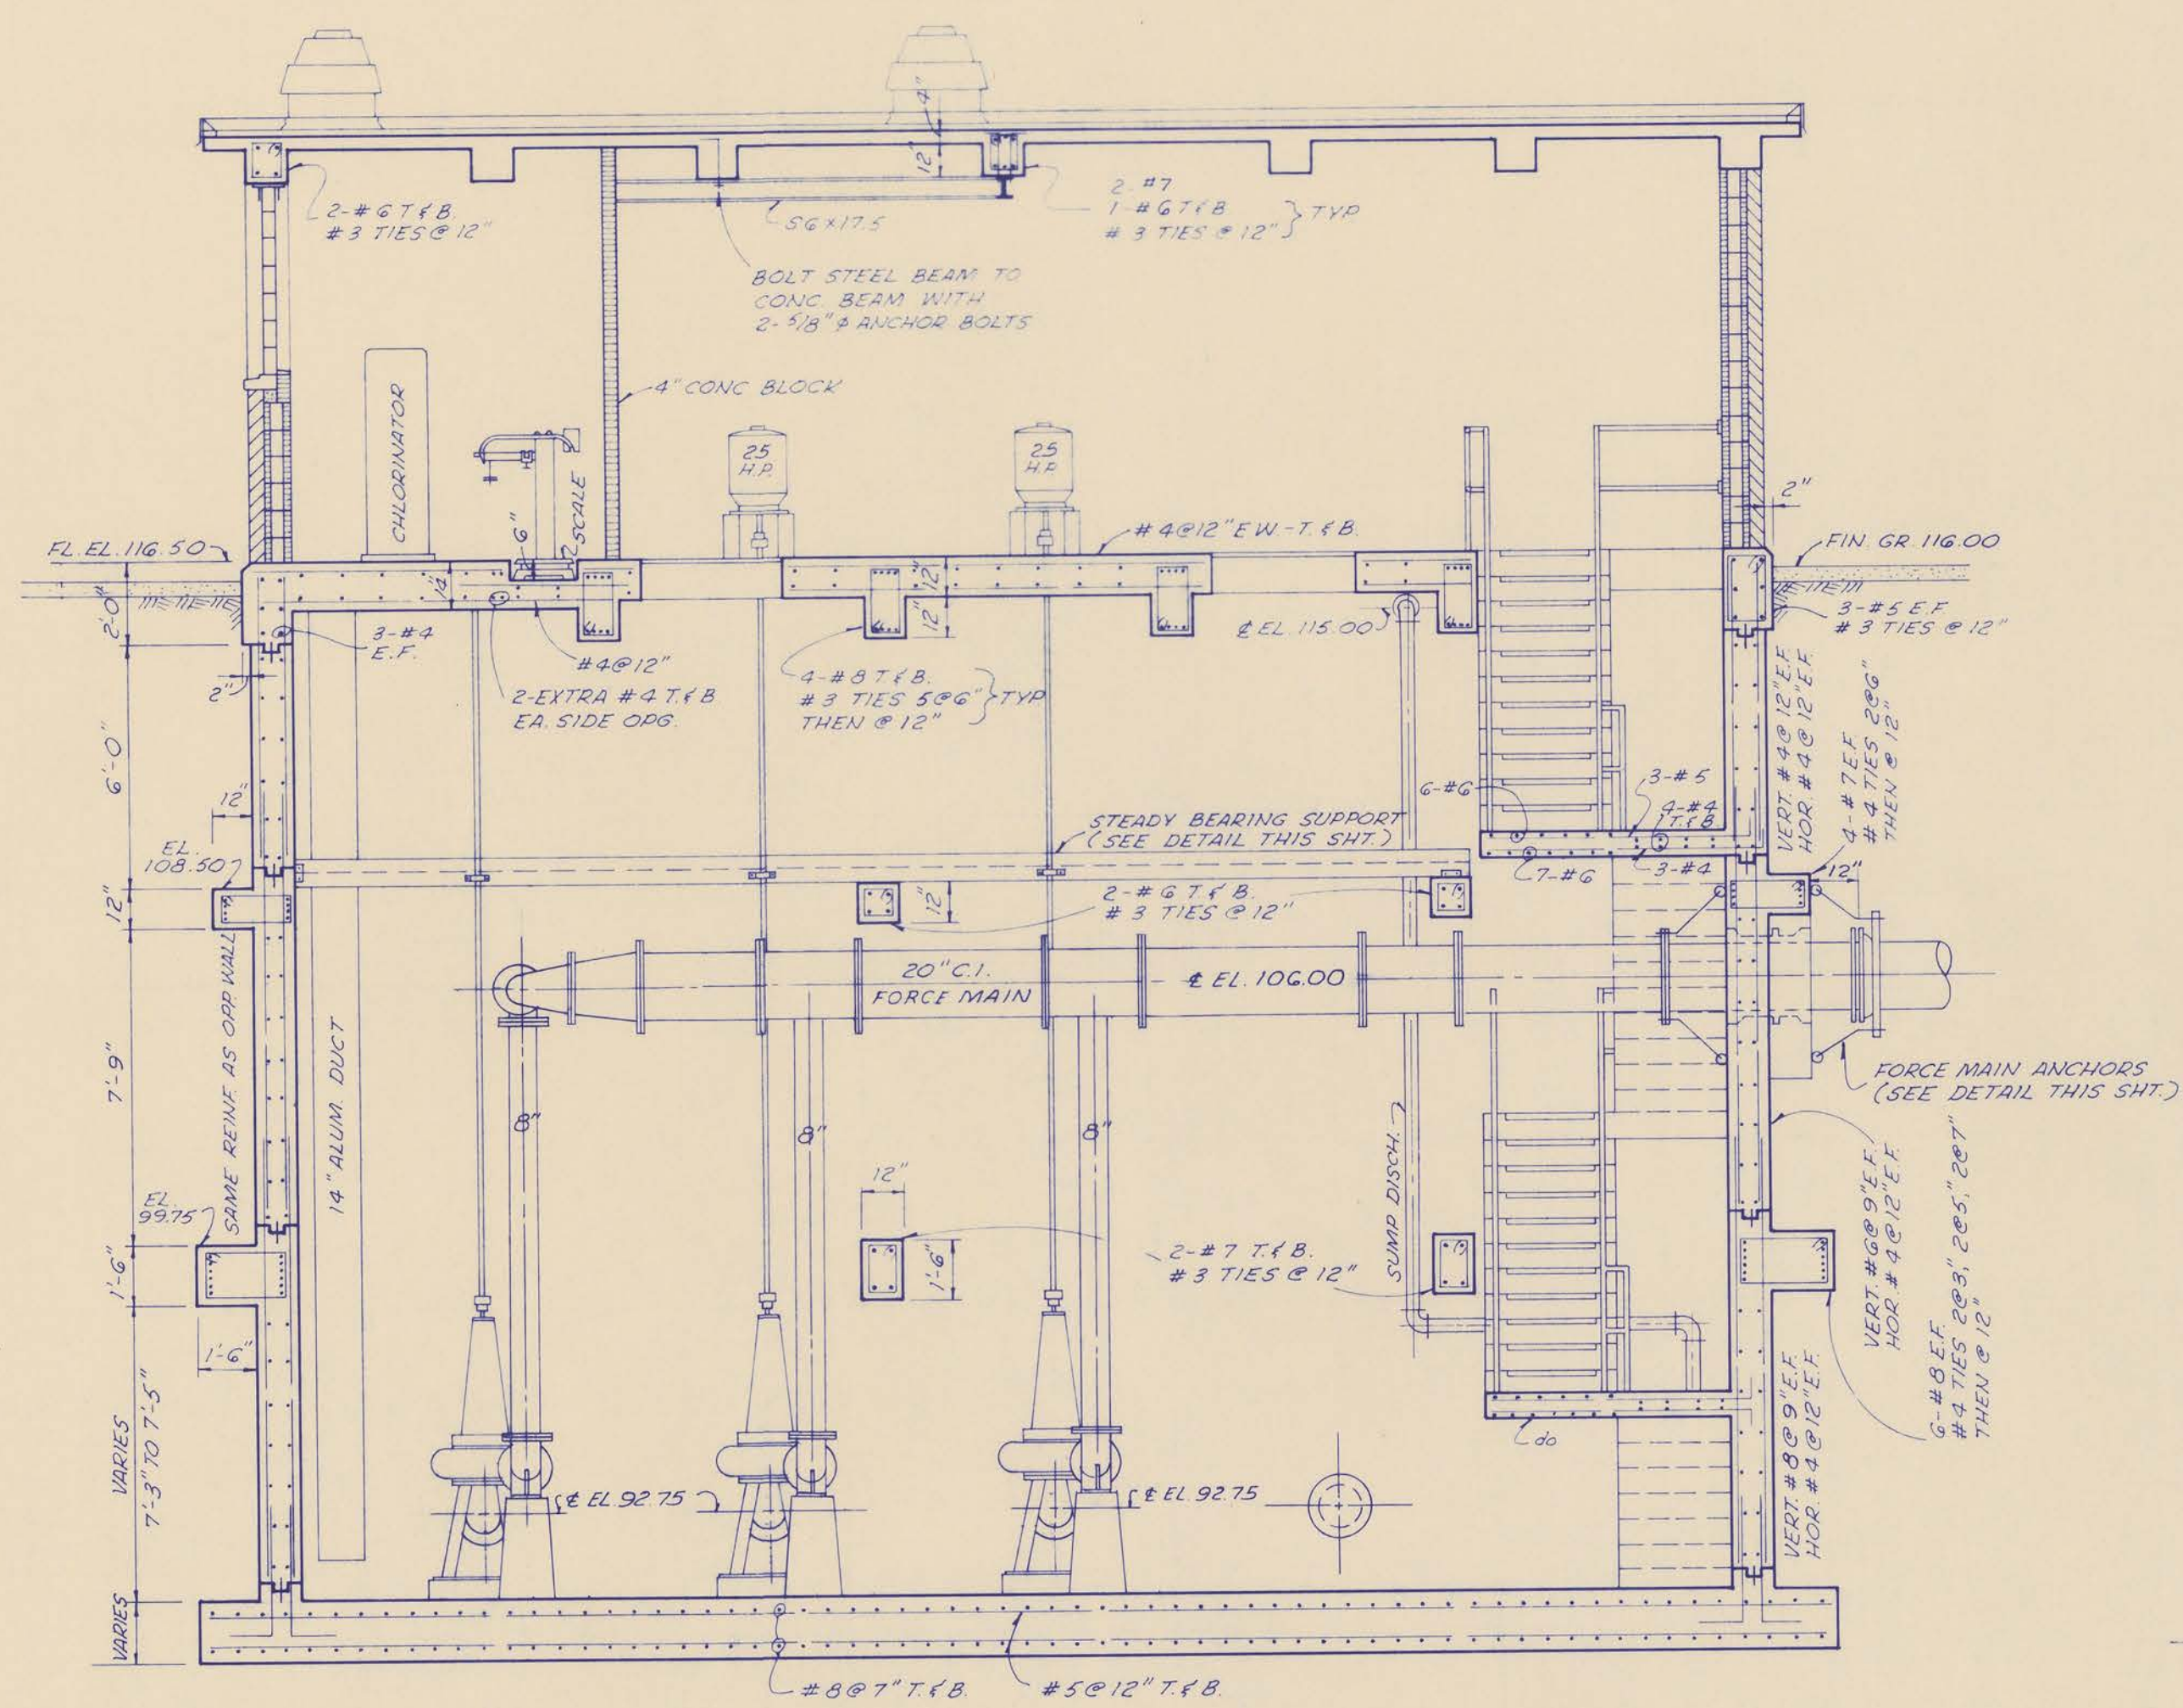


SECTION A-A  
1/4"=1'-0"

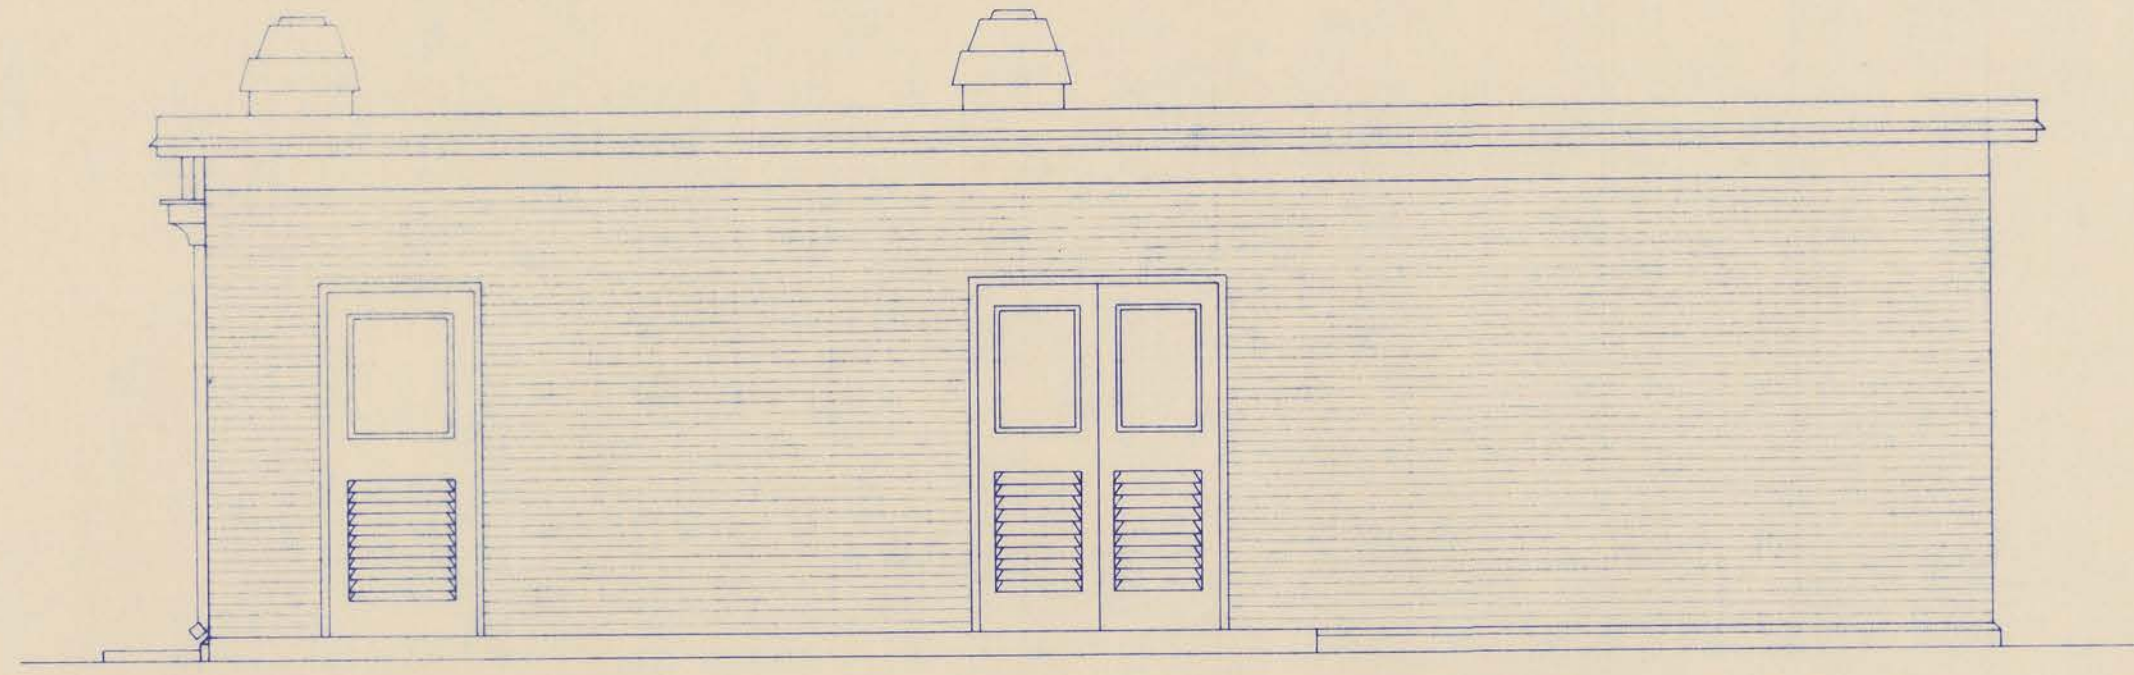


FRONT ELEVATION  
1/4"=1'-0"

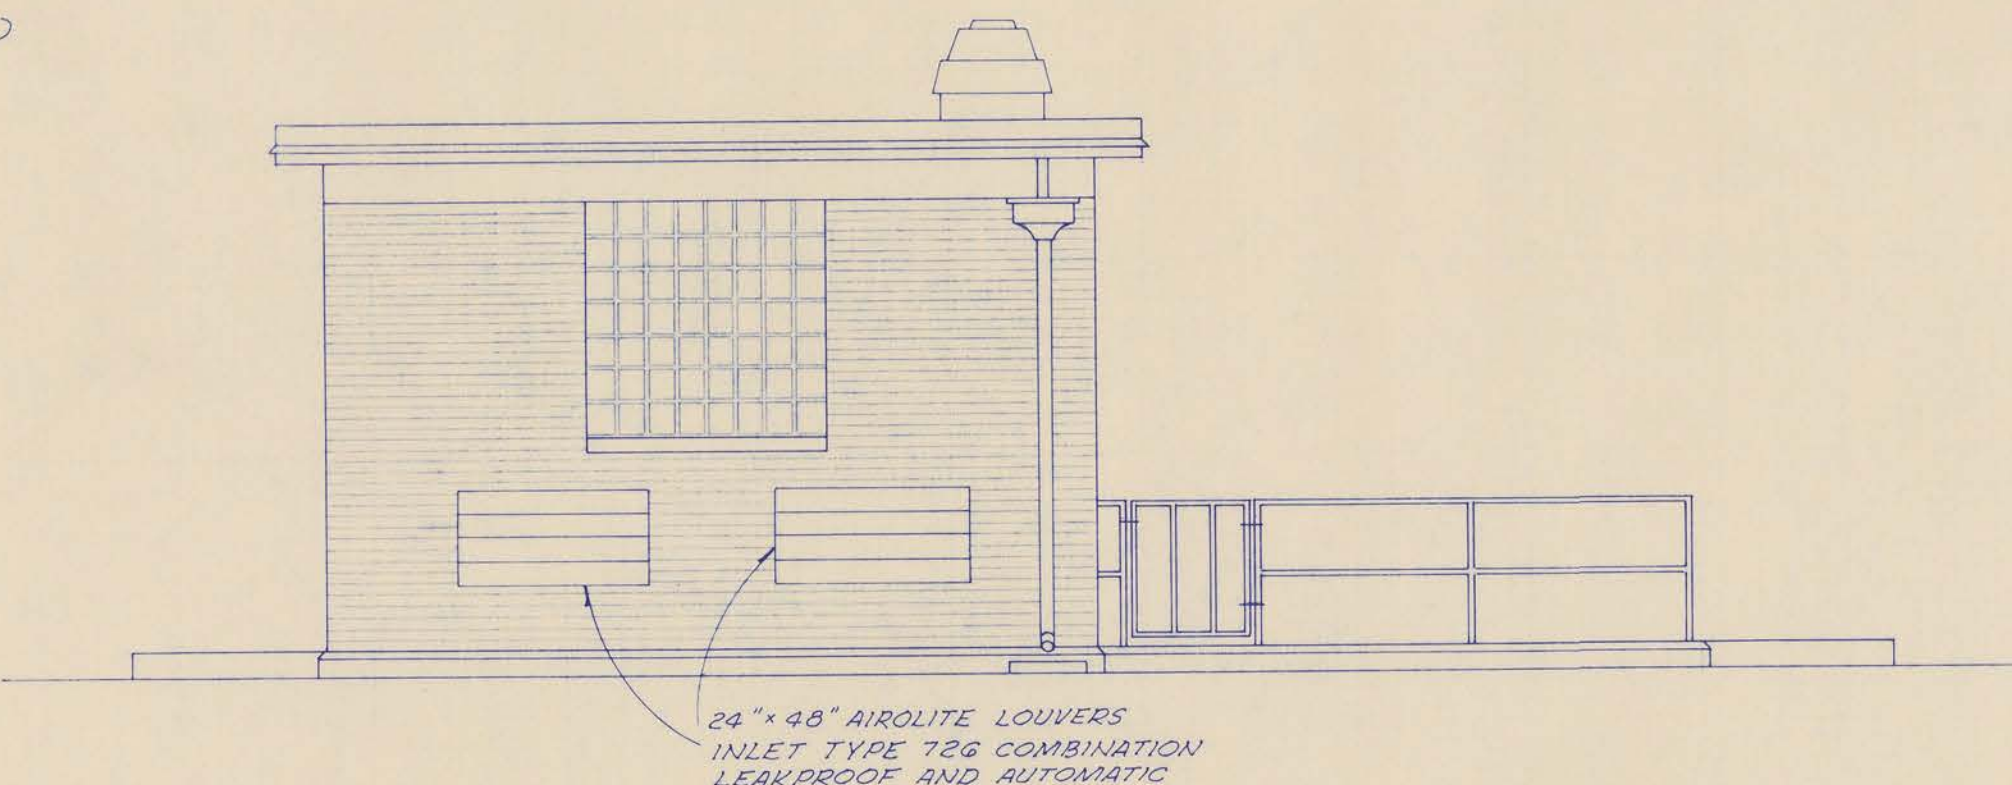


RIGHT SIDE ELEVATION  
1/4"=1'-0"

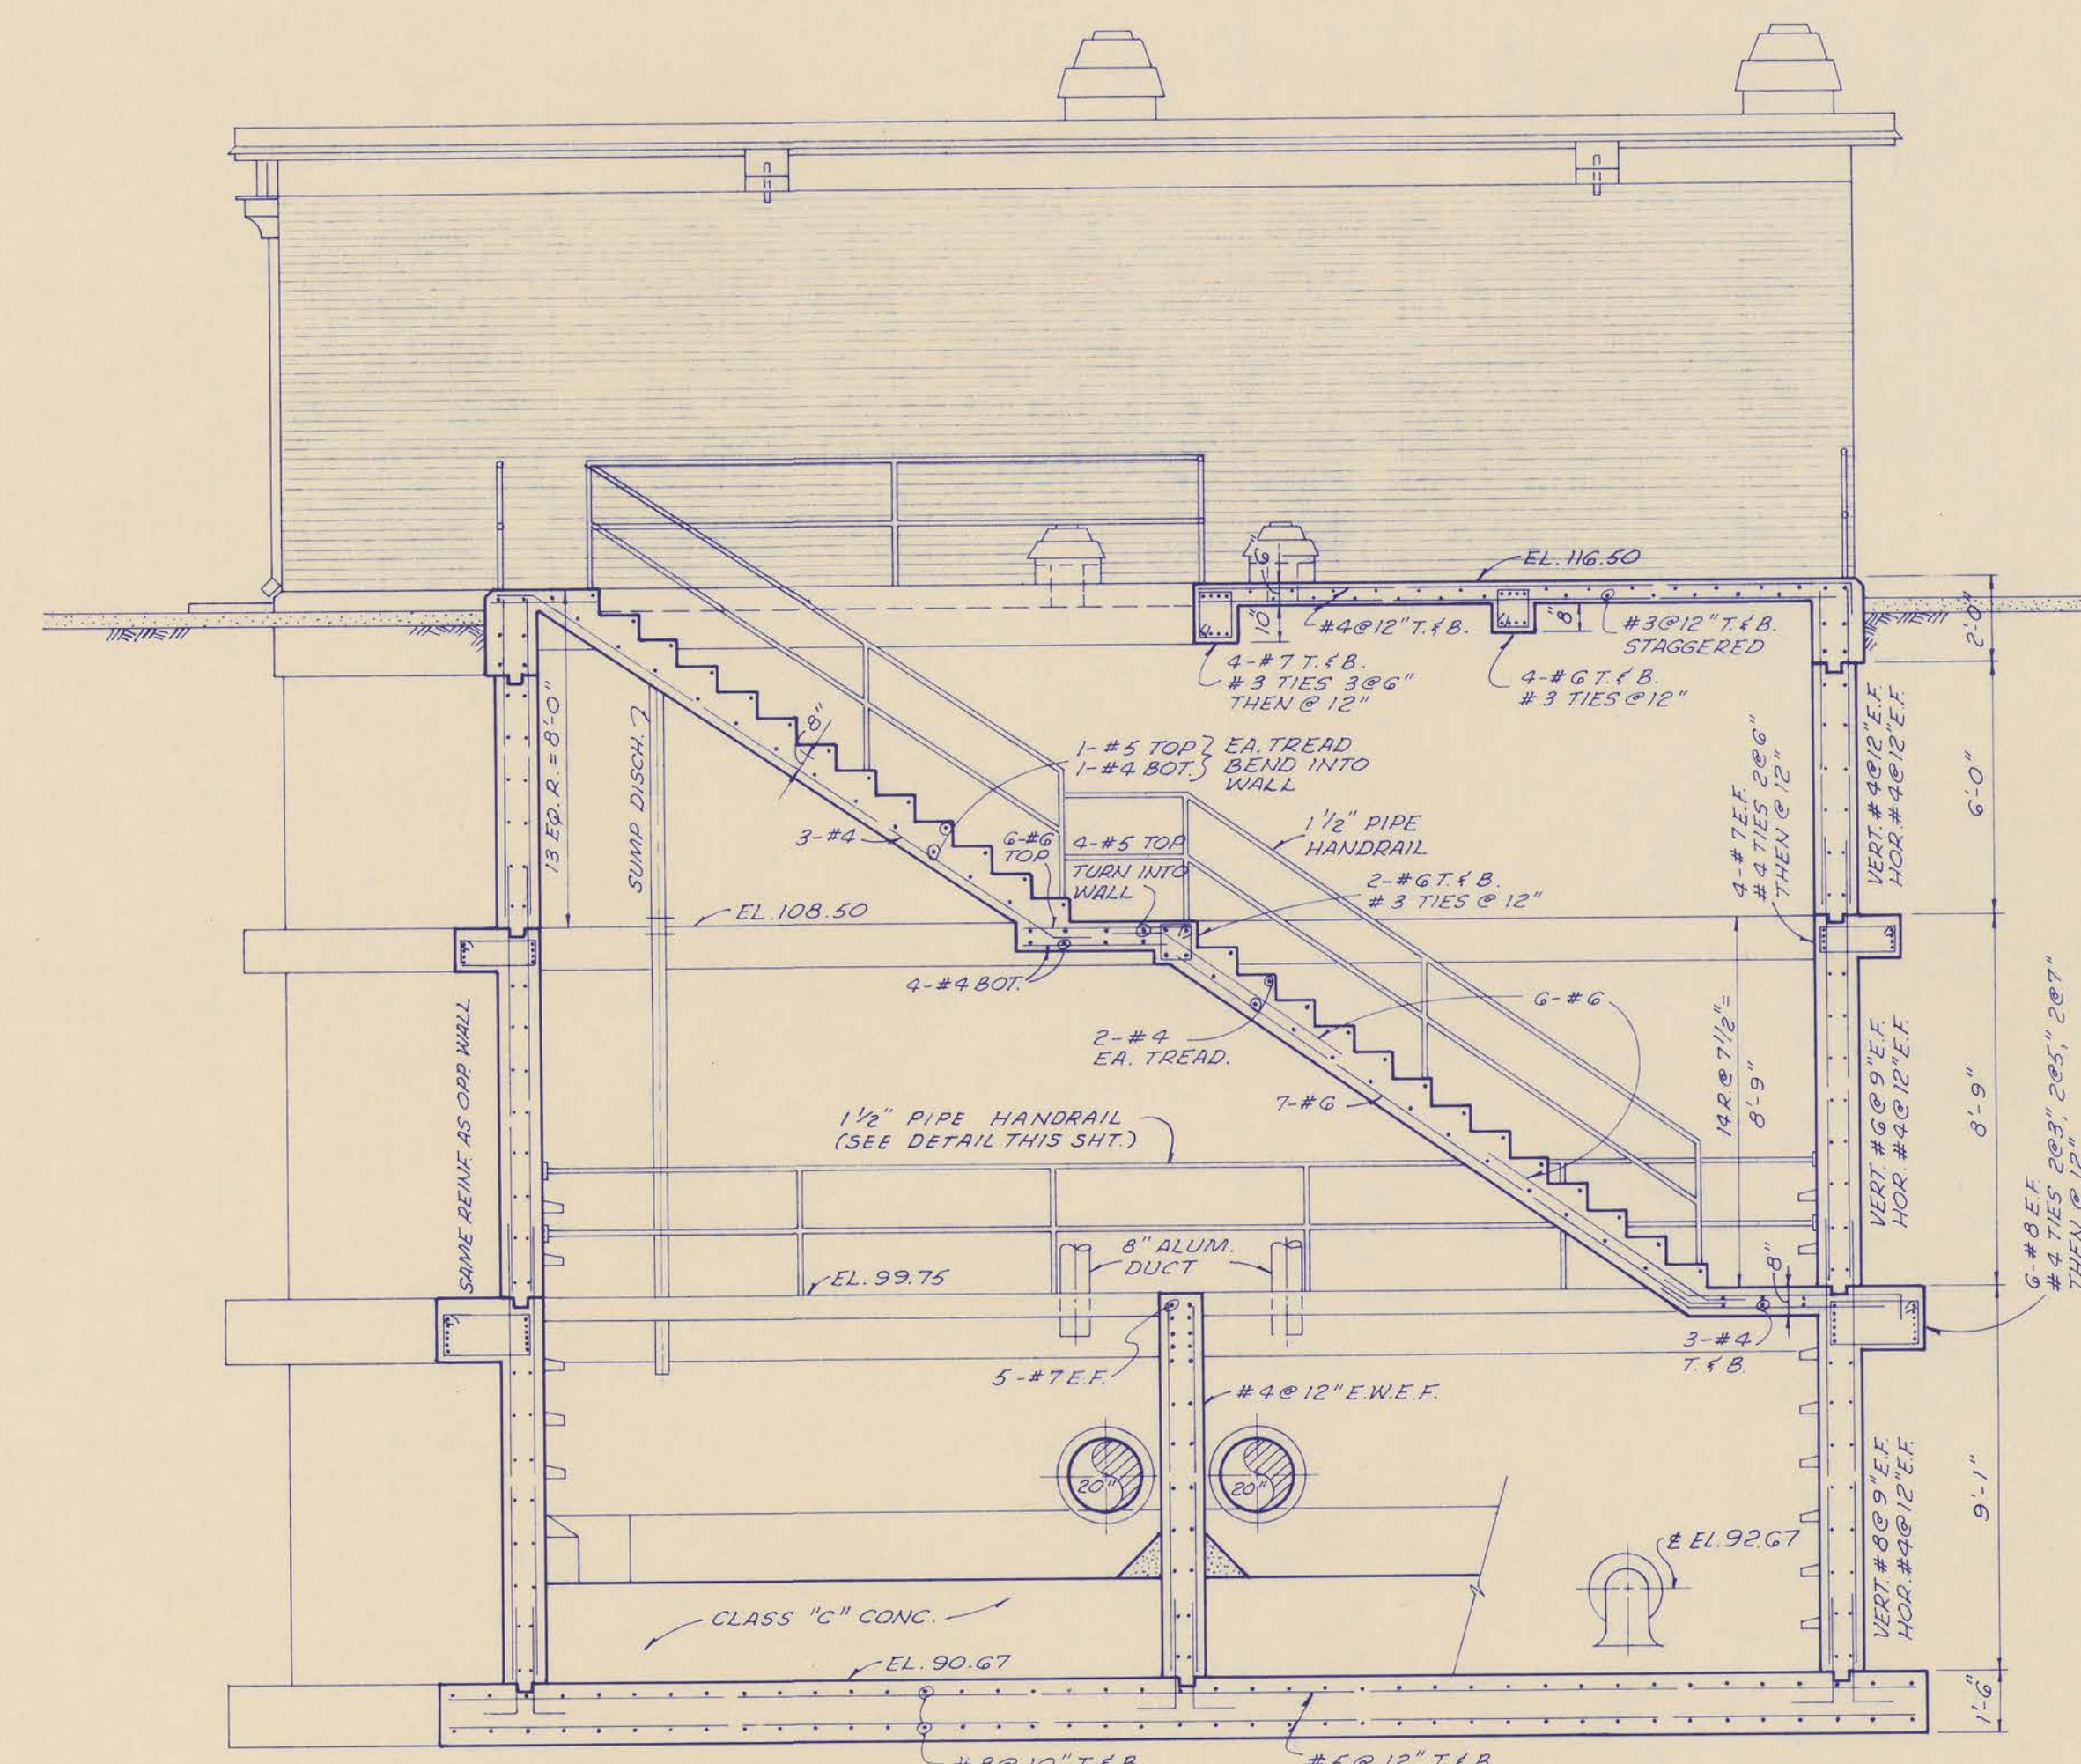

SECTION B-B  
1/4"=1'-0"

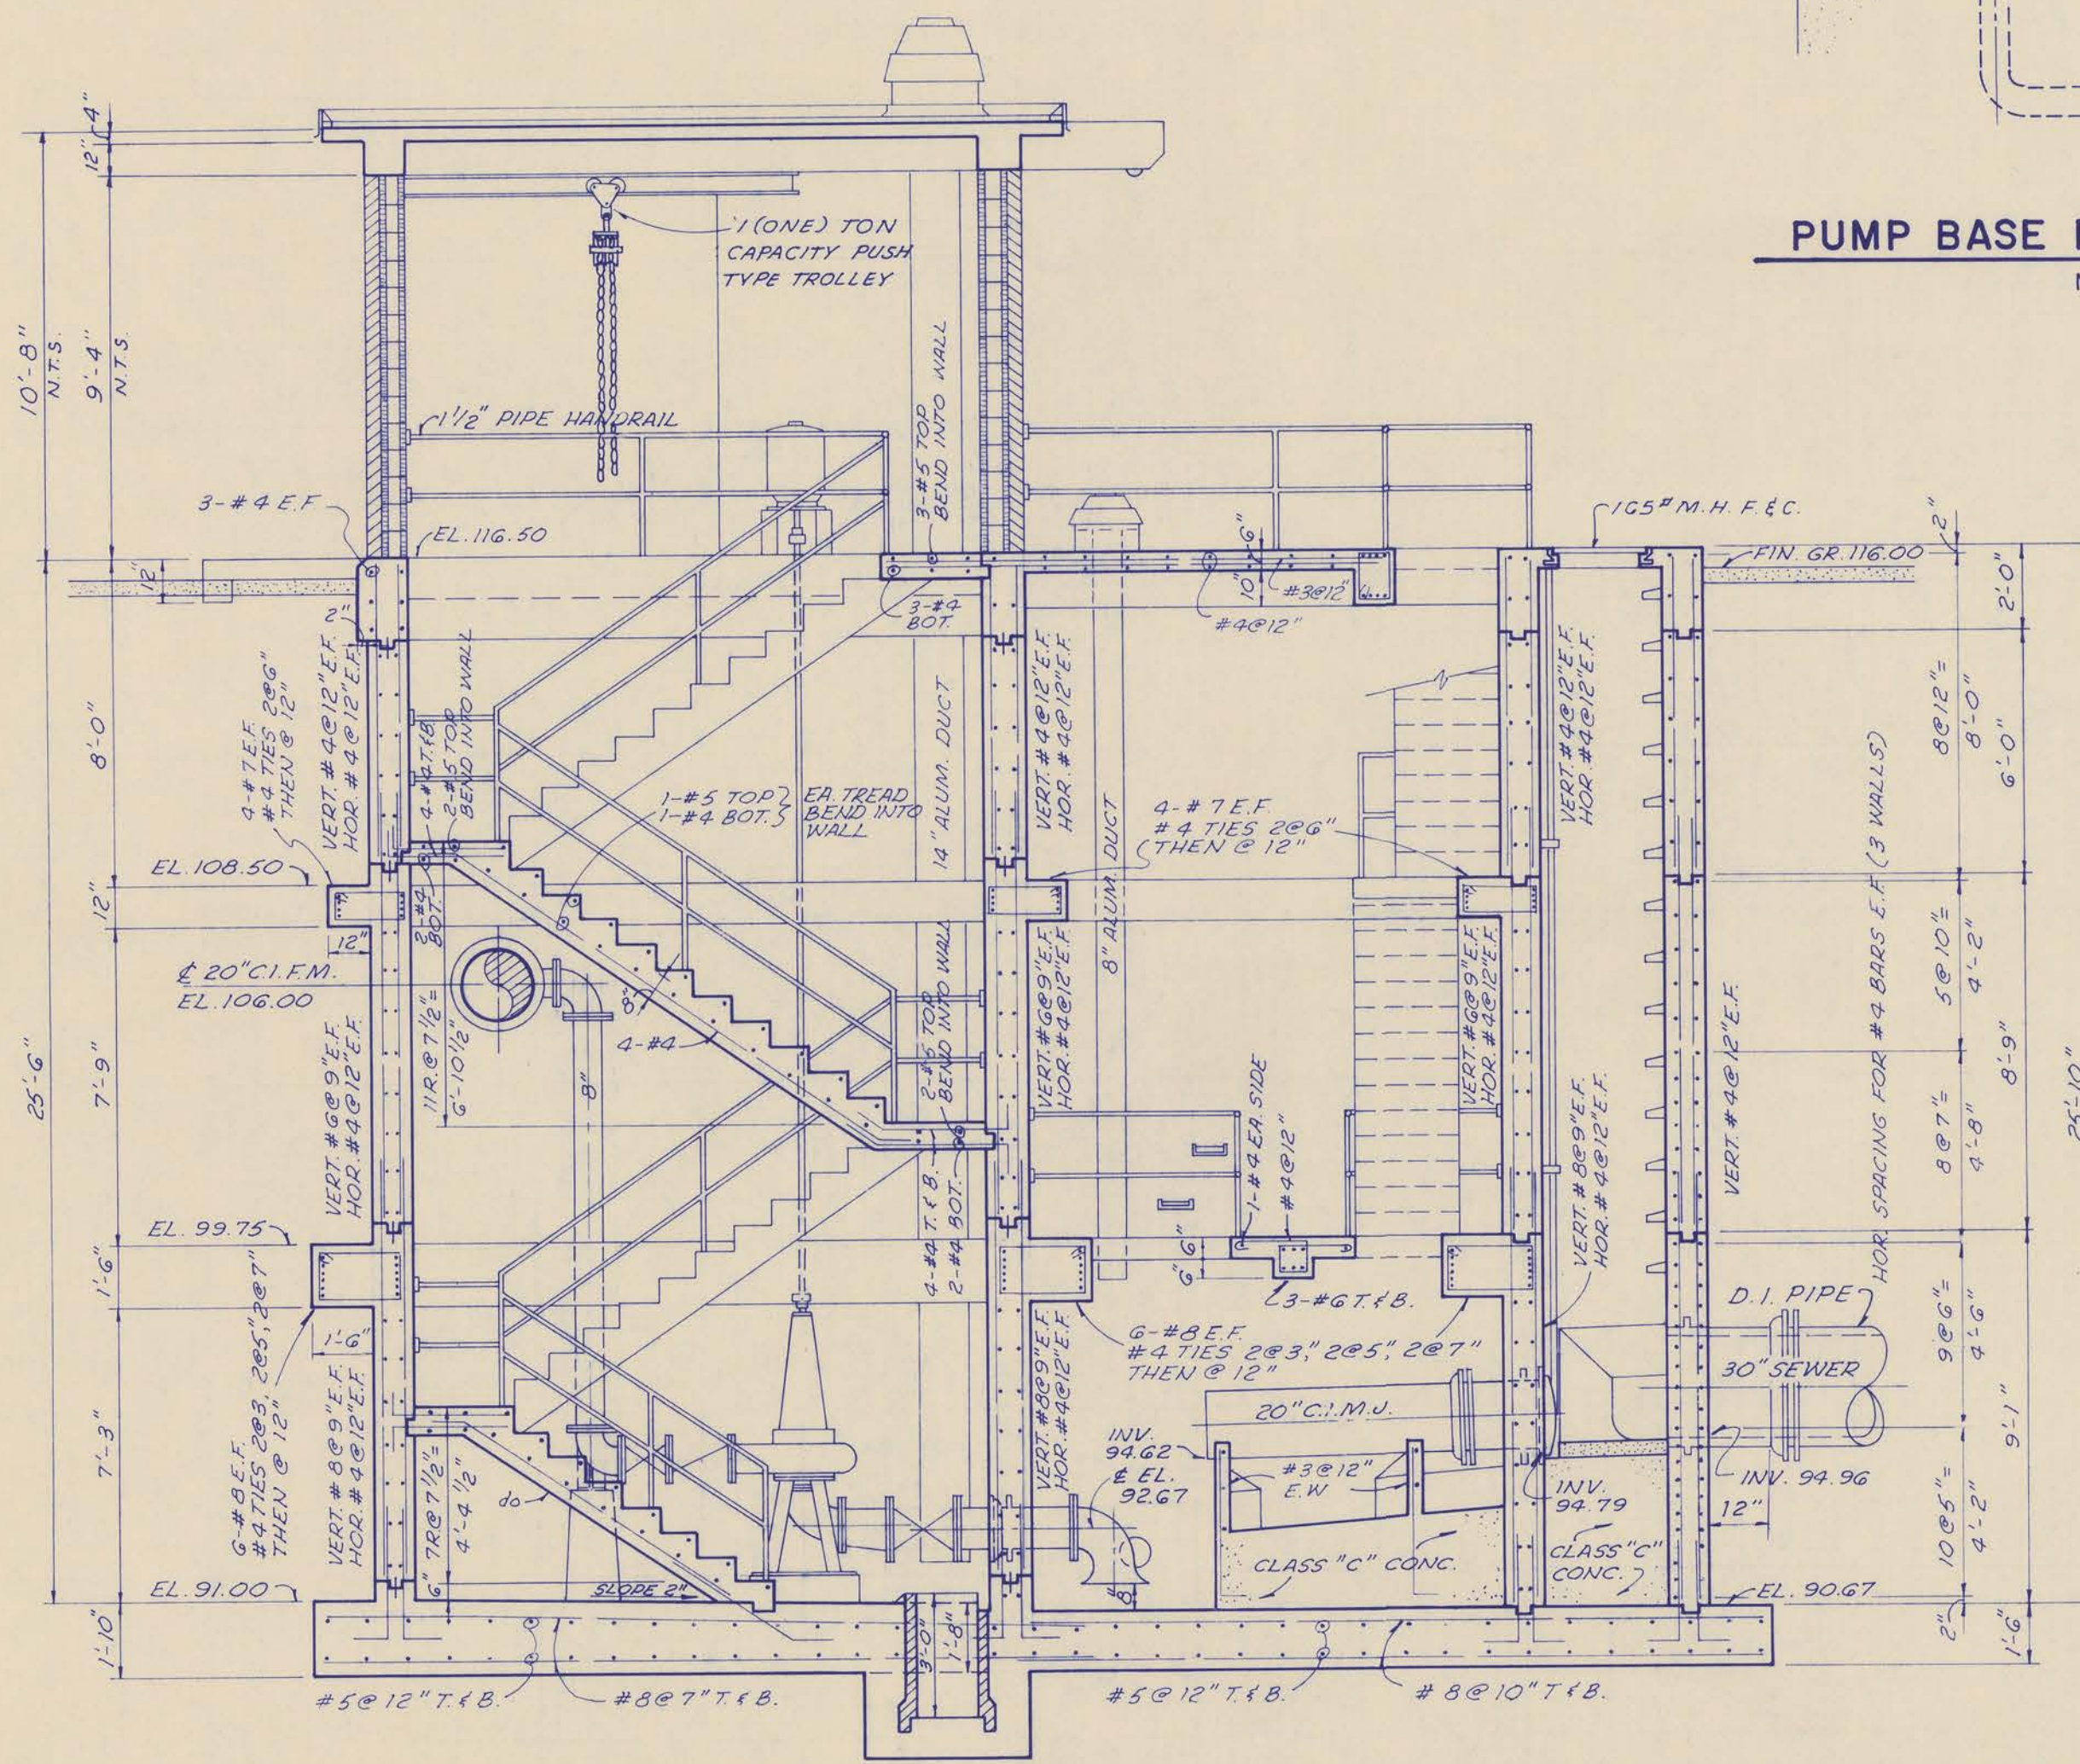


SECTION C-C  
1/4"=1'-0"

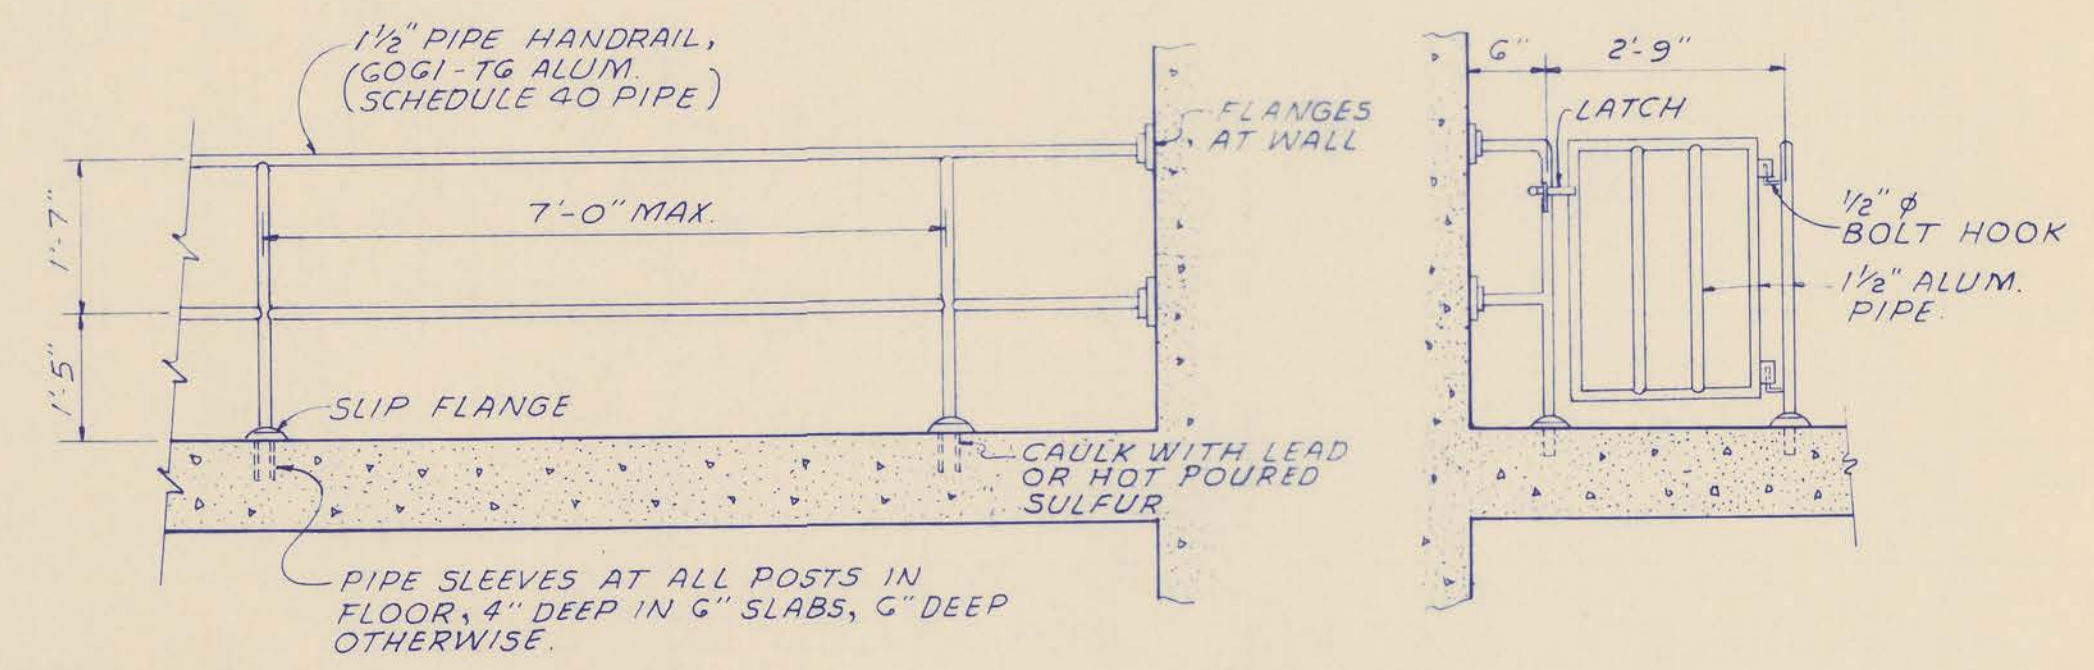


1 1/2" ALUMINUM PIPE HANDRAIL  
N.T.S.


1 1/2" PIPE GATE  
N.T.S.

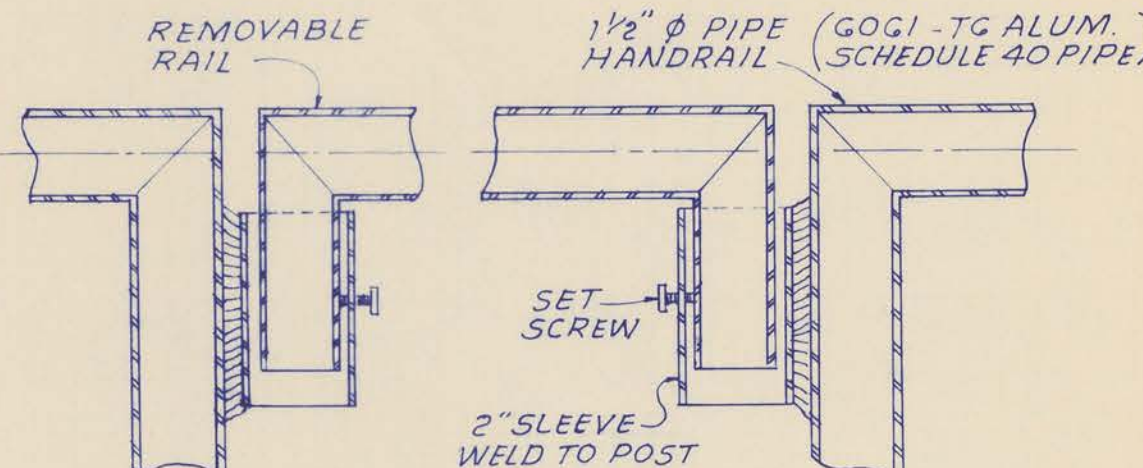

REMOVABLE SECTION  
1 1/2" PIPE HANDRAIL  
N.T.S.

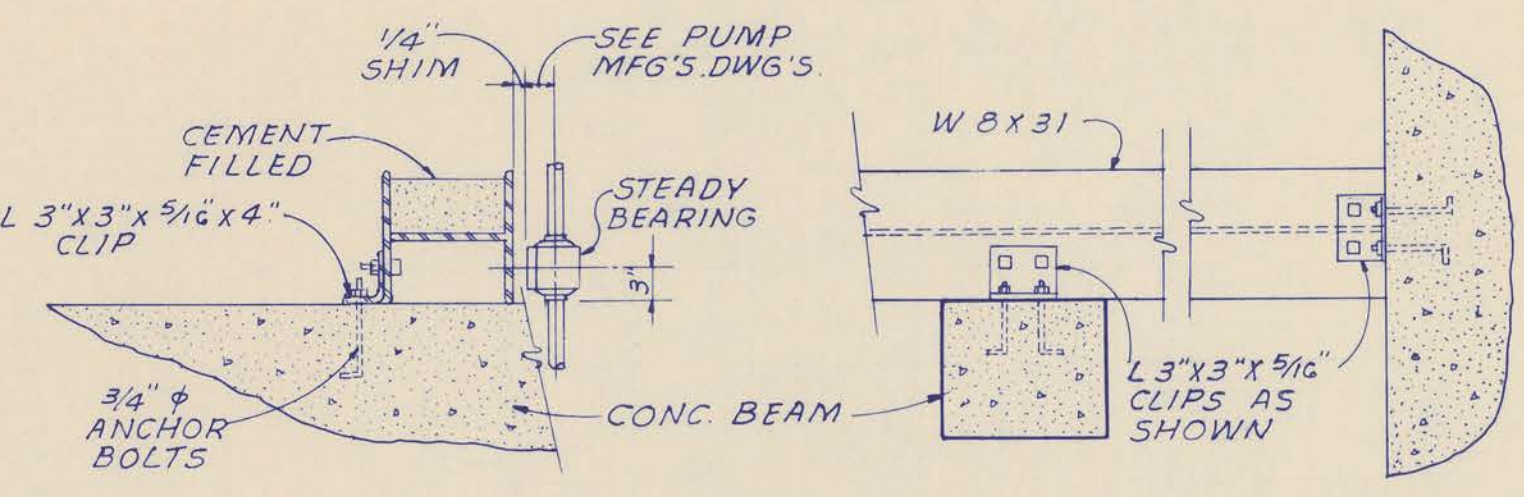


STEADY BEARING SUPPORT  
N.T.S.

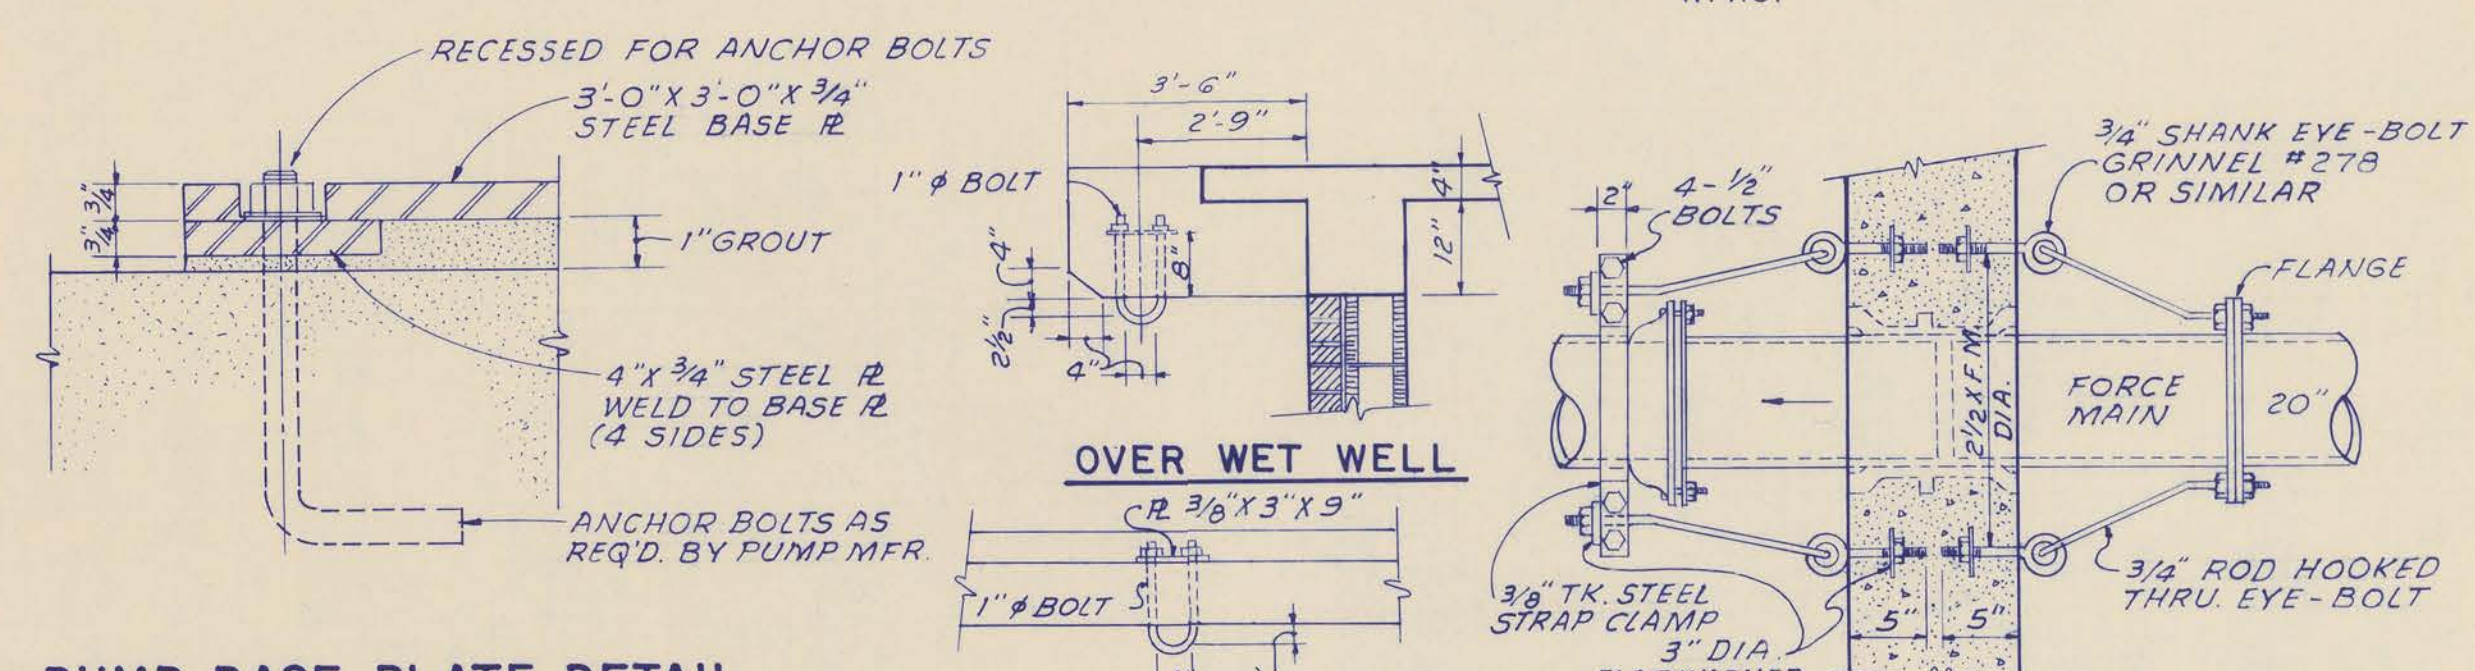

PUMP BASE PLATE DETAIL  
N.T.S.

INDOORS  
HOIST HOOKS  
1/2"=1'-0"

FORCE MAIN ANCHORS  
N.T.S.

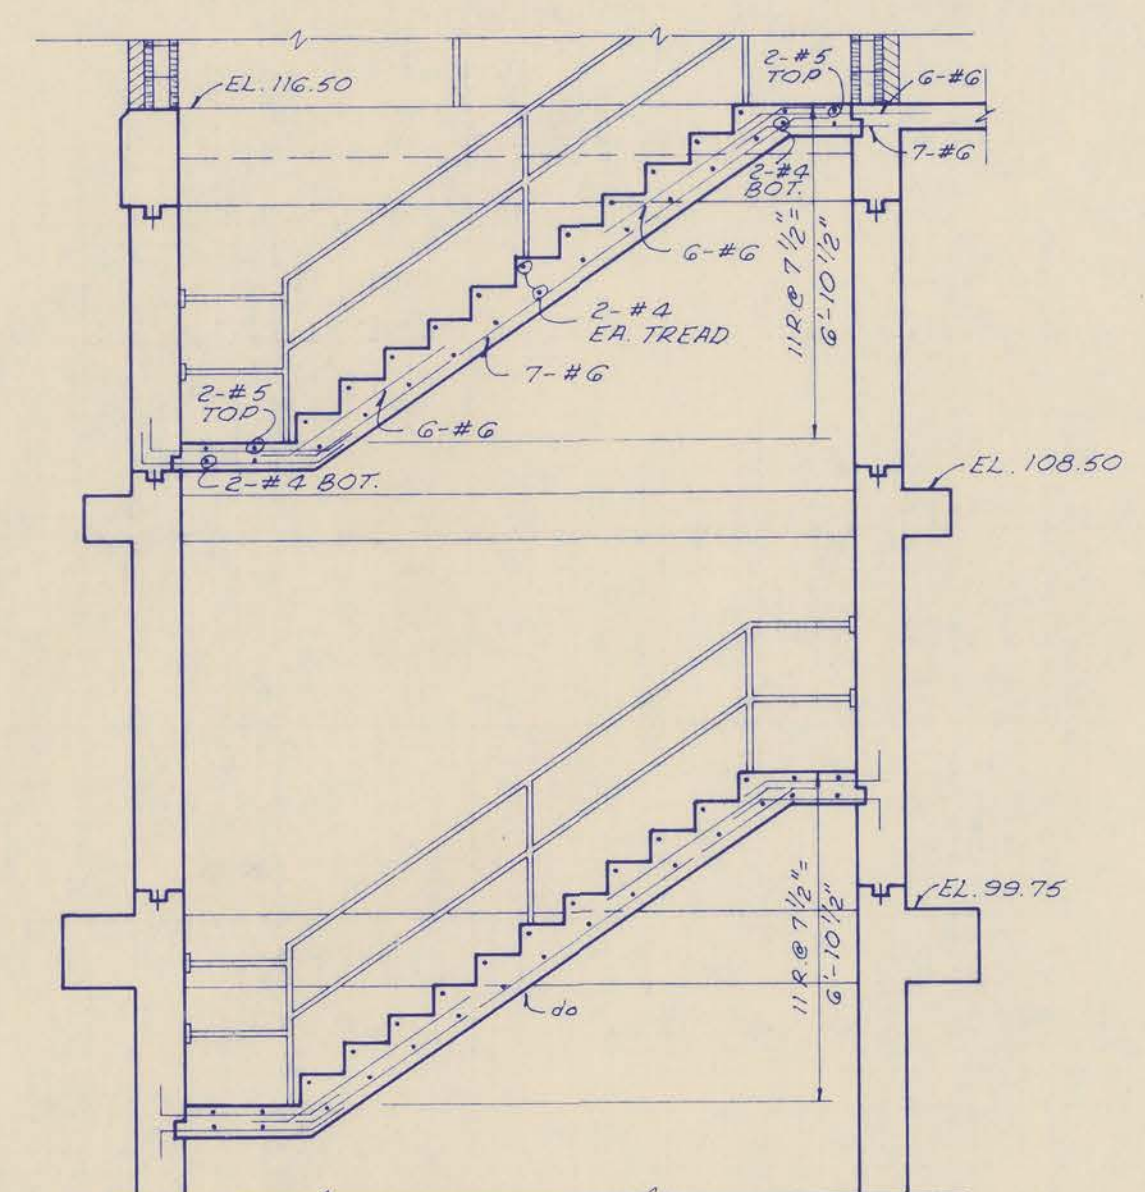

SECTION D-D  
1/4"=1'-0"

CONTRACT - A - 1976  
EPA PROJECT NO. C130381  
DIVISION TWO

CITY OF BRUNSWICK, GEORGIA  
SEWERAGE SYSTEM IMPROVEMENTS

ARCO PUMPING STATION  
ELEVATIONS, SECTIONS AND DETAILS

DATUM EQUALS USC&GS MEAN  
SEA LEVEL PLUS 100.00 FT.



SCALE AS SHOWN  
DATE JAN. 1976  
WIEDEMAN AND SINGLETON  
ENGINEERS  
ATLANTA GEORGIA  
SHEET 3 OF