




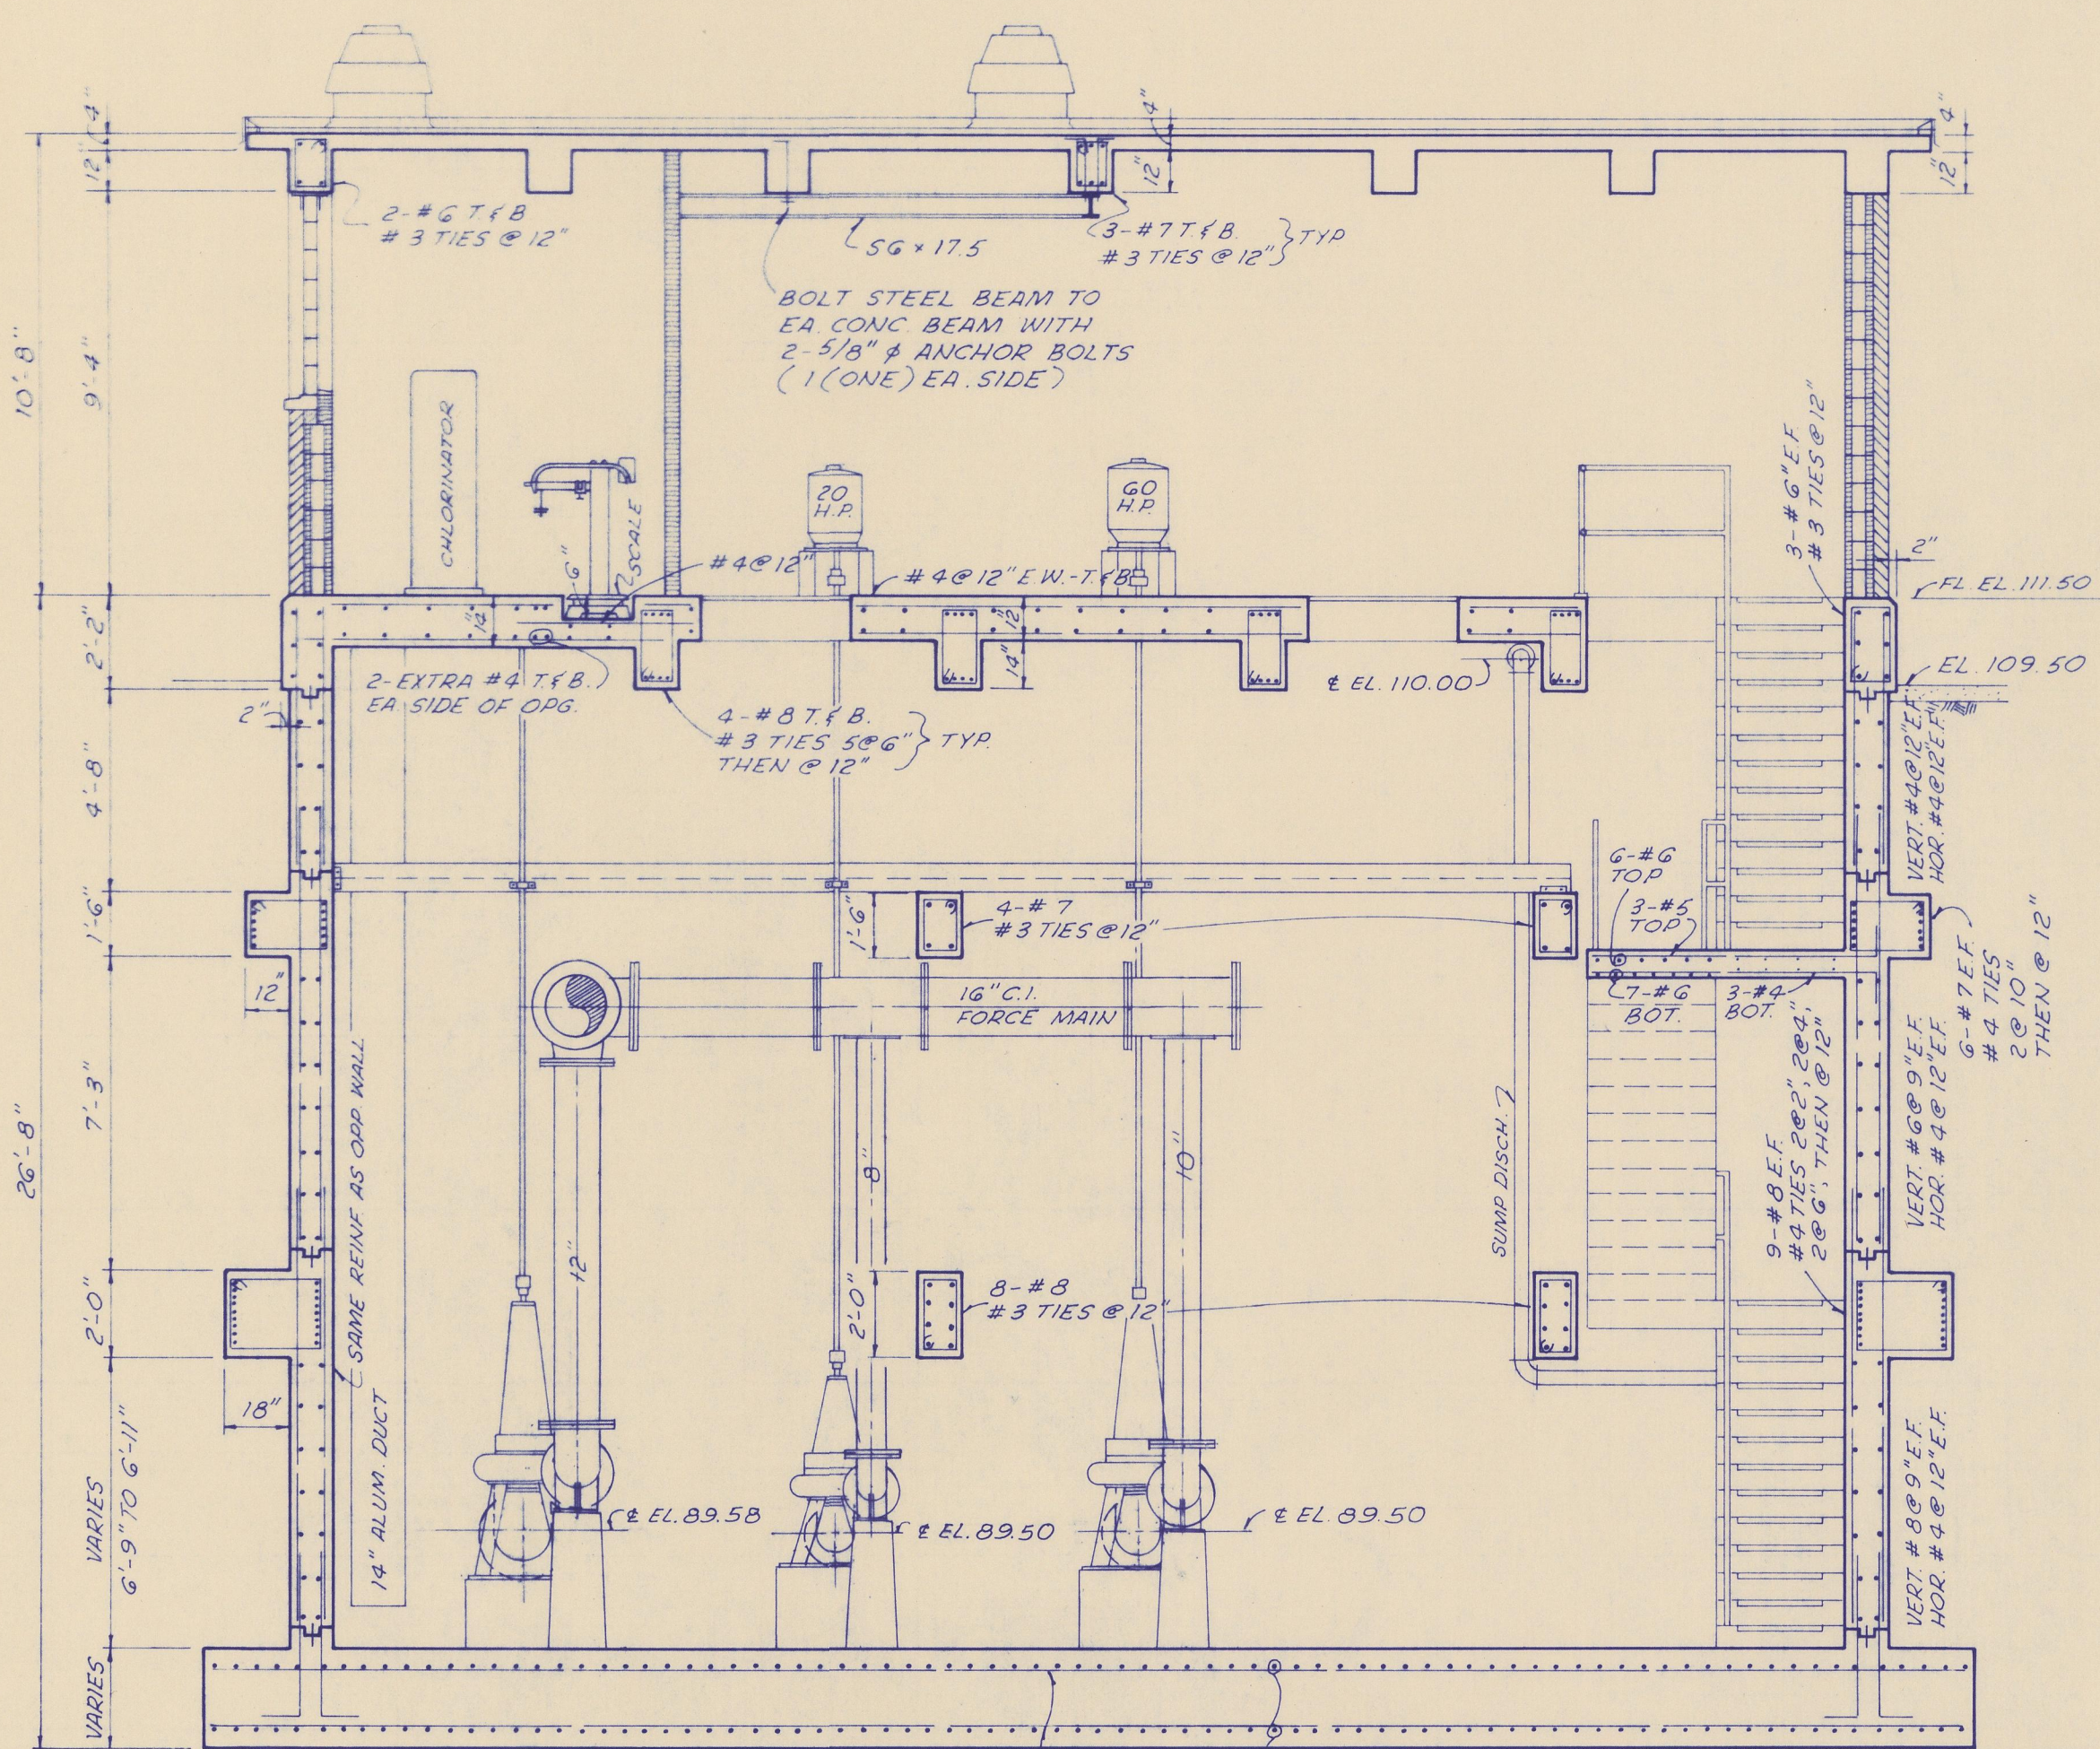









SECTION A-A
1/4" = 1'-0"

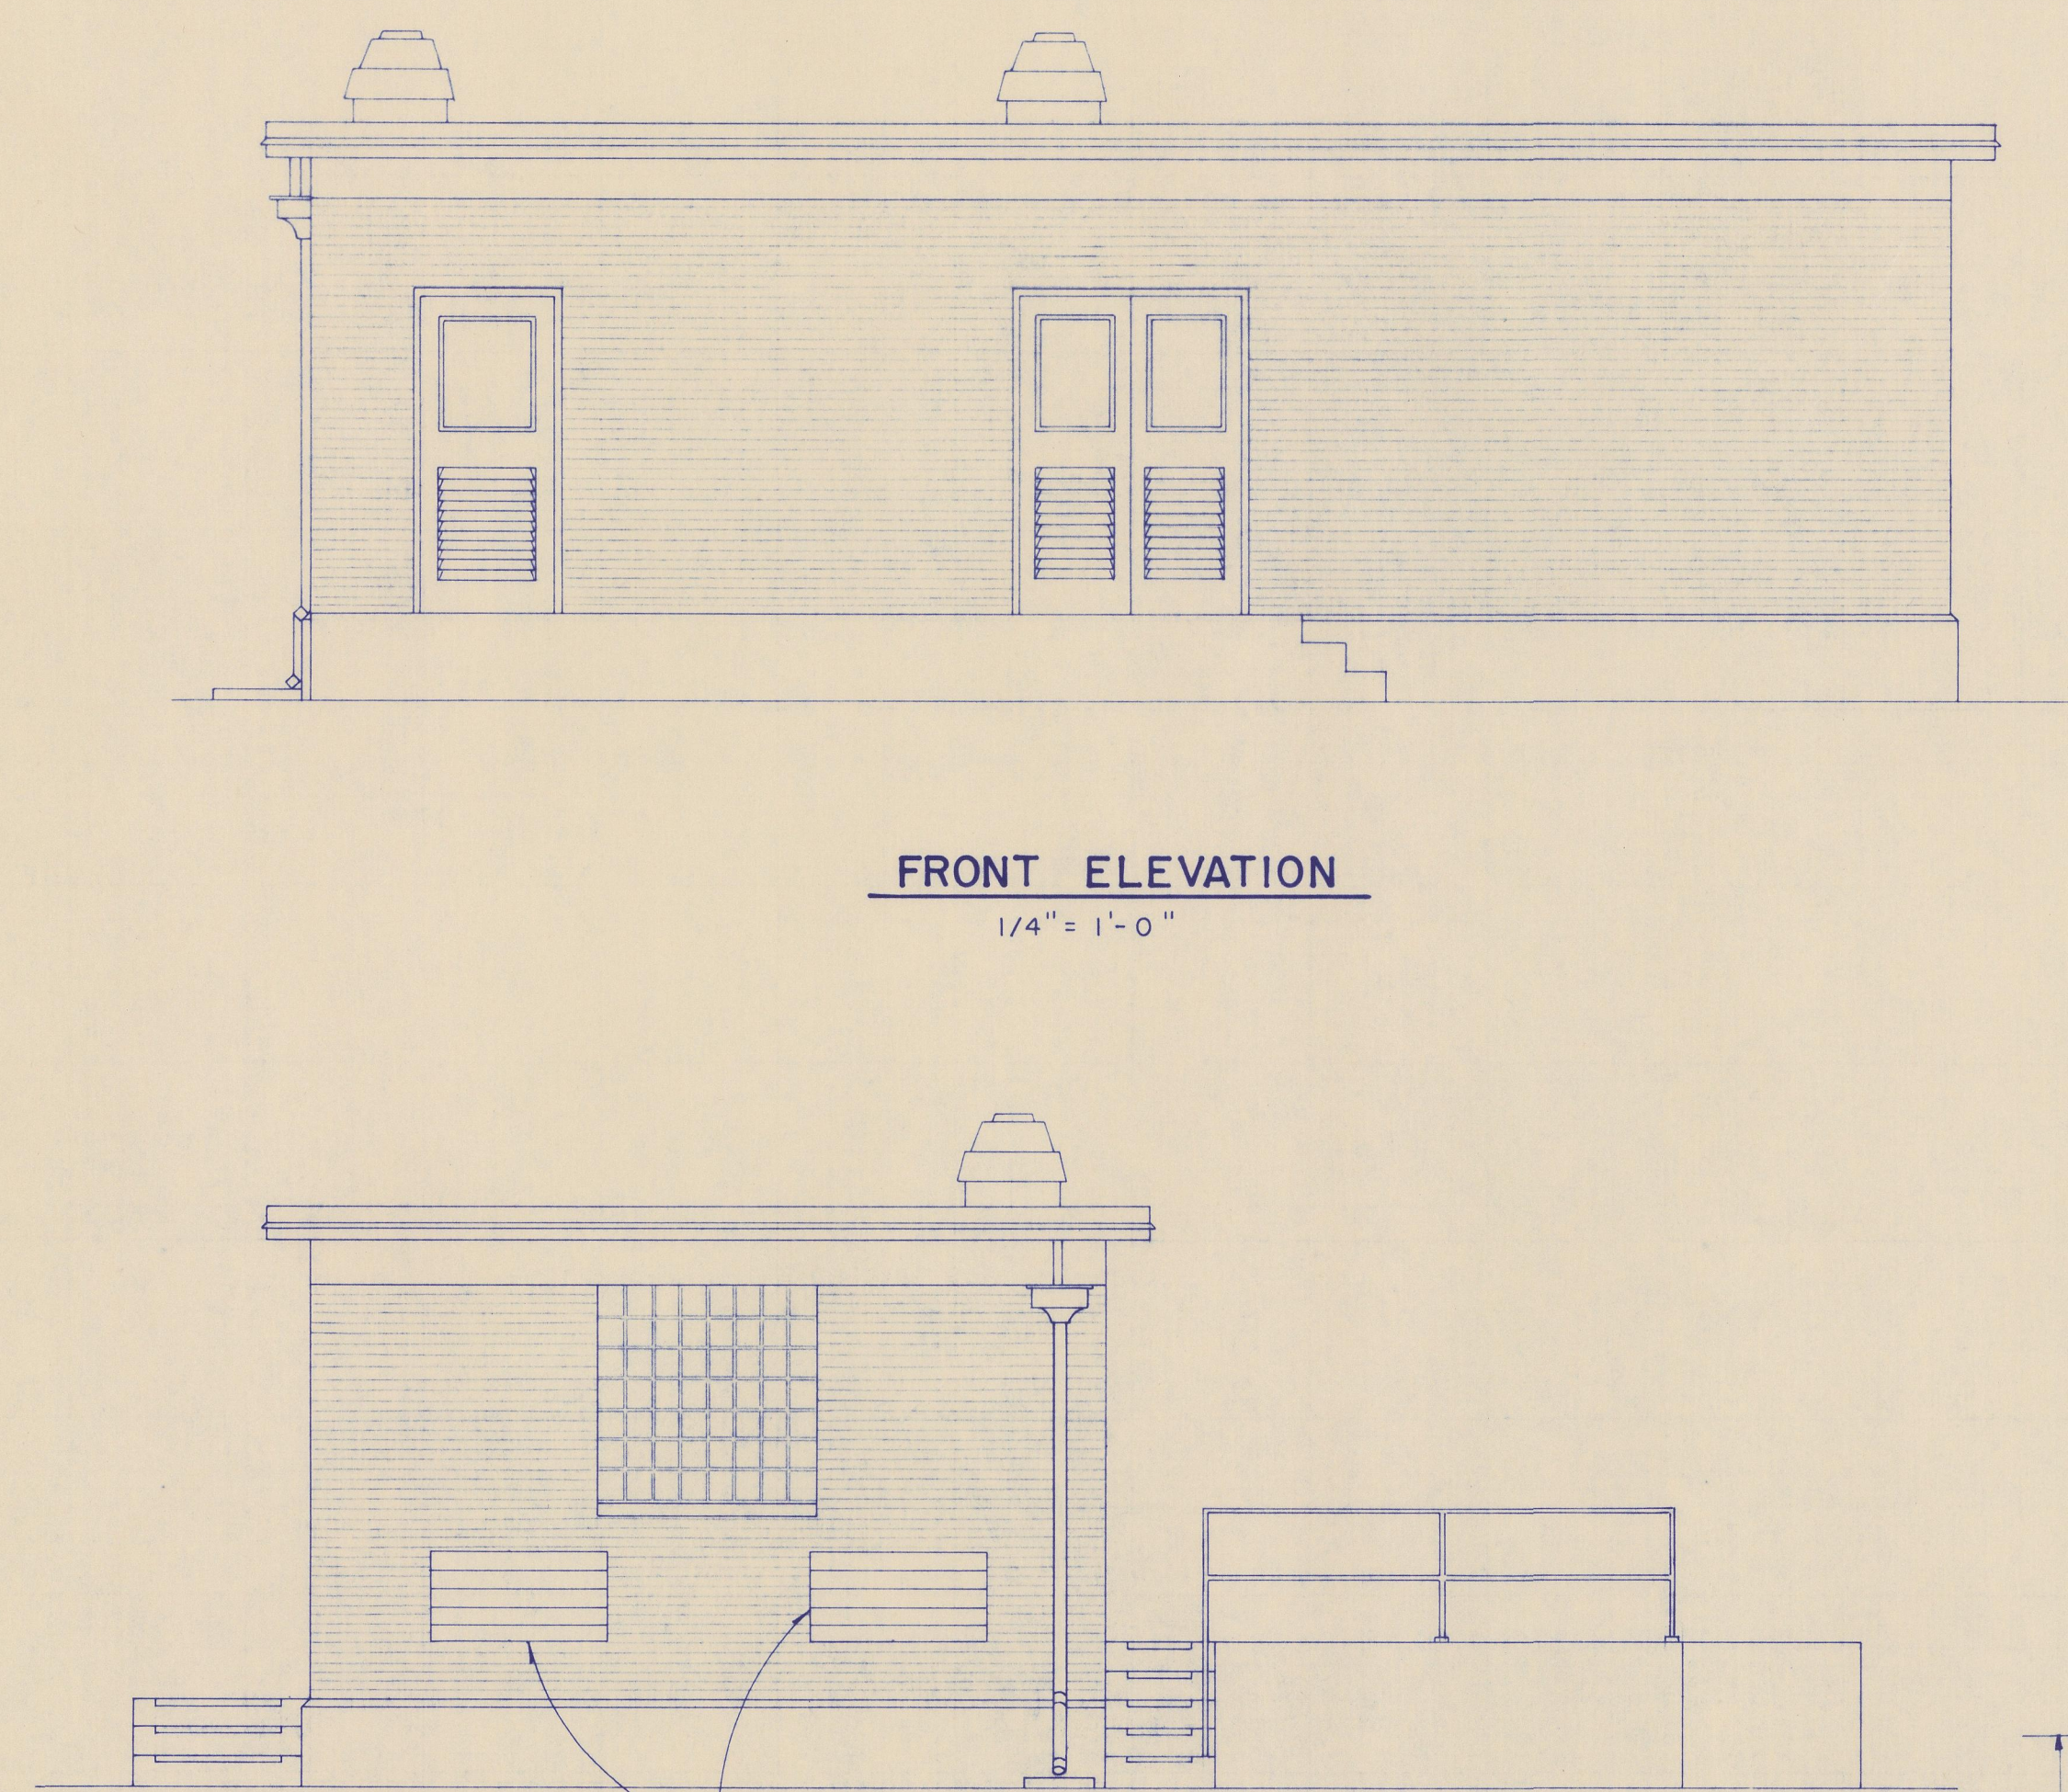


FRONT ELEVATION
1/4" = 1'-0"

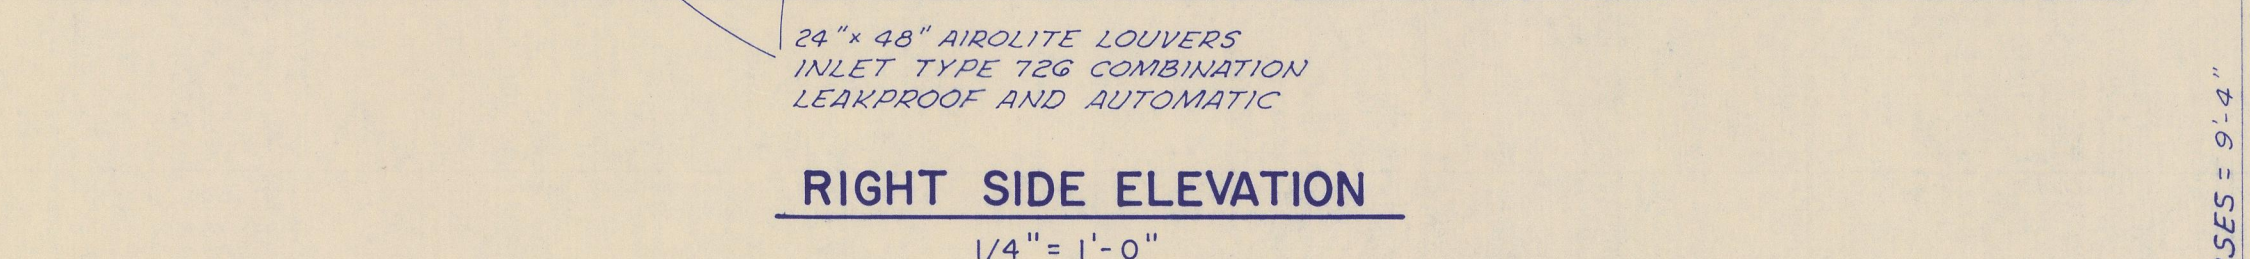


RIGHT SIDE ELEVATION
1/4" = 1'-0"

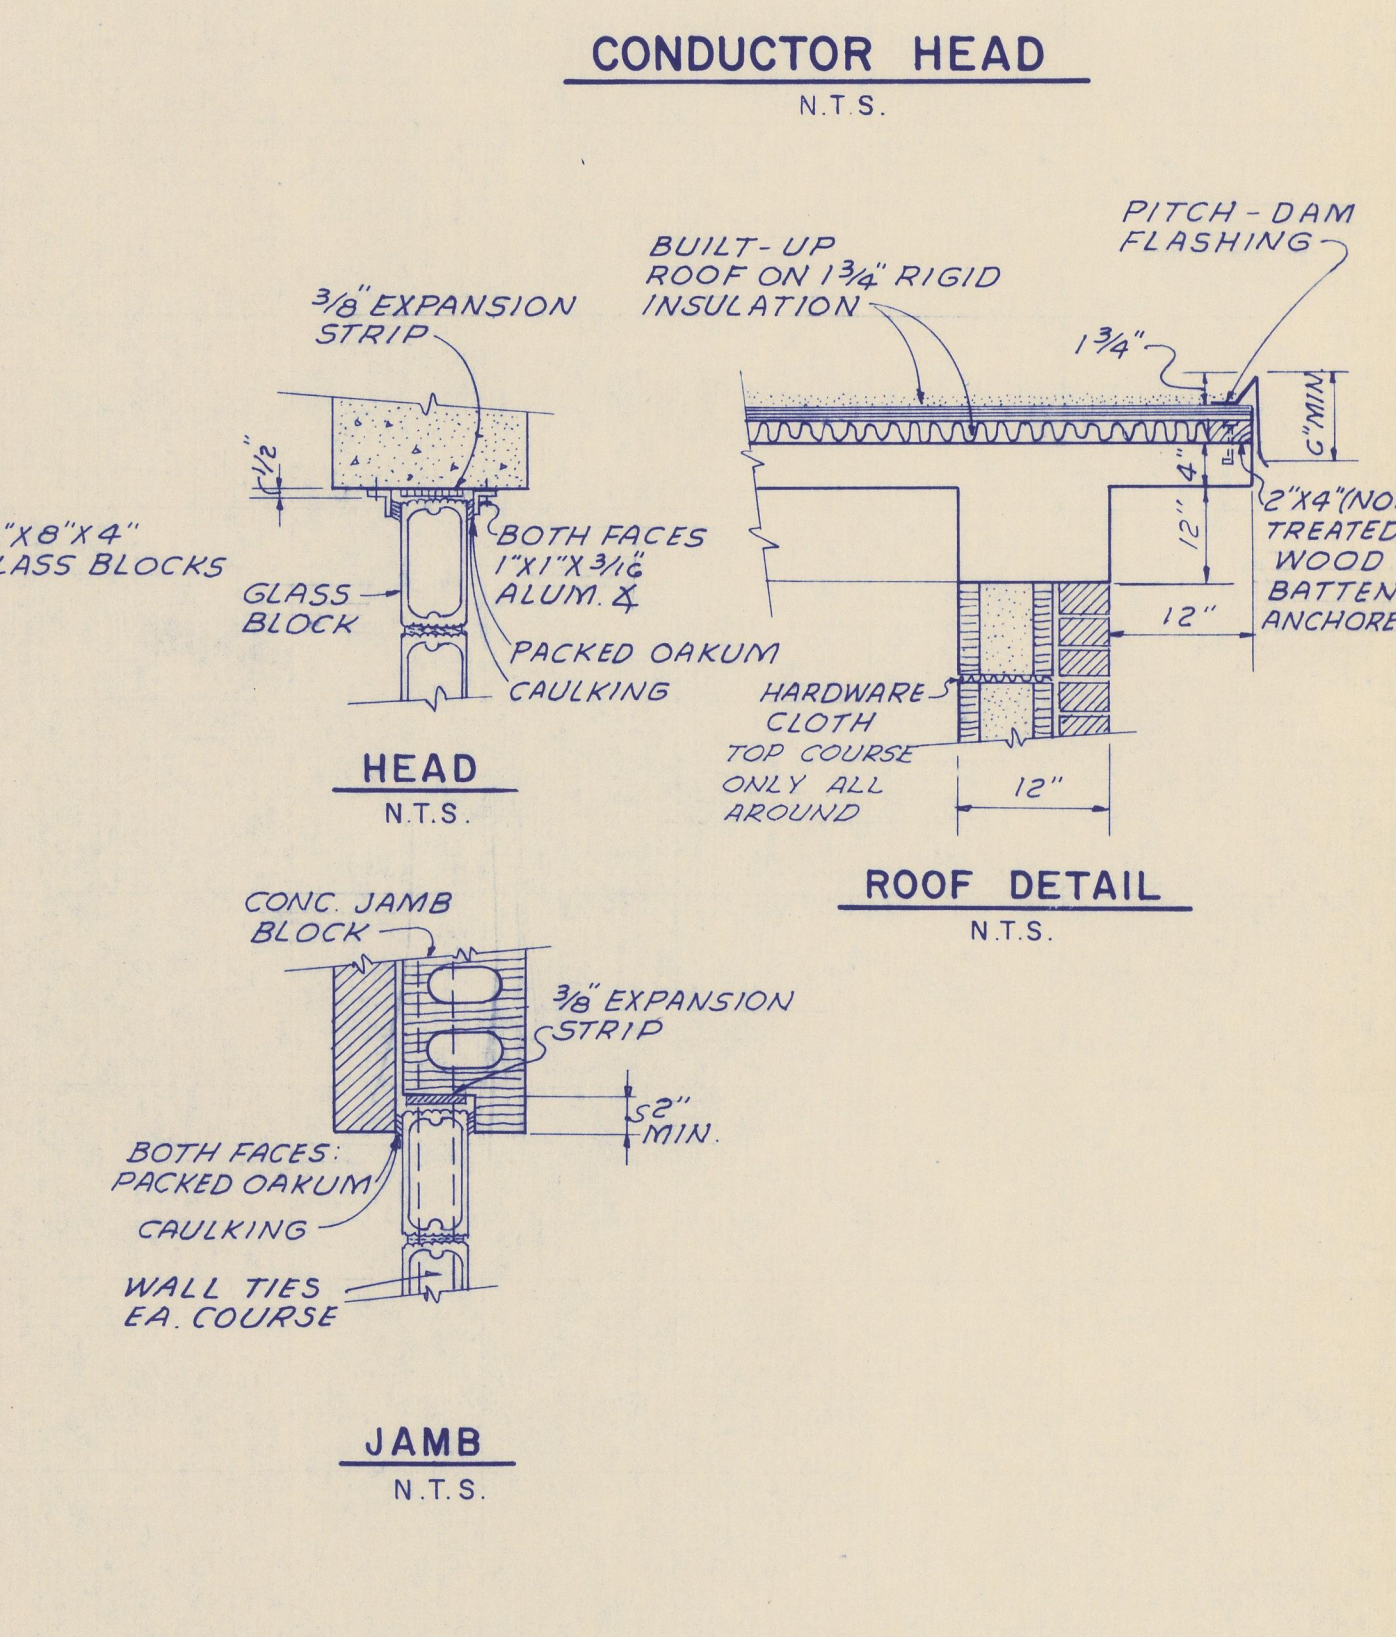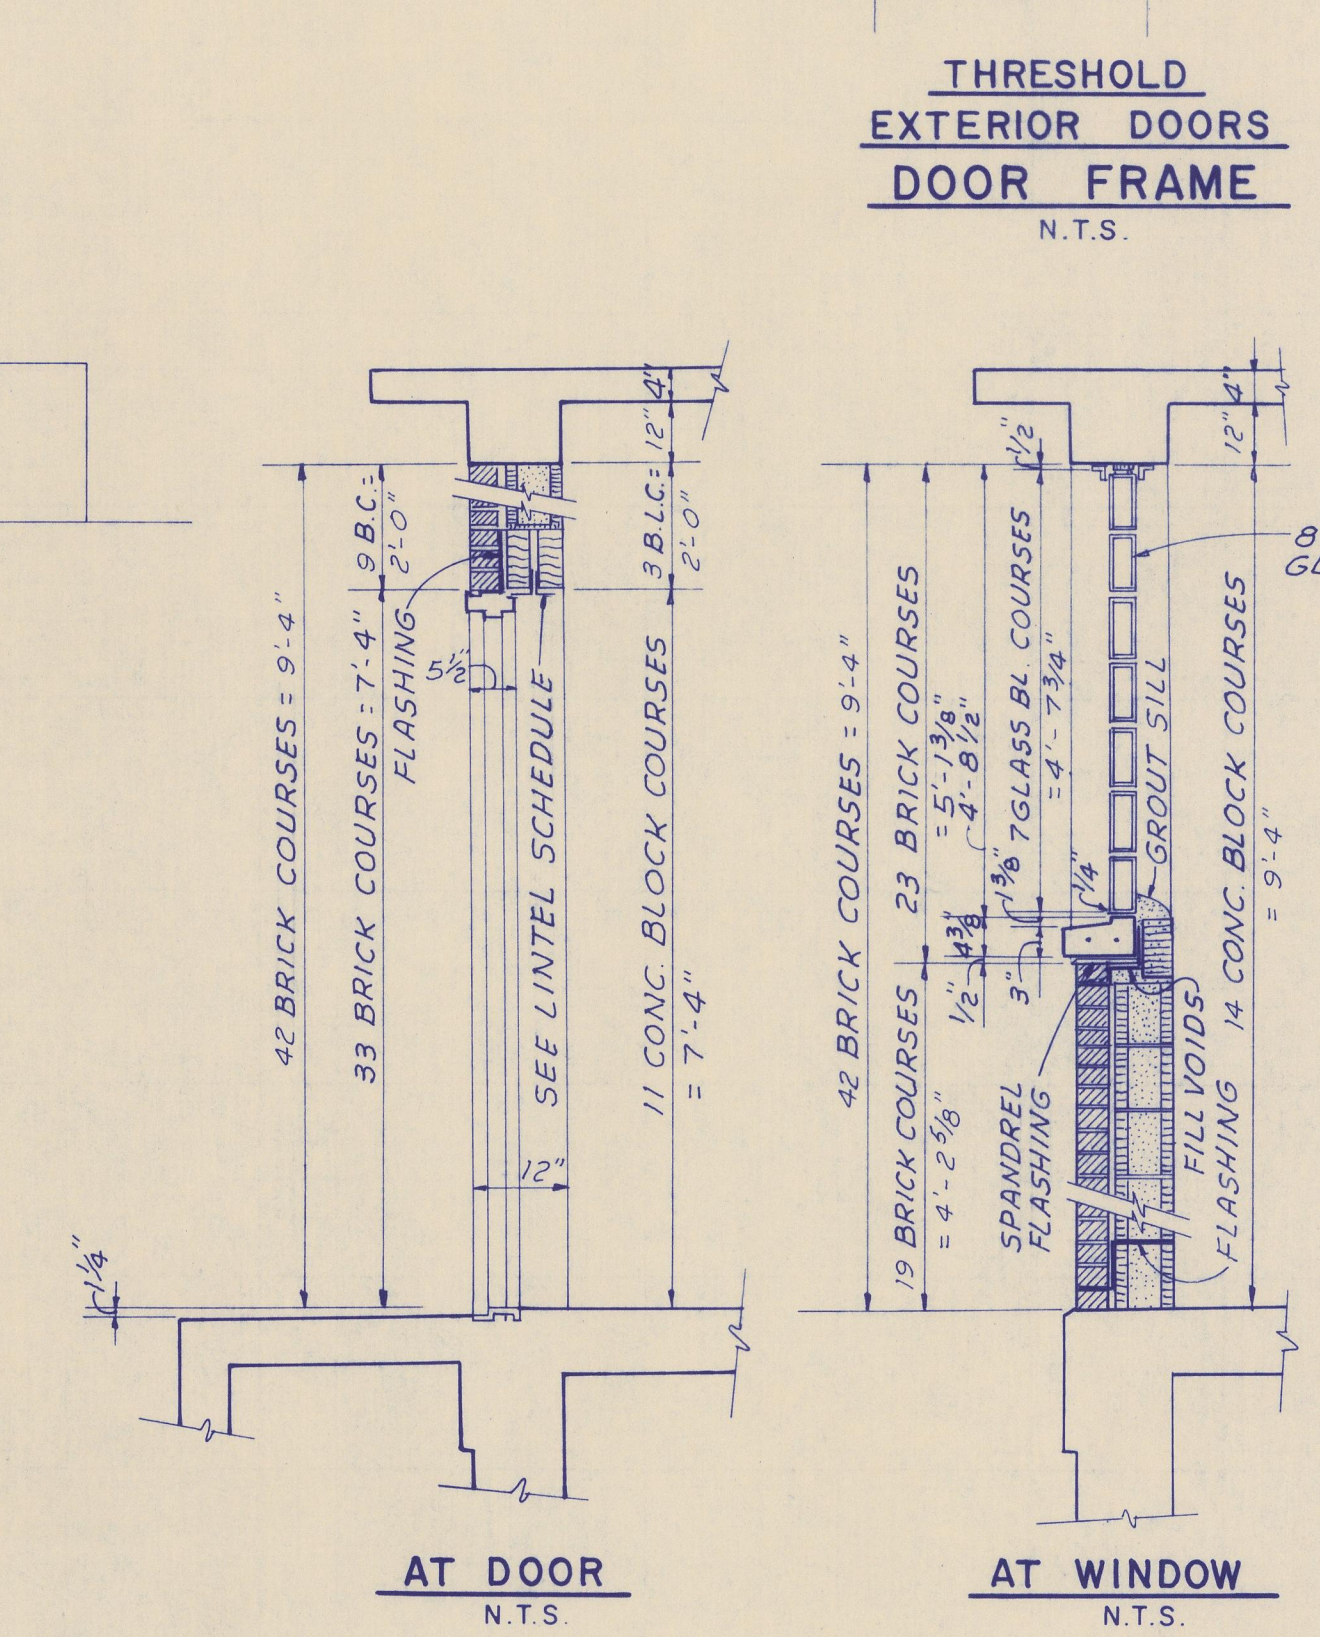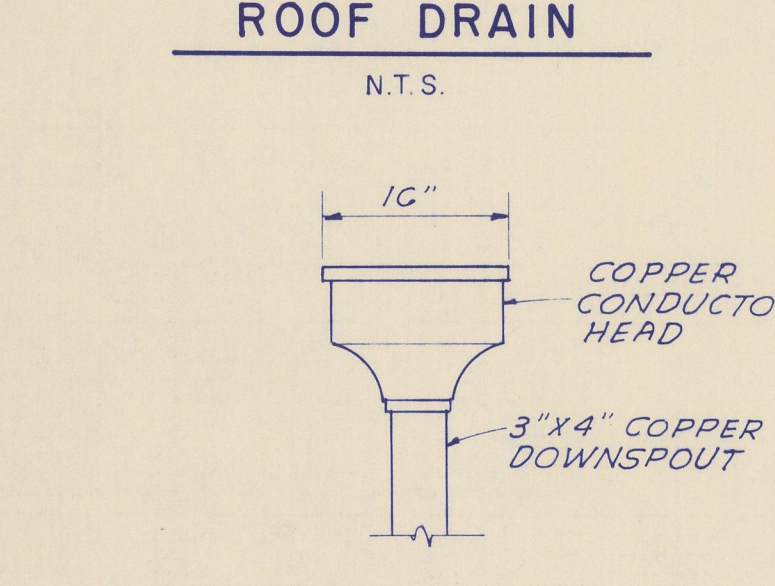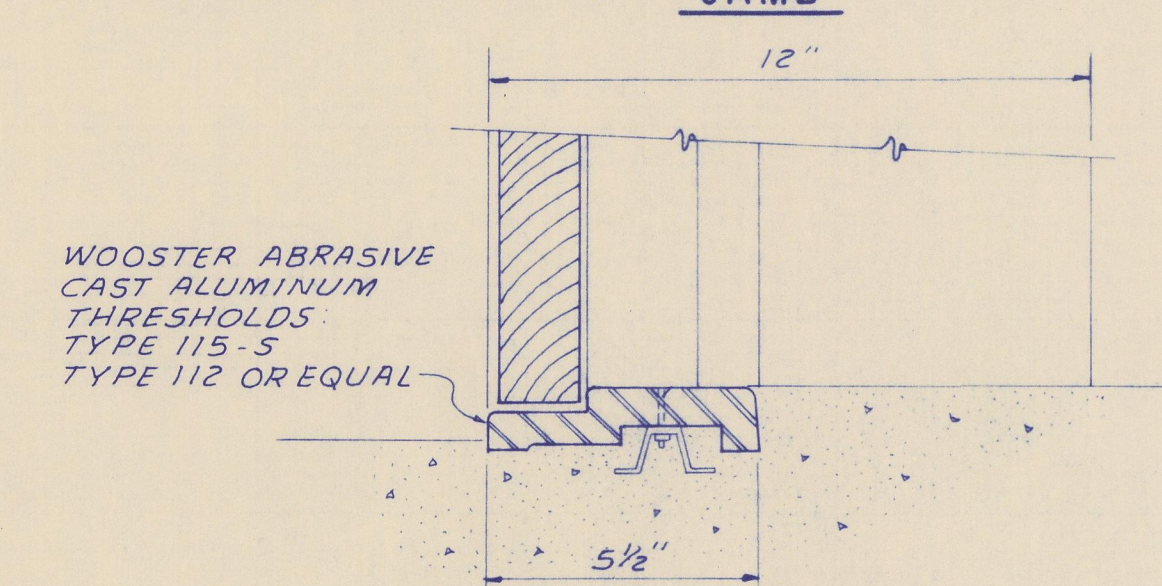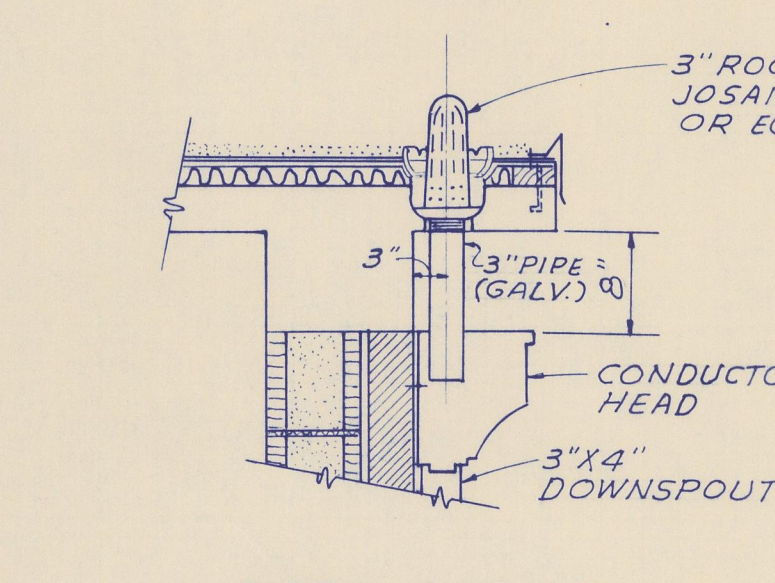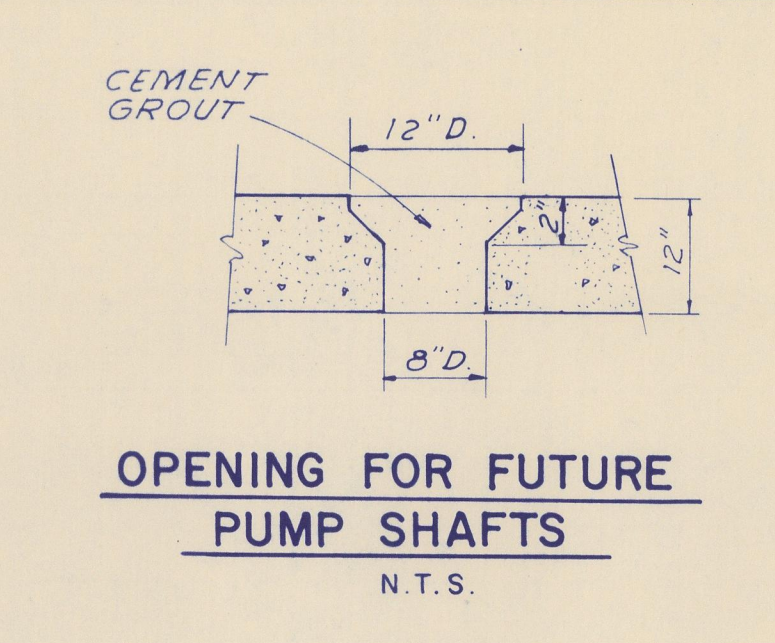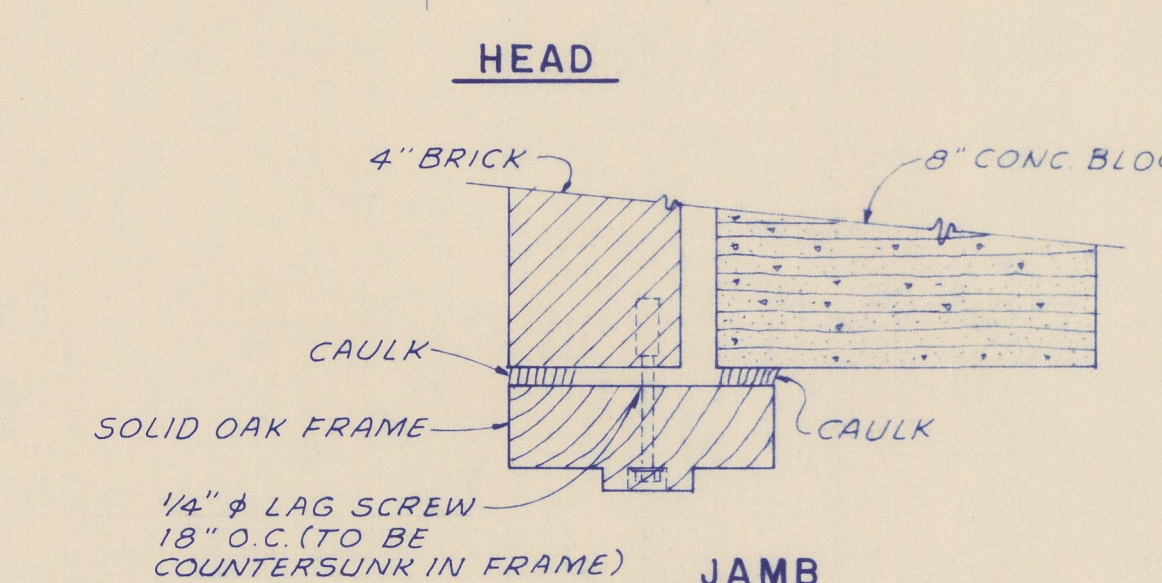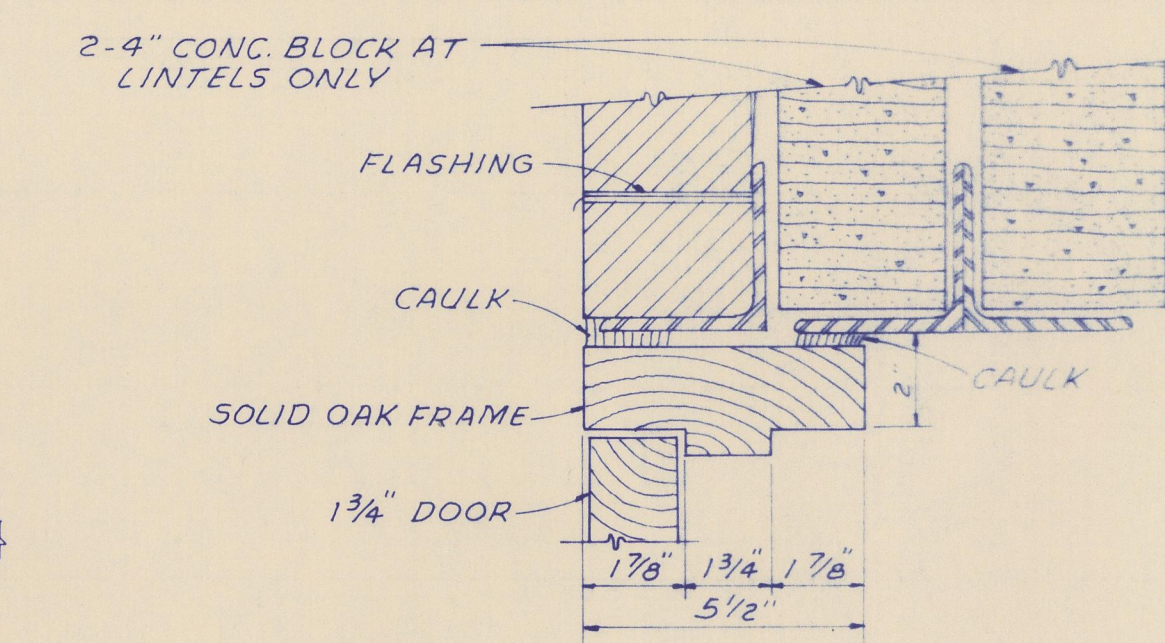


TYPICAL WALL SECTIONS

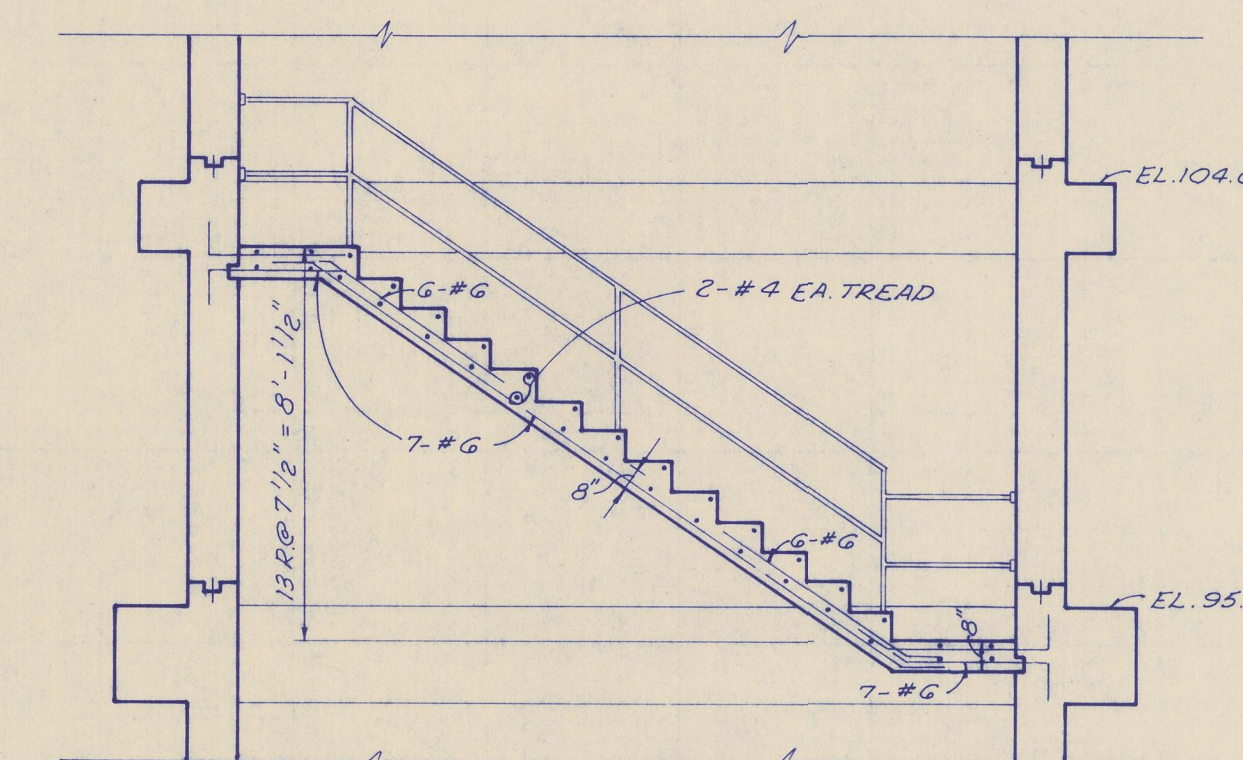

SECTION D-D
1/4" = 1'-0"

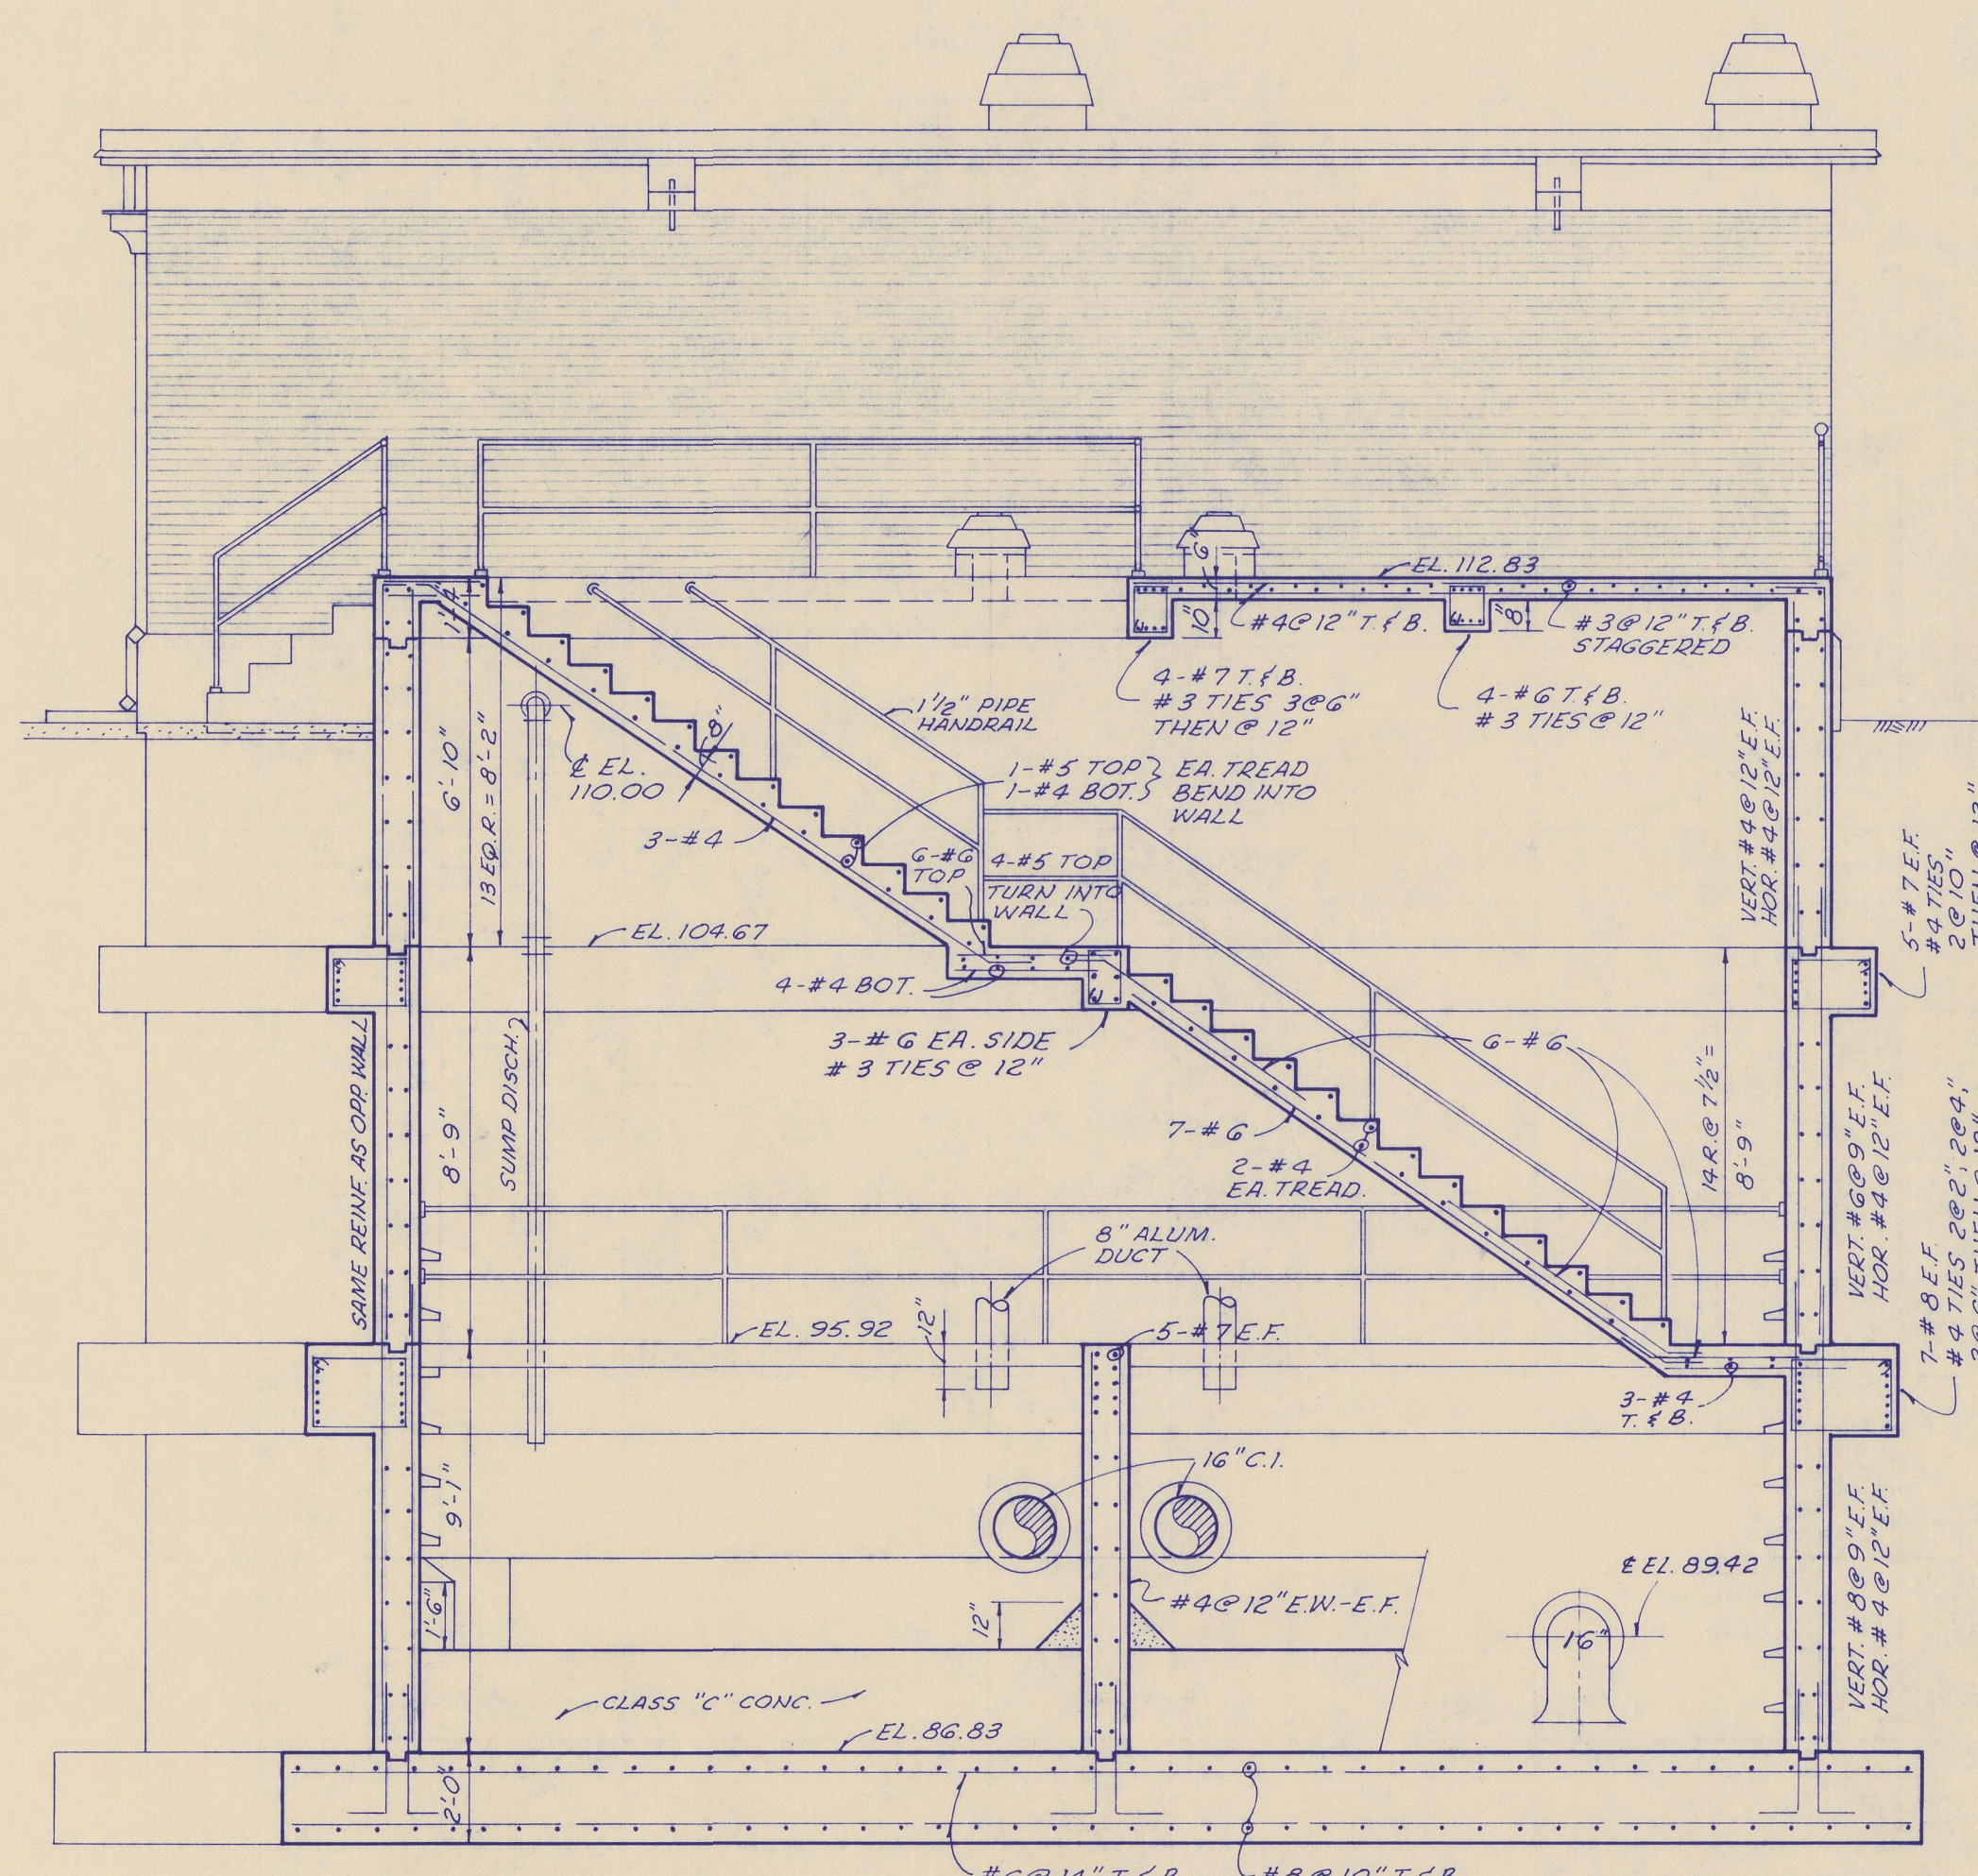

SECTION B-B
1/4" = 1'-0"

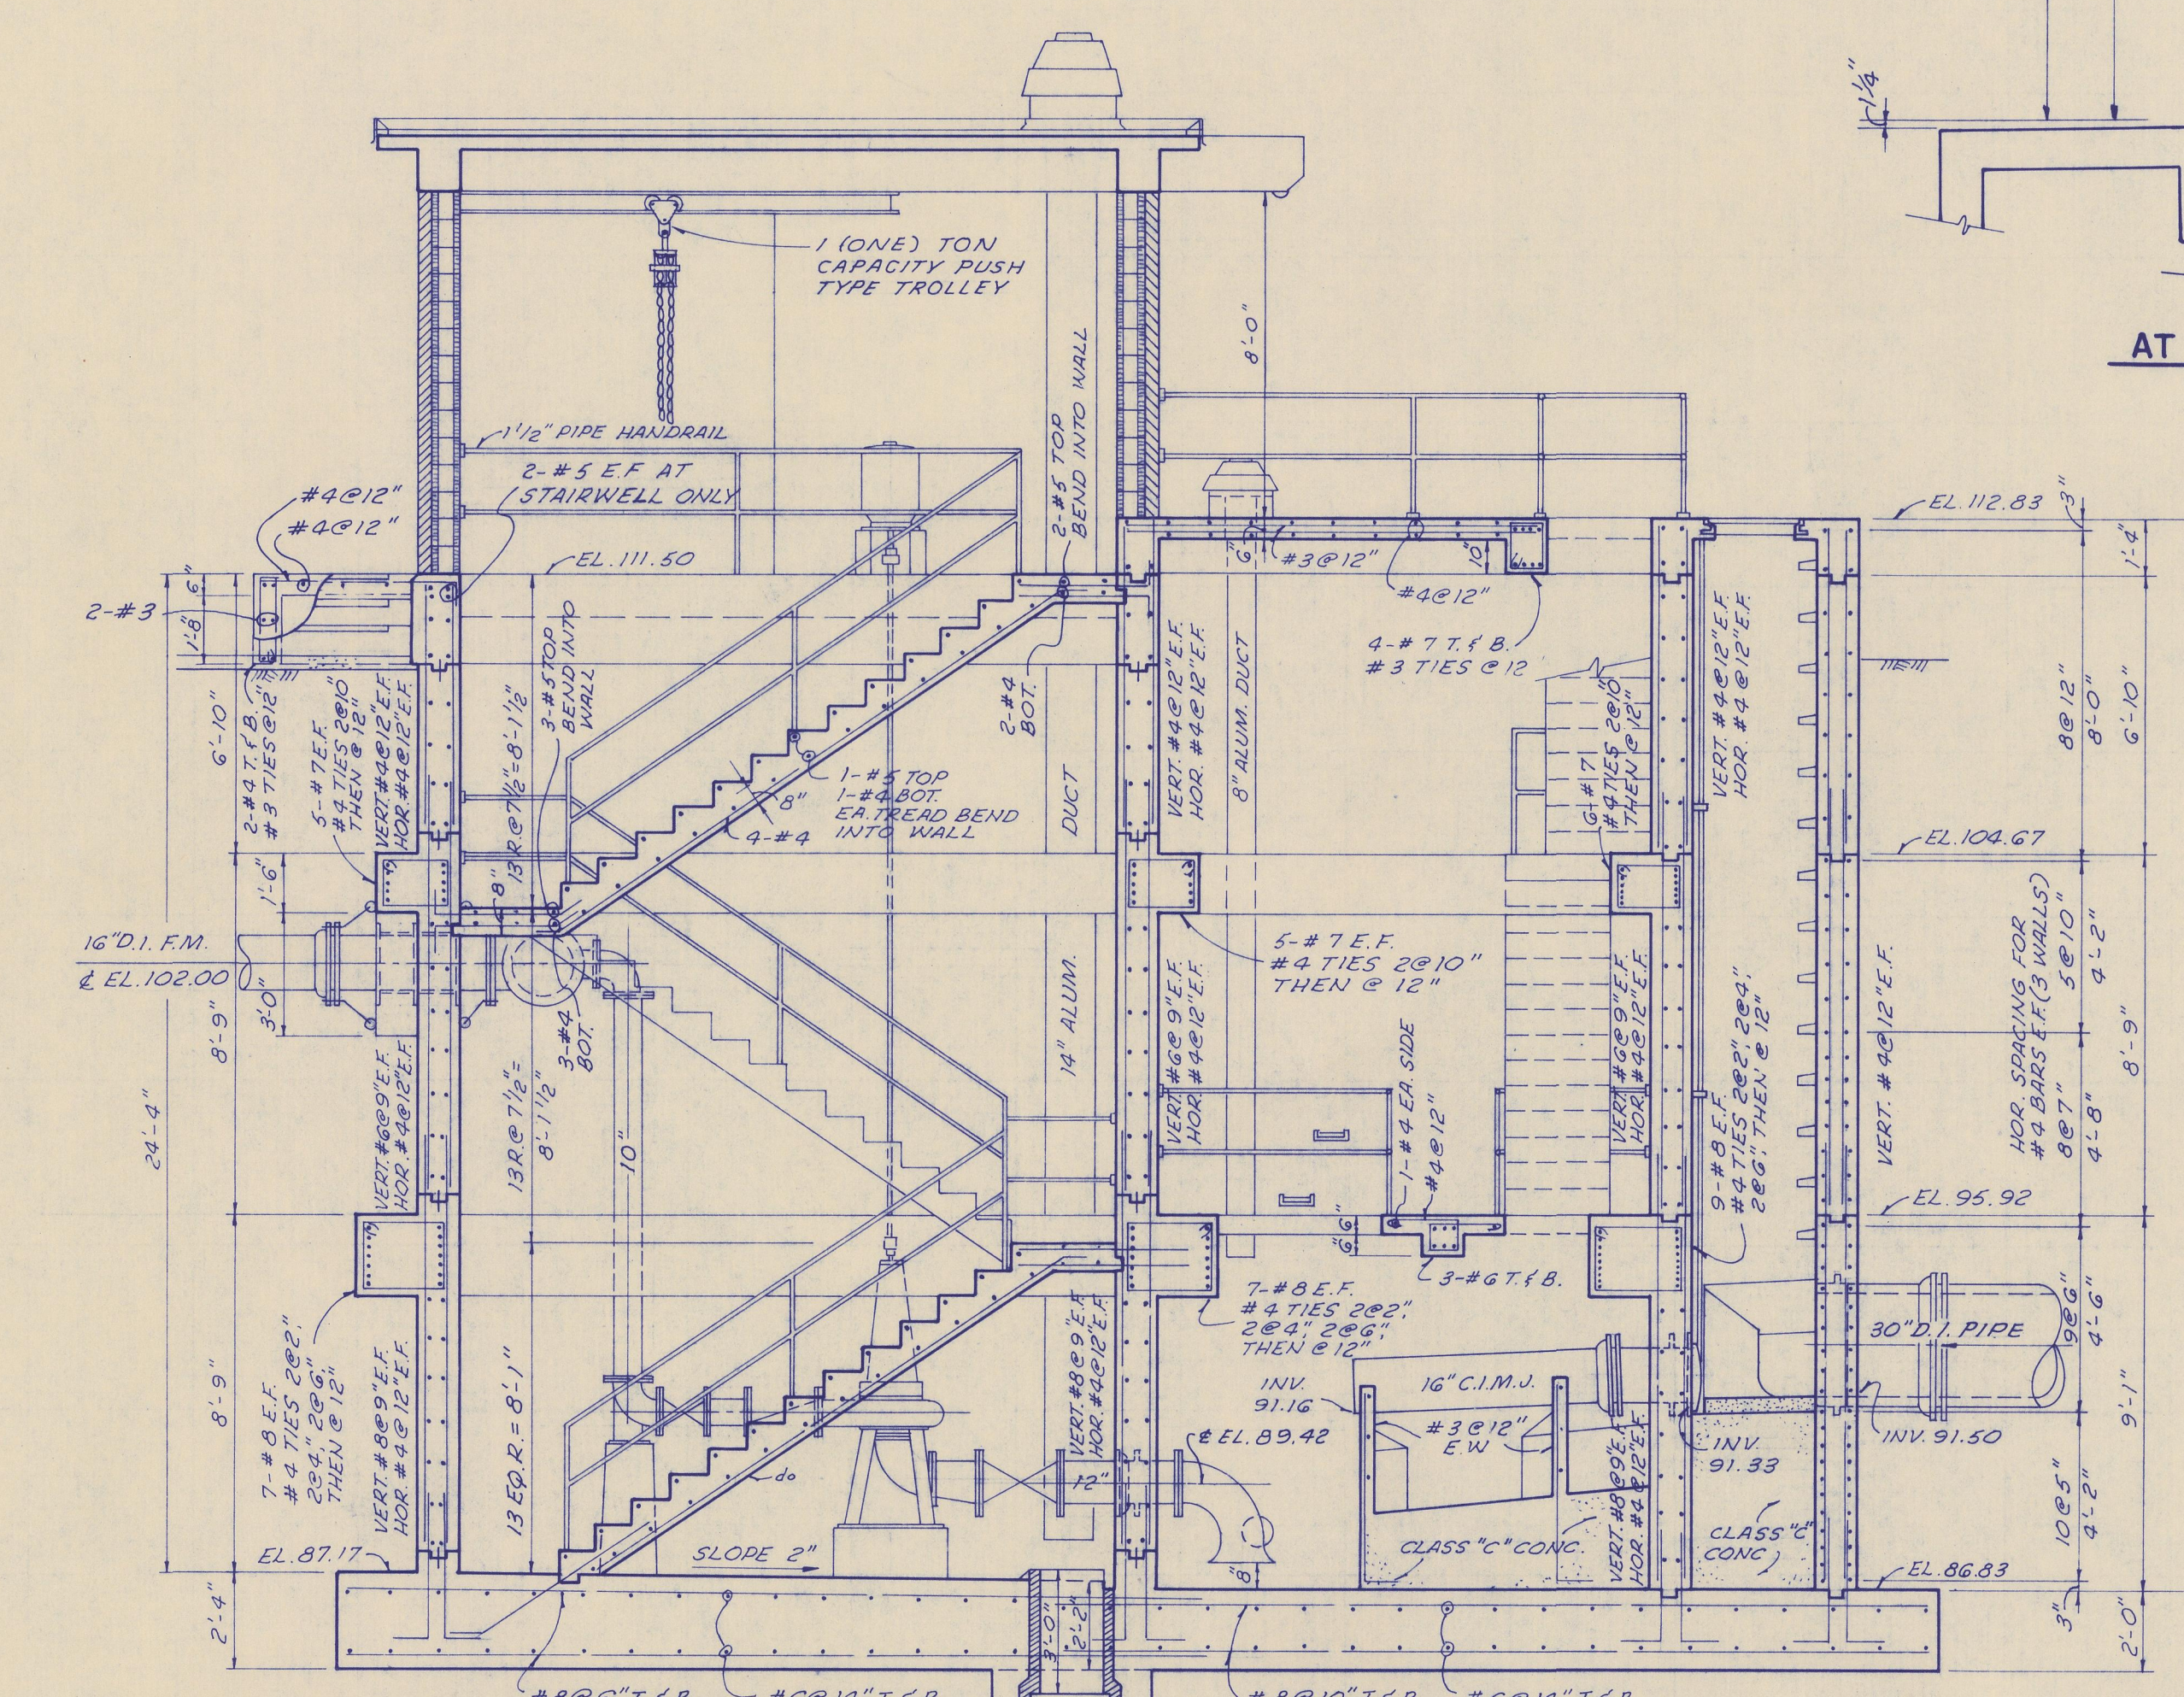

SECTION C-C
1/4" = 1'-0"

LINTEL SCHEDULE		
OPENING	NO.	SIZE OF ANGLE
0" TO 3'-0"	3	3 1/2" X 3 1/2" X 5/16"
3'-0" TO 6'-0"	3	4" X 3 1/2" X 5/16"
6'-0" TO 8'-0"	3	5" X 3 1/2" X 5/16"

DATUM EQUALS USC&GS MEAN
SEA LEVEL PLUS 100.00 FT.

CONTRACT - A-1976
EPA PROJECT NO. C130381
DIVISION TWO

CITY OF BRUNSWICK, GEORGIA
SEWERAGE SYSTEM IMPROVEMENTS

YELLOW BLUFF CREEK
PUMPING STATION
ELEVATIONS, SECTIONS AND DETAILS

SCALE AS SHOWN
DATE JAN. 1976
WIEDEMAN AND SINGLETON
ENGINEERS
ATLANTA
GEORGIA
SHEET 5
OF 8

